


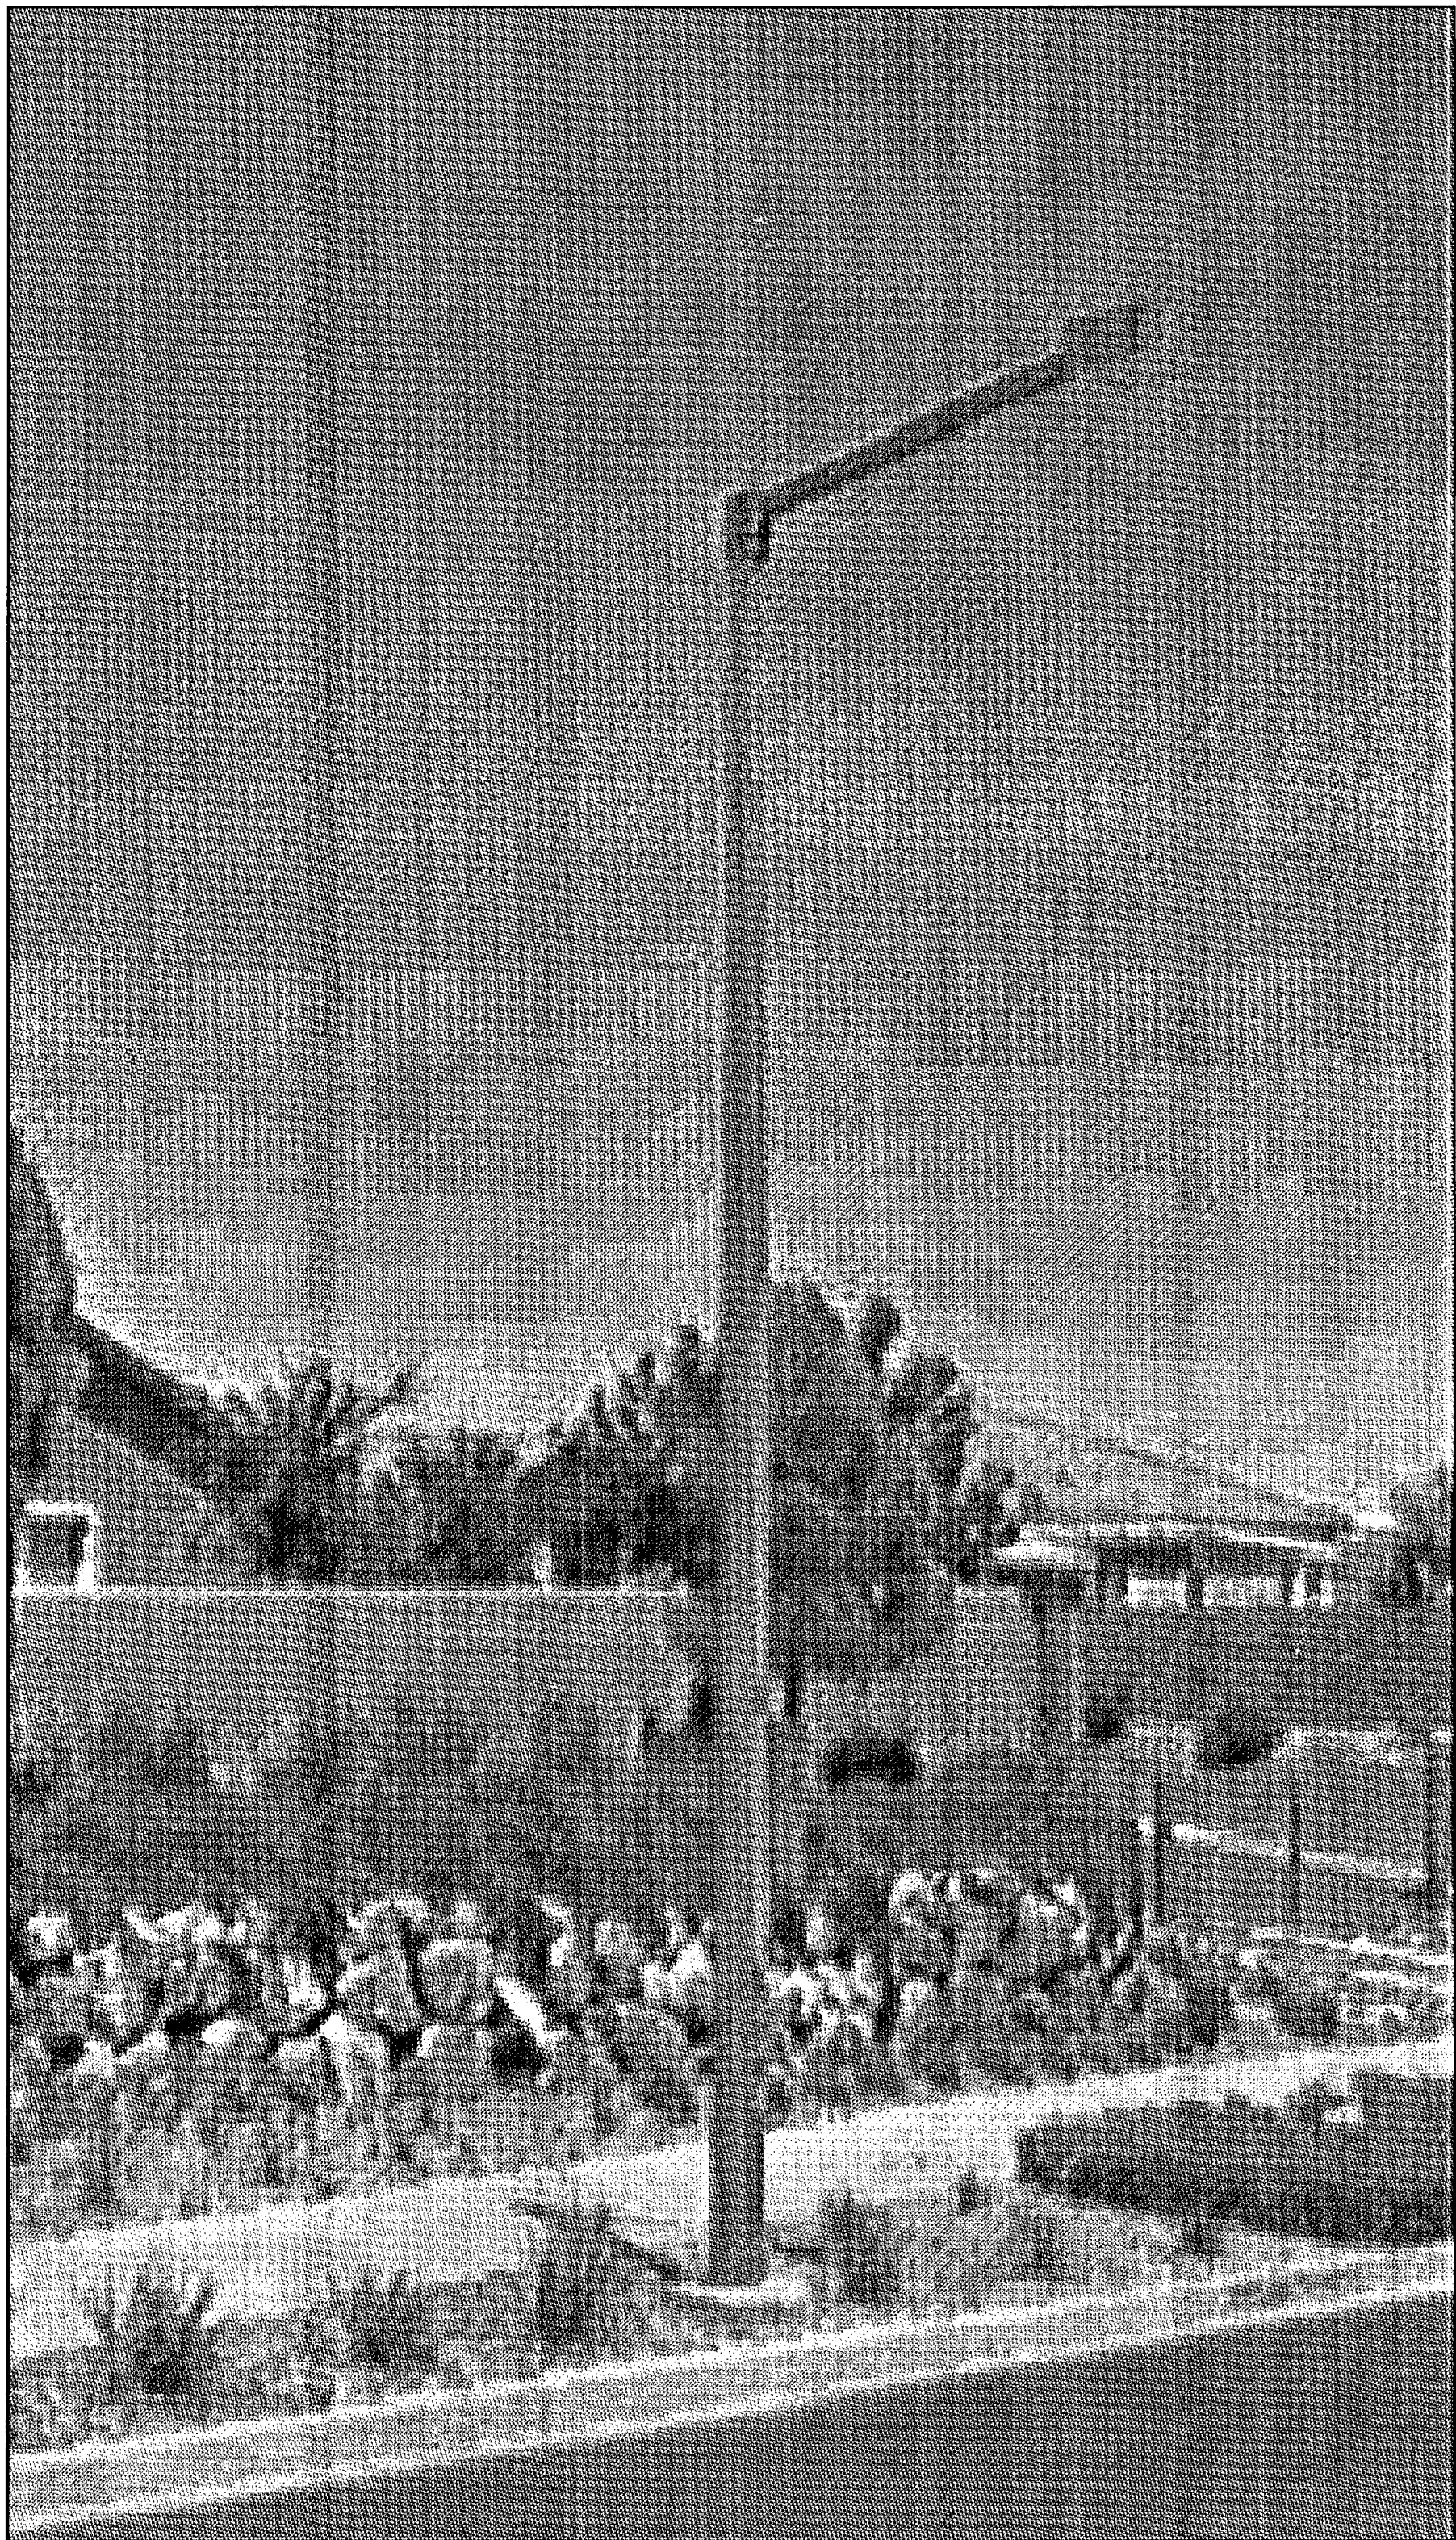

SITE PHOTO
INTERSECTION OF VISTA RUN DR. AND SKY LN.

NOTICE TO CONTRACTOR:


1. CONSTRUCTION CONTRACTOR AGREES THAT IN ACCORDANCE WITH GENERALLY ACCEPTED CONSTRUCTION PRACTICES, CONSTRUCTION CONTRACTOR SHALL BE REQUIRED TO ASSUME SOLE AND COMPLETE RESPONSIBILITY FOR JOB SITE CONDITIONS DURING THE COURSE OF CONSTRUCTION OF THE PROJECT, INCLUDING SAFETY OF ALL PERSONS AND PROPERTY, THAT THIS REQUIREMENT SHALL BE MADE TO APPLY CONTINUOUSLY AND NOT BE LIMITED TO NORMAL WORKING HOURS, AND CONSTRUCTION CONTRACTOR FURTHER AGREES TO DEFEND, INDEMNIFY AND HOLD DESIGN PROFESSIONALS HARMLESS FROM ALL LIABILITY, REAL OR ALLEGED IN CONNECTION WITH THE PERFORMANCE OF WORK ON THIS PROJECT, EXCEPTING LIABILITY ARISING FROM THE SOLE NEGLIGENCE OF DESIGN PROFESSIONAL.
2. CONTRACTOR SHALL VERIFY ALL CONDITIONS AND DIMENSIONS AND SHALL REPORT ALL DISCREPANCIES TO THE ENGINEER PRIOR TO THE COMMENCEMENT OF WORK.
3. THE EXISTENCE AND APPROXIMATE LOCATION OF ANY UNDERGROUND FACILITIES SHOWN HEREON WERE OBTAINED FROM A SEARCH OF AVAILABLE RECORDS. THERE MAY, HOWEVER BE EXISTING UTILITIES NOT SHOWN ON THE PLANS. THE CONTRACTOR SHALL TAKE NECESSARY PRECAUTIONS TO PROTECT THE UTILITIES OR STRUCTURES SHOWN HEREON AND ANY OTHER NOT OF RECORD OR NOT SHOWN ON THESE PLANS.
4. 14 GAUGE SOLID COPPER WIRE FOR LINE LOCATION SHALL BE REQUIRED OVER ALL SERVICE LATERALS NOT INSTALLED PERPENDICULAR TO THE MAIN IN ACCORDANCE WITH UDACS PLATE No. 27.
5. SEE PLAN AND PROFILE AND MASTER UTILITY SHEETS FOR COMPLETE WATER AND SEWER DESIGN.
6. CONTRACTOR SHALL BE RESPONSIBLE FOR DUST AND EROSION CONTROL DURING CONSTRUCTION.
7. SEE LANDSCAPE PLANS FOR LANDSCAPING. (SEE ARCH PACKAGE- COMPLETED BY OTHERS)

REVISIONS		REV.	DESCRIPTION	APPROD BY	DATE

SPECTRUM
SPECTRUM SERVICES, INC.
8805 W. POST ROAD, SUITE 100
LAS VEGAS, NEVADA 89148
OFFICE: (702) 367-7705
FAX: (702) 367-8733

CROWN CASTLE
NG WEST, INC.
685 RIVER OAKS PARKWAY
SAN JOSE, CALIFORNIA 95134

IMPROVEMENT PLANS
FOR SUMMERLIN
GENERAL NOTES
VFH01 FIBER OPTIC CABLE
IMPROVEMENTS IN SUMMERLIN
INTERSECTION OF VISTA RUN DR.
AND SKY LN.

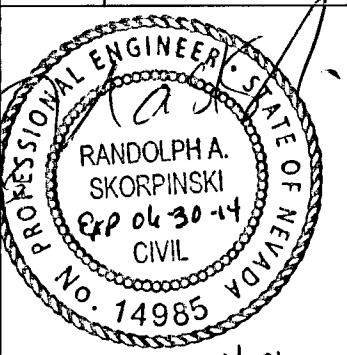

ENGINEER'S SEAL

IT'S COSTLY
CALL BEFORE
YOU DIG
UNDERGROUND
1-702-455-7511
CLARK COUNTY TRAFFIC
OPERATIONS AND
1-702-229-6811
LAS VEGAS AREA
TRAFFIC SYSTEM

Avoid overhead power line
contact. It's costly.
**Call
before you
OVERHEAD**
1-702-227-2829

Call before you Dig
Avoid cutting underground
utility lines. It's costly.
**Call
811**
1-800-227-2800
1-702-455-7544

CONTRACTED WITH:	PERMIT #	DATE: 12/10/13	JOB NO: C013030	DRAWN BY: NEL	CHECKED BY: RAS	SCALE: NONE
C2						