
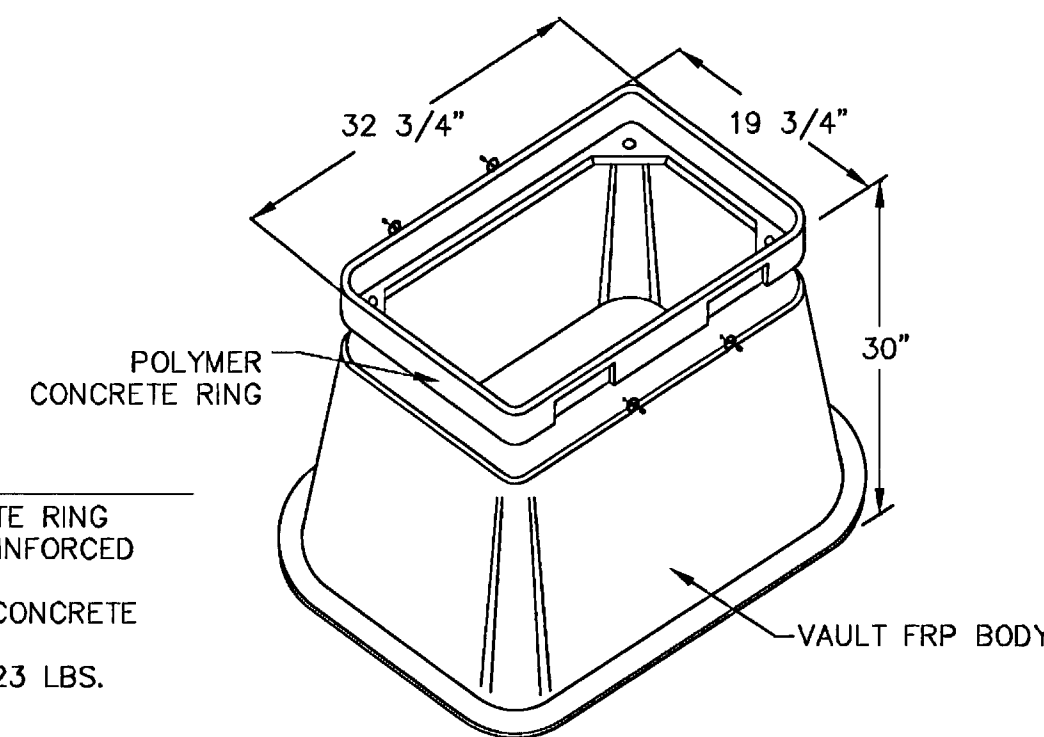


COVER FEATURES:

- * PW - 10,400 LBS. WHEEL LOAD ON 10" X 10" PLATE.
- * APPROX. WT. = 72 LBS.
- * POLYMER CONCRETE
- * ONE PIECE COVER
- * FOUR BOLT DOWN
- * COLOR: CONCRETE GREY
- * NON - SKID SURFACE

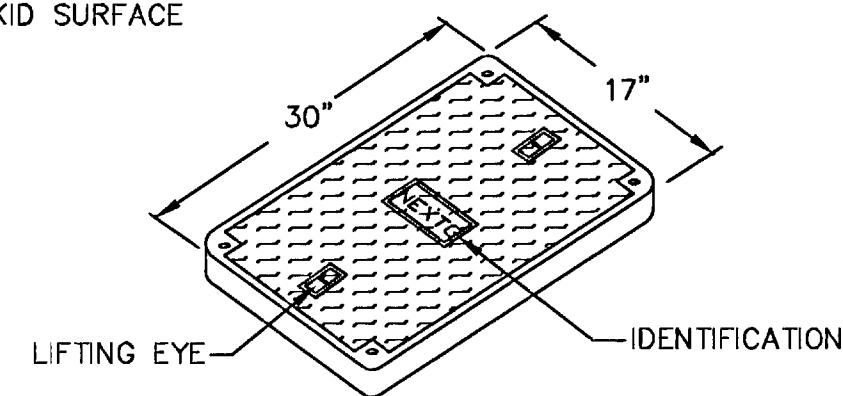


VAULT FEATURES:

- * POLYMER CONCRETE RING AND FIBERGLASS REINFORCED POLYMER BODY
- * COLOR OF RING: CONCRETE GREY
- * APPROX. WT. = 123 LBS.

17' X 30' CONNECTOR MANHOLE
NTS

5

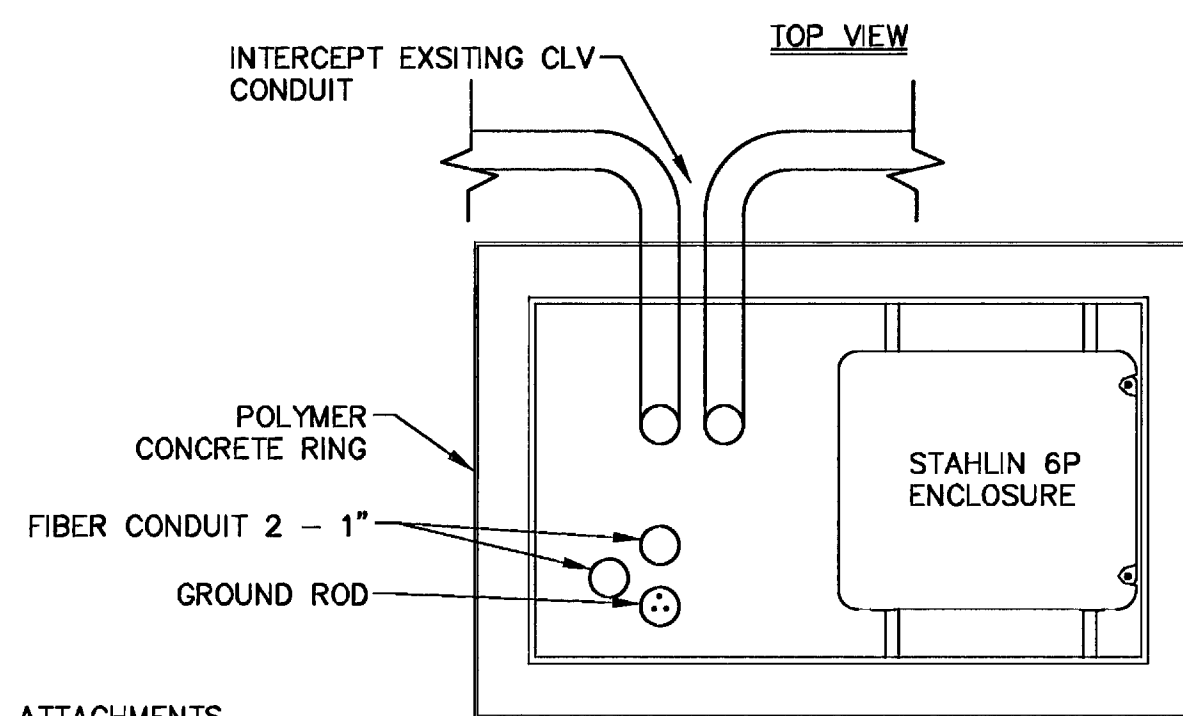


NOTE:
ALL MOUNTING ATTACHMENTS
FOR THIS BOX SHALL BE THROUGH EXTERNAL
MOUNTING FLANGES INTEGRAL WITH BOX.


SIDE VIEW

FRONT VIEW


STAHLIN 6P ENCLOSURE

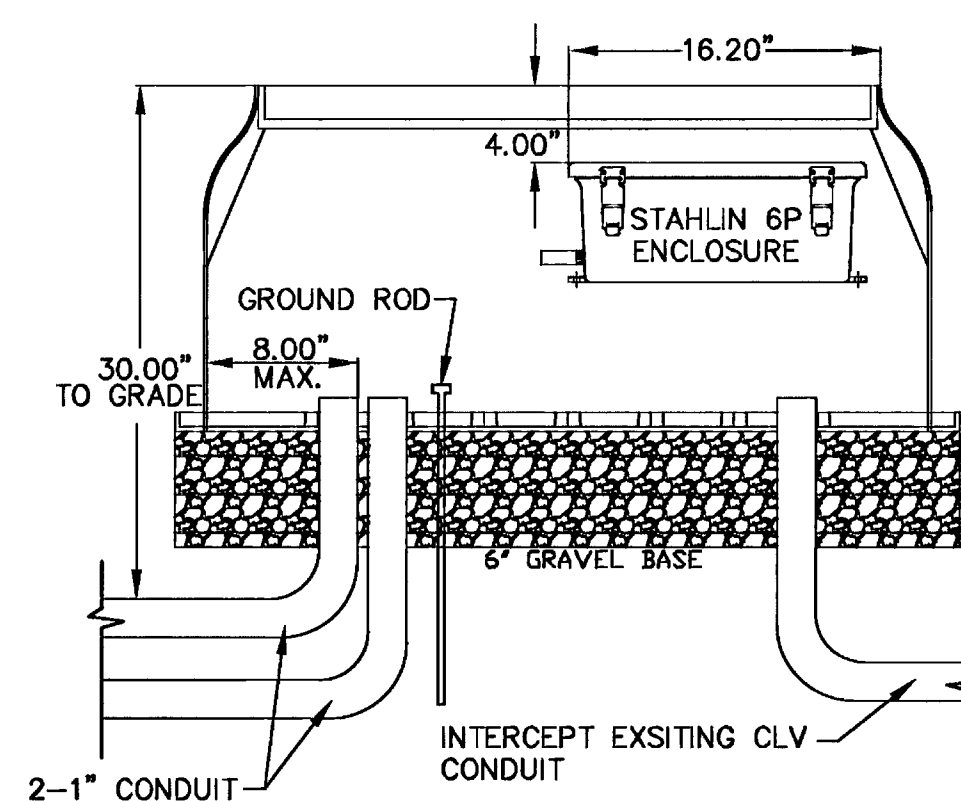STAHLIN 6P ENCLOSURE
NTS


3

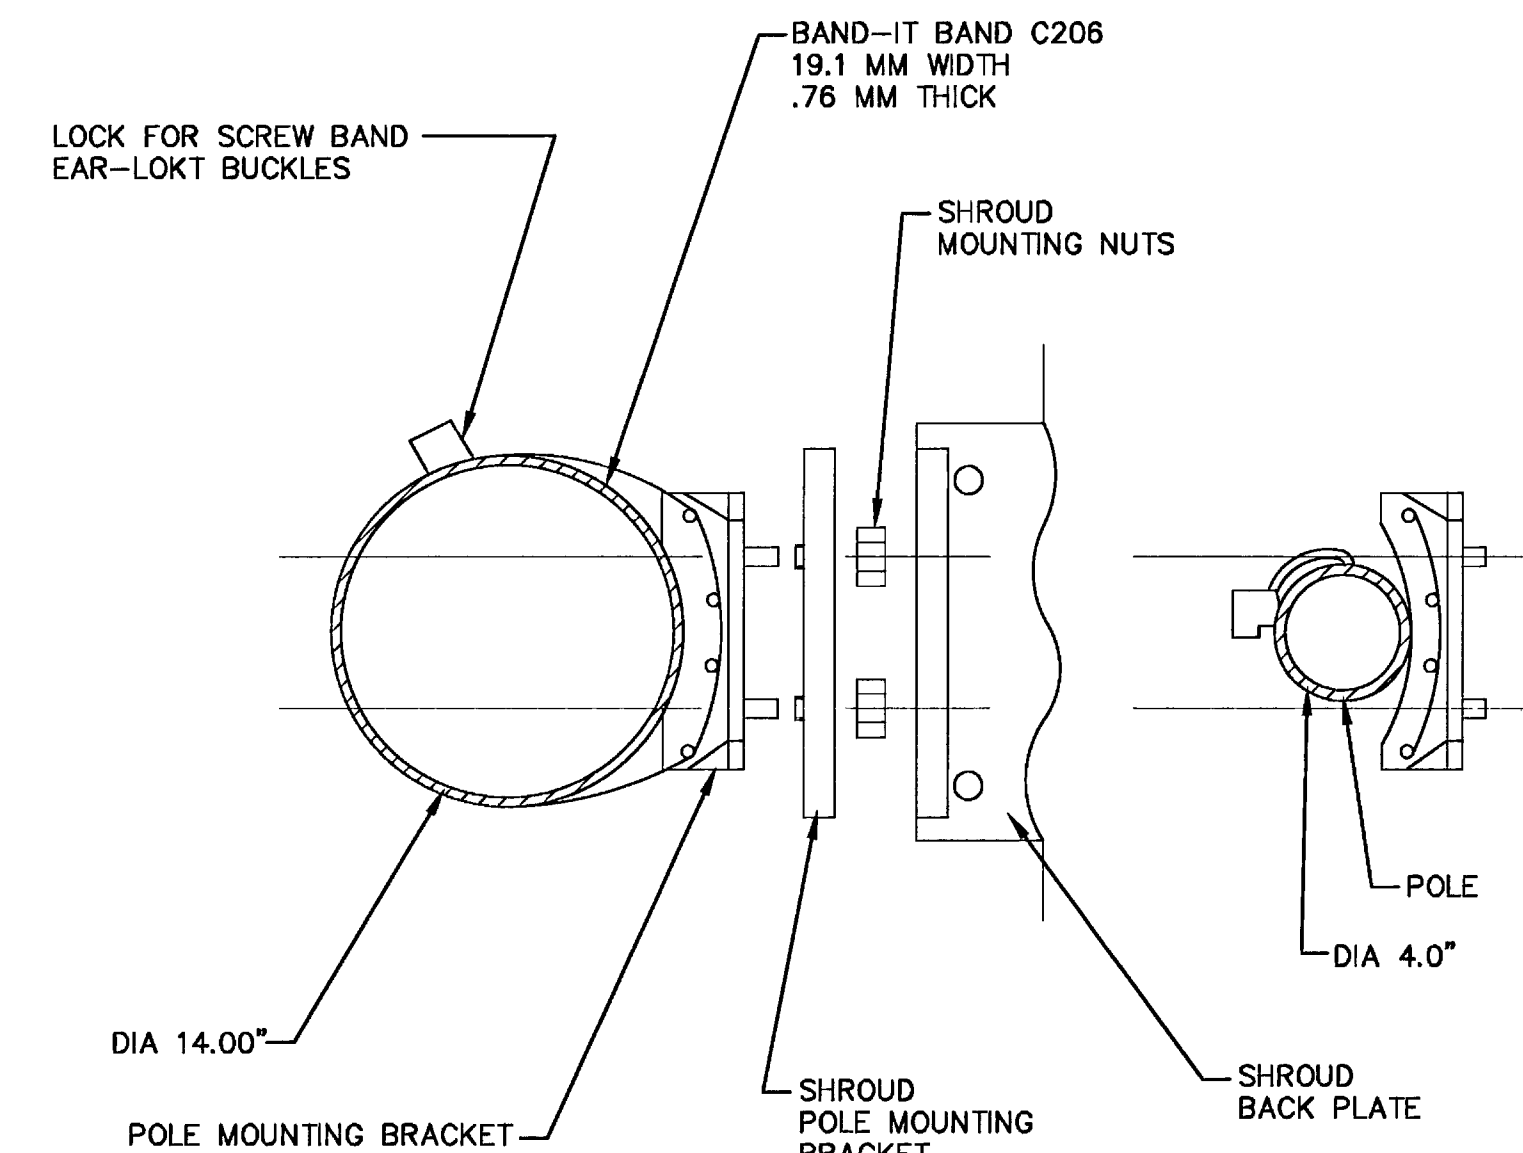POLE MOUNTING
NTS

2

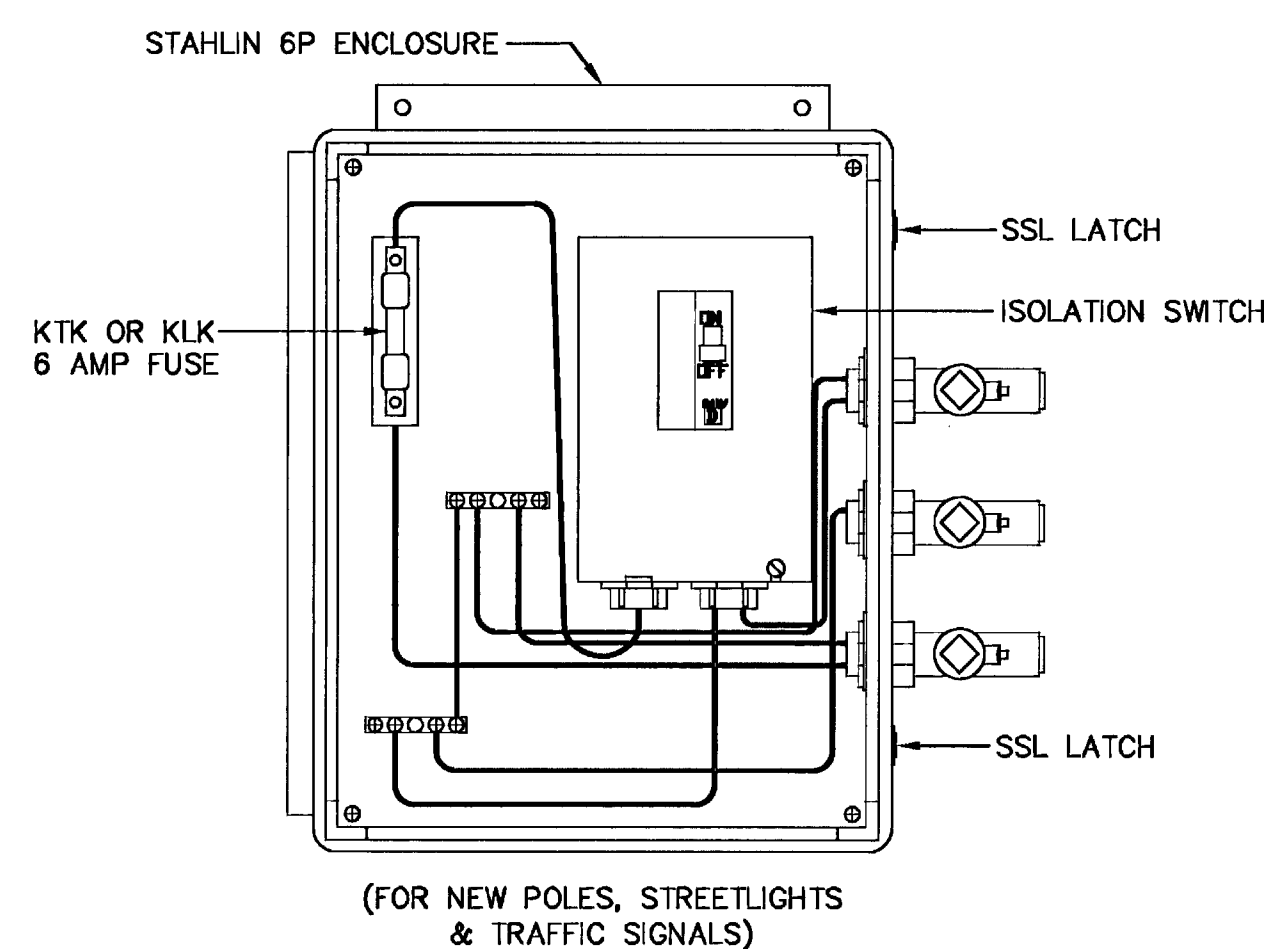(FOR NEW POLES, STREETLIGHTS
& TRAFFIC SIGNALS)WTR FUSE BOX
NTS

4

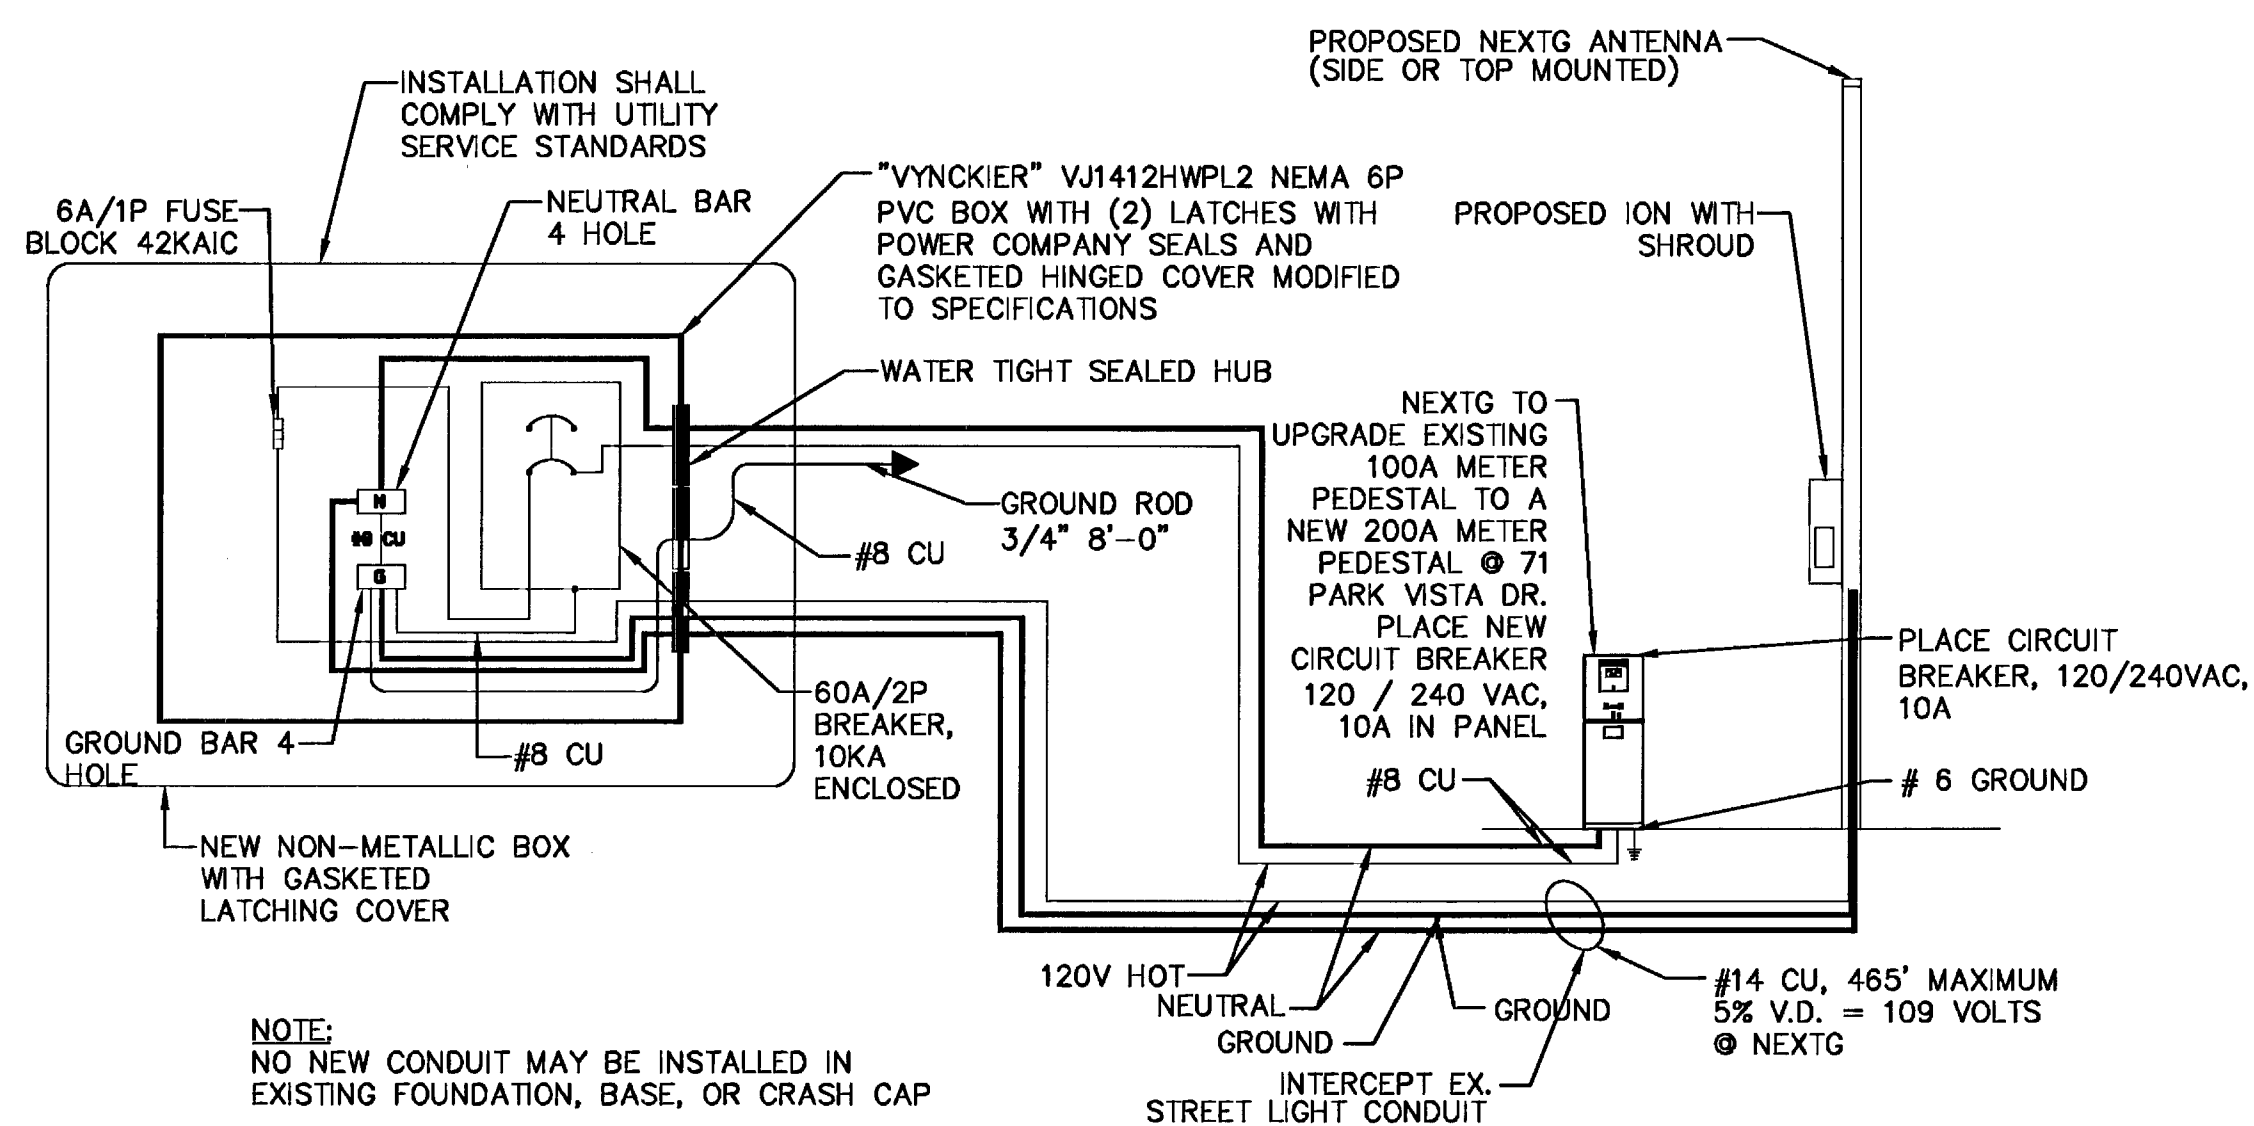

NOTE:
NO NEW CONDUIT MAY BE INSTALLED IN
EXISTING FOUNDATION, BASE, OR CRASH CAP

POWER SINGLE LINE DIAGRAM
NTS

1

REVISIONS

REV.	DESCRIPTION	APPROV BY	DATE

SPECTRUM


SPECTRUM SERVICES, INC.
8905 W. POST ROAD, SUITE 100
LAS VEGAS, NEVADA 89148
OFFICE: (702) 367-7705
FAX: (702) 367-8733

CROWN CASTLE
NG WEST, INC.

685 RIVER OAKS PARKWAY
SAN JOSE, CALIFORNIA 95134

IMPROVEMENT PLANS
FOR SUMMERLIN

DETAIL SHEET
VFH01 FIBER OPTIC CABLE
IMPROVEMENTS IN SUMMERLIN
INTERSECTION OF VISTA RUN DR.
AND SKY LN.

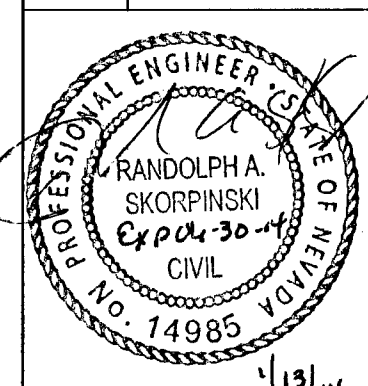

ENGINEER'S SEAL

CONTRACTED WITH:
HP COMMUNICATIONS

PERMIT #

DATE: 12/10/13

JOB NO: CD13030

DRAWN BY: NEL

CHECKED BY: RAS

SCALE: NONE

SHEET 5
OF 7