



- COVER FEATURES:
- * PW - 10,400 LBS. WHEEL LOAD ON 10" X 10" PLATE.
 - * APPROX. WT. = 72 LBS.
 - * POLYMER CONCRETE
 - * ONE PIECE COVER
 - * FOUR BOLT DOWN
 - * COLOR: CONCRETE GREY
 - * NON - SKID SURFACE

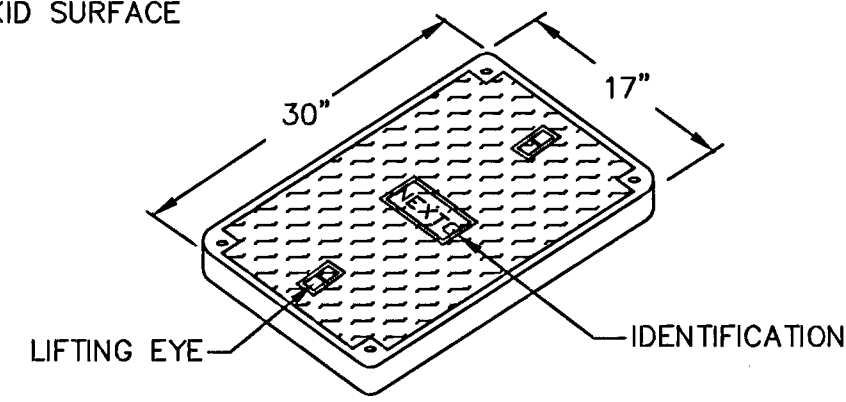


- VAULT FEATURES:
- * POLYMER CONCRETE RING AND FIBERGLASS REINFORCED POLYMER BODY
 - * COLOR OF RING: CONCRETE GREY
 - * APPROX. WT. = 123 LBS.

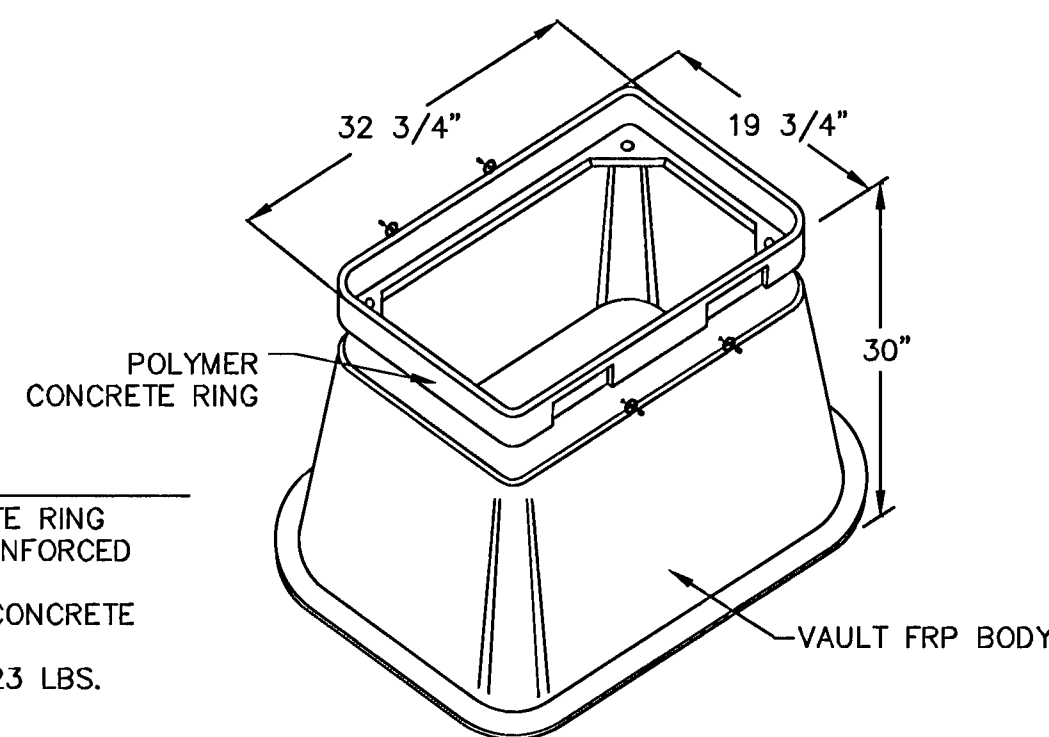


17" X 30" CONNECTOR MANHOLE
NTS

5

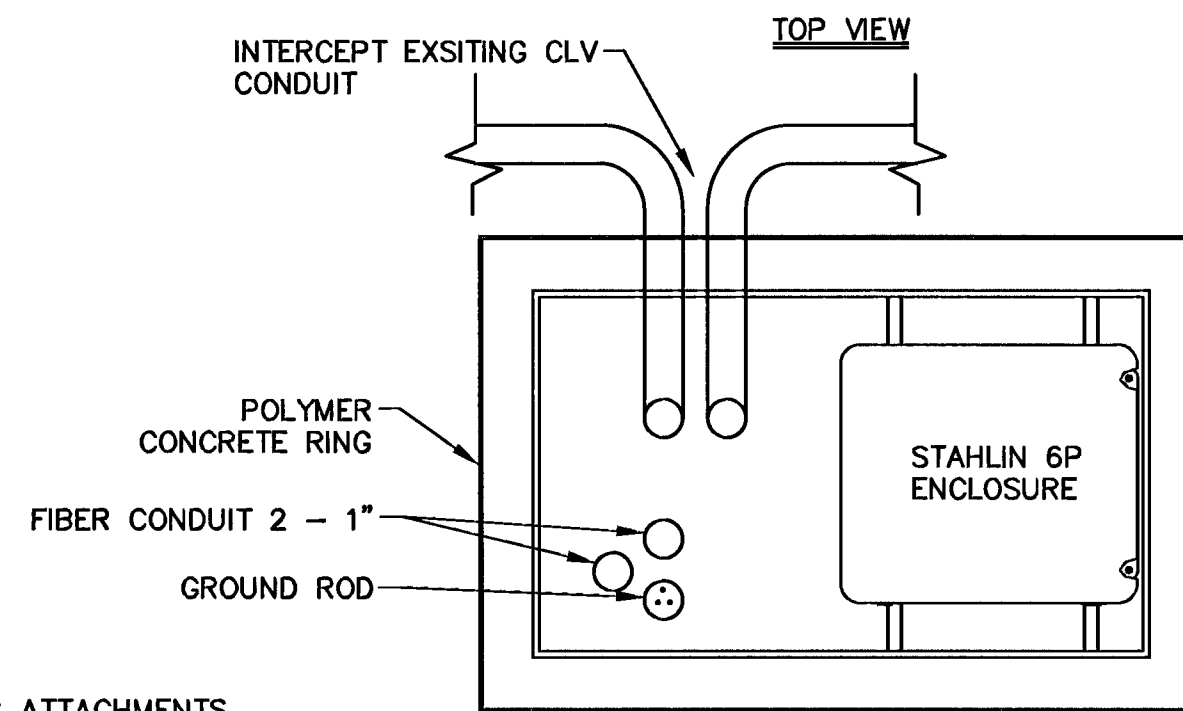


NOTE:
ALL MOUNTING ATTACHMENTS
FOR THIS BOX SHALL BE THROUGH EXTERNAL
MOUNTING FLANGES INTEGRAL WITH BOX.

SIDE VIEW

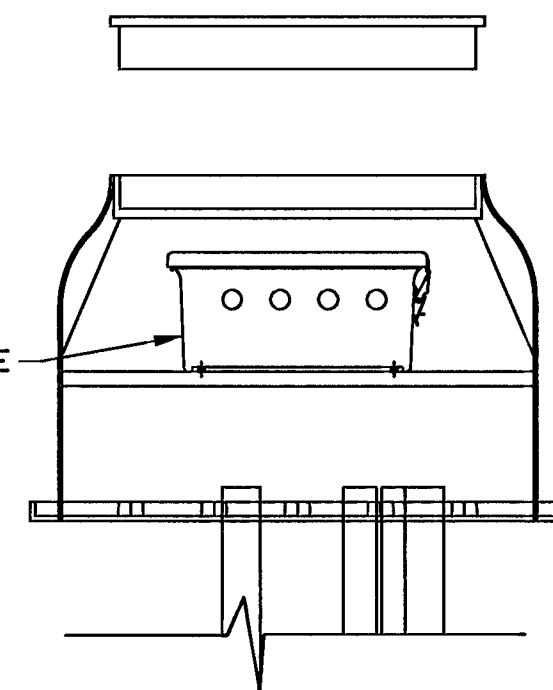


FRONT VIEW

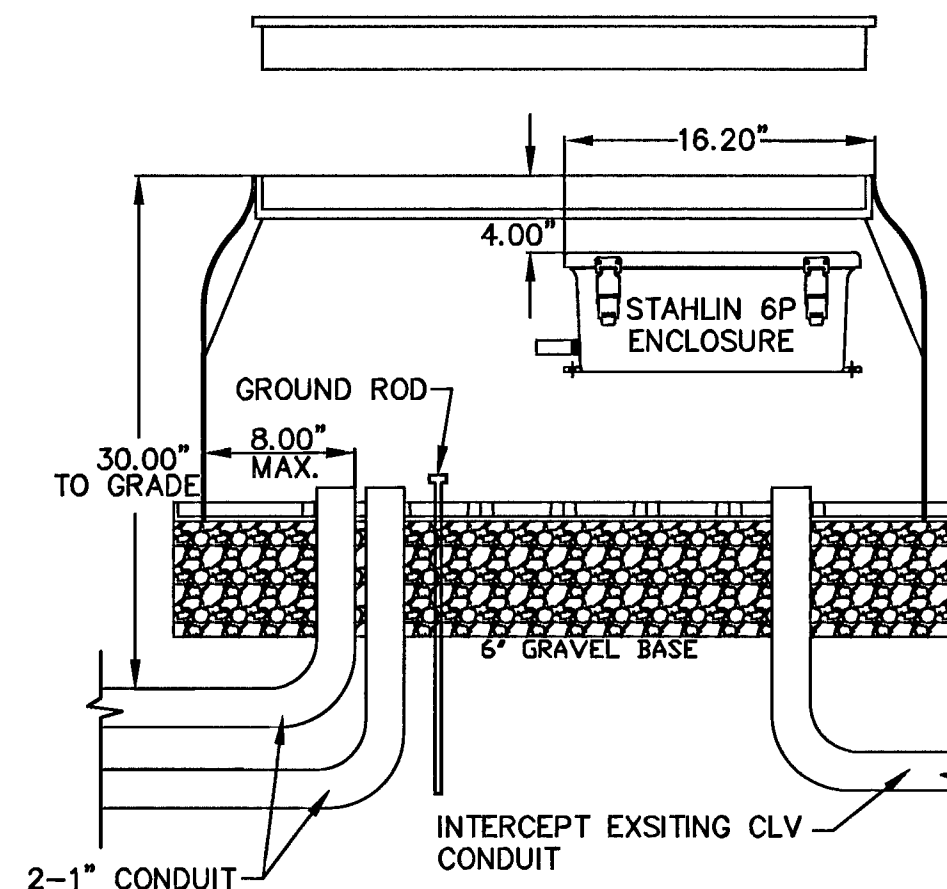


STAHLIN 6P ENCLOSURE
NTS

3

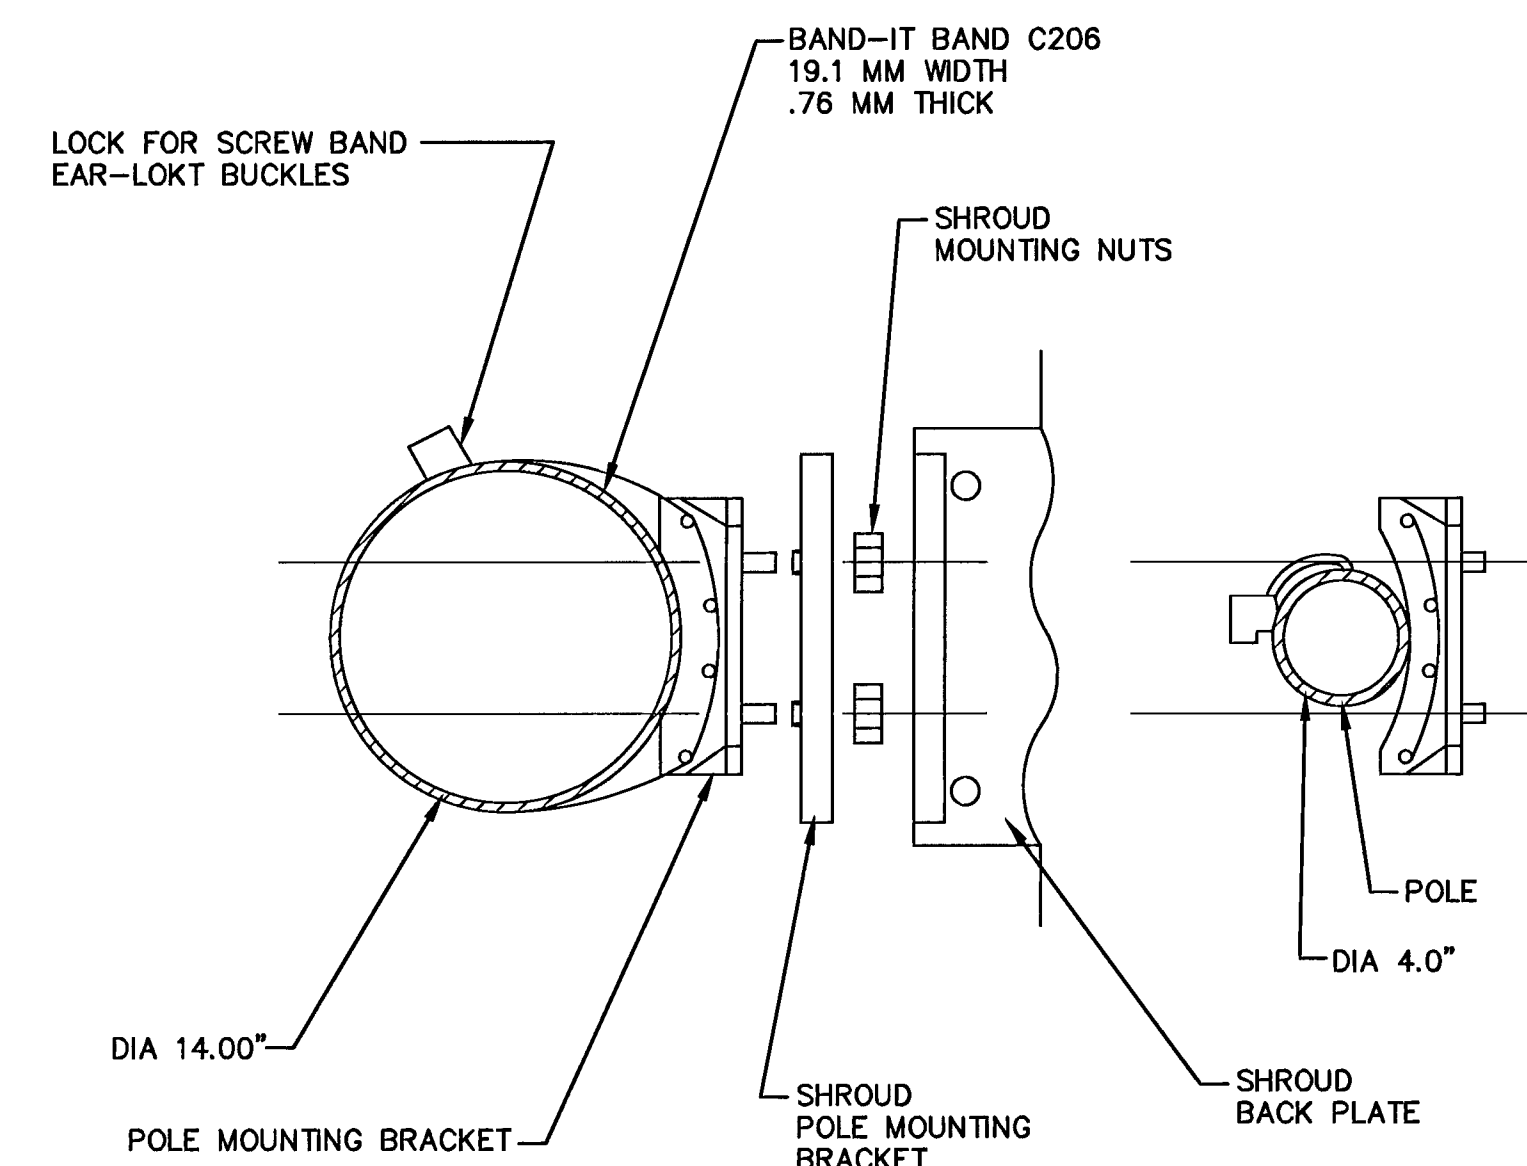


POLE MOUNTING
NTS

2

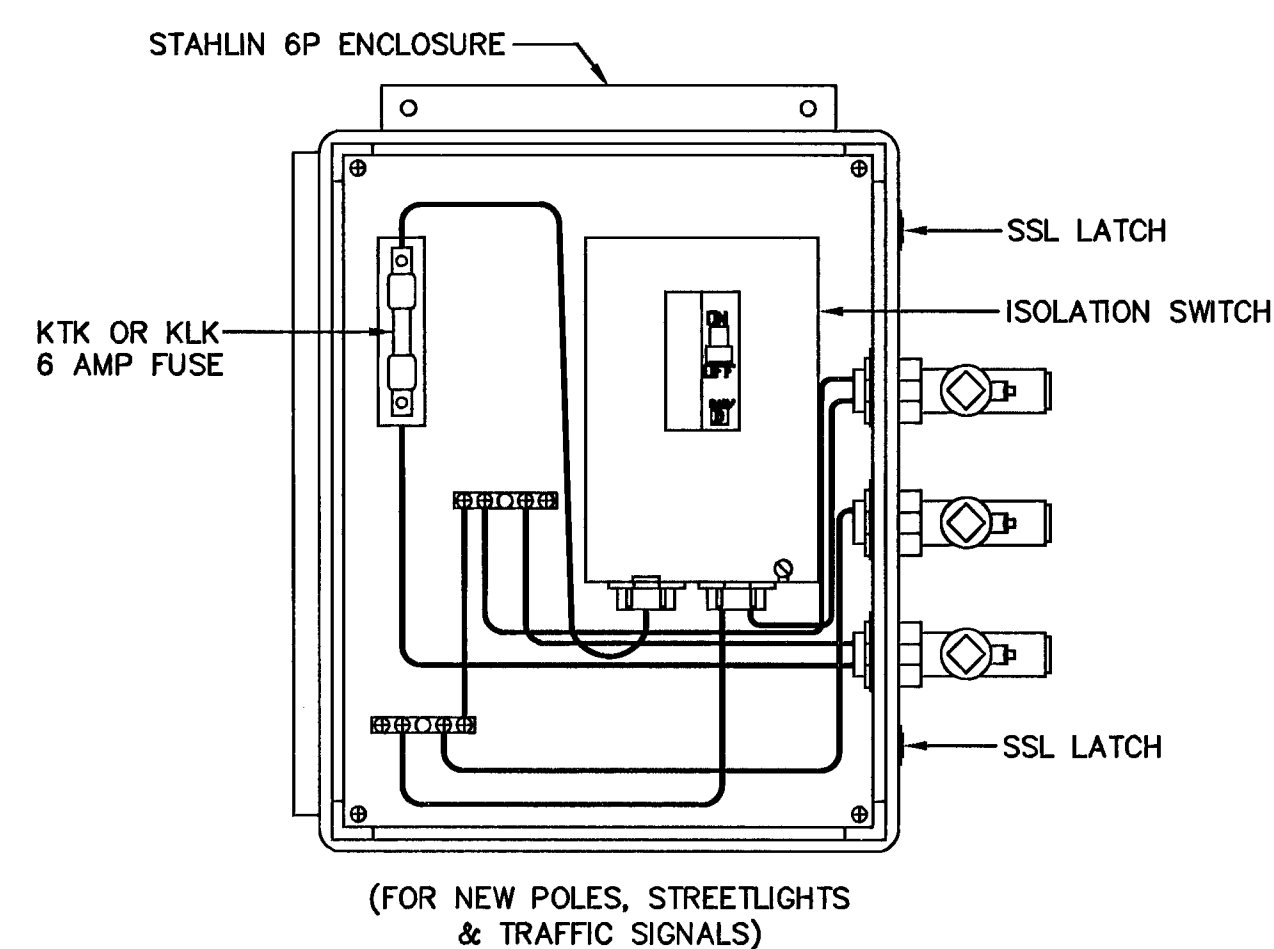

WTR FUSE BOX
NTS

4

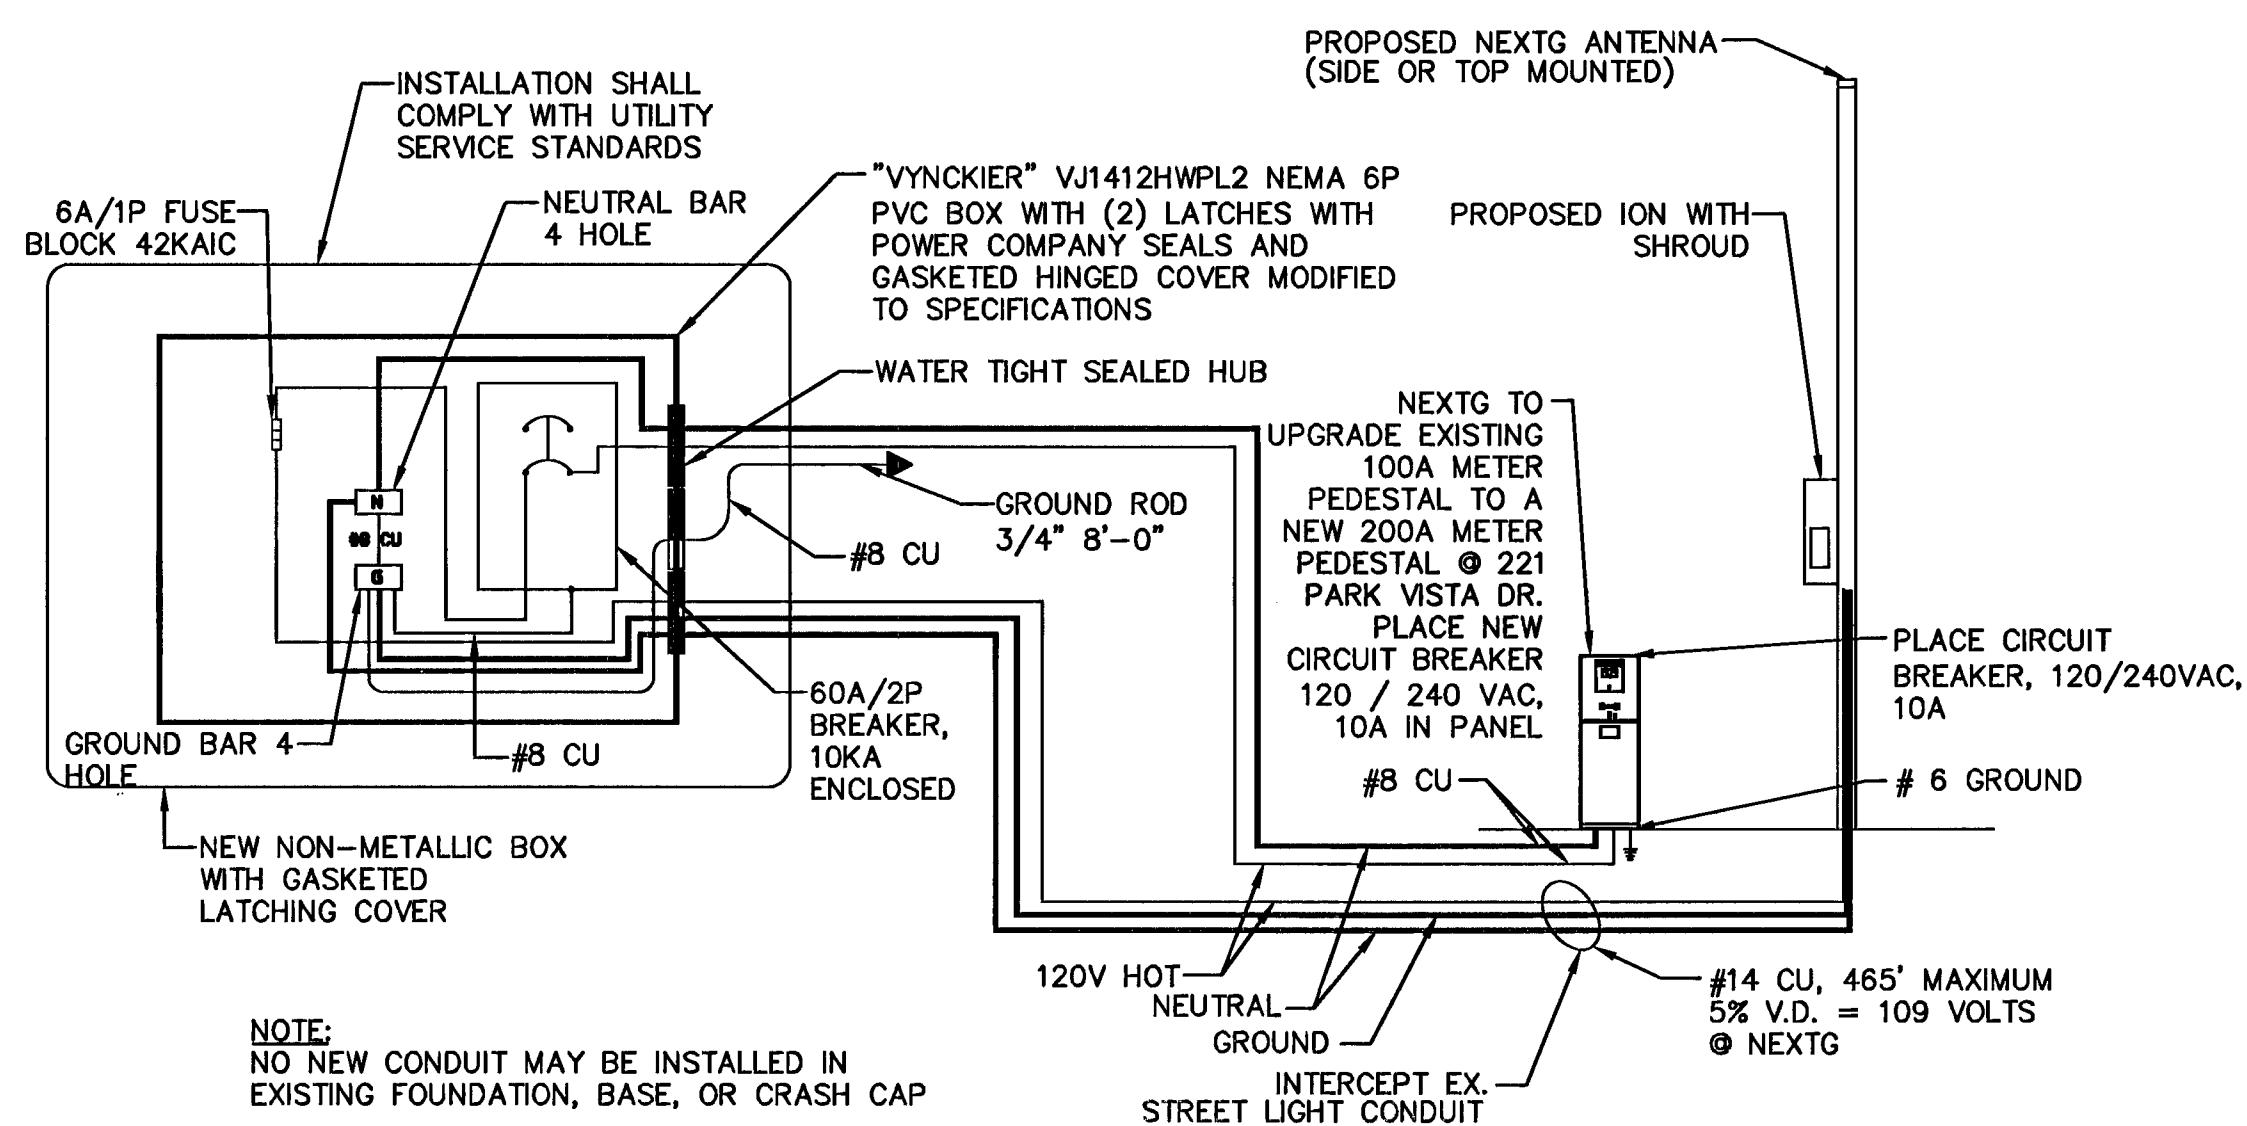

NOTE:
NO NEW CONDUIT MAY BE INSTALLED IN
EXISTING FOUNDATION, BASE, OR CRASH CAP

POWER SINGLE LINE DIAGRAM
NTS

1

REVISIONS

REV.

DESCRIPTION

APPROV BY

DATE

IMPROVEMENT PLANS
FOR SUMMERLIN

DETAIL SHEET

VFH02 FIBER OPTIC CABLE
IMPROVEMENTS IN SUMMERLIN

S. VISTA RUN DR.
(140 FT. S. OF W. MOUNTAIN SHADOW RD.)

ENGINEER'S SEAL

CONTRACTED WITH:
HP COMMUNICATIONS

PERMIT #

DATE: 11/08/13

JOB NO: C013030

DRAWN BY: NEL

CHECKED BY: RAS

SCALE: NONE

SHEET 5

OF 7

10/13

10/13

