


VAN BUREN AVENUE

PROFILE
SCALE: HORIZ. 1" = 40'
VERT. 1" = 4'

NOTE:
CONTRACTOR TO KEEP WATER MAIN IN SERVICE AND SUPPORT 6" WATER AND THRUST BLOCKS AT ALL TIMES

RECONNECT SERVICE LATERALS 2" AND SMALLER

ALL SERVICES LATERALS 2" AND SMALLER THAT ARE CUT OR DAMAGED MAY BE RECONNECTED, PROVIDED THE FOLLOWING CRITERIA ARE MET:
1. IF THE LATERAL IS COPPER, THE LATERAL MAY BE CUT AND SPLICED NOT MORE THAN ONCE IN A MANNER APPROVED BY THE DISTRICT.
2. IF THE LATERAL IS NOT COPPER, THE LATERAL MUST BE ABANDONED FROM THE EXISTING WATER MAIN, AND REPLACED WITH A COPPER SERVICE LATERAL PER UDACS PLATE NO. 18 OR 1D. IF THE CORPORATION STOP IS DAMAGED BEYOND REPAIR OR PULLED FROM THE EXISTING WATER MAIN, THE MAIN SHALL BE REPAIRED AT THE CONTRACTOR'S EXPENSE, IN A MANNER APPROVED BY THE LVWD. IF THE CORPORATION STOP IS NOT WATER TIGHT, THE CONTRACTOR SHALL NOTIFY LVWD COMMUNICATION SUPPORT CENTER (702-258-7171) FOR FURTHER DIRECTION. THE CONTRACTOR SHALL INSTALL A NEW SERVICE OF LIKE SIZE ADJACENT TO THE DAMAGED SERVICE IN ACCORDANCE WITH UDACS PLATE NO. 18 OR 1D. ESN 031

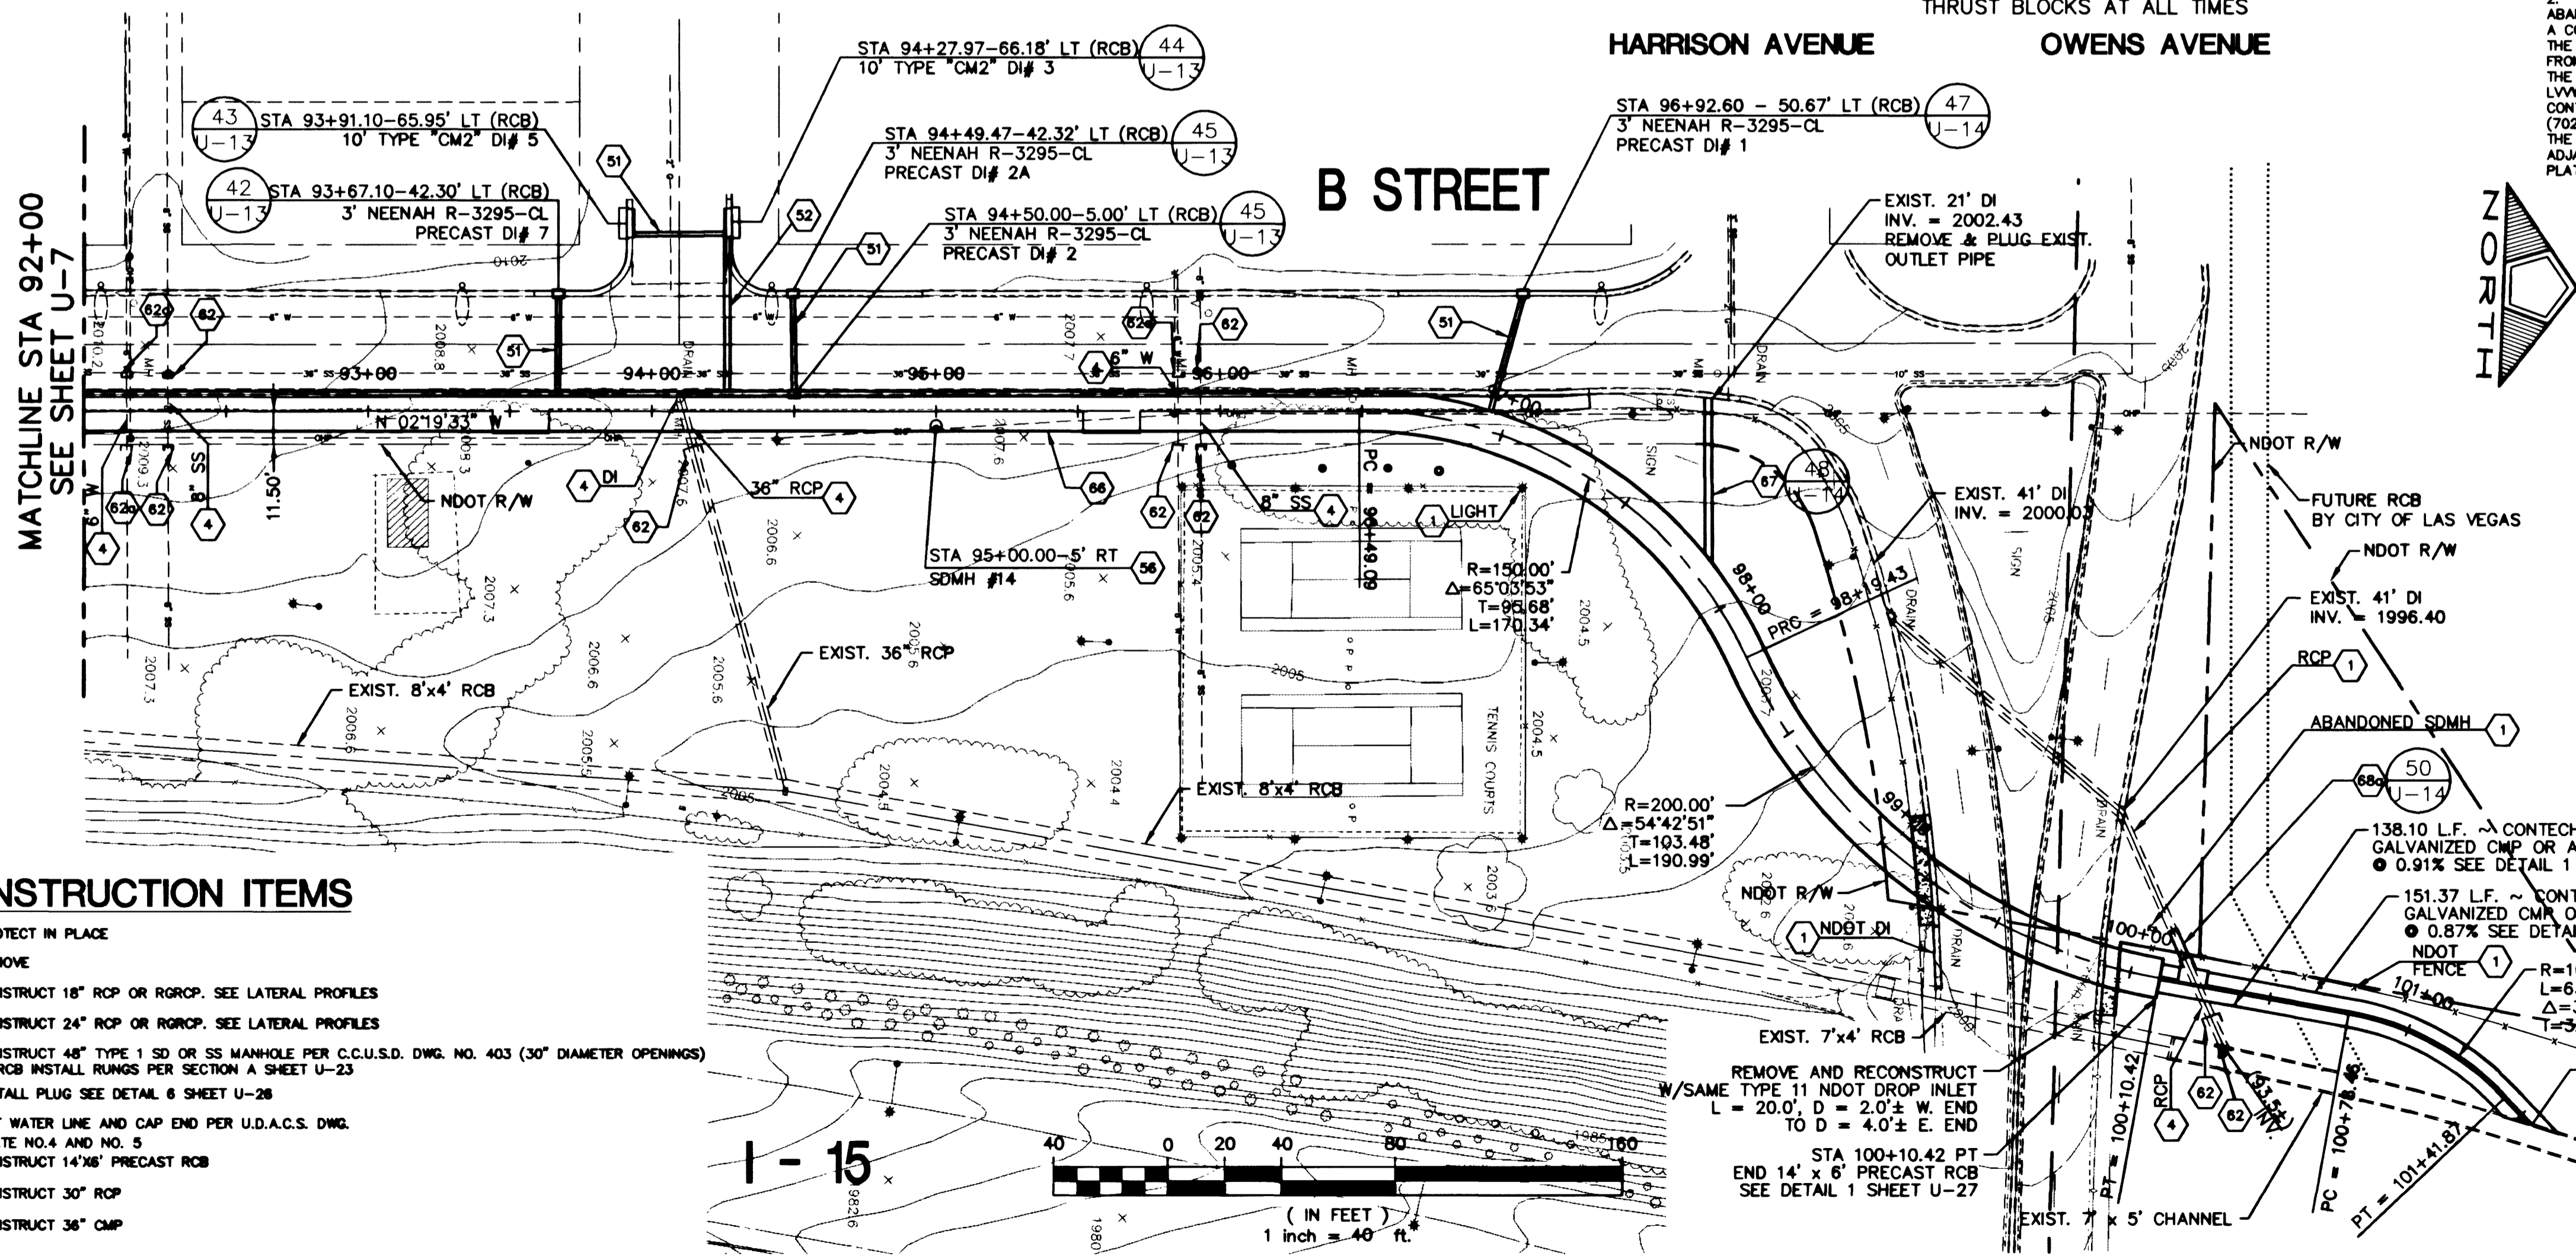

GENERAL NOTES


1. RCB JOINTS SHALL BE MORTAR GROUTED ON THE INSIDE FACE AND OUTSIDE FACE; ALL SIDES, UNLESS NOTED OTHERWISE, IN WHICH CASE, A CONCRETE COLLAR WILL BE UTILIZED.

NOTE:
ALL STATIONS ON THIS SHEET ARE BASED ON RCB CL ALIGNMENT

Arnie CDT
LAS VEGAS VALLEY WATER DISTRICT
8-17-00
DATE

CONSTRUCTION ITEMS

- 1 PROTECT IN PLACE
- 2 REMOVE
- 3 CONSTRUCT 18" RCP OR RGRCP. SEE LATERAL PROFILES
- 4 CONSTRUCT 24" RCP OR RGRCP. SEE LATERAL PROFILES
- 5 CONSTRUCT 48" TYPE 1 SD OR SS MANHOLE PER C.C.U.S.D. DWG. NO. 403 (30" DIAMETER OPENINGS) IN RCB INSTALL RUNGS PER SECTION A SHEET U-23
- 6 INSTALL PLUG SEE DETAIL 6 SHEET U-28
- 7 CUT WATER LINE AND CAP END PER U.D.A.C.S. DWG. PLATE NO. 4 AND NO. 5
- 8 CONSTRUCT 14"x6" PRECAST RCB
- 9 CONSTRUCT 30" RCP
- 10 CONSTRUCT 36" CMP

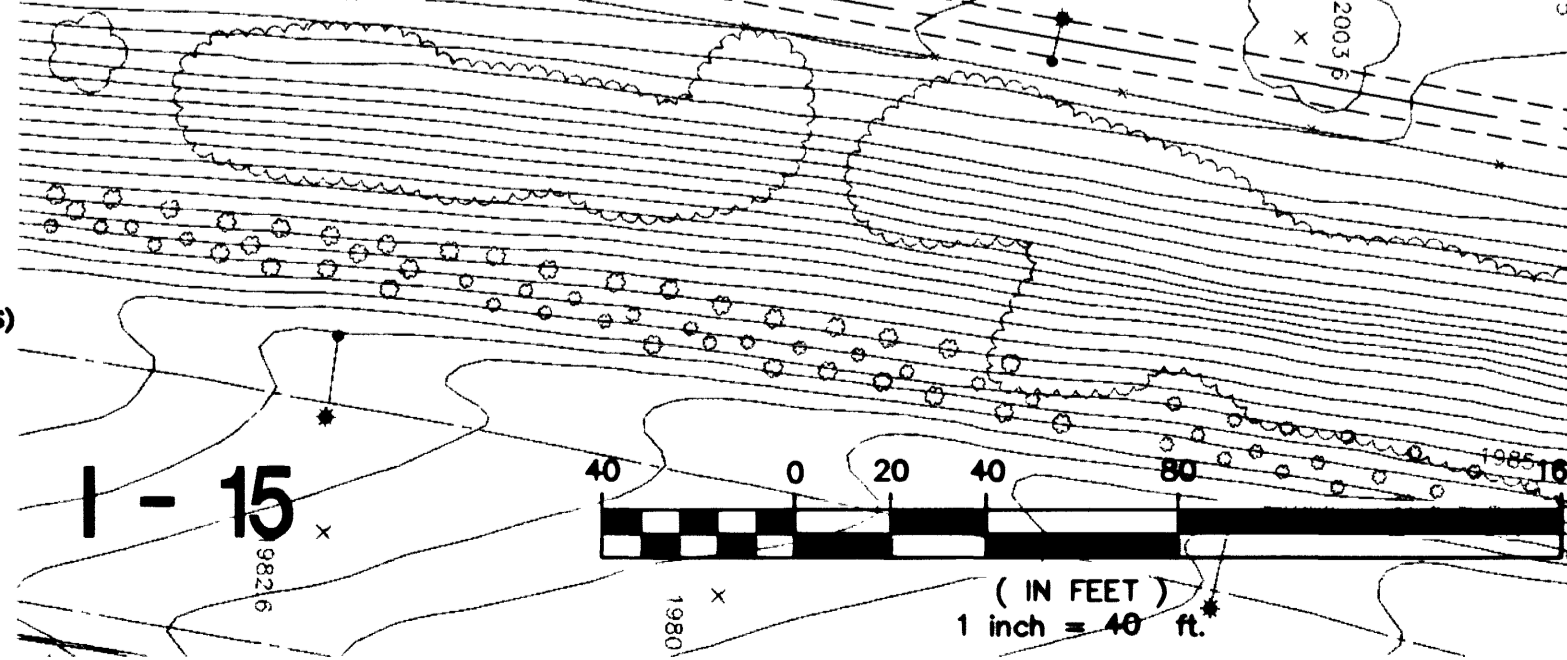

Avoid hitting overhead power lines. It's costly.

Call before you do Overhead

1-702-593-6111

Avoid cutting underground utility lines. It's costly.

Call before you Dig.

1-800-227-2600

UNDERGROUND SERVICE ALERT (USA)

<p>PENTACORE</p> <p>CIVIL ENGINEERING • LAND SURVEYING • PLANNING CONSTRUCTION MANAGEMENT • ADA CONSULTING 6793 WEST CHARLESTON BOULEVARD LAS VEGAS, NEVADA 89146 (702)258-0115</p>	<p>CITY OF LAS VEGAS WASHINGTON AVENUE UTILITY PLAN & PROFILE STA 92+00 TO STA 101+00</p>
<p>DATE: 04/27/00 DRAWN BY: JRL/WTA DESIGNED BY: J.L.B.T. CHECKED BY: J.L.B.T. ADA CHECKED BY: JOB NO.: 01330141 SCALE: AS SHOWN</p>	<p>NO. DESCRIPTION DATE APPD</p>
<p>PROFESSIONAL ENGINEER - STATE OF NEVADA MYRON R. WELSH No. 2646 7/25/00</p>	<p>SHEET 34 U-8 OF 59</p>
<p>DWG. NO. 107-V3110</p>	

2651