



SANDHILL ROAD
MATCH LINE STA. "S" 30+00
SEE SHEET 7

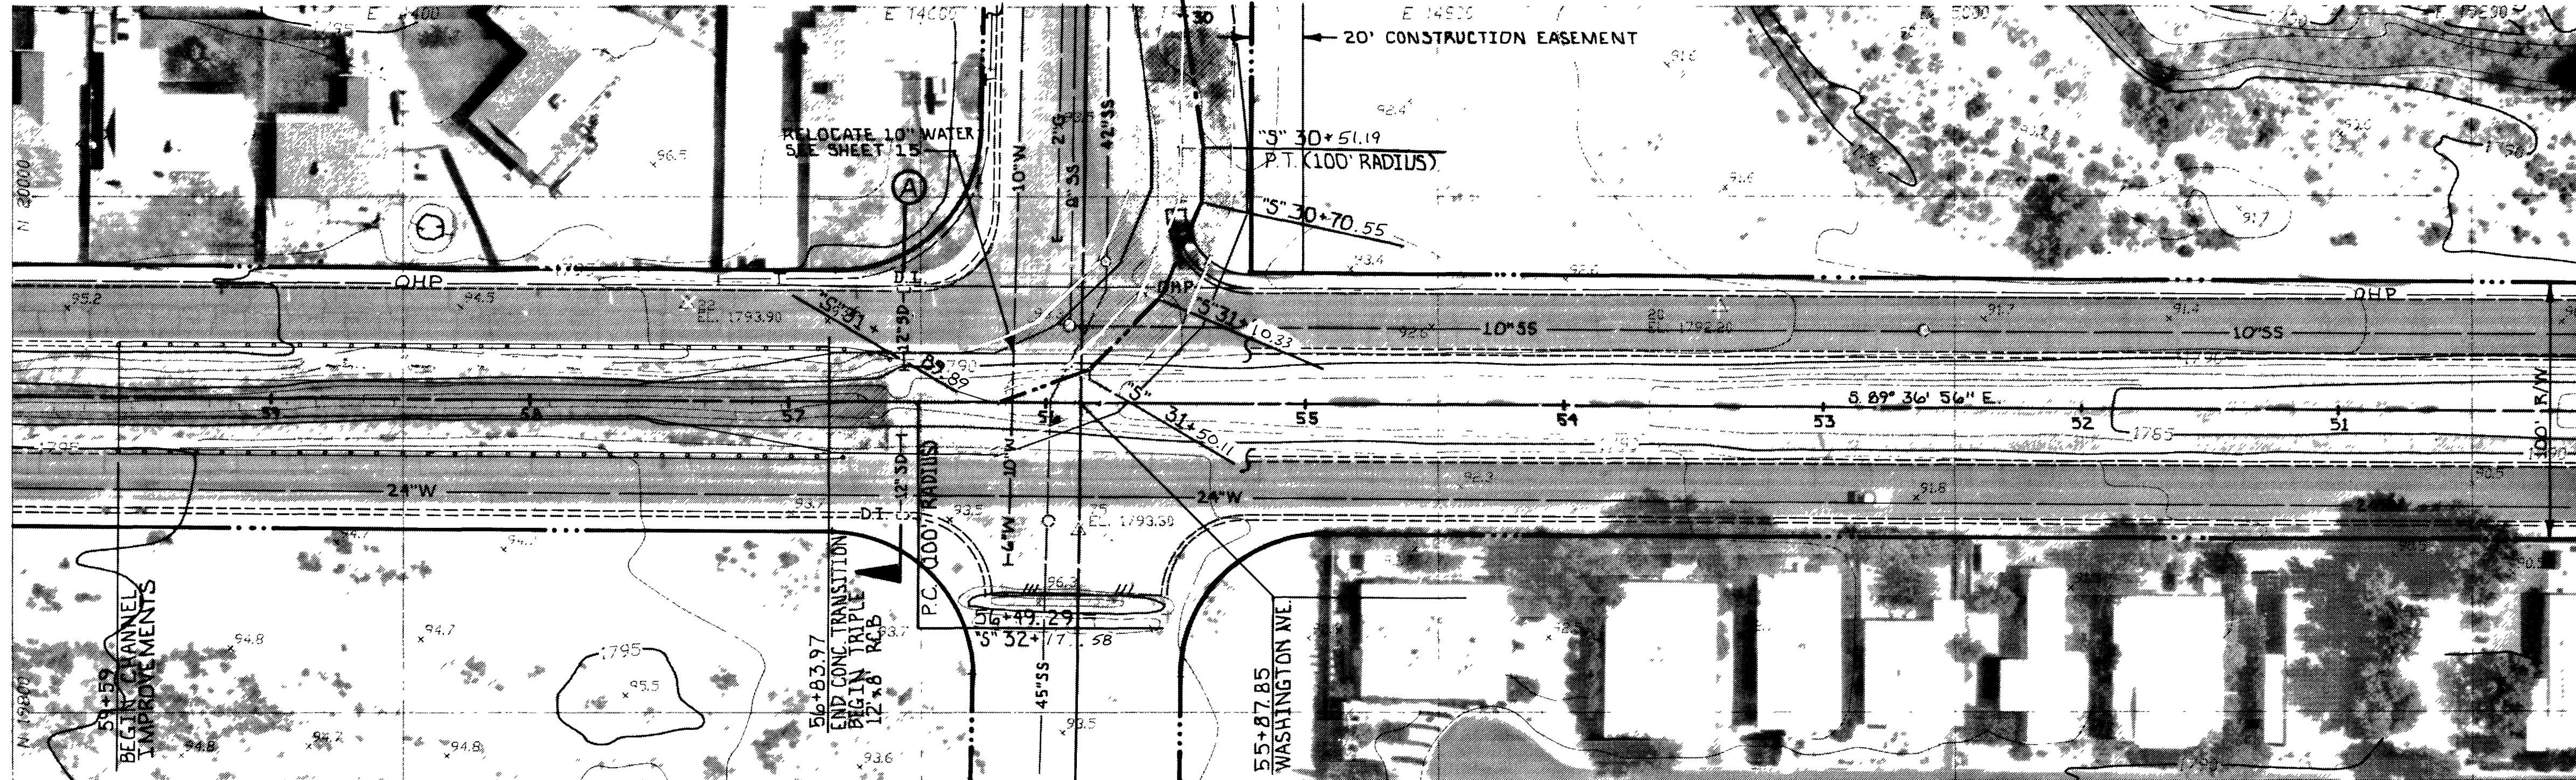

WASHINGTON AVENUE

RECORD DRAWING
These Record Drawings have been prepared based on information provided by others. The Engineer has not verified the accuracy of such information and shall not be responsible for any errors or omissions which may be incorporated herein as a result.

DATE 3-15-92
LVVV

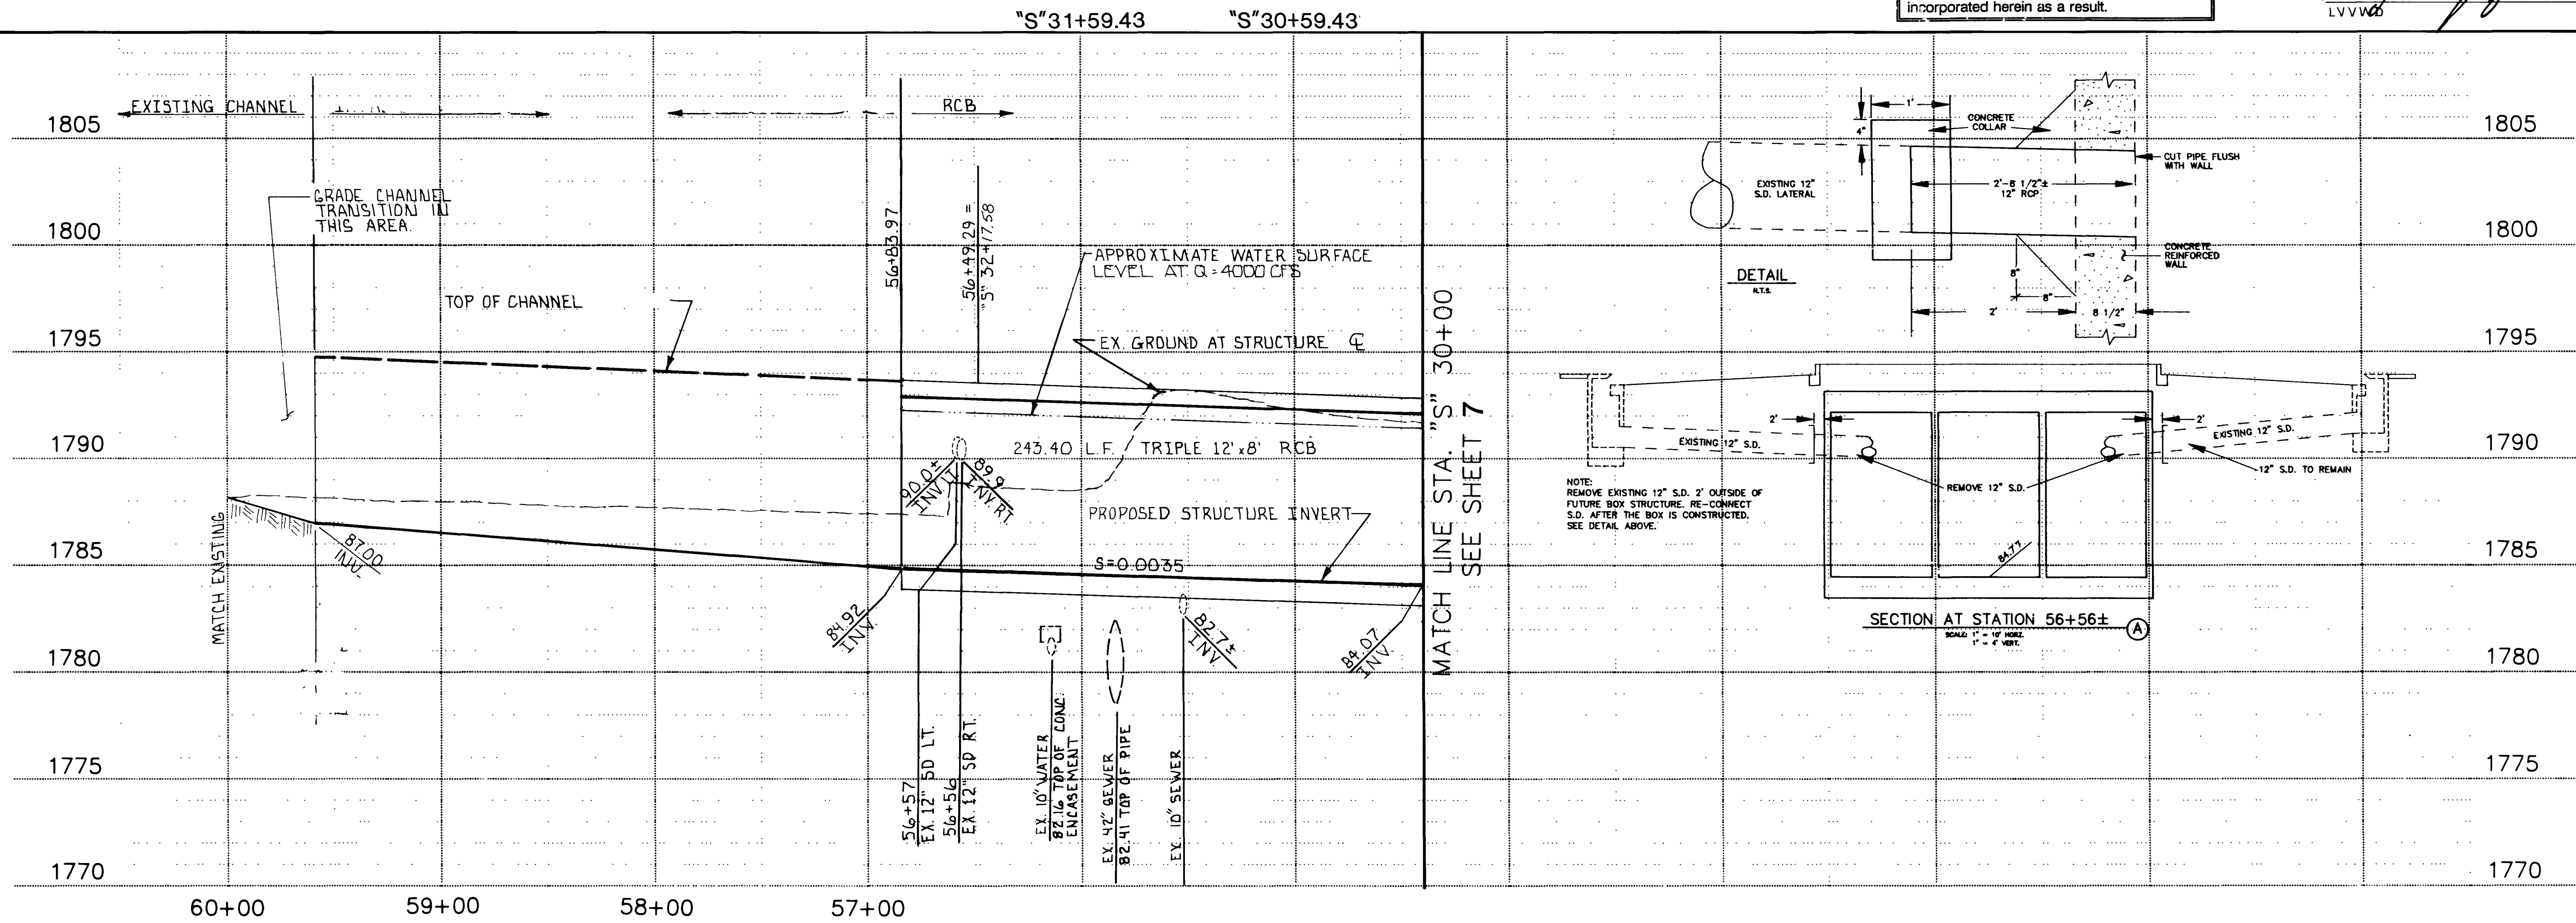

REVISIONS	
No.	Date

DESIGNED: R.T.
DRAWN: P.S.M.
CHECKED: L.H.G.
JOB NO. 343-90
SCALE: HORIZ. 1"=40'
VERT. 1"=4'

1055 EAST TROPICANA
SUITE 800
LAS VEGAS, NEVADA 89119
(702) 798-1007
MEA
CONSULTING ENGINEERS

PROJECT: CITY OF LAS VEGAS
WASHINGTON AVENUE CONVEYANCE SYSTEM
DESCRIPTION: RCB PLAN AND PROFILE
SHEET 8
OF 15

