


REVISED INLET STRUCTURE SEE SHT 7

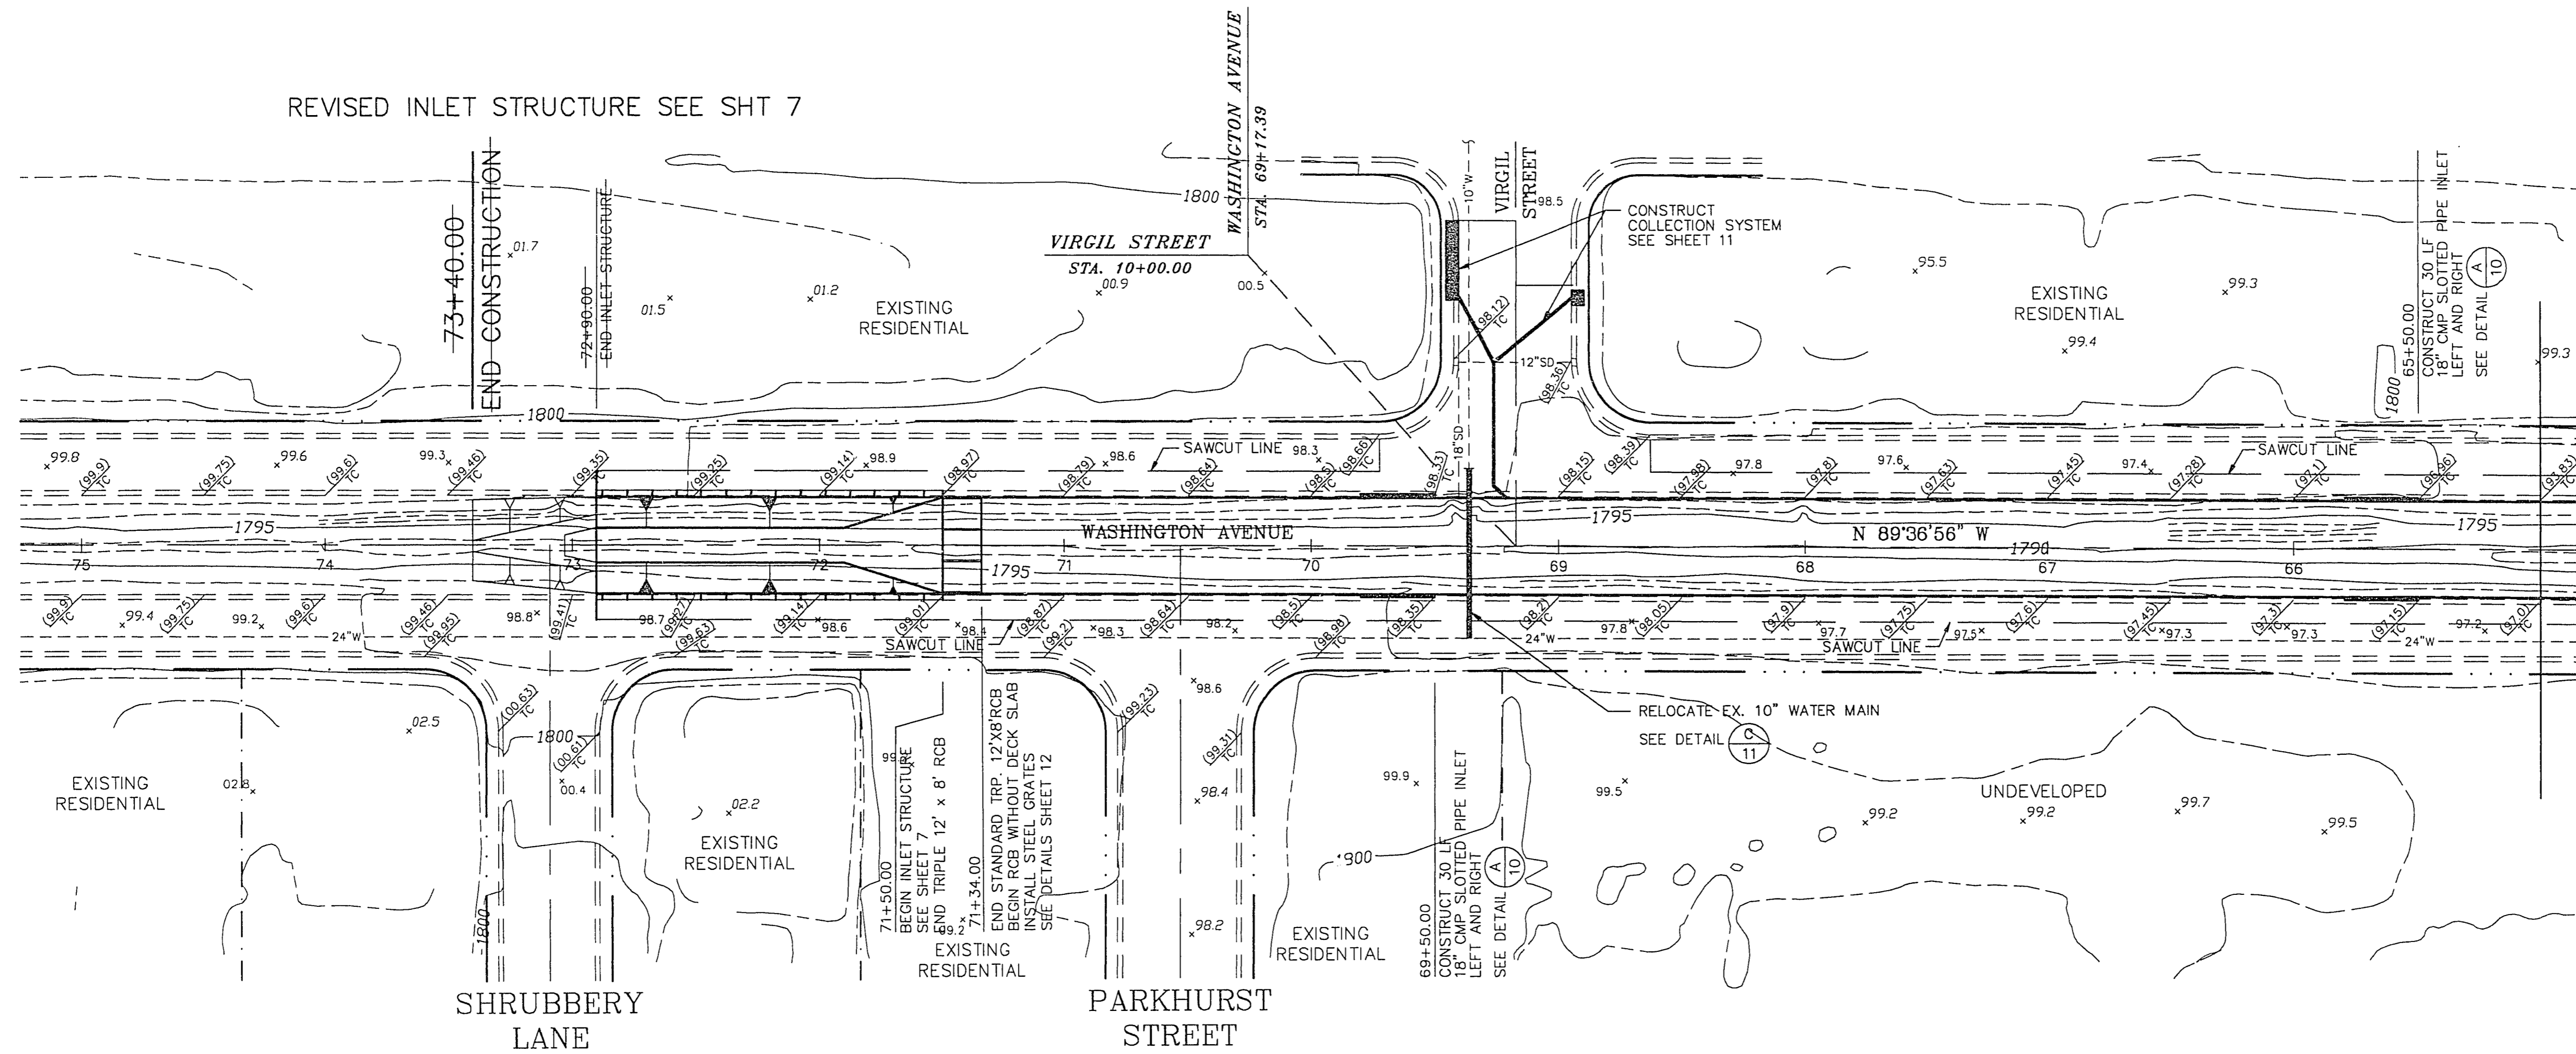

MATCH LINE - STA. 65+00  
SEE SHEET 5




REVISIONS	
No.	Date

DESIGNED: BDC/CK  
 DRAWN: CK/EM  
 CHECKED: JHG  
 JOB NO. 393-91  
 SCALE: HORIZ. 1" = 40'  
 VERT. 1" = 4'

1055 EAST TROPICANA  
 SUITE 800  
 LAS VEGAS, NEVADA 89119  
 (702) 798-1007

AEA  
CONSULTING ENGINEERS

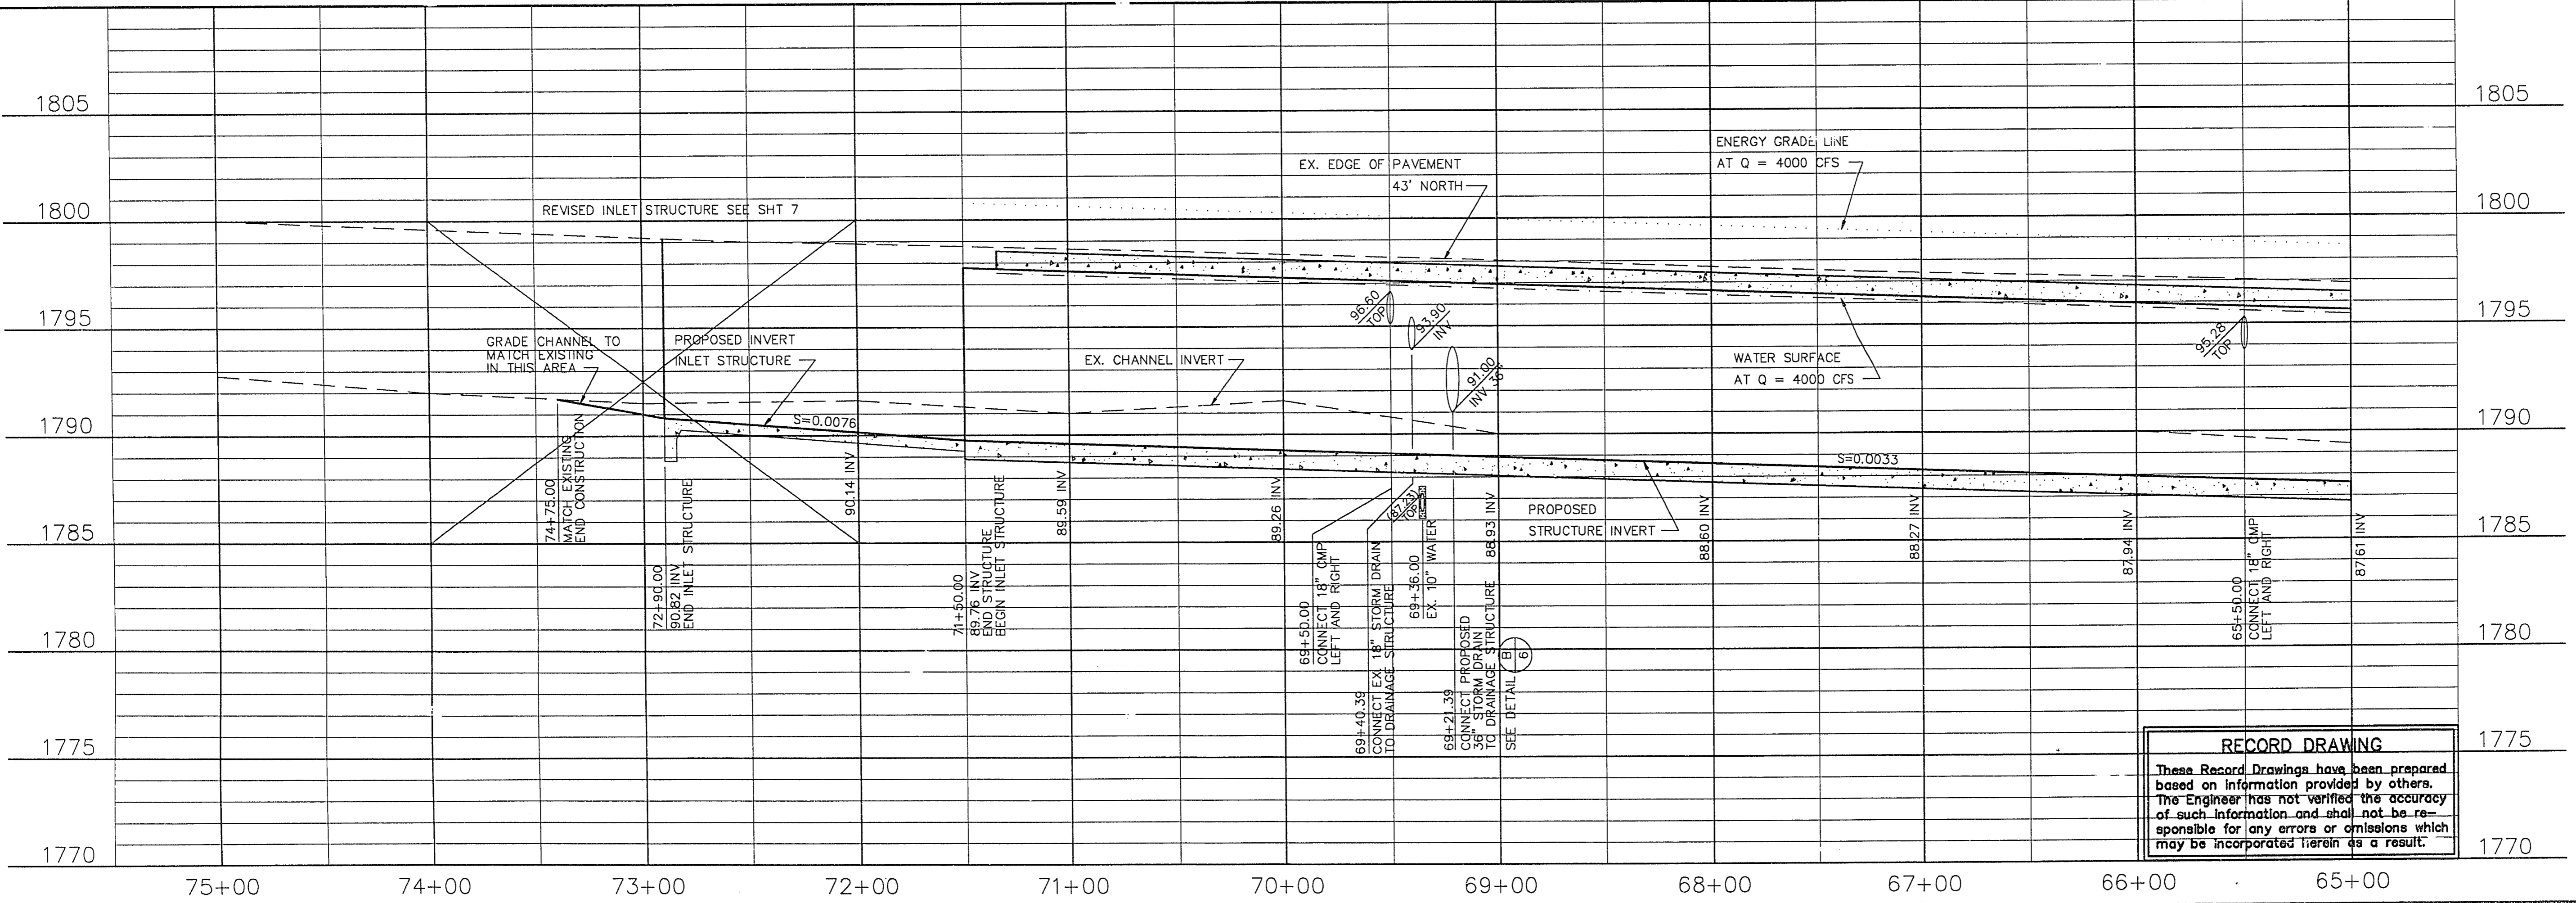

PROJECT: CITY OF LAS VEGAS  
 WASHINGTON AVENUE CONVEYANCE SYSTEM  
 DESCRIPTION: DRAINAGE STRUCTURE PLAN and PROFILE  
 STA. 75+00 to 65+00

SHEET 4 OF 12