


CONSTRUCTION NOTES

- SAWCUT AND MATCH EXISTING A.C. PAVEMENT
- CONSTRUCT 'L' TYPE CURB & GUTTER PER USD #216
- CONSTRUCT 5' SIDEWALK PER USD #234
- CONSTRUCT TYPICAL ROADWAY SECTION PER DETAIL (R6)
- REMOVE EX. SW, C&G, CONST. SW RAMP PER USD #235
- CONSTRUCT SW RAMP, CASE I, PER USD #235
- REMOVE EX. MED. ISLAND, CONST. MED. ISLAND PER USD #220
- CONSTRUCT MEDIAN NOSE MARKINGS PER USD #248
- EXISTING CURB & GUTTER AND SW TO REMAIN
- INSTALL TYPE I MONUMENT PER USD #239
- INSTALL TYPE II-B MONUMENT PER USD #240
- INSTALL TYPE III MONUMENT PER USD #410
- EXISTING CURB & GUTTER TO REMAIN
- EXISTING VALLEY GUTTER TO REMAIN
- INSTALL STORAGE LANE LINE PER USD #246
- INSTALL TWO WAY LEFT TURN LINE PER USD #244
- INSTALL LANE LINE PER USD #246
- INSTALL POLYMER CROSSWALK MARKING PER USD #254
- INSTALL POLYMER PAVEMENT ARROW
- INSTALL POLYMER PAVEMENT "ONLY"
- INSTALL POLYMER PAVEMENT STOP BAR (24")
- REMOVE EXISTING A.C. PAVEMENT
- REMOVE EXISTING VALLEY GUTTER AS SHOWN
- EXISTING SIDEWALK RAMP TO REMAIN
- INSTALL 6" WHITE BIKE LANE LINE
- REMOVE EXISTING CURB & GUTTER
- REMOVE EXISTING SIDEWALK
- VERTICALLY ADJUST WATER VALVE BOX
- VERTICALLY ADJUST MANHOLE COVER
- RELOCATE SIGN
- REMOVE & SALVAGE EX. SIGN
- TRAFFIC SIGNAL IMPROVEMENTS (SEE ELECTRICAL PLANS)
- INSTALL DOTTED LANE LINE PER DETAIL (R6)
- REMOVE AND SALVAGE EXISTING CONCRETE BARRIER RAIL
- INSTALL TEMPORARY STRIPING AS SHOWN
- CONSTRUCT PLANT MIX BITUMINOUS SURFACE PER DETAIL (R6)
- CONSTRUCT TYPICAL ROADWAY SECTION PER DETAIL (R6)
- CONST. TYPICAL ROADWAY SECTION PER DETAIL (R6)
- REMOVE TACK-ON CURB
- INSTALL POLYMER BIKE LANE MARKERS PER DETAIL (R6)
- CONST. TYPICAL ROADWAY SECTION PER DETAIL (R6)

MATCH LINE - STA. 65+00
SEE SHEET R-3

SIGNAGE LEGEND


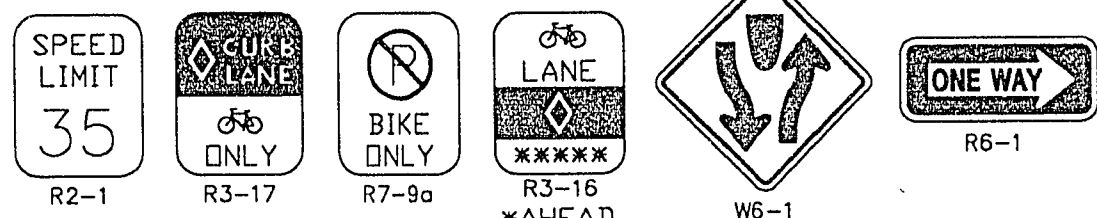


NOTE:
WHERE SIGN LOCATIONS INDICATED ARE 20 FEET OR LESS FROM AN EXISTING STREETLIGHT STANDARD, THE SIGN SHALL BE MOUNTED ON THE STREETLIGHT STANDARD WITH ACCEPTABLE HARDWARE.

NOTE:
1. FOR MEDIAN ISLAND GEOMETRY SEE SHEET R-7.

SANDHILL ROAD
STA. 10+00.00

SANDHILL ROAD

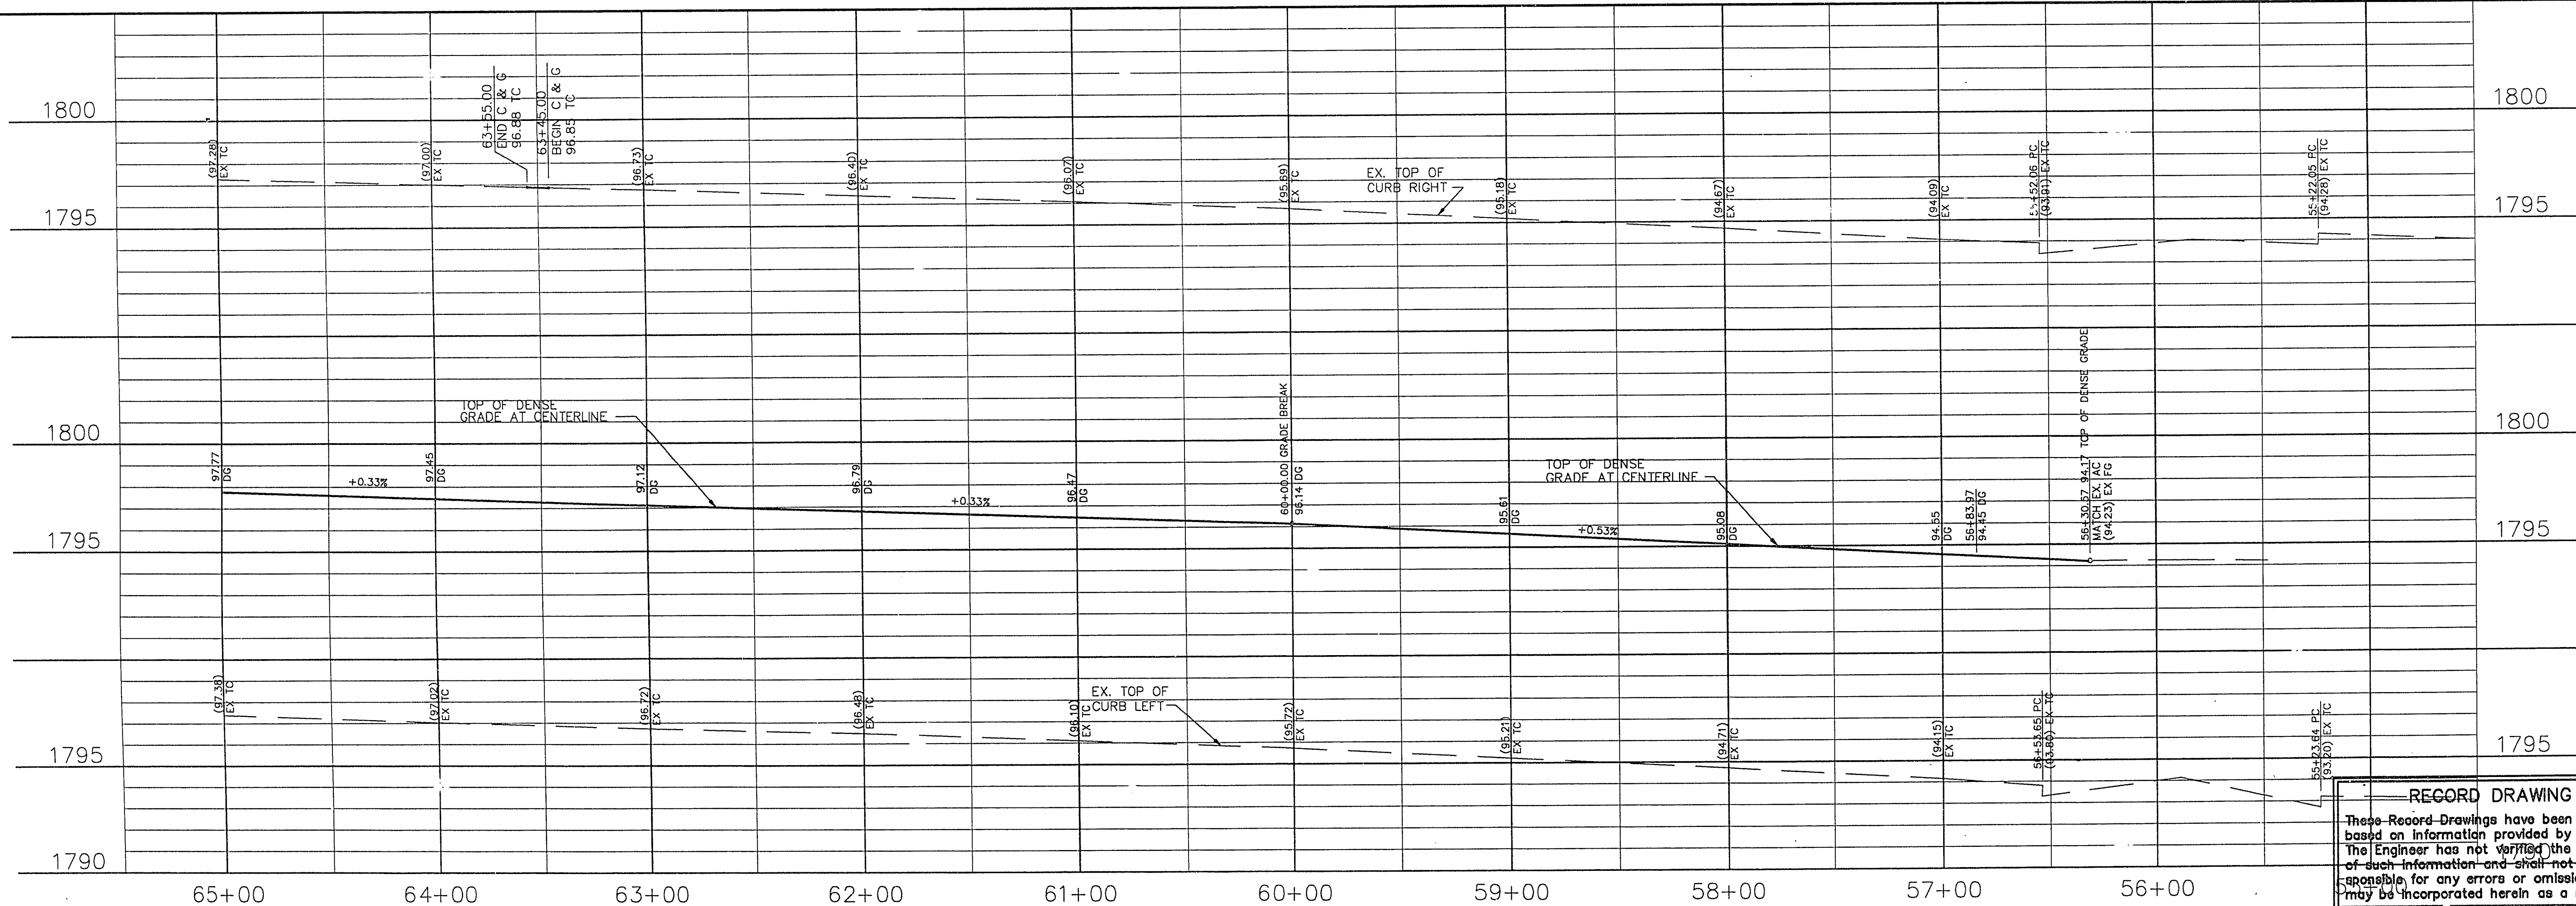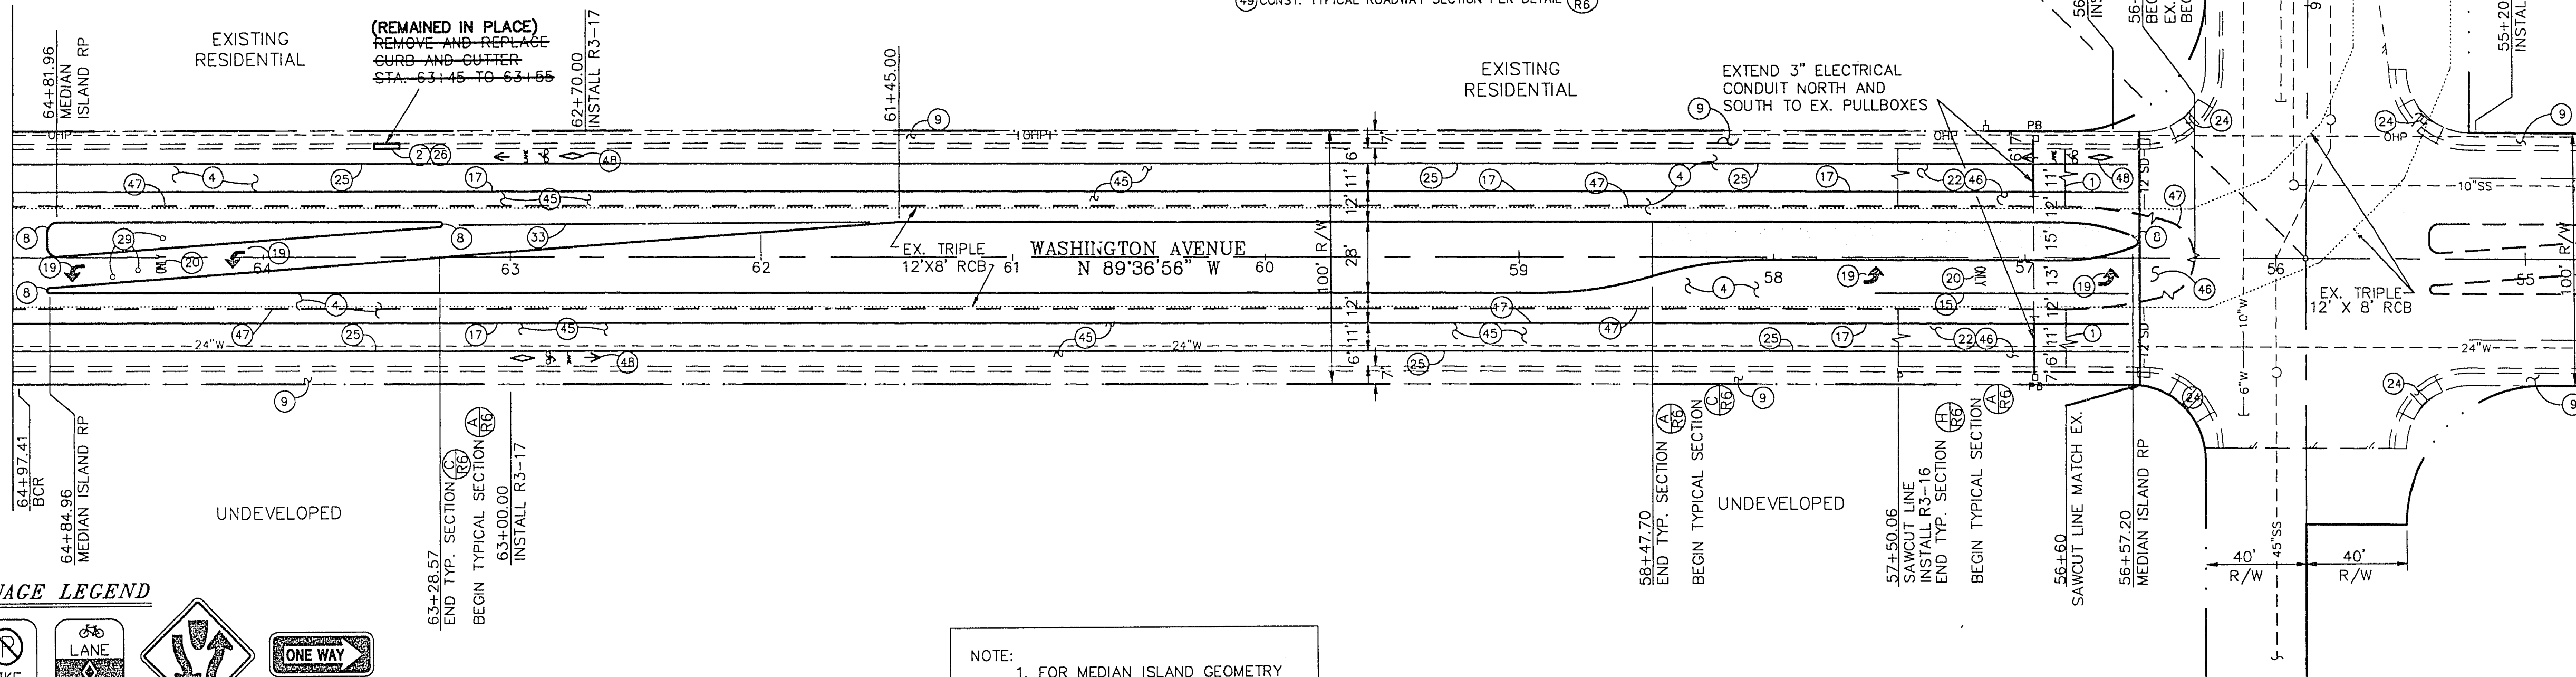


RECORD DRAWING

These Record Drawings have been prepared based on information provided by others. The Engineer has not verified the accuracy of such information and shall not be responsible for any errors or omissions which may be incorporated herein as a result.

REVISIONS		DESIGNED: JB		DRAWN: MS/DB		CHECKED: LUC		JOB NO. 462-83		SCALE: HORIZ. 1" = 40'		VERT. 1" = 4'	
No.	Date												

1055 EAST TROPICANA
SUITE 800
LAS VEGAS, NEVADA 89119
(702) 796-1007

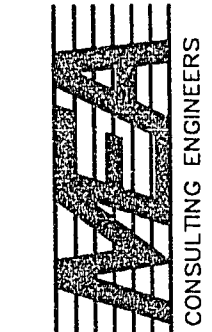

PROJECT: CITY OF LAS VEGAS
WASHINGTON AVENUE CONVEYANCE SYSTEM

DESCRIPTION:
ROADWAY PLAN and PROFILE
STA. 65+00 to 56+83.97

SHEET
R-4
17 OF 23