



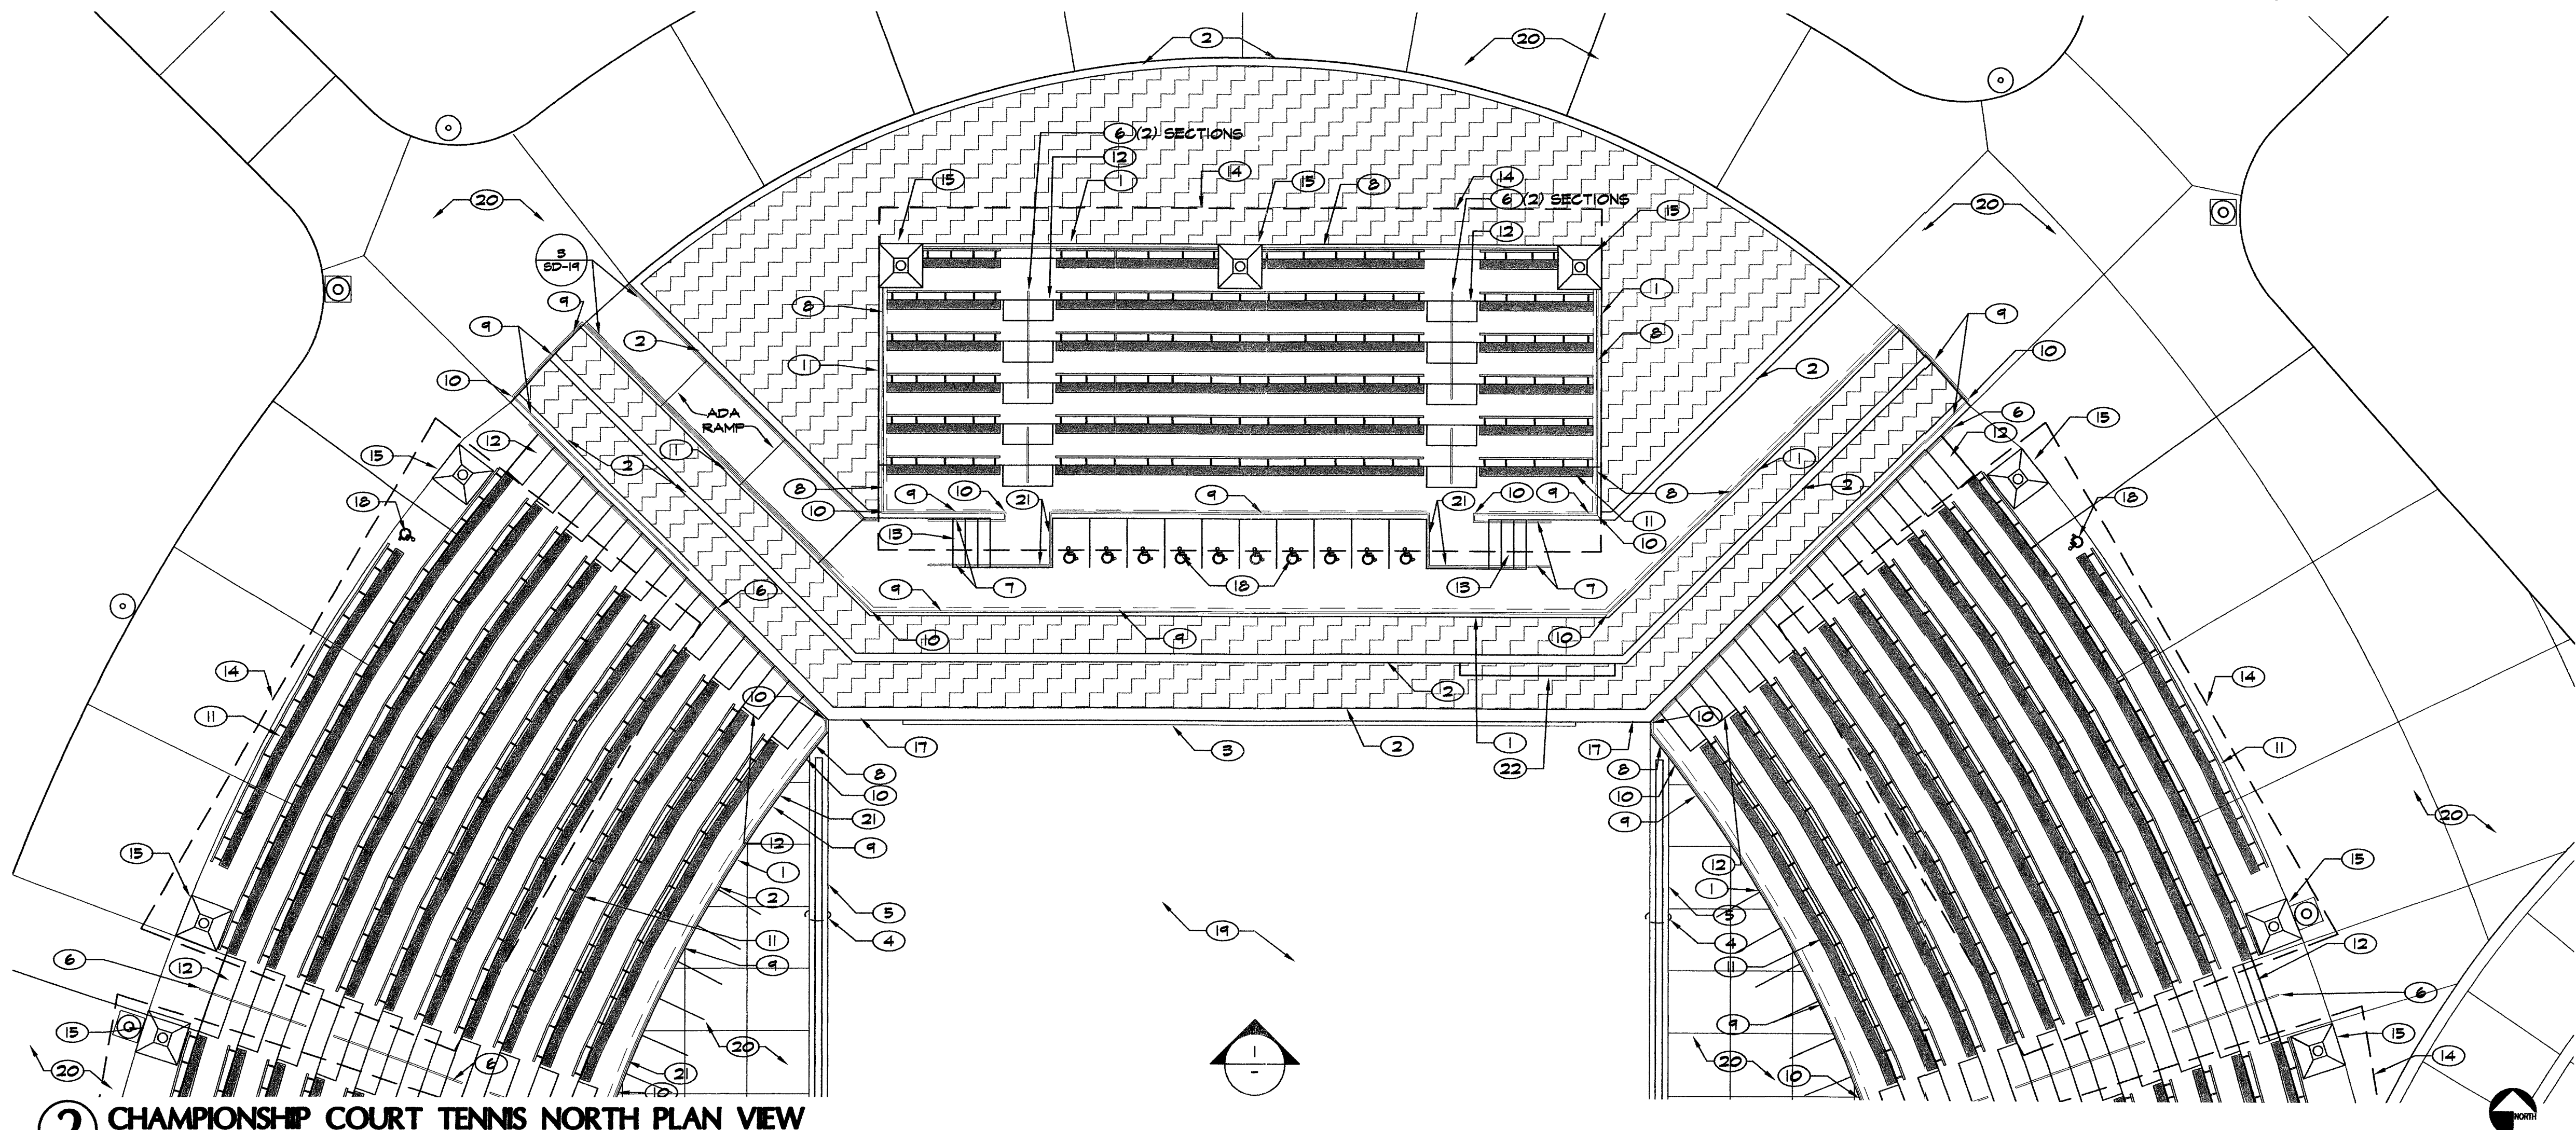

LEGEND							
KEY	DESCRIPTION	KEY	DESCRIPTION	DETAIL REF.	KEY	DESCRIPTION	DETAIL REF.
	BLEACHERS SEE SPECS. 13125		1 OUTSIDE FACE OF POURED-IN-PLACE CONCRETE WALL WITH THICKENED CONCRETE EDGE OF SLAB ON TOP OF WALL. SEE ALSO STRUCTURAL PLANS.	3 SD-4		7 HANDRAIL AT CONCRETE STEPS	3 SD-11
	LANDSCAPE PLANTERS & TREE FITS IN TENNIS PLAZA AREAS		2 POURED-IN-PLACE CONCRETE PLANTER WALL. SEE ALSO STRUCTURAL PLANS.	4 SD-4		8 GUARD RAIL	1 SD-11
			3 TENNIS COURT PAD - SEE SPECS SECTION 02865	-		9 SAFETY RAIL	4 SD-11
			4 TRENCH DRAIN - SEE CIVIL PLANS	C14		10 WELD RAILS TOGETHER AT THEIR MEETING POINTS - PROVIDE DETAILING ON SHOP DRAWINGS.	6 SD-12
			5 CONCRETE ENCASMENT AS SHOWN AROUND TRENCH DRAIN: 4500 P.S.I. @ 28 DAY CURE (SEE CIVIL PLANS). CONCRETE SURROUNDING TRENCH DRAIN SHALL SLOPE TOWARDS THE DRAIN AT 1%. NO WATER PONDING SHALL OCCUR NEXT TO POURED-IN-PLACE WALL, OR ANY OTHER LOCATION.	3 SD-10		11 BLEACHER SEAT (TYP)	2 SD-11
			6 HAND RAIL AT SPECTATOR SEATING			12 CONCRETE STEPS AT BLEACHER SPECTATOR SEATING	1 SD-10
						13 CONCRETE STEPS	3 SD-11
						14 SHADE TRELLIS WITH FABRIC ADDITIVE ALTERNATE #2	1-7 SD-12
						15 SHADE TRELLIS COLUMN ADDITIVE ALTERNATE #2	6 SD-12
						16 CONCRETE FOOTING - SEE STRUCTURAL PLANS.	
						17 CONCRETE RELIEF TENNIS SCULPTURE	7-10 SD-11
						18 ADA SEATING AREA WITH LOGO PAINTED ON CONCRETE PAVEMENT COLOR - ADA BLUE	4 SD-17
						19 POST TENSION TENNIS COURT	2 SD-24
						21 GUARD RAIL CONDITION AT SAFETY RAIL	5 SD-11
						22 SCORE BOARD SEE SPECS. 16705 AND ELECTRICAL PLANS	

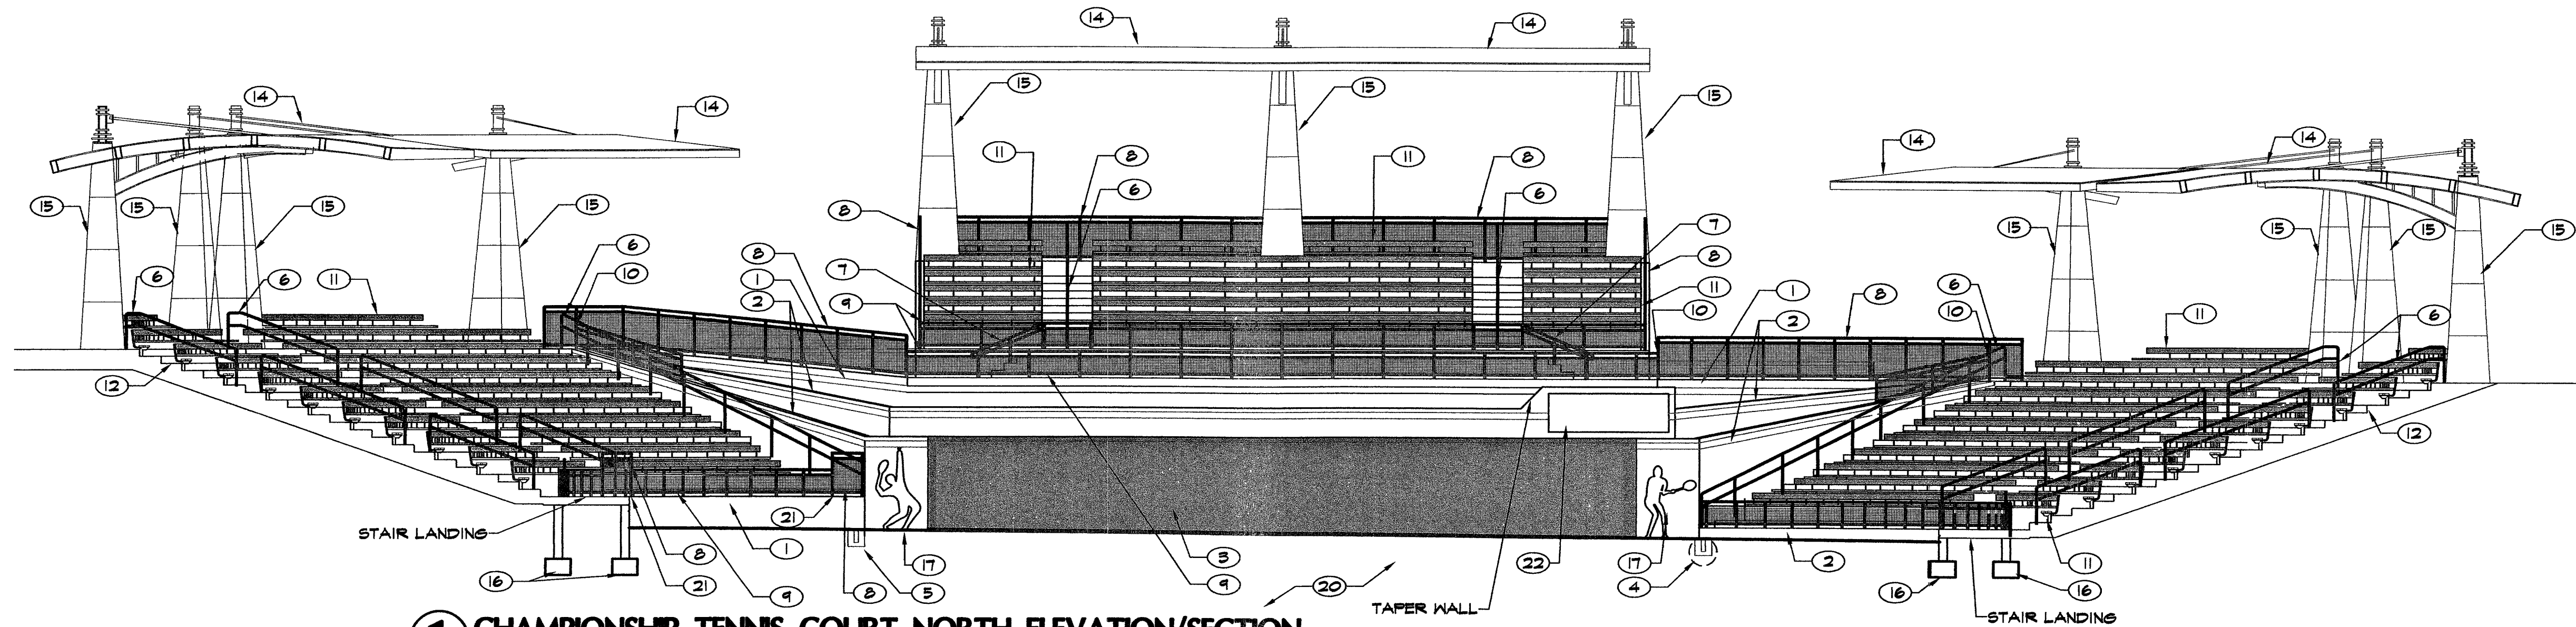

REVISIONS

CONSULTANT


7251 W. CHARLESTON BLVD
LAS VEGAS, NEVADA 89117
PHONE (702) 258-0115
FAX (702) 869-8547



WASHINGTON BUFFALO PARK - PHASE 1A
WASHINGTON & BUFFALO, LAS VEGAS, NV

SITE DETAILS

STAMP

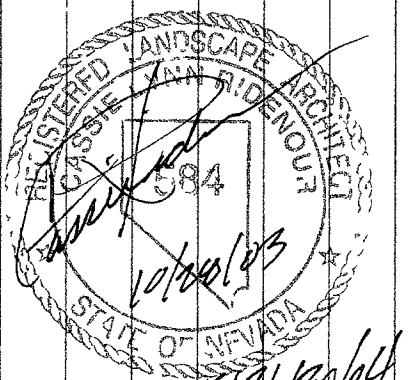

OWNER: CITY OF LAS VEGAS
DEPARTMENT OF PUBLIC WORKS
ARCHITECTURAL SERVICES

400 EAST STEWART AVENUE
LAS VEGAS, NEVADA 89101
PHONE: (702) 229-8535
FAX: (702) 382-5232
TDD: (702) 386-9108

DRAWN: KUC

FILE: 2166SD-03.dwg

DATE: 1/03

SCALE: 1/8"=1'-0"

SD NO: 03.1534100

CLV DWG NO: 65016-1A

SHT NO: 100% SUBMITTAL

SD-3

79244