



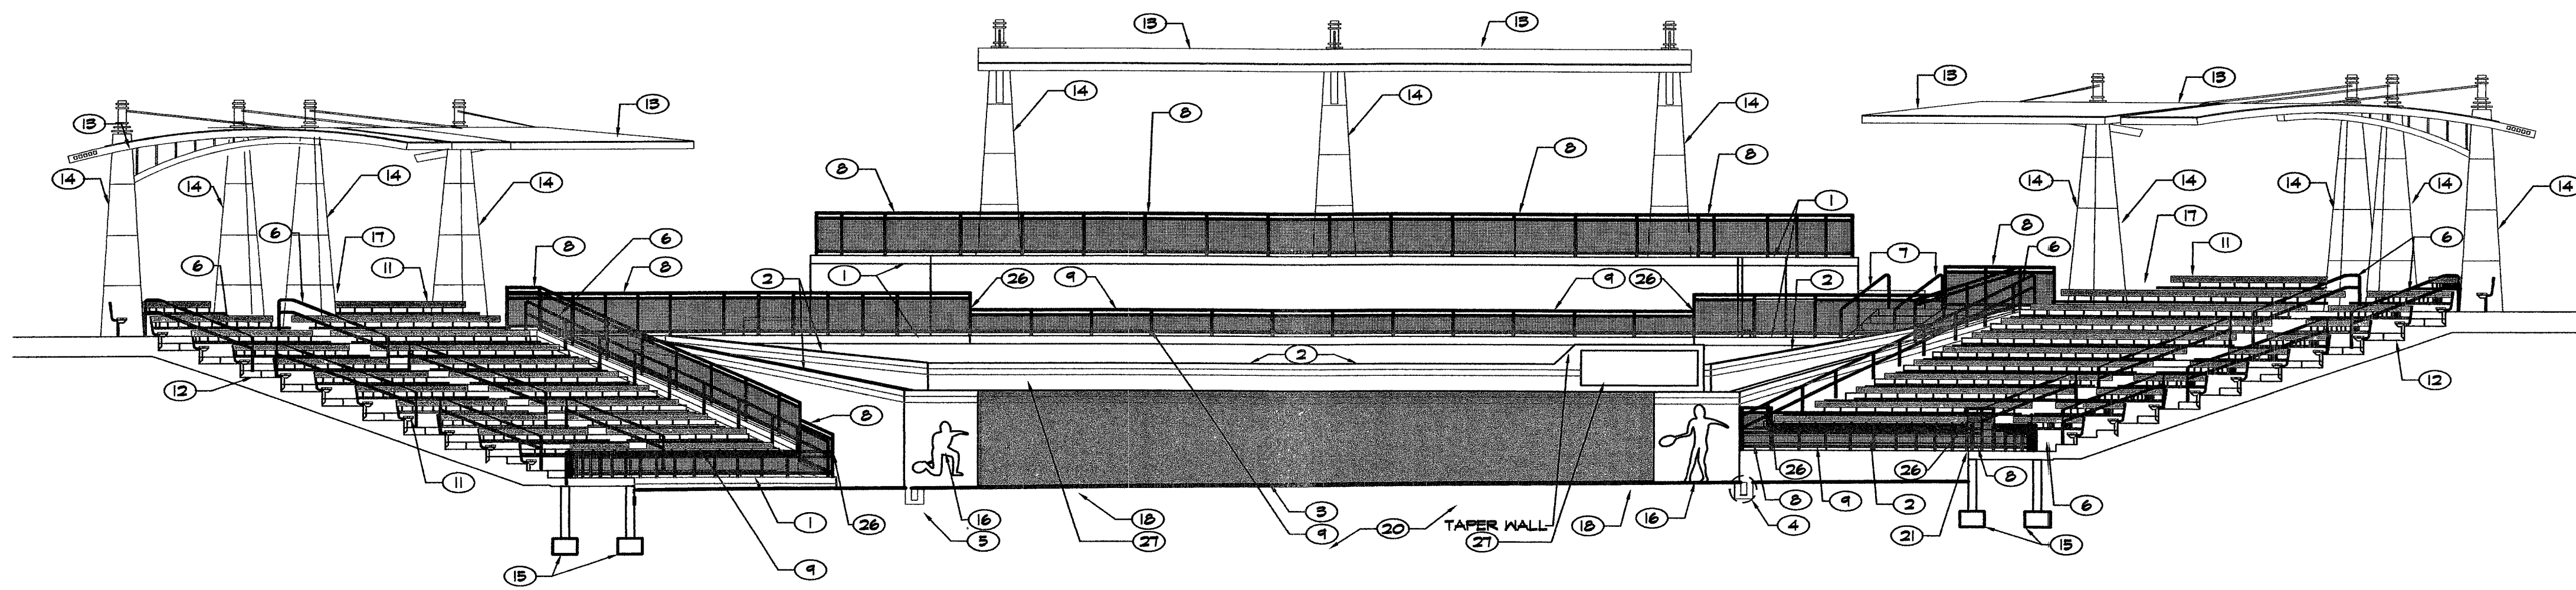

1 CHAMPIONSHIP TENNIS COURT SOUTH ELEVATION/SECTION

1/8" = 1'-0"

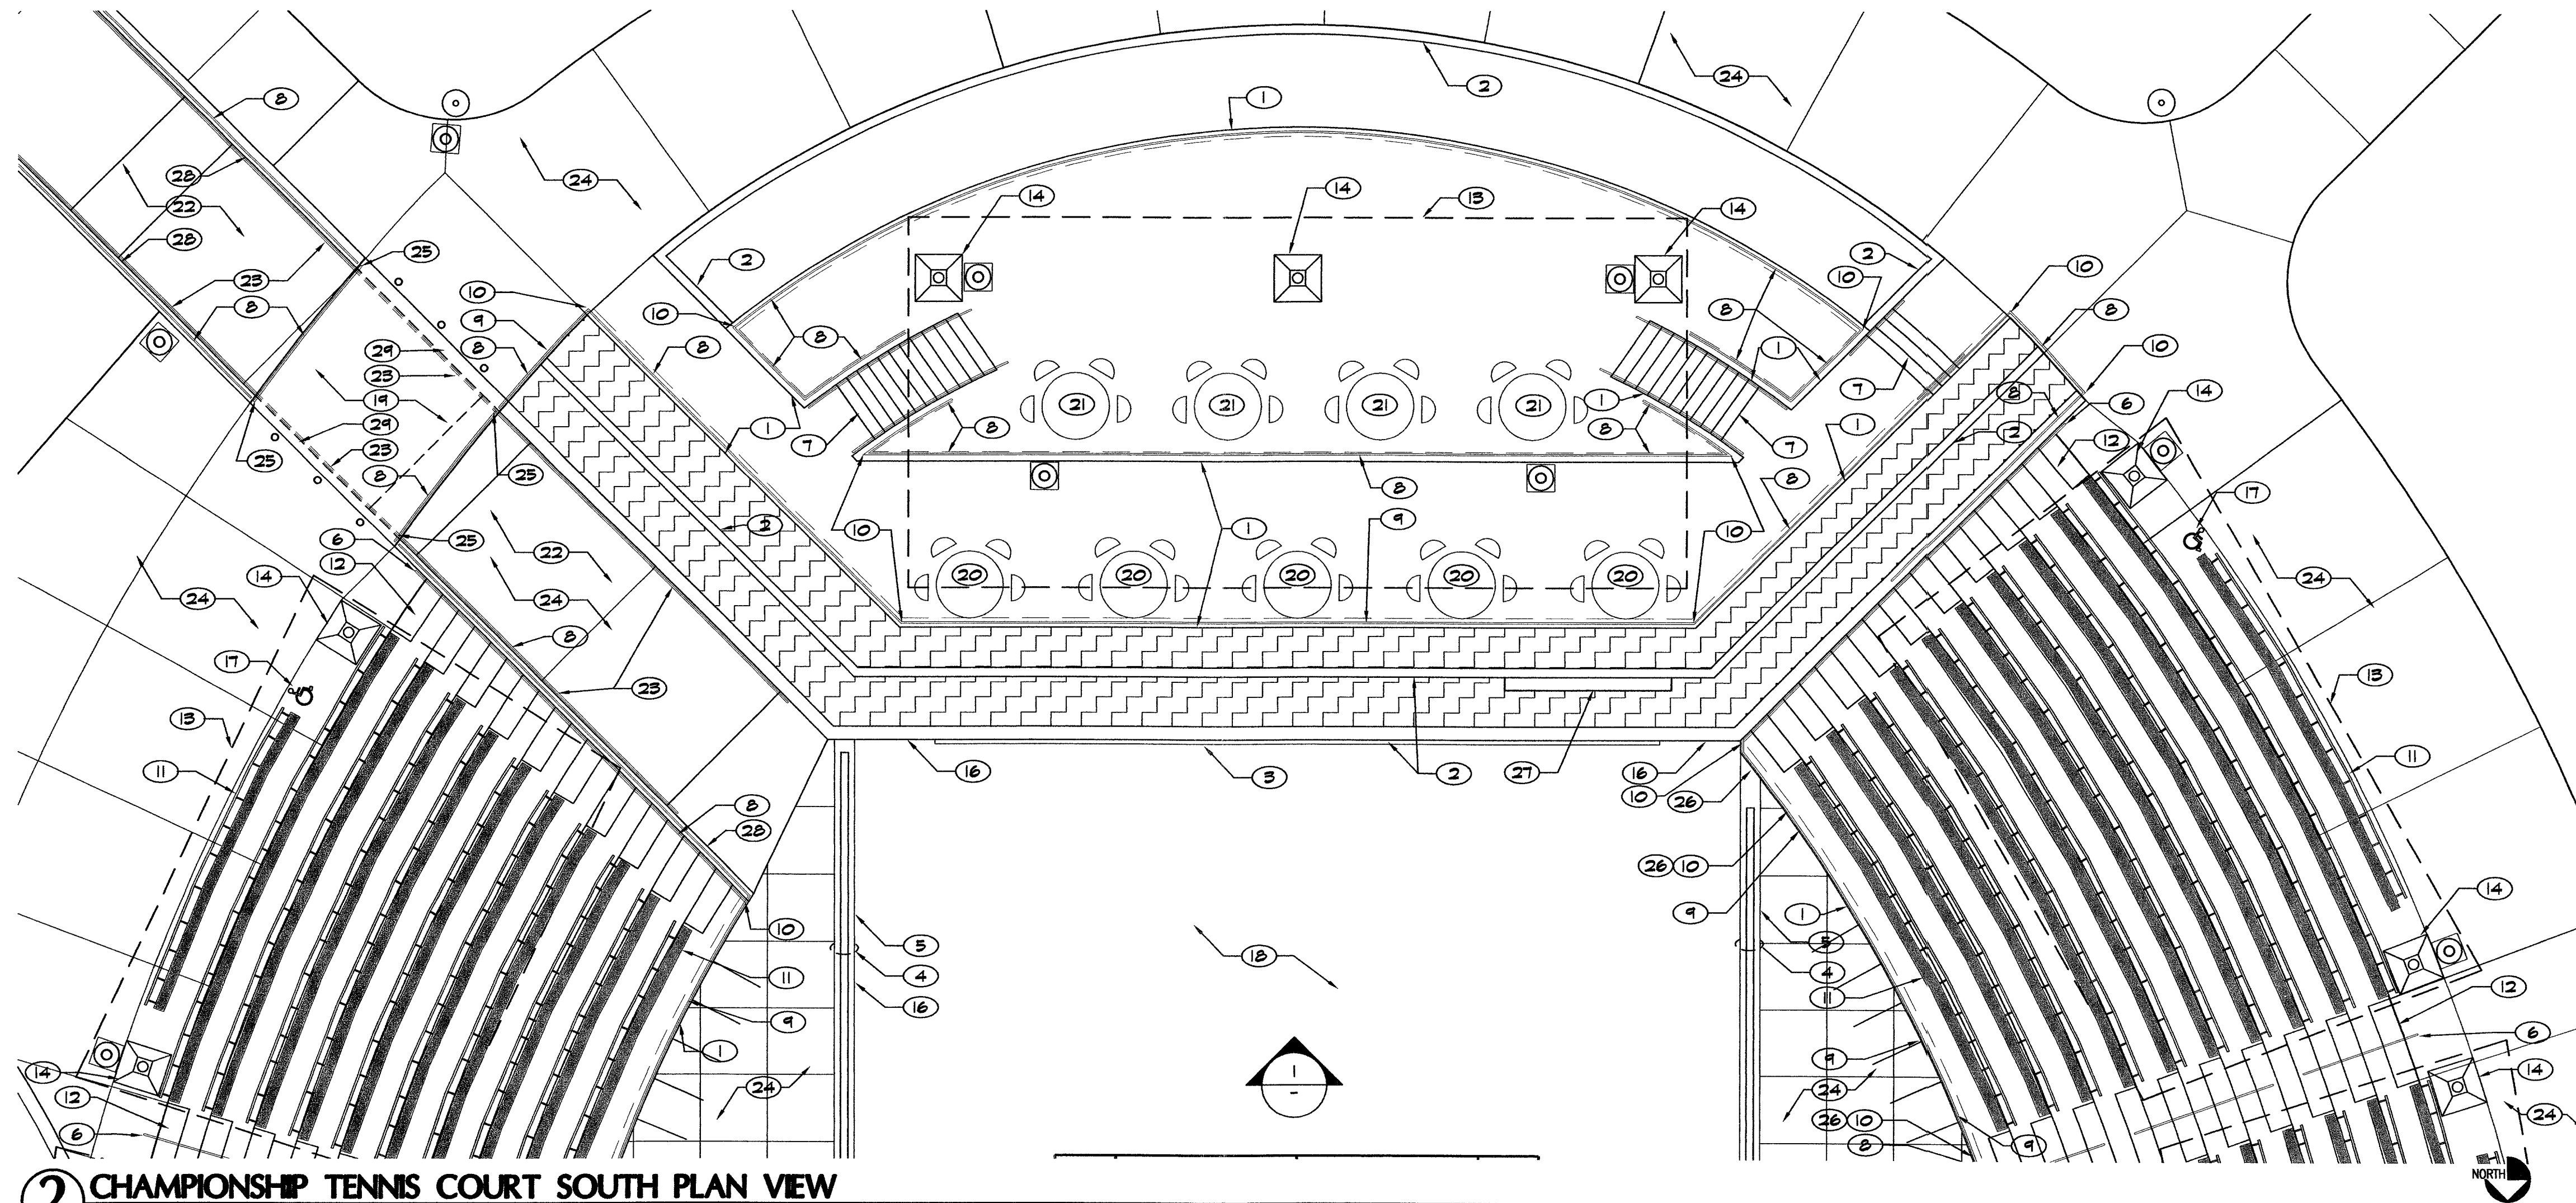

2 CHAMPIONSHIP TENNIS COURT SOUTH PLAN VIEW

1/8" = 1'-0"

LEGEND									
KEY	DESCRIPTION	KEY	DESCRIPTION	DETAIL REF.	KEY	DESCRIPTION	DETAIL REF.	KEY	DESCRIPTION
	BLEACHERS SEE SPECS. SECTION 13125	1	OUTSIDE FACE OF POURED-IN-PLACE CONCRETE WALL, WITH CONCRETE THICKENED EDGE OF SLAB ON TOP OF WALL	3 SD-9	7	CONCRETE STEPS WITH HANDRAILS ON EACH SIDE	3 SD-11	12	CONCRETE STEP AT SPECTATOR SEATING AREA
	LANDSCAPE PLANTERS AND TREE FITS IN TENNIS PLAZA AREAS	2	POURED-IN-PLACE CONCRETE PLANTER WALL	4 SD-4	8	GUARD RAIL	1 SD-11	13	SHADE TRELLIS WITH FABRIC ADDITIVE ALTERNATE #2
		3	TENNIS COURT PAD - SEE SPECS SECTION 02265	- C14	9	SAFETY RAIL	4 SD-11	14	SHADE TRELLIS COLUMN ADDITIVE ALTERNATE #2
		4	TRENCH DRAIN - SEE CIVIL PLANS.	- C14	10	WELD RAILS TOGETHER AT THEIR MERGING POINTS, EXCEPT AS NOTED (SEE (25)). PROVIDE DETAILING ON SHOP DRAWINGS	2 SD-11	15	CONCRETE FOOTING - SEE STRUCTURAL PLANS.
		5	CONCRETE ENCASUREMENT AS SHOWN AROUND DRAINAGE TRENCH: 4500 P.S.I. @ 28 DAY CURE (SEE CIVIL PLANS). CONCRETE SURROUNDING TRENCH DRAIN SHALL SLOPE TOWARDS THE DRAIN AT 1%. NO WATER PONDING SHALL OCCUR NEXT TO THE CMU WALL, OR ANY OTHER LOCATION.	3 SD-10	11	BLEACHER SEAT (TYP) SEE SPECS. SECTION 13125	2 SD-11	16	RELIEF CONCRETE TENNIS SCULPTURE
		6	HAND RAIL AT SPECTATOR SEATING	3 SD-10				17	ADA SEATING AREA WITH LOGO PAINTED ON CONCRETE PAVEMENT - COLOR: ADA BLUE
								18	POST TENSION TENNIS COURT
								19	REMOVABLE PEDESTRIAN BRIDGE SEE STRUCTURAL PLANS
								20	V.I.P. STD. TABLE WITH (4) CHAIRS (NO UMBRELLA) - SEE SPECS. SECTION 02270
								21	V.I.P. BAR TABLE WITH (4) CHAIRS - SEE SPECS. SECTION 02270
								22	ADA/VEHICULAR RAMP 6" REINFORCED CONCRETE PAVEMENT
								23	RAMP HAND RAIL
								24	6" REINFORCED INTEGRALLY COLORED CONCRETE PAVEMENT COLOR: MESA BUFF
								25	DO NOT WELD TOGETHER RAILINGS AT CORNERS OF BRIDGE; THESE SHALL BE INDEPENDENT RAILINGS. MAX. GAP: 3"
								26	GUARD RAIL CONDITION AT SAFETY RAIL
								27	SCORE BOARD - SEE SPECS. SECTION 16705 AND ELECTRICAL PLANS.
								28	RAMP WALL
								29	RAMP WALL UNDER BRIDGE

79245



REVISIONS	DATE	DESCRIPTION

CONSULTANT	7251 W. CHARLESTON BLVD. LAS VEGAS, NEVADA 89117 PHONE (702) 258-0115 FAX (702) 869-8547
OWNER	WASHINGTON BUFFALO PARK - PHASE 1A WASHINGTON & BUFFALO, LAS VEGAS, NV
SITE DETAILS	

STAMP	SEAL OF THE CITY OF LAS VEGAS ARCHITECTURAL SERVICES
OWNER	CITY OF LAS VEGAS DEPARTMENT OF PUBLIC WORKS ARCHITECTURAL SERVICES
DATE	7/2/23
SCALE	1/8"=1'-0"
SHEET NO.	SD-4
CLV DWS NO.	65216-1A
100% SUBMITTAL	

400 EAST STEWART AVENUE LAS VEGAS, NEVADA 89101 PHONE: (702) 229-5535 FAX: (702) 382-9232 TDD: (702) 386-9108	DRAWN FILE DATE SCALE SHEET NO. CLV DWS NO. 100% SUBMITTAL	KUC 7/26/23-04.dwg 7/2/23 1/8"=1'-0" 65216-1A SD-4
---	--	---