



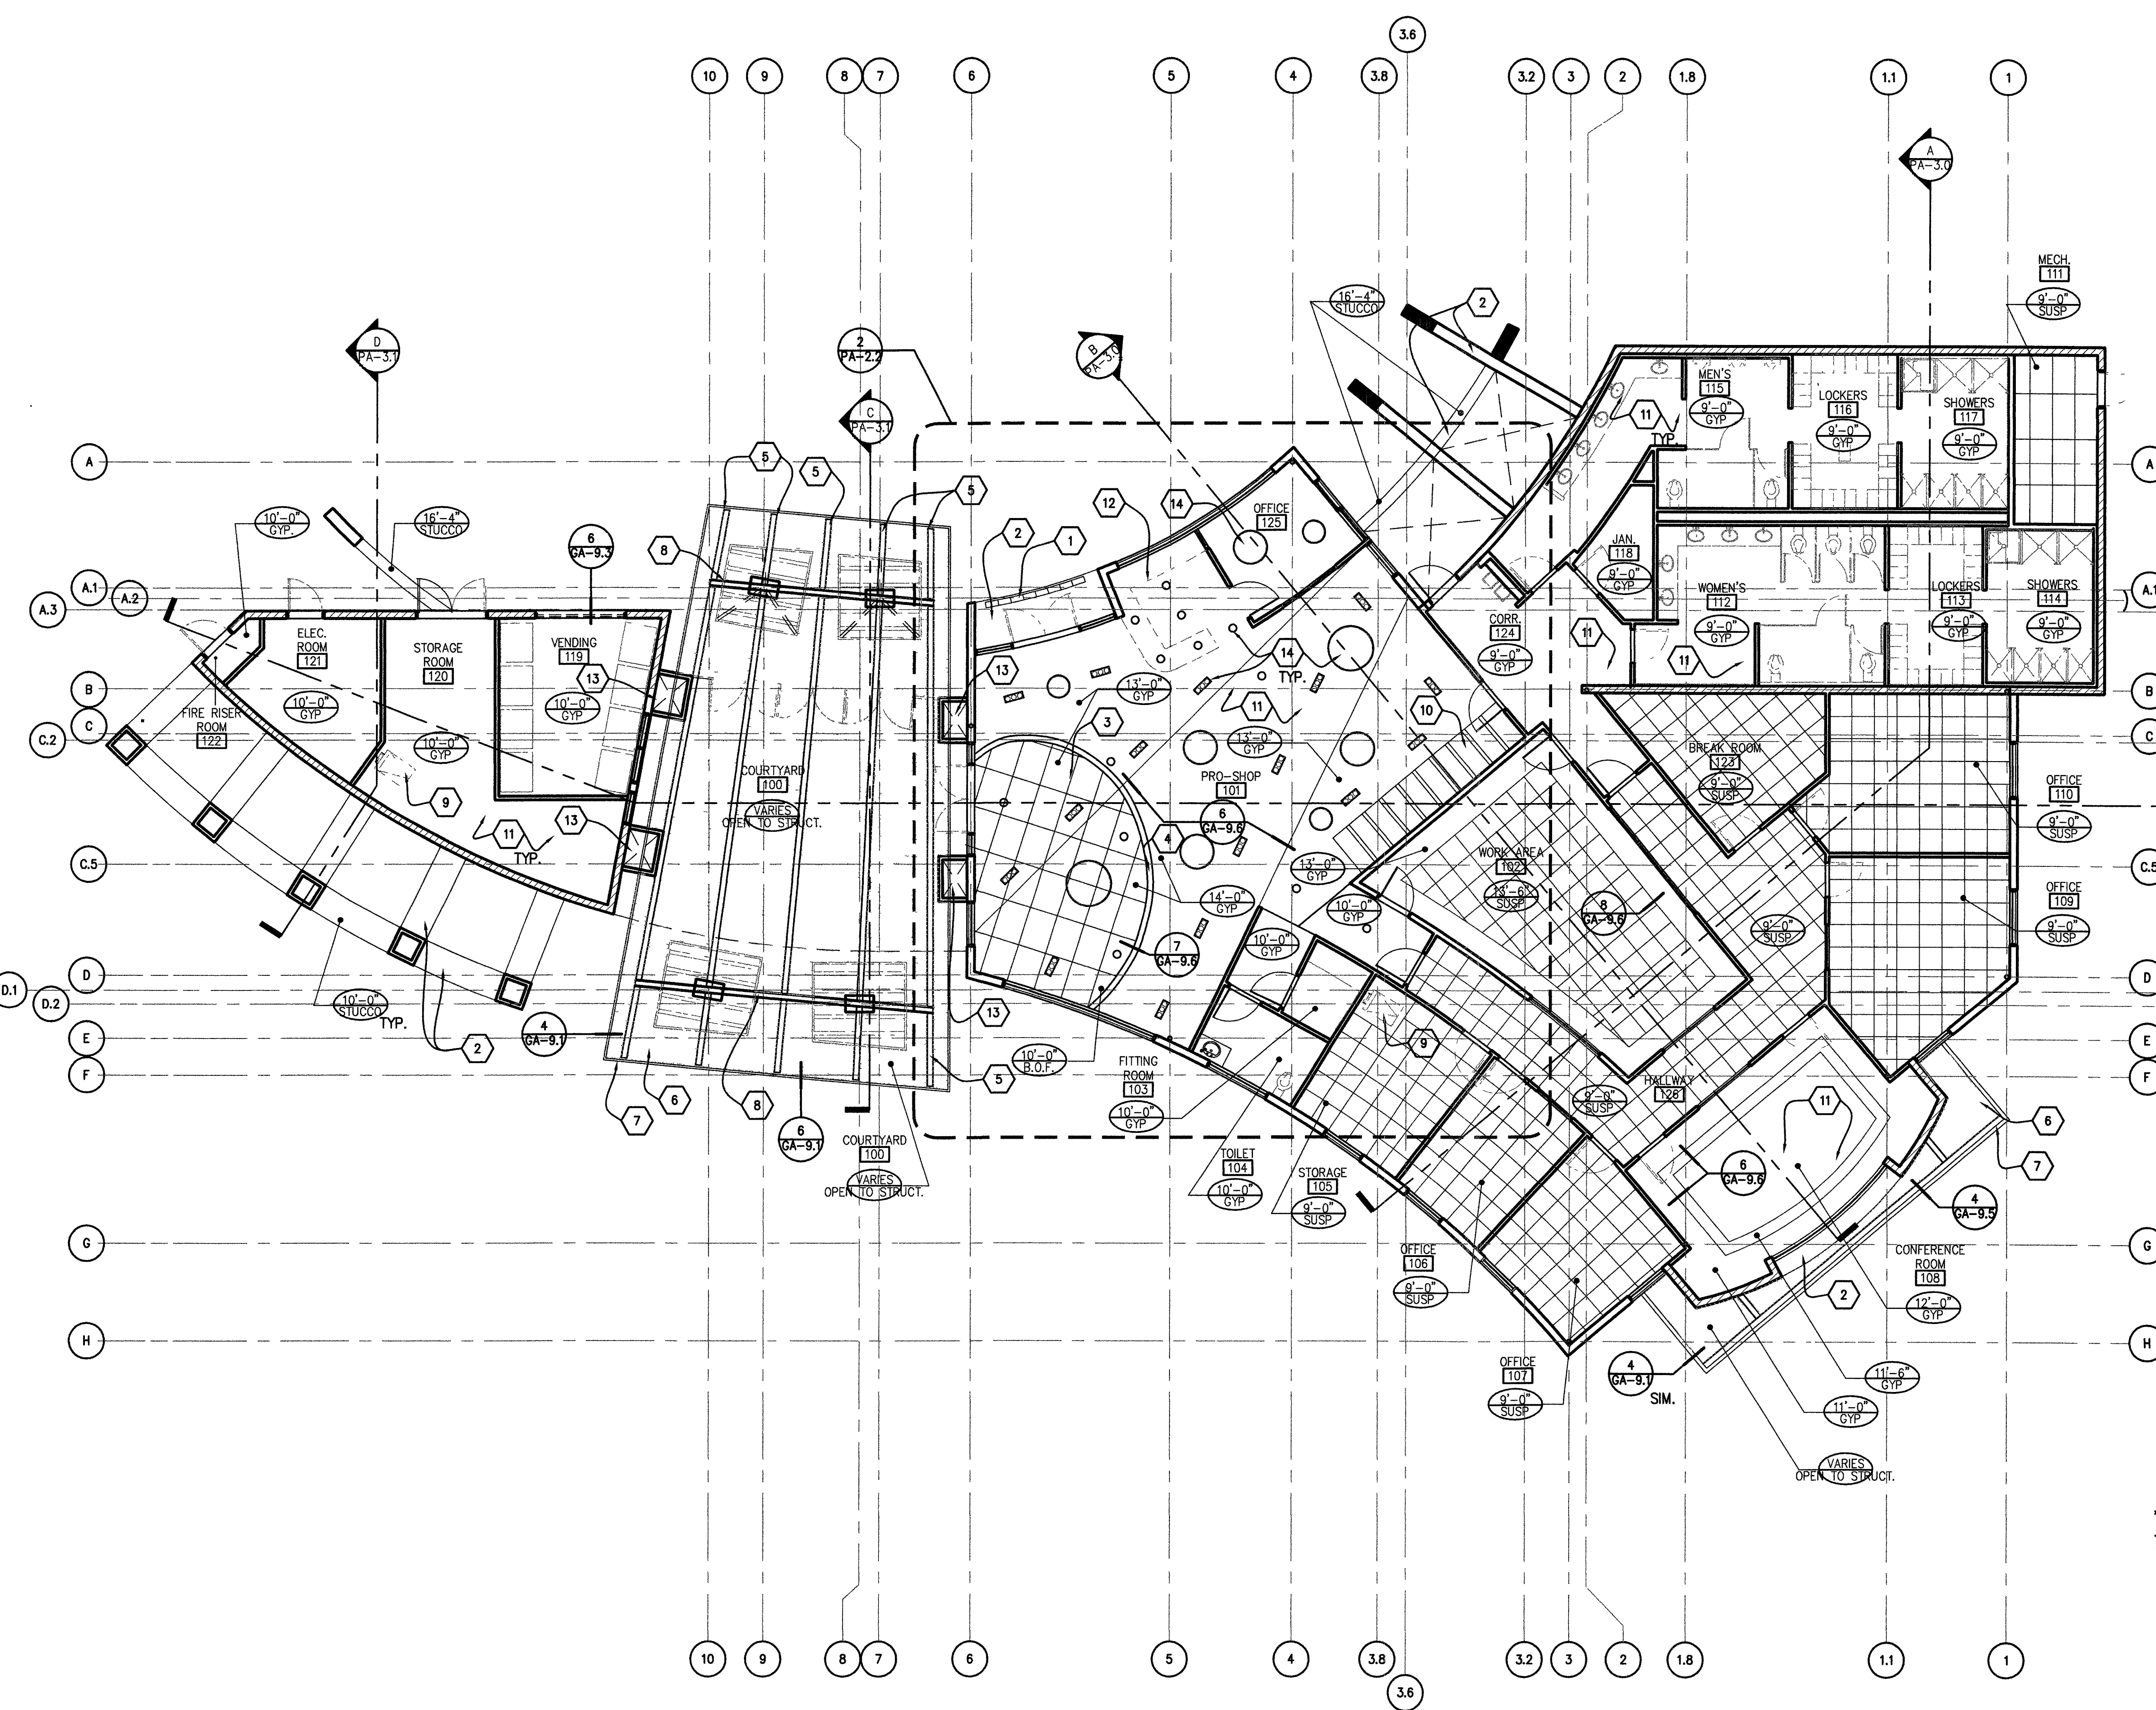


1 PRO-SHOP REFLECTED CEILING PLAN
SCALE: 1/8" = 1'-0"

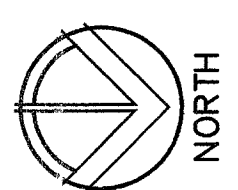

- KEYNOTES**
- 4" WIDE SOFFIT VENT.
 - 7/8" STUCCO SYSTEM SOFFIT OVER 5/8" EXT-GYP. OVER SHEATHING OVER MTL. STUDS FRAMING, REF. SECTIONS AND SPECS.
 - CABLE STRING, REF. SPECS.
 - TRELLIS FRAME, BENT STEEL PLATE, REF. DETAILS AND SPECS. PAINT
 - CURVED STEEL TRUSSES, ABOVE, PAINTED. REF. STRUCT. DWGS.
 - MTL. DECK, ABOVE, PAINTED. REF. STRUCT. DWGS.
 - MTL. ROOF FASCIA, REF. DTL.
 - STEEL BEAM FOR ROOF SUPPORT, PAINT. REF. STRUCT. DWGS.
 - ROOF HATCH WITH LADDER, SEE DETAIL 6/GA-9.2
 - SKYLIGHT. SEE ROOF PLAN & SECTIONS, REF. DETAILS.
 - 5/8" TYPE "X" GB CEILING, PAINTED, SEE DETAIL 4/GA-9.6 TYP.
 - LINE OF DESK BELOW, SEE FLOOR PLAN.
 - FRAMED COLUMN CHASE, NO CEILING.
 - LIGHT FIXTURES. REF. ELEC. DWGS.

- GENERAL NOTES**
- ALL HEIGHTS SHOWN ARE FROM BUILDING TOP OF SLAB. (ELEV. OF 100'-0")
 - PROVIDE COMPLETE SHOP DRAWINGS FOR STEEL TRELLIS & CABLES, SHOWING ALL CONNECTIONS, SIZES AND SUPPORT DETAILS AS REQUIRED BY DRAWINGS & SPECS. CONTRACTOR SHALL OUTLINE TRELLIS SHAPE ON FLOOR SLAB & OBTAIN ARCHITECT APPROVAL PRIOR TO FABRICATION.
 - SEE DETAIL 2/GA-9.6 FOR DIAGONAL CLG. BRACING AT "LAY-IN" CLG.

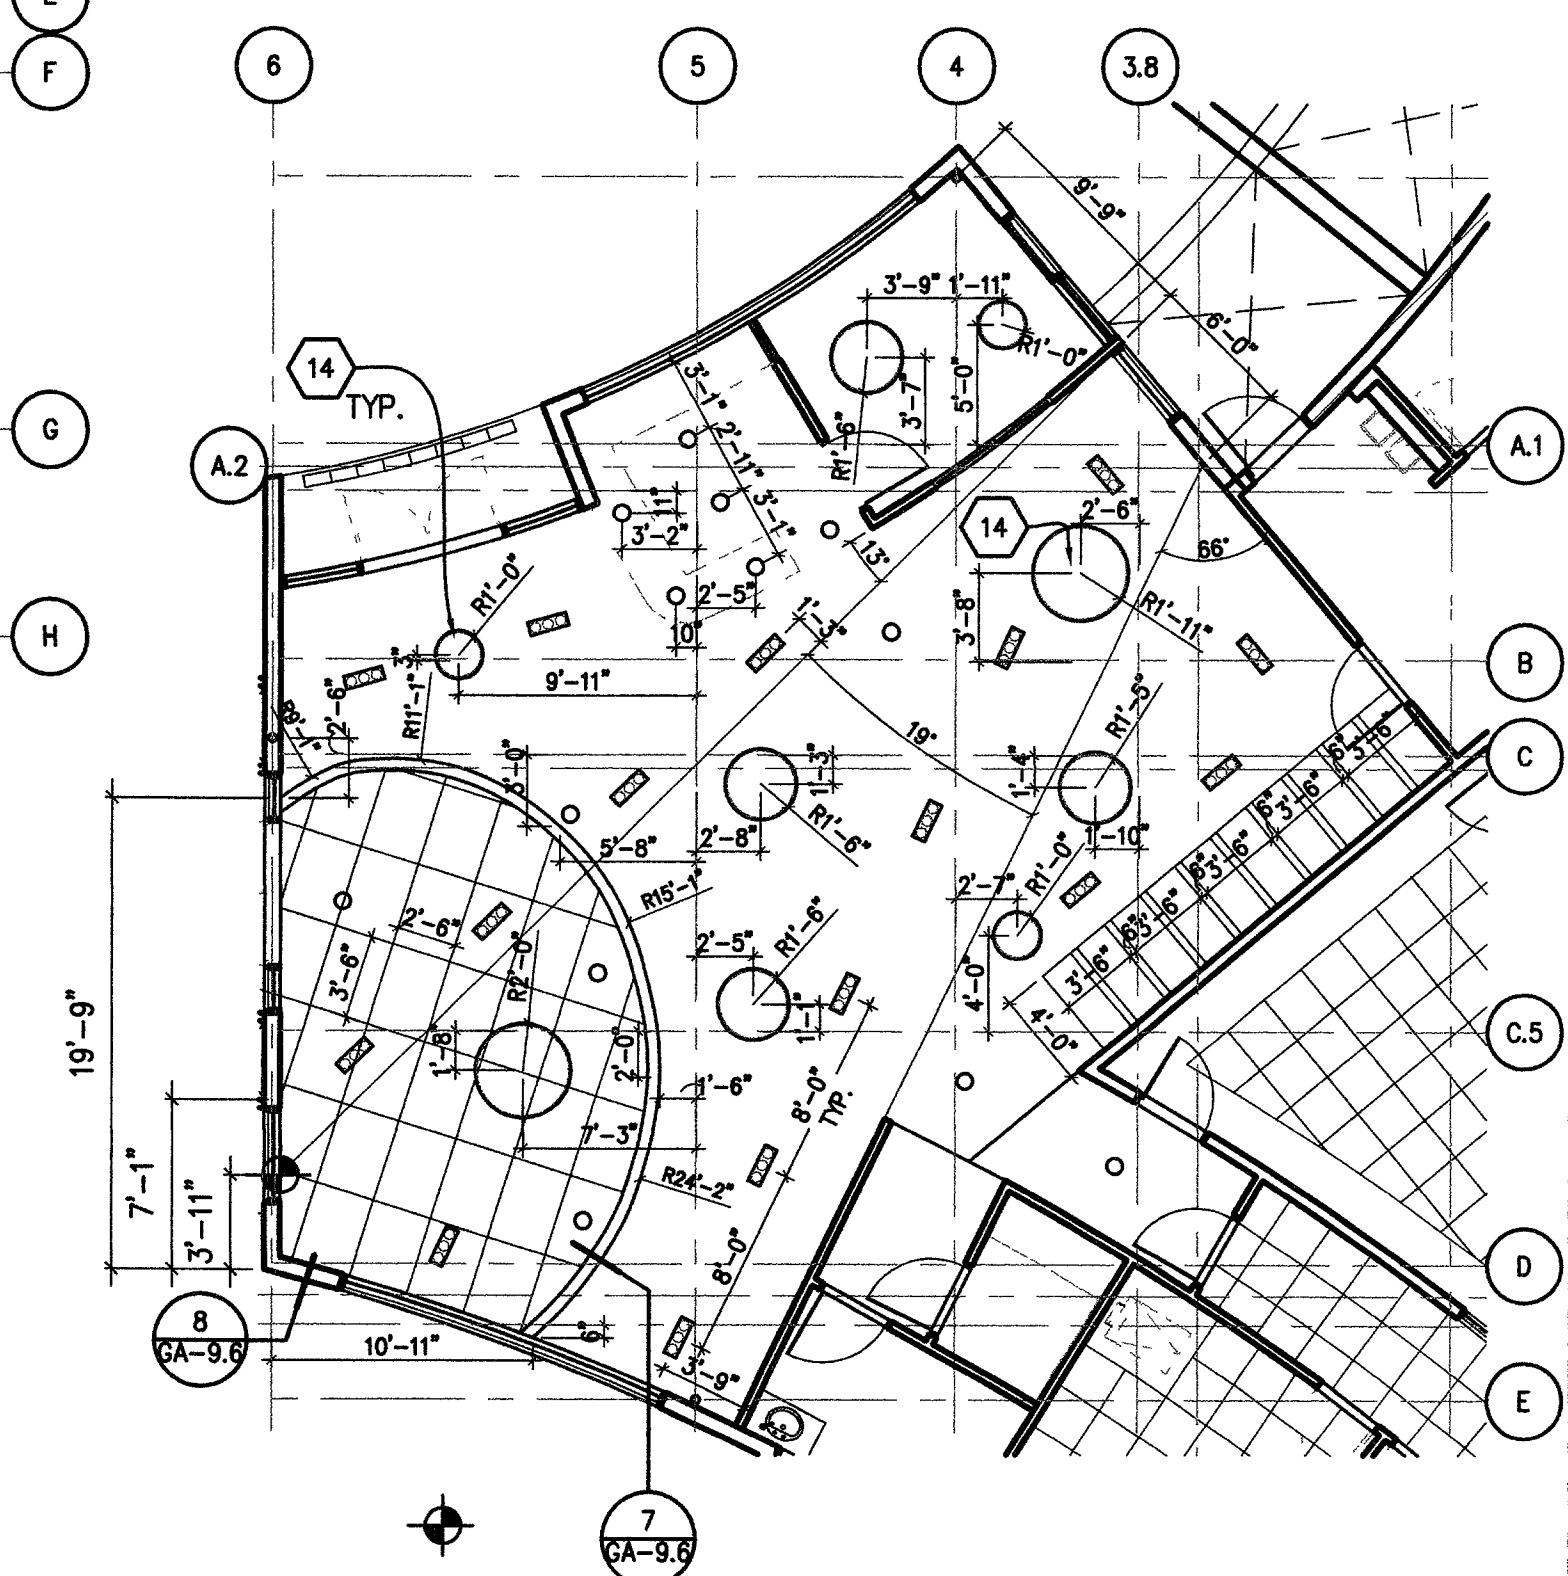

2 PRO-SHOP ROOM CLG. DIM. PLAN
SCALE: 1/8" = 1'-0"



REVISIONS

NO.	DESCRIPTION
1	4" WIDE SOFFIT VENT.
2	7/8" STUCCO SYSTEM SOFFIT OVER 5/8" EXT-GYP. OVER SHEATHING OVER MTL. STUDS FRAMING, REF. SECTIONS AND SPECS.
3	CABLE STRING, REF. SPECS.
4	TRELLIS FRAME, BENT STEEL PLATE, REF. DETAILS AND SPECS. PAINT
5	CURVED STEEL TRUSSES, ABOVE, PAINTED. REF. STRUCT. DWGS.
6	MTL. DECK, ABOVE, PAINTED. REF. STRUCT. DWGS.
7	MTL. ROOF FASCIA, REF. DTL.
8	STEEL BEAM FOR ROOF SUPPORT, PAINT. REF. STRUCT. DWGS.
9	ROOF HATCH WITH LADDER, SEE DETAIL 6/GA-9.2
10	SKYLIGHT. SEE ROOF PLAN & SECTIONS, REF. DETAILS.
11	5/8" TYPE "X" GB CEILING, PAINTED, SEE DETAIL 4/GA-9.6 TYP.
12	LINE OF DESK BELOW, SEE FLOOR PLAN.
13	FRAMED COLUMN CHASE, NO CEILING.
14	LIGHT FIXTURES. REF. ELEC. DWGS.

CONSULTANT

CDA
CREATIVE DESIGN ARCHITECTURE
ARCHITECTURE PLANNING CONSULTING
2229 Maple Rose Dr. Las Vegas, NV 89134 Tel. (702) 256-6663

OWNER: CITY OF LAS VEGAS
DEPARTMENT OF PUBLIC WORKS
ARCHITECTURAL SERVICES

400 EAST STEWART AVENUE
LAS VEGAS, NEVADA 89101
PHONE: (702) 229-6535
FAX: (702) 382-3232
TDD: (702) 386-9108

DRAWN: JL
FILE: PA-22
DATE: July-2003
SCALE: 1/8" = 1'-0"
BID NO: 03.1534/08
CLV DWG NO: 650.16-1A

PA-2.2

79317