
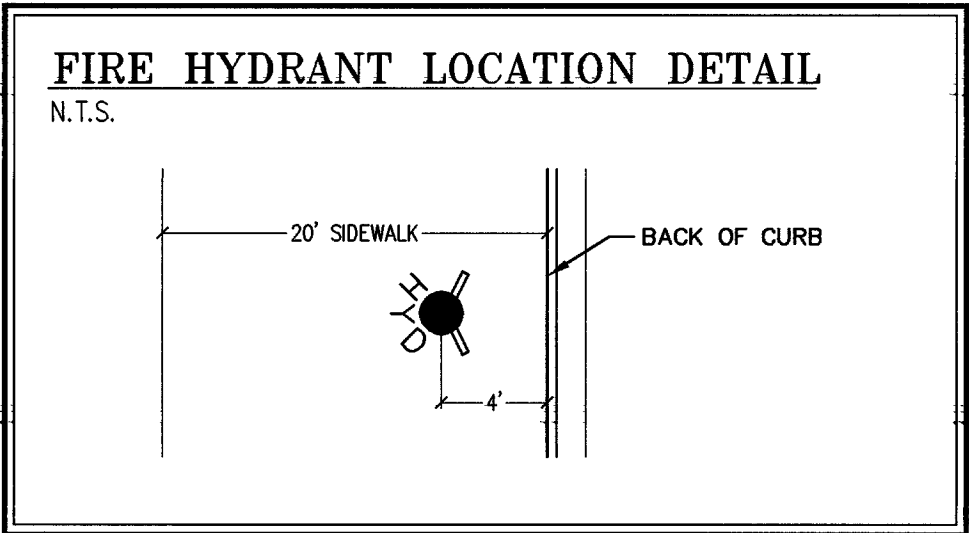
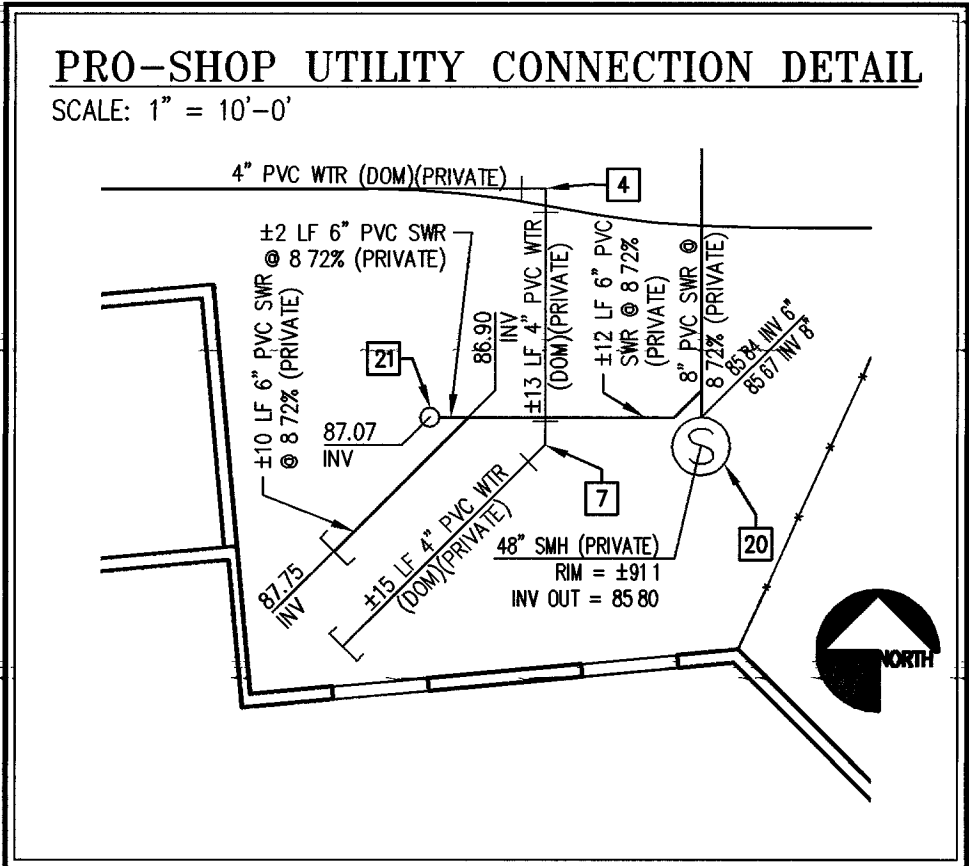
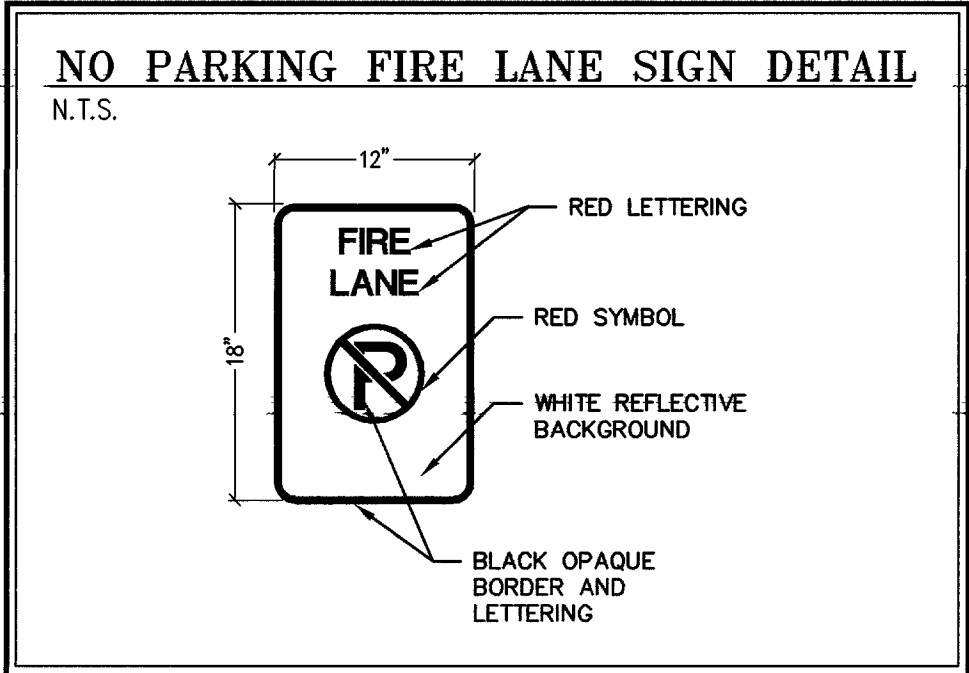
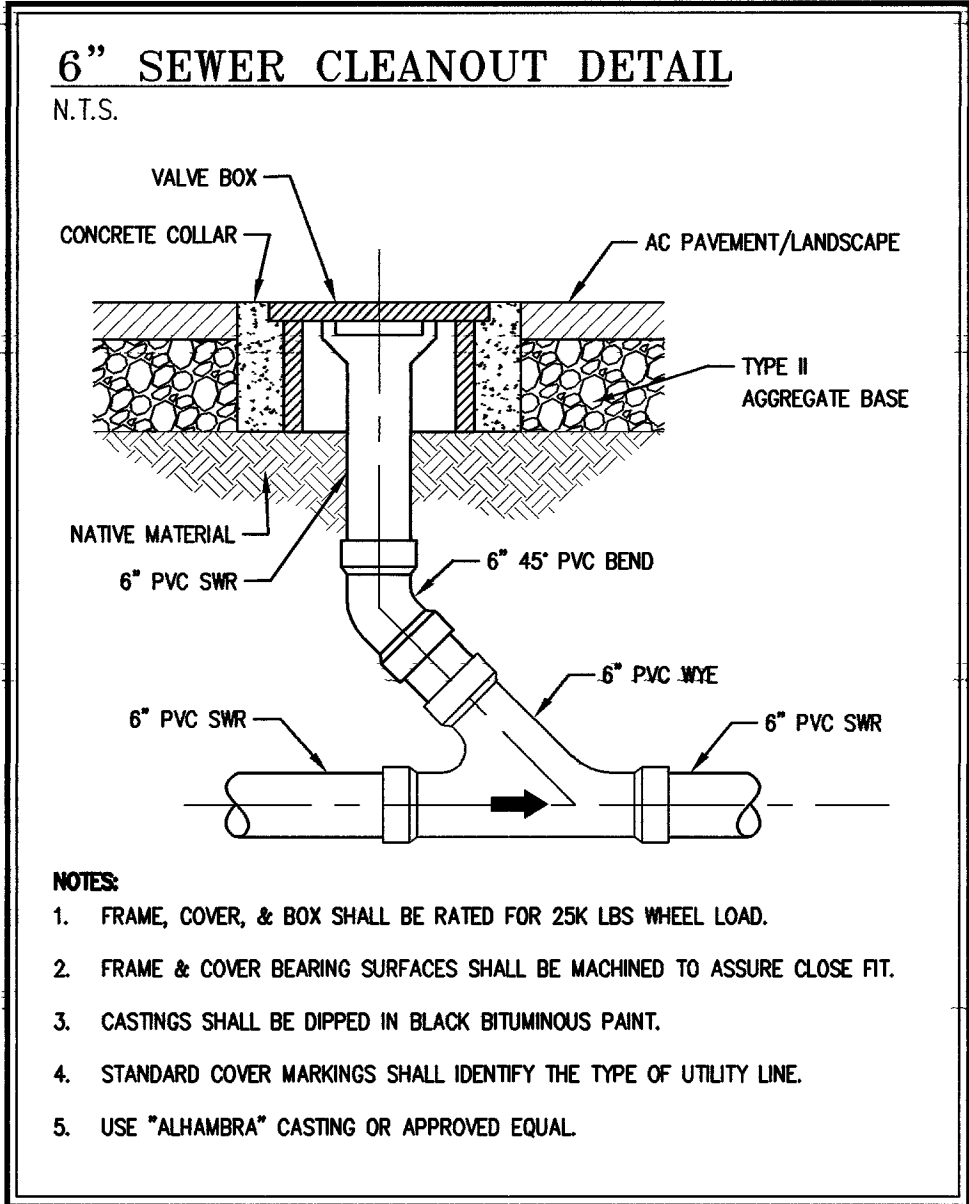
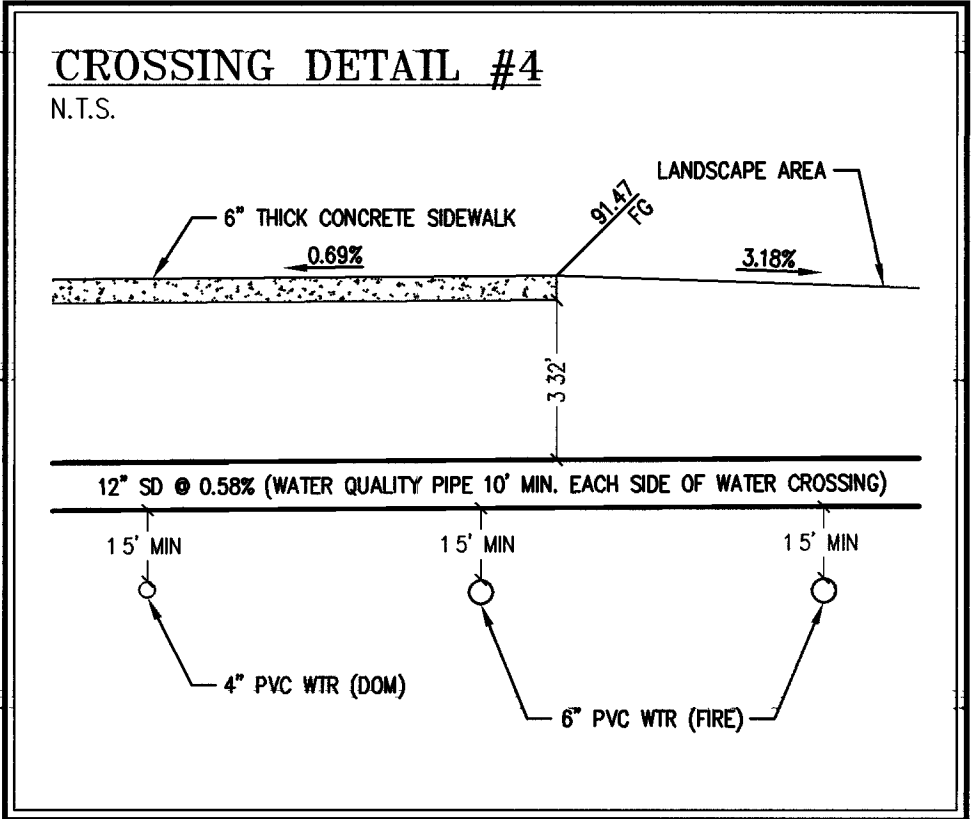
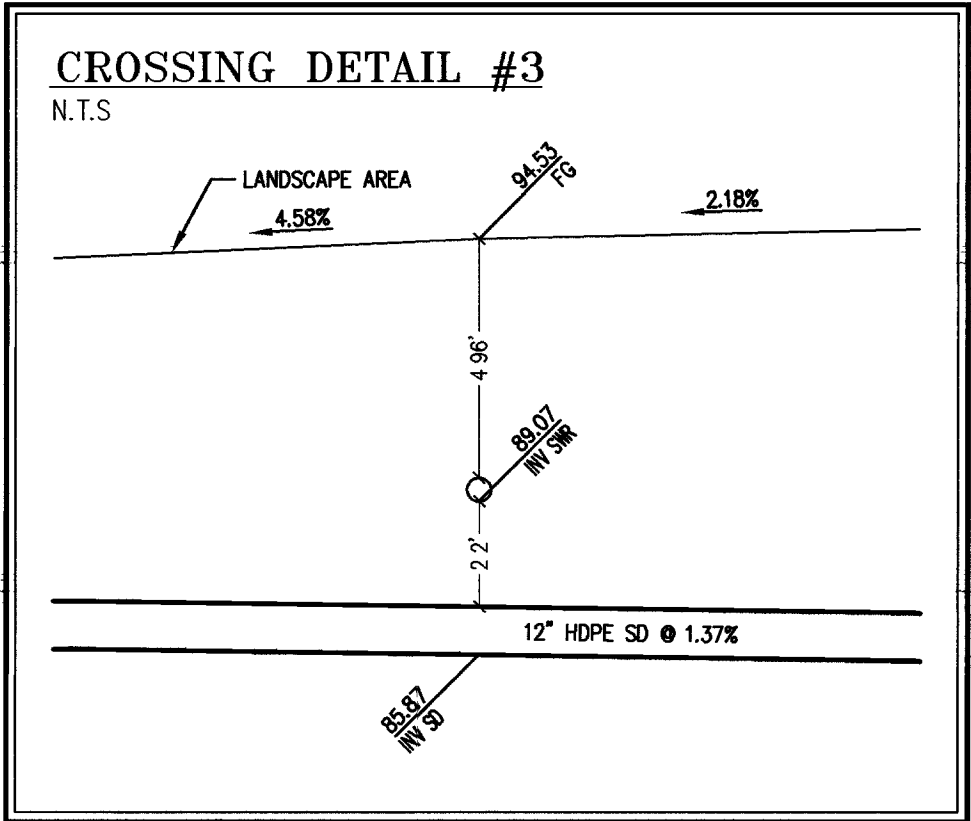
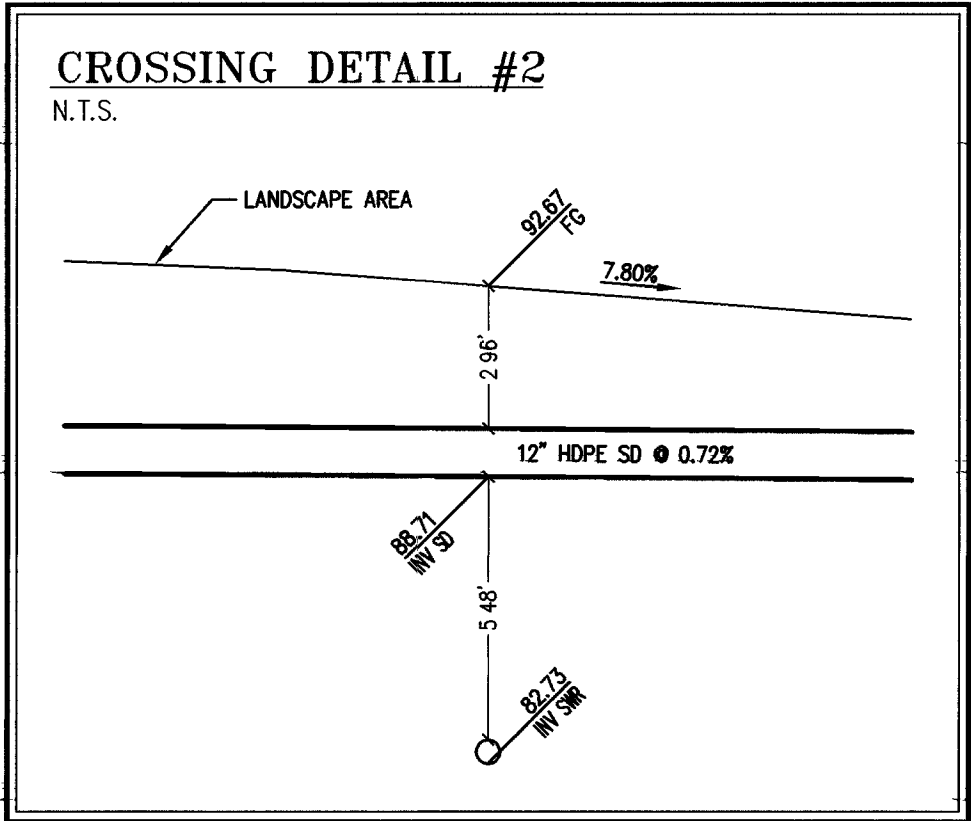


96945

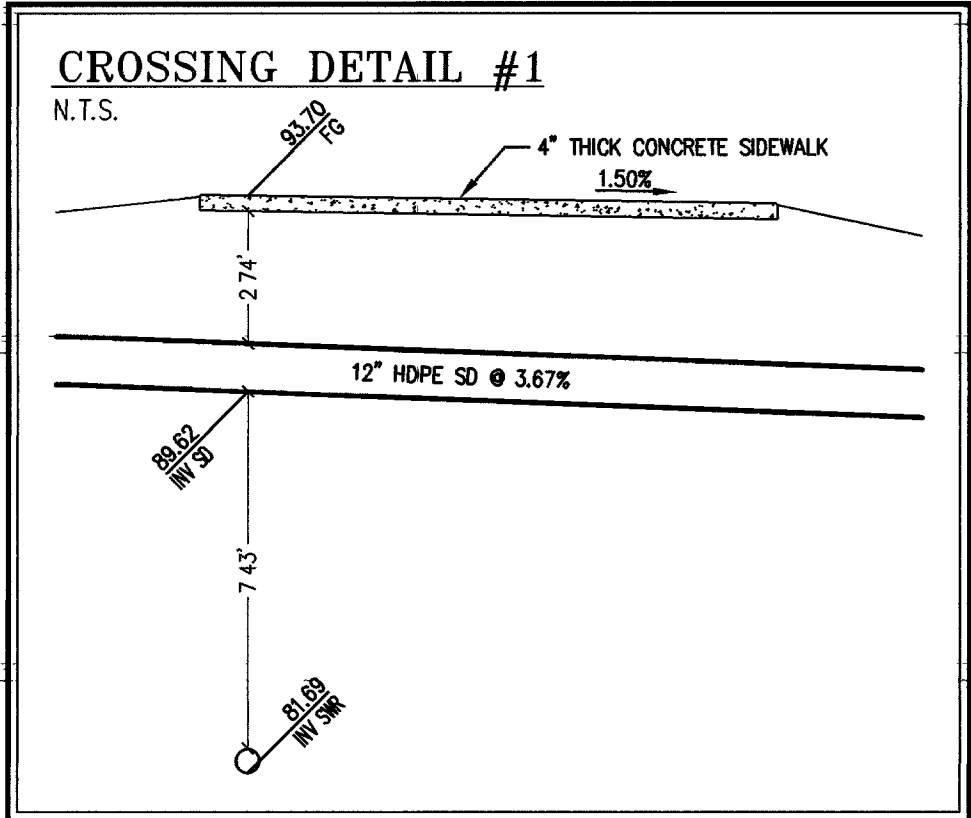

Avoid cutting underground utility lines - It's costly

Call before you Dig

1-800-227-2600
UNDERGROUND SERVICE ALERT (USA)

Avoid overhead power line contact

Call before you OVERHEAD

1-702-227-2929
NEVADA POWER ENVIRONMENT & SAFETY SERVICES DEPARTMENT

APPROVED FOR CONSTRUCTION

LAS VEGAS FIRE DEPARTMENT _____ DATE _____

NO DISTRICT FACILITIES
LAS VEGAS VALLEY WATER DISTRICT _____ DATE _____

CITY OF LAS VEGAS
NEVADA

REVISIONS

CONSULTANT

7251 W CHARLESTON BLVD
LAS VEGAS, NEVADA 89117
PHONE (702) 258-0115
FAX (702) 869-8547

stantec

WASHINGTON BUFFALO PARK - PHASE 1A
WASHINGTON & BUFFALO, LAS VEGAS, NV

UTILITY DETAILS

OWNER: CITY OF LAS VEGAS
DEPARTMENT OF PUBLIC WORKS
ARCHITECTURAL SERVICES

400 EAST STEWART AVENUE
LAS VEGAS, NEVADA 89101
PHONE: (702) 229-6535
FAX: (702) 382-3232
TDD: (702) 386-9108

DRAWN: M. GRIMES
FILE: Utility Plan.dwg
DATE: 7/03
SCALE: NTS
SHEET NO: 03.15341.00
CLV DWG NO: 65076-1A
SHEET NO: 100% SUBMITTAL
C14

DRAWINGS AS INSTRUMENTS OF SERVICE ARE THE PROPERTY OF THE DESIGN PROFESSIONAL WHOSE STAMP OF CERTIFICATION APPEARS ON THE DRAWINGS AND SPECIFICATIONS RETAINED BY THE CLIENT. THEY ARE NOT TO BE REPRODUCED OR USED FOR ANY OTHER PROJECT WITHOUT THE WRITTEN CONSENT OF THE DESIGN PROFESSIONAL. ANY REPRODUCTION IN WHOLE OR IN PART WITHOUT WRITTEN CONSENT IS STRICTLY PROHIBITED. COPIES OF THE DRAWINGS AND SPECIFICATIONS RETAINED BY THE CLIENT MAY BE UTILIZED ONLY FOR OCCUPANCY OF THE PROJECT FOR WHICH THEY WERE PREPARED AND NOT FOR THE CONSTRUCTION OF ANY OTHER PROJECT. N.E.C. 853.192