

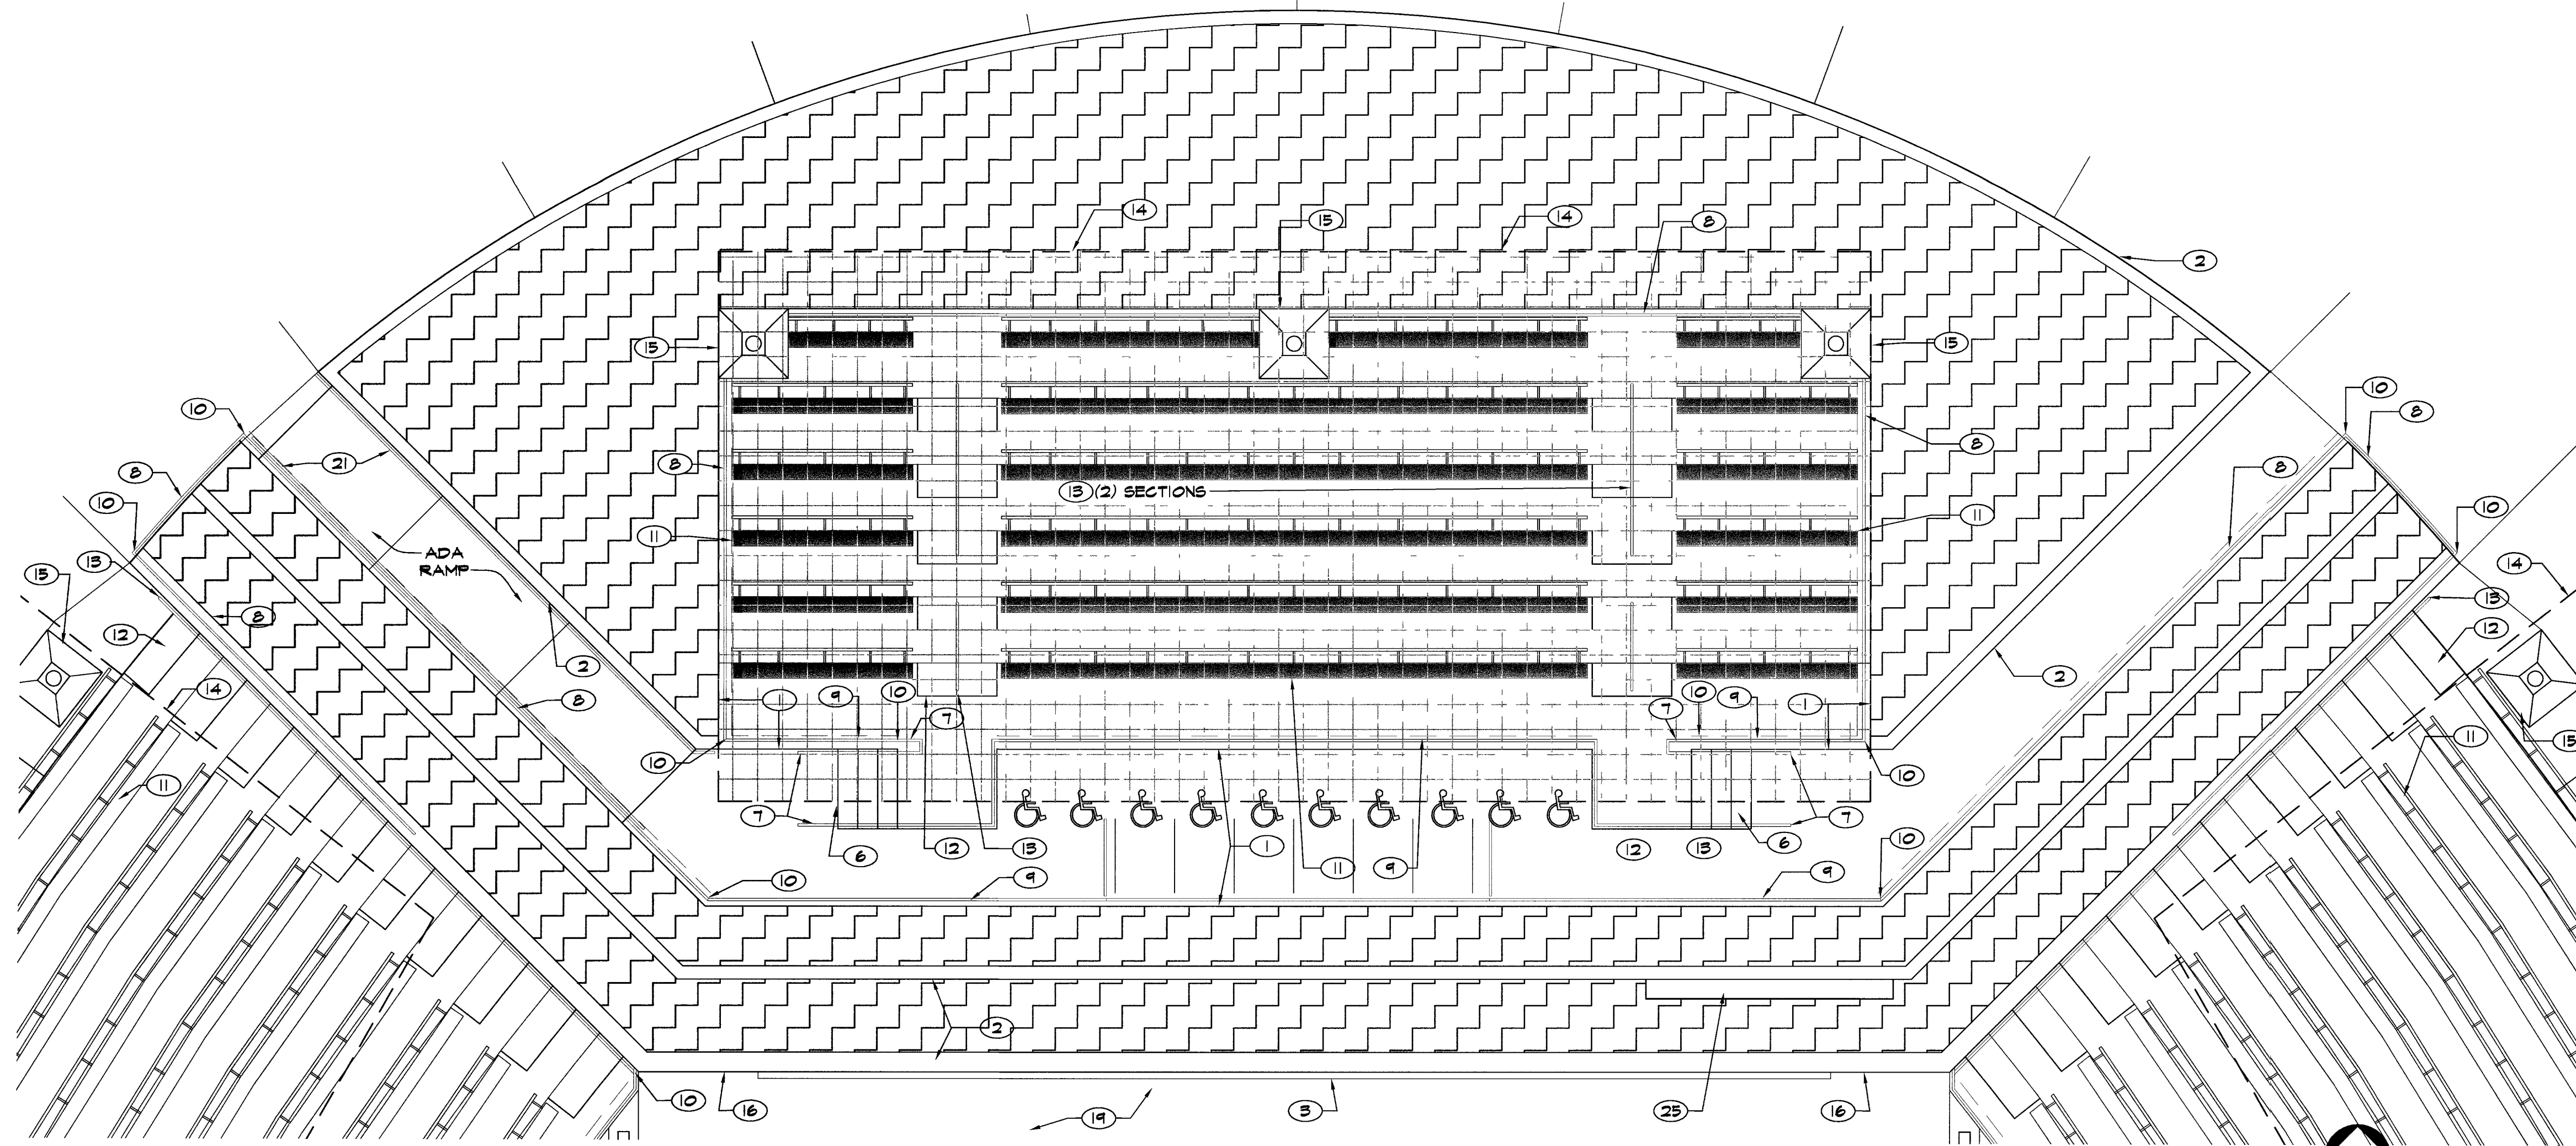
 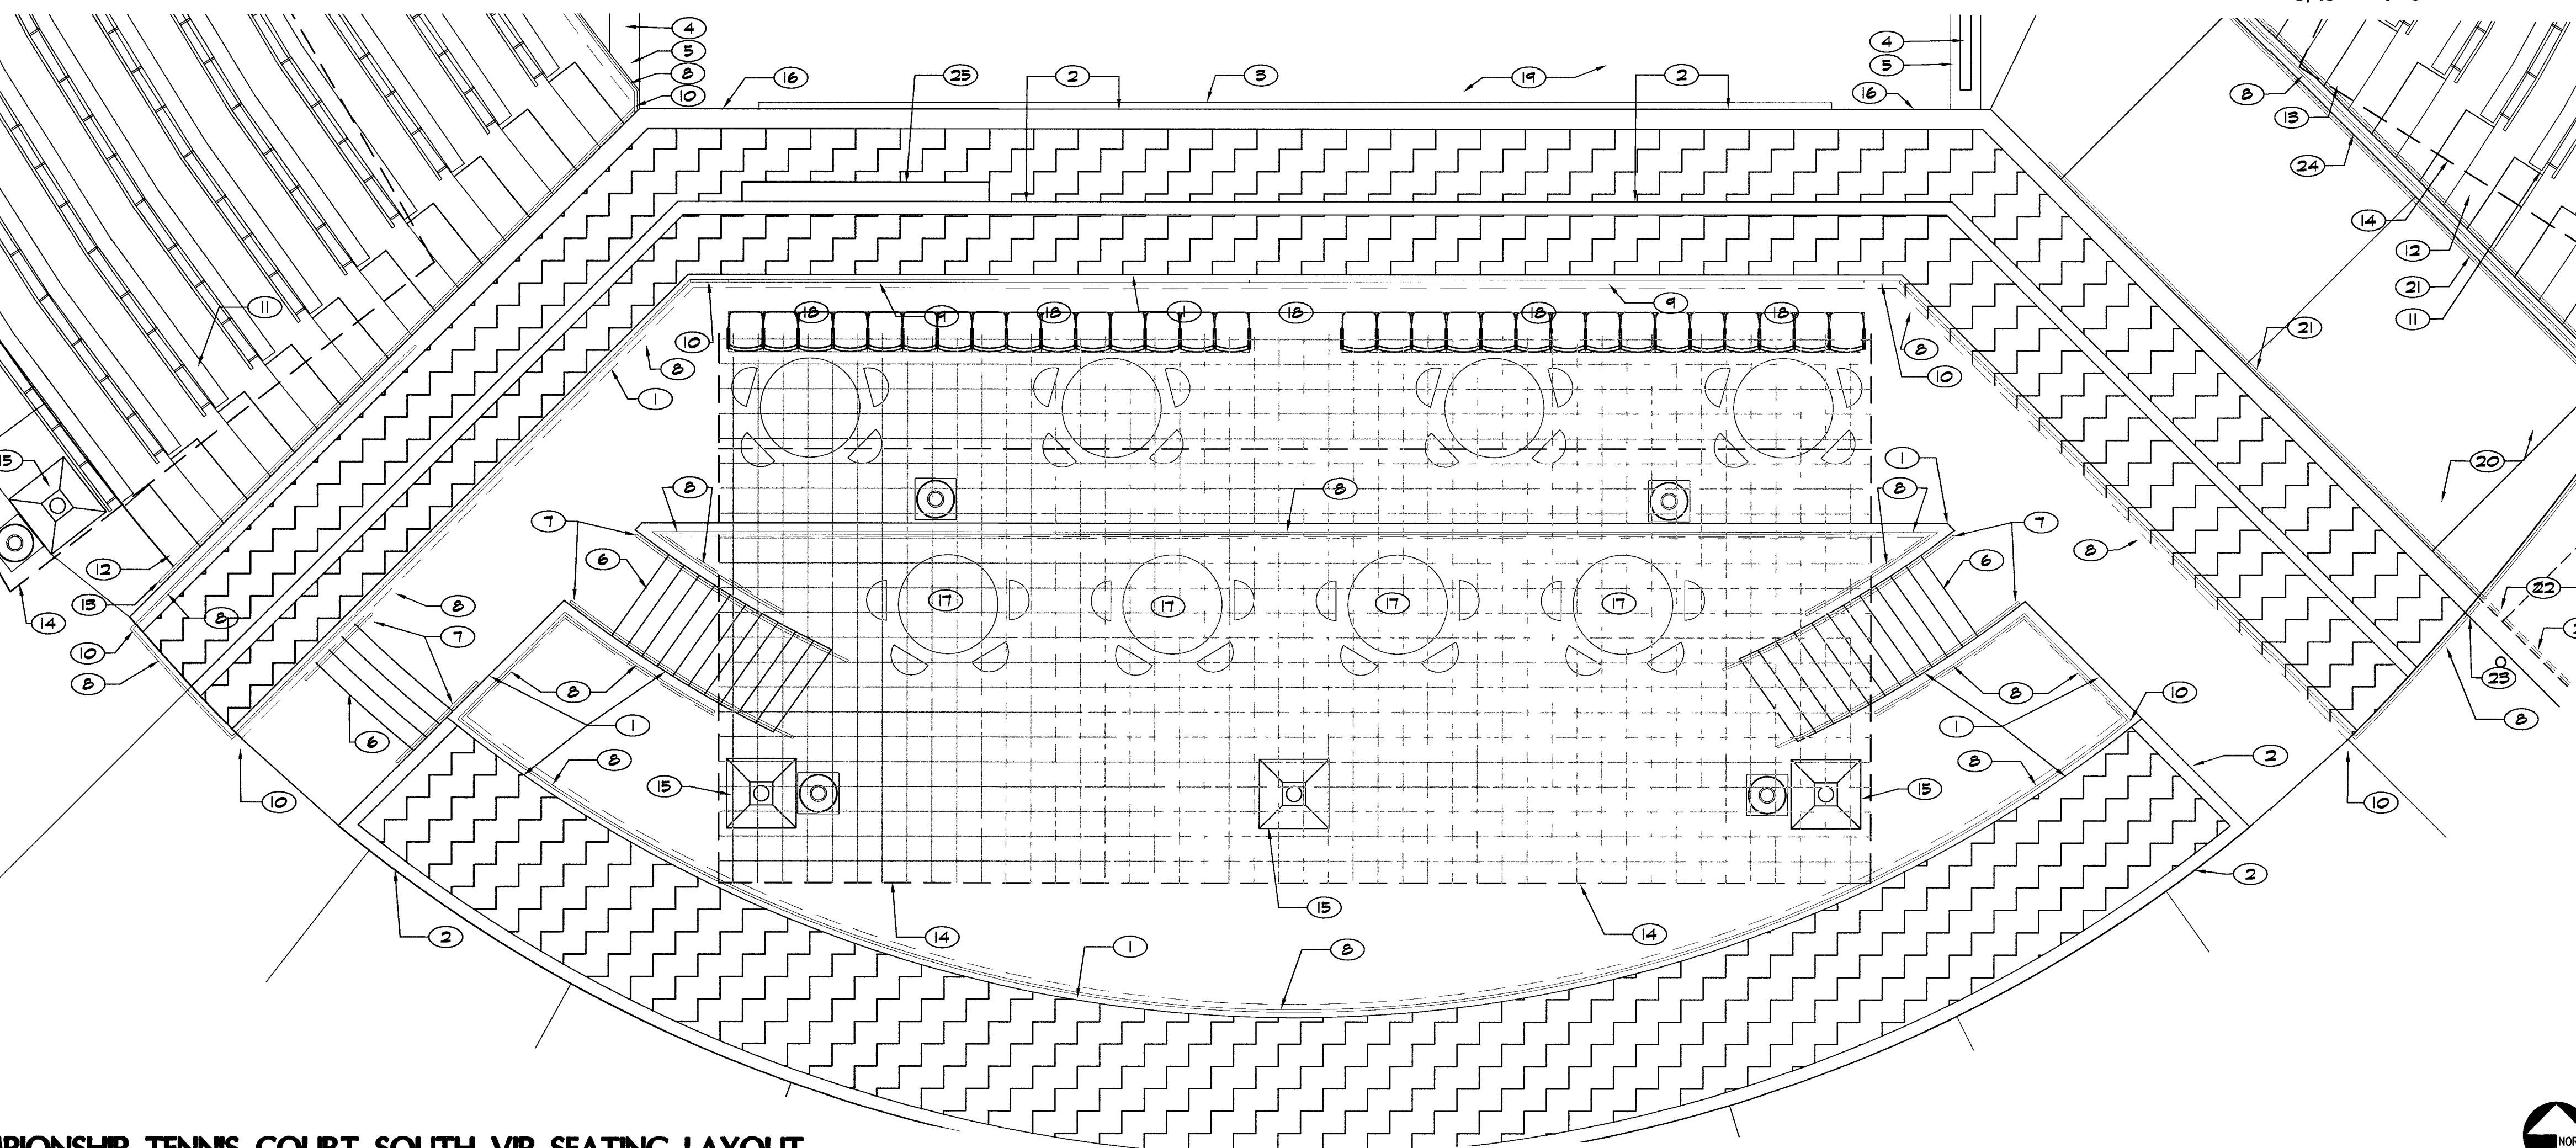
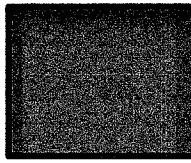



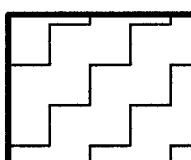

1 CHAMPIONSHIP TENNIS COURT NORTH SEATING LAYOUT

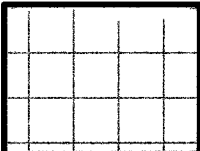

2 CHAMPIONSHIP TENNIS COURT SOUTH VIP SEATING LAYOUT

LEGEND			
SYMBOL	DESCRIPTION	SYMBOL	DESCRIPTION
	BLEACHERS SEE SPECS 13125		CONCRETE MEDIUM BROOM FINISH
	LANDSCAPE PLANTERS		SHADE TRELLIS SEE ALSO SPECS SECTION 13015
NO	DESCRIPTION	DETAIL & SHEET REFERENCE	
1	OUTSIDE FACE OF POURED-IN-PLACE CONCRETE WALL, WITH THICKENED CONCRETE EDGE OF SLAB ON TOP OF WALL.	3	SD-9
2	POURED-IN-PLACE CONCRETE PLANTER WALL	3	SD-9
3	TENNIS COURT PAD - SEE SPECS SECTION 02865	-	C14
4	TRENCH DRAIN - SEE CIVIL PLANS.		
5	CONCRETE ENCASEMENT AS SHOWN AROUND DRAINAGE TRENCH SHALL BE 4500 P.S.I. @ 28 DAY CURE - SEE CIVIL PLANS. CONCRETE SURROUNDING THE TRENCH DRAIN SHALL SLOPE TOWARDS THE DRAIN AT 1%, AND NO WATER FONDINGS SHALL OCCUR NEXT TO THE CMU WALL, OR ANY OTHER LOCATION.	3	SD-11
6	CONCRETE STEPS	3	SD-11
7	HAND RAIL AT STEPS	3	SD-11
8	GUARD RAIL	1	SD-11
9	SAFETY RAIL	4	SD-11
10	WELD RAILS TOGETHER AT THEIR MERGING POINTS. PROVIDE DETAILING ON SHOP DRAWINGS.	5	SD-23
11	BLEACHER SEAT (TYPICAL)	3	SD-10
12	CONCRETE STEP AT SPECTATOR SEATING AREA	1:7	SD-12
13	HAND RAIL AT SPECTATOR BLEACHER SEATING	6	SD-12
14	SHADE TRELLIS WITH FABRIC ADDITIVE ALTERNATE #2	7:10	SD-11
15	SHADE TRELLIS COLUMN ADDITIVE ALTERNATE #2		
16	RAISED CONCRETE TENNIS FIGURE	1:2	SD-19, SD-21
17	V.I.P. BAR TABLE WITH (4) CHAIRS - SEE SPECS SECTION 02870	3	SD-19
18	V.I.P. STD. TABLE WITH (4) CHAIRS (NO UMBRELLA) - SEE SPECS SECTION 02870		
19	TENNIS COURT SURFACE - SEE SPECS SECTION 02796	1:2	SD-19, SD-21
20	ADA / VEHICULAR RAMP W/ 6" REINFORCED CONCRETE PAVEMENT		
21	RAMP HAND RAIL	3	SD-19
22	PEDESTRIAN BRIDGE SEE STRUCTURAL PLANS		
23	DO NOT WELD TOGETHER RAILINGS @ CORNERS OF BRIDGE, THESE SHALL BE INDEPENDENT RAILINGS MAX. GAP: 3 1/2"	1-2	SD-19, 21
24	RAMP WALL		
25	SCOREBOARD ABOVE - SEE SPECS. SECTION 16705. SEE ALSO ELECTRICAL PLANS.		



REVISIONS

CONSULTANT

7251 W CHARLESTON BLVD
LAS VEGAS, NEVADA 89117
PHONE (702) 258-0115
FAX (702) 258-4956

WASHINGTON BUFFALO PARK - PHASE 1A
WASHINGTON & BUFFALO, LAS VEGAS, NV

SITE DETAILS

STAMP
RECORD DOCUMENTS ARE PREPARED
FROM DATA AND INFORMATION
SUPPLIED BY OTHERS. STANTEC
CONSULTING, INC. DOES NOT CERTIFY,
NOR WARRANT IN ANY MANNER, THE
ACCURACY OR COMPLETENESS OF
RECORD DOCUMENTS. STANTEC
CONSULTING, INC. ADVISES ANYONE
USING RECORD DOCUMENTS, FOR ANY
PURPOSE, TO INDEPENDENTLY VERIFY
THE ACCURACY OR COMPLETENESS OF
THE INFORMATION PRESENTED, AND
TO VERIFY THE SUITABILITY OF THE
INFORMATION FOR THE PURPOSE FOR
WHICH THEY INTEND TO USE THE
INFORMATION. STANTEC CONSULTING,
INC. SHALL NOT BE RESPONSIBLE
FOR ANY PROBLEMS, DISCREPANCIES
OR RELATED COSTS THAT MAY ARISE
OUT OF THE USE OF RECORD
DOCUMENTS.

OWNER: CITY OF LAS VEGAS
DEPARTMENT OF PUBLIC WORKS
ARCHITECTURAL SERVICES

400 EAST STEWART AVENUE
LAS VEGAS, NEVADA 89101
PHONE: (702) 229-8535
FAX: (702) 382-5232
TDD: (702) 386-6108

DRAWN: KIC
FILE: 216-95-00 Aug
DATE: 7/03
SCALE: 3/16" = 1'
PID NO: 03.1341.00
CLV DWG NO: 65076-1A
SIT NO: 100% SUBMITTAL

SD-8

RECORD DRAWING (01/19/06)

DESIGNS & INSTRUMENTS OF SERVICE ARE THE PROPERTY OF THE DESIGN PROFESSIONAL. NOISE STAMP OF CERTIFICATION APPEARS ON THE DRAWING AND SPECIFICATIONS. NOISE STAMP OF REPRODUCTION IN WHOLE OR IN PART WITHOUT WRITTEN CONSENT IS STRICTLY PROHIBITED. COPIES OF THE DRAWINGS AND SPECIFICATIONS RETURNED BY THE CLIENT MAY BE UTILIZED ONLY FOR OCCUPANCY OF THE PROJECT FOR WHICH THEY WERE PREPARED AND NOT FOR THE CONSTRUCTION OF ANY OTHER PROJECT. H & C 003 700