




- NOTE: 1. FLOWS TO THE EXISTING PLANTS MUST BE MAINTAINED DURING CONSTRUCTION OF THE BAR SCREEN STRUCTURE.
2. INSTALLATION OF BAR SCREENS TO BE COMPLETED PRIOR TO DEMOLITION OF EXISTING PLANT 1 AND 2 BAR SCREENS.
3. REMOVE EXIST INFLUENT SEWER PIPES AS REQUIRED.
4. CONTRACTOR TO APPLY COAL TAR DAMPROOFING AS DESCRIBED IN SPECIFICATIONS.

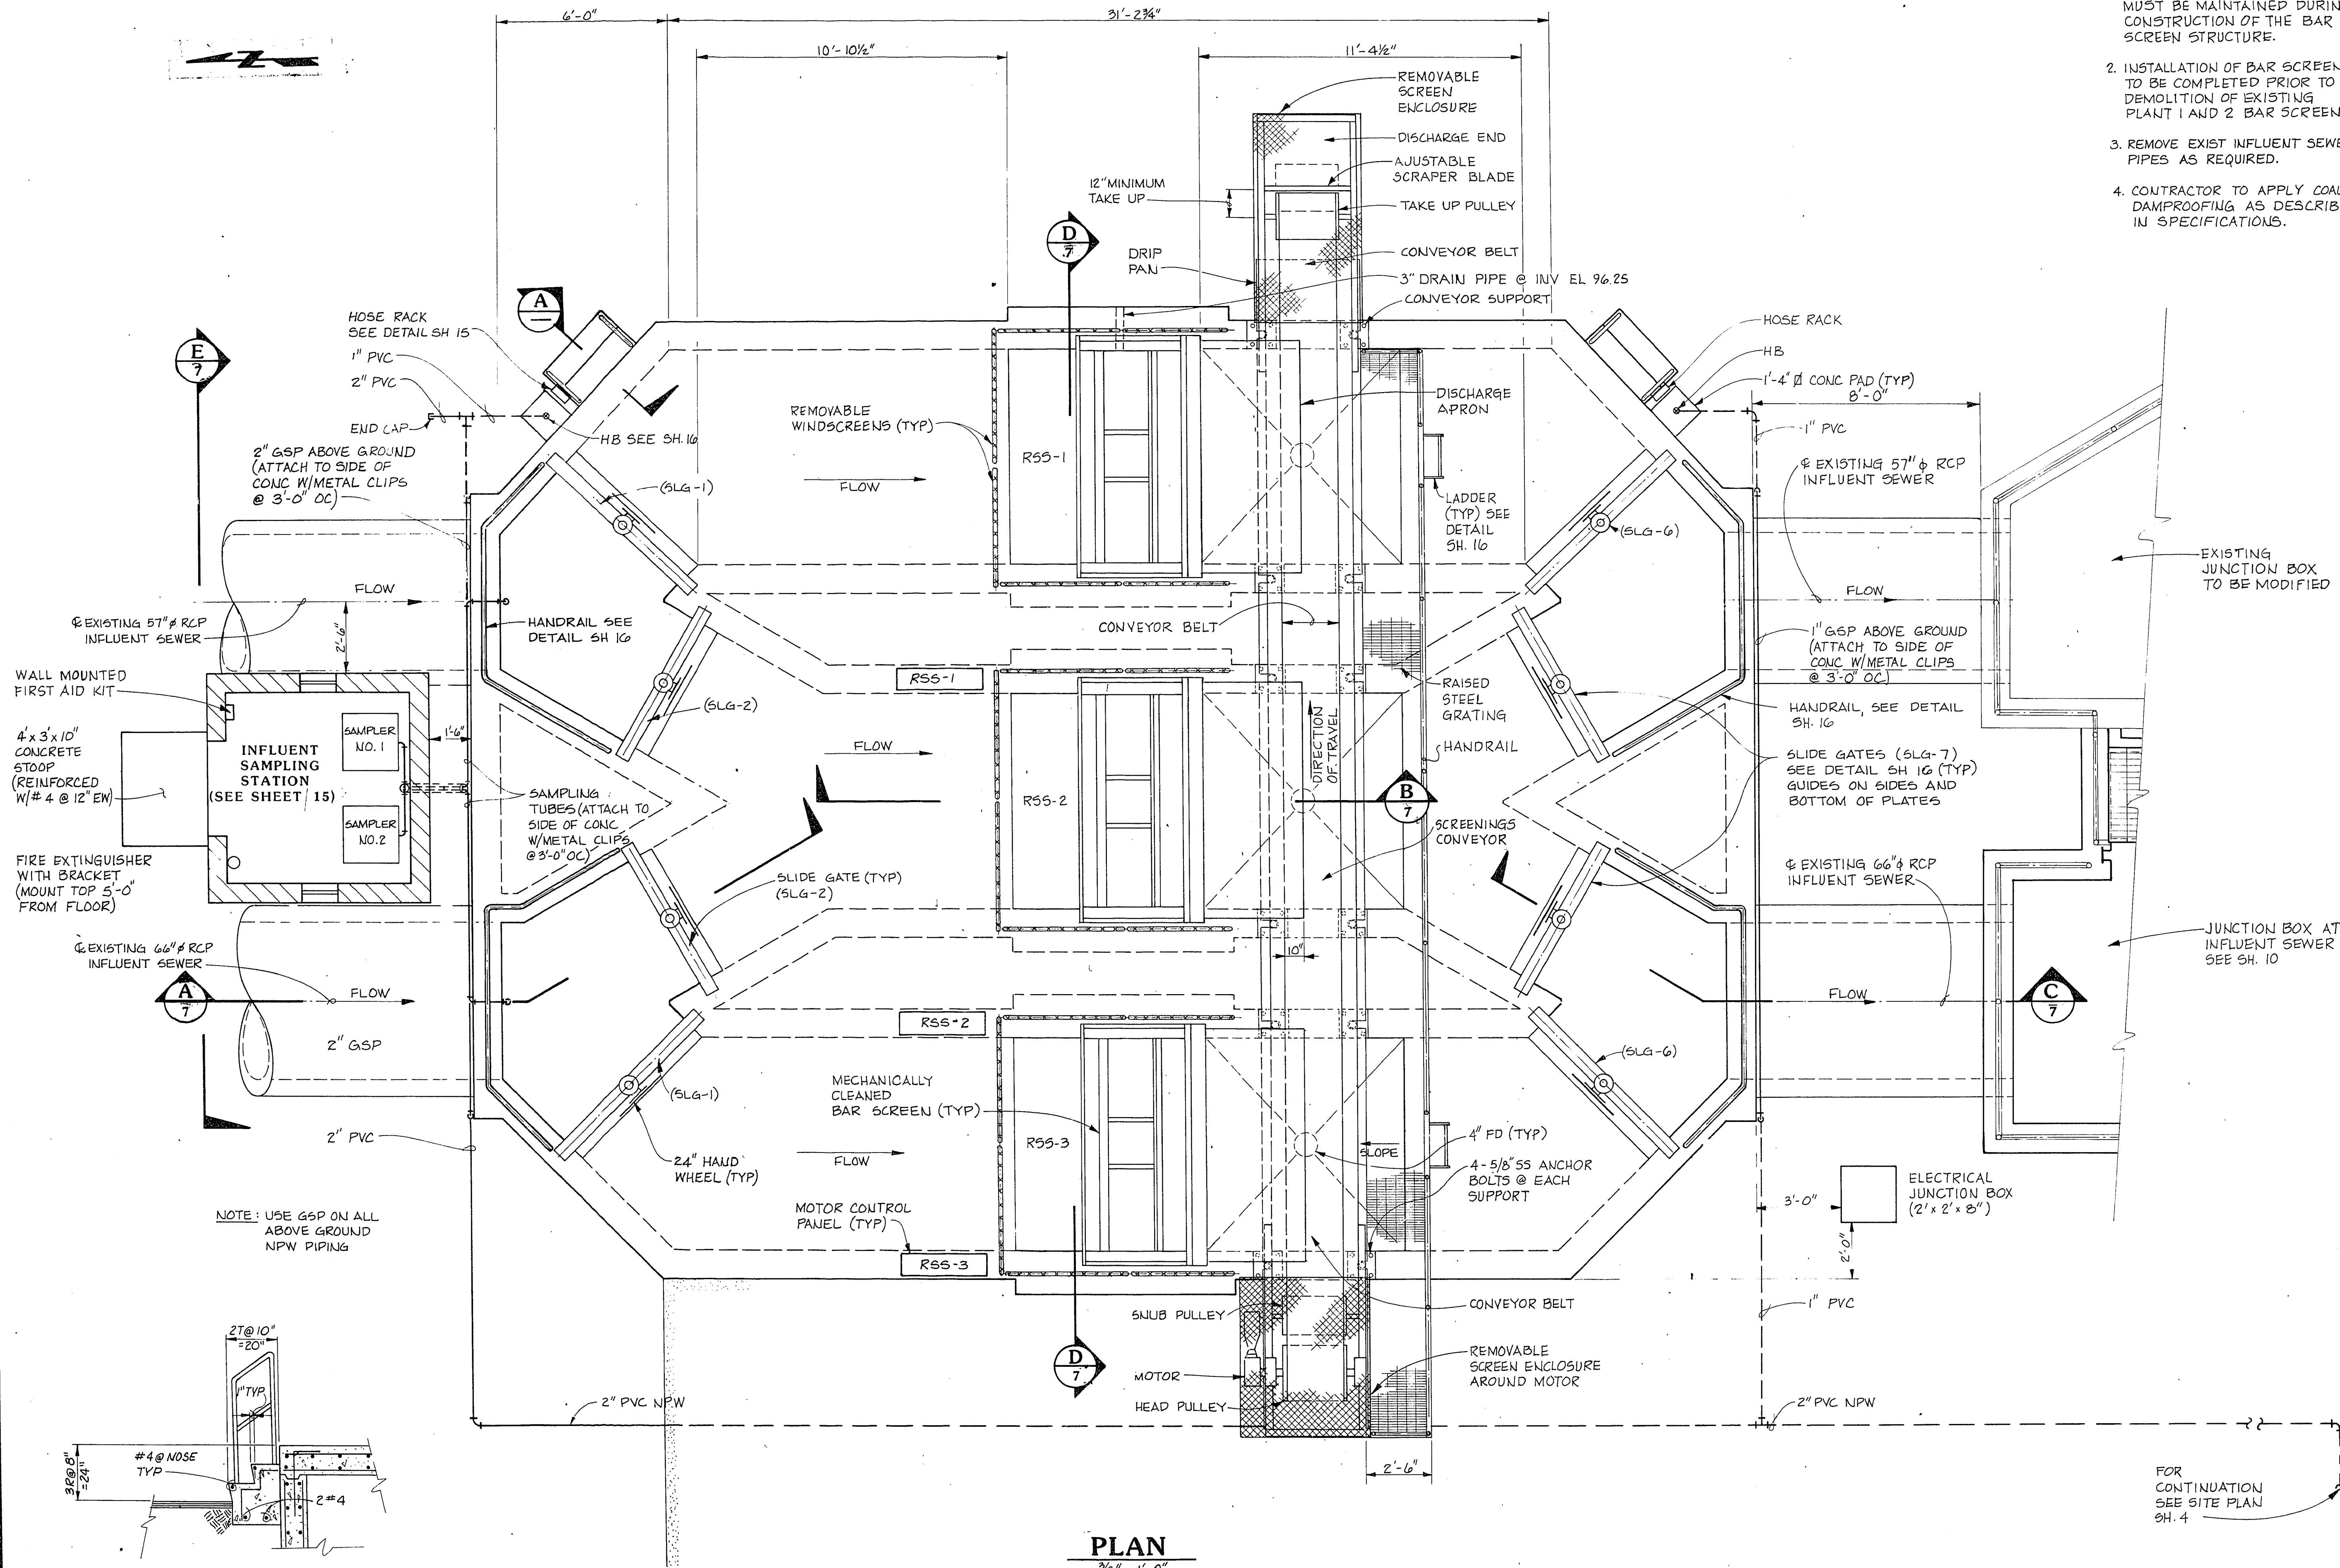


SECTION A
3/8" = 1'-0"

PLAN
3/8" = 1'-0"

FOR CONTINUATION
SEE SITE PLAN
SH. 4

CULP/WESNER/CULP
SANITARY ENGINEERS
SANTA ANA, CALIFORNIA

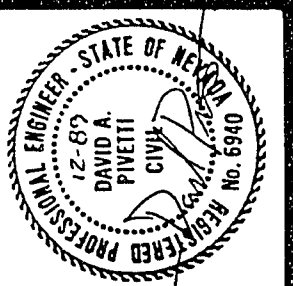

Job No. 10-19-41
Designed: DPC
Drawn: BWP
Checked: JAV
Approved: DAP
Date: 7-8-8

No.	By	Date	Revision Description

City of Las Vegas
WASTEWATER TREATMENT PLANT
NEW BAR SCREEN FACILITY AND
PLANT NO. 1 GRIT BASIN RENOVATION

BAR SCREENS -
MECHANICAL PLAN

Sheet
6
of

5-1-6 3/1/20