




NOTE: FIELD VERIFY DIMENSIONS &
LOCATION OF SPOOL PIECES

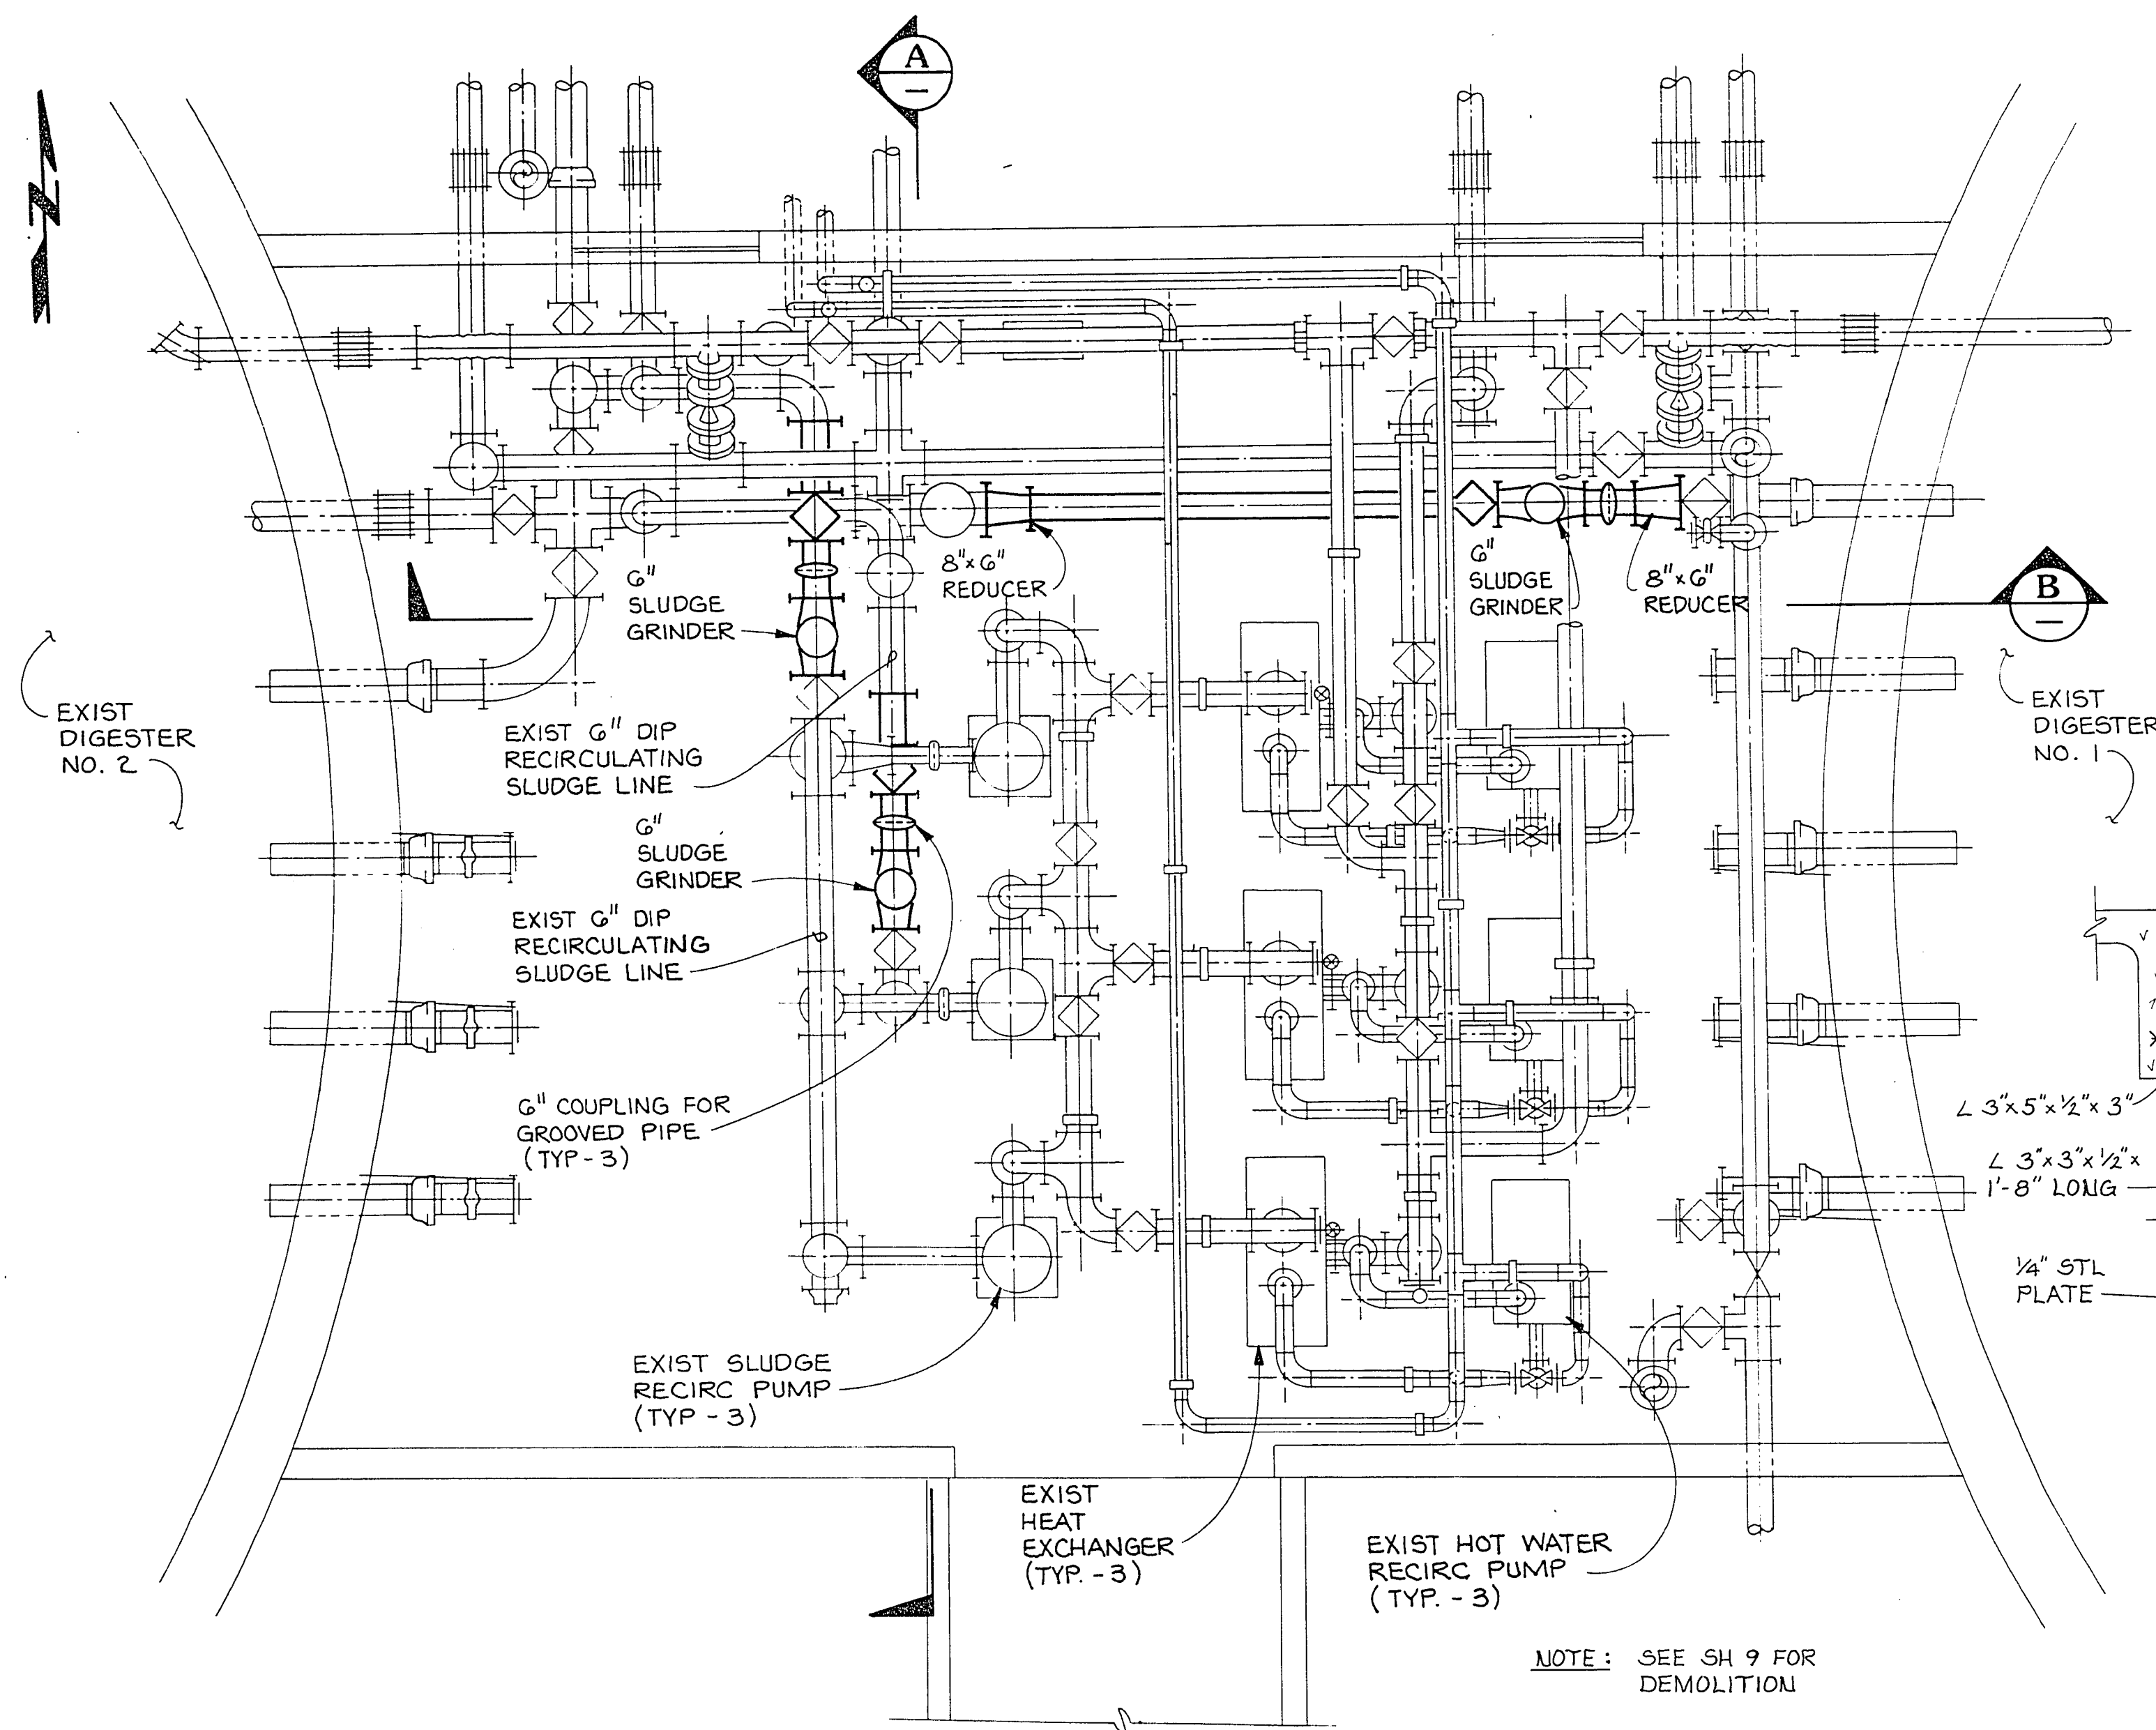


FLOOR PLAN
3/8" = 1' - 0"

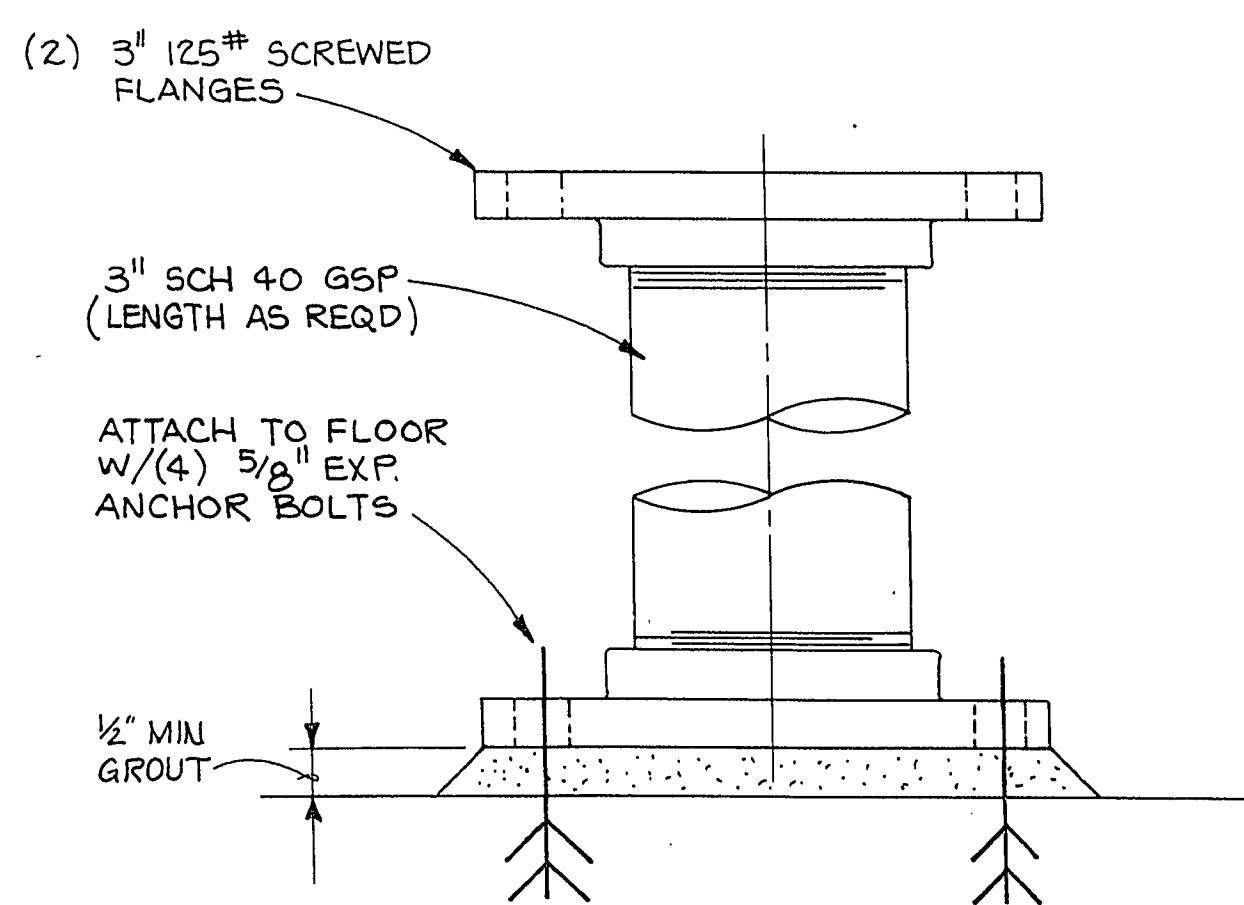

GS-1 SUPPORT DETAIL

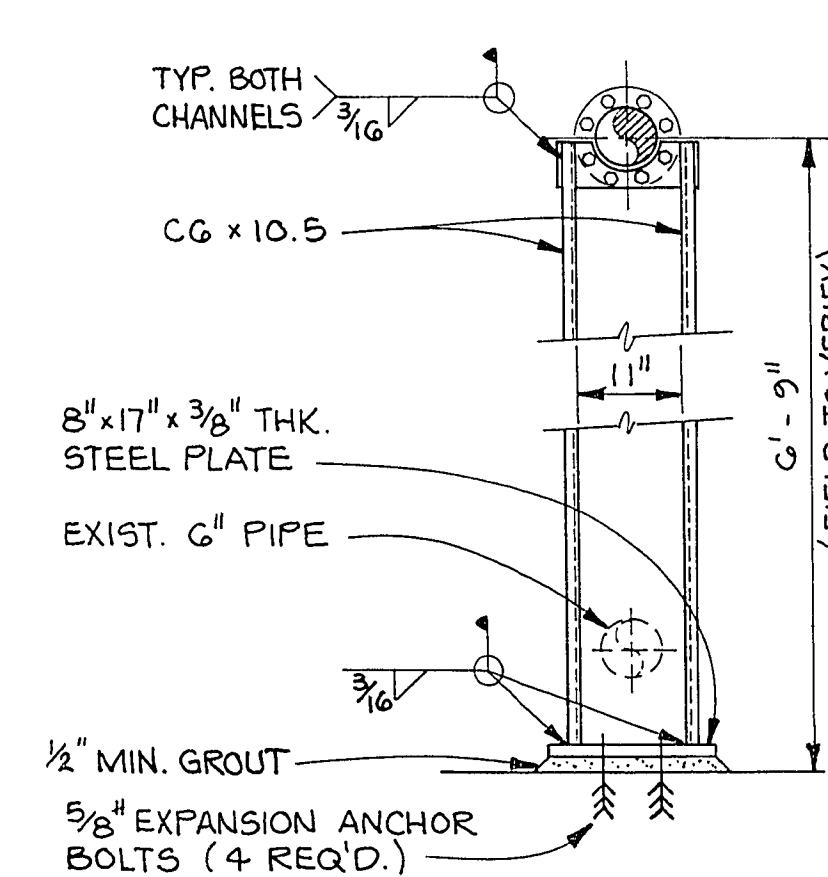


GS-2 SUPPORT DETAIL

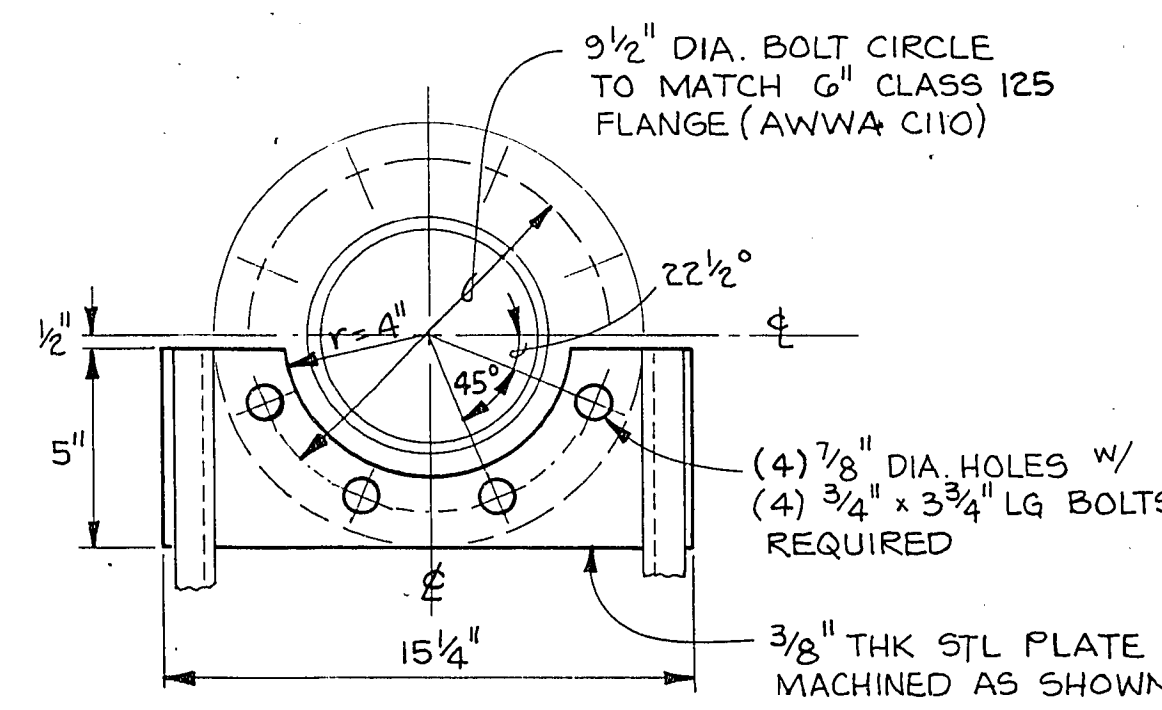



MOUNTING PLATE DETAIL

PS-D
NTS

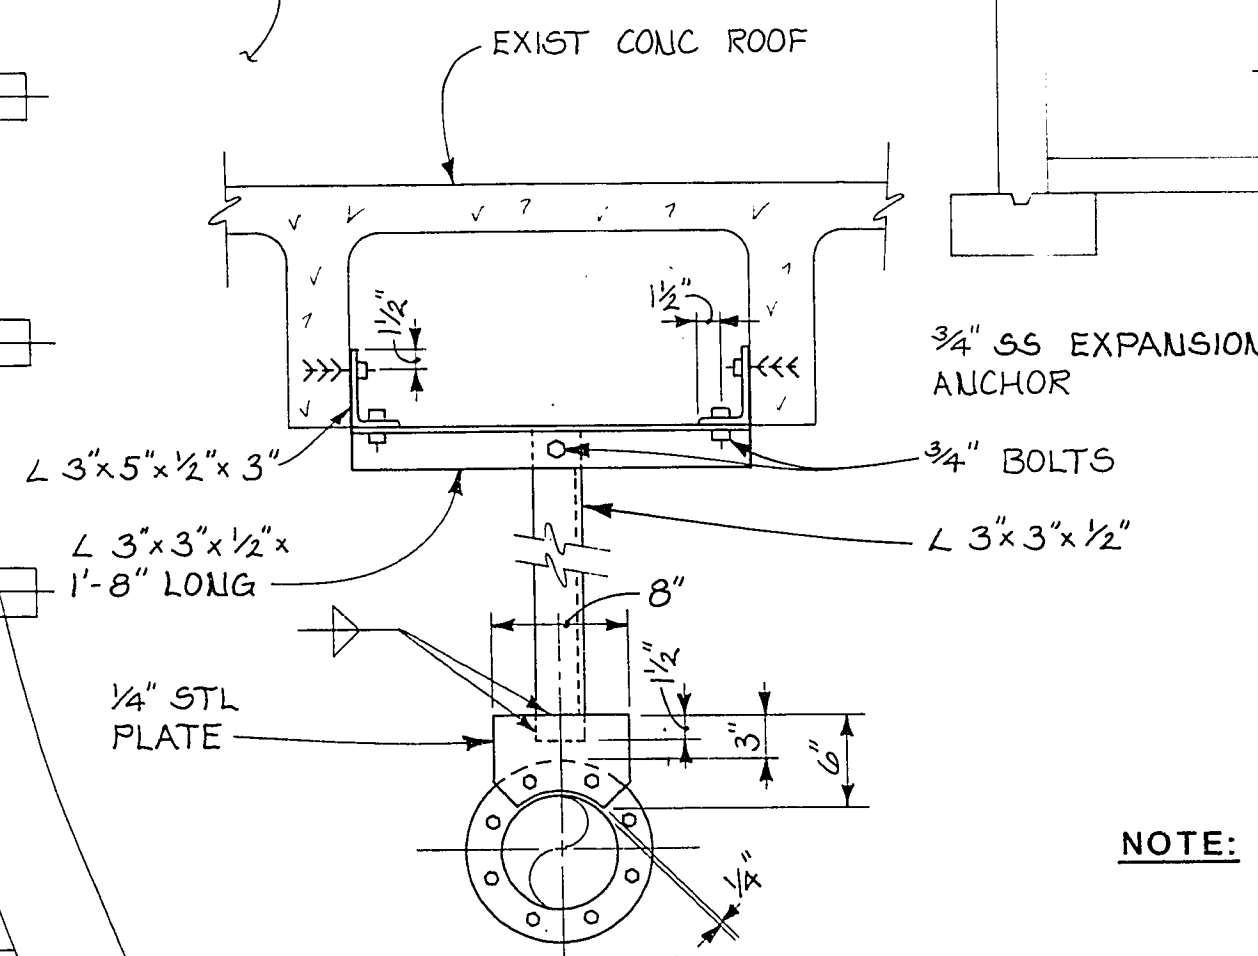


NOTE: ALL WORK COMPLETED ON THIS SHEET
IS COMPLETED UNDER CONTRACT 1

SECTION A
3/8" = 1' - 0"

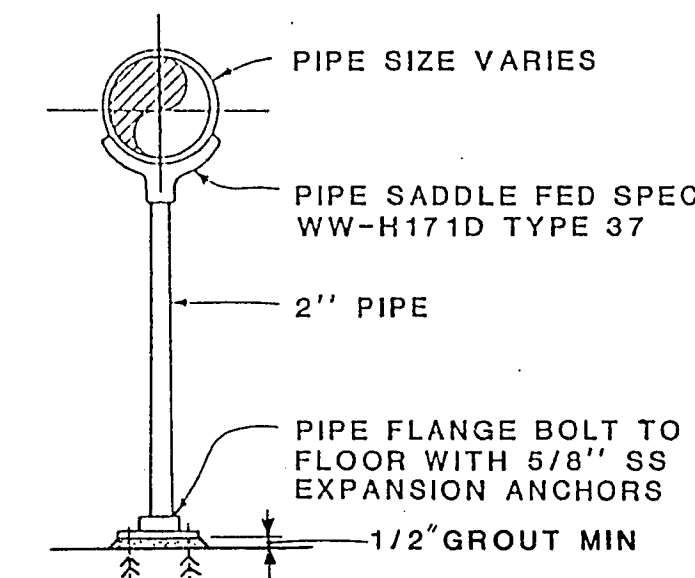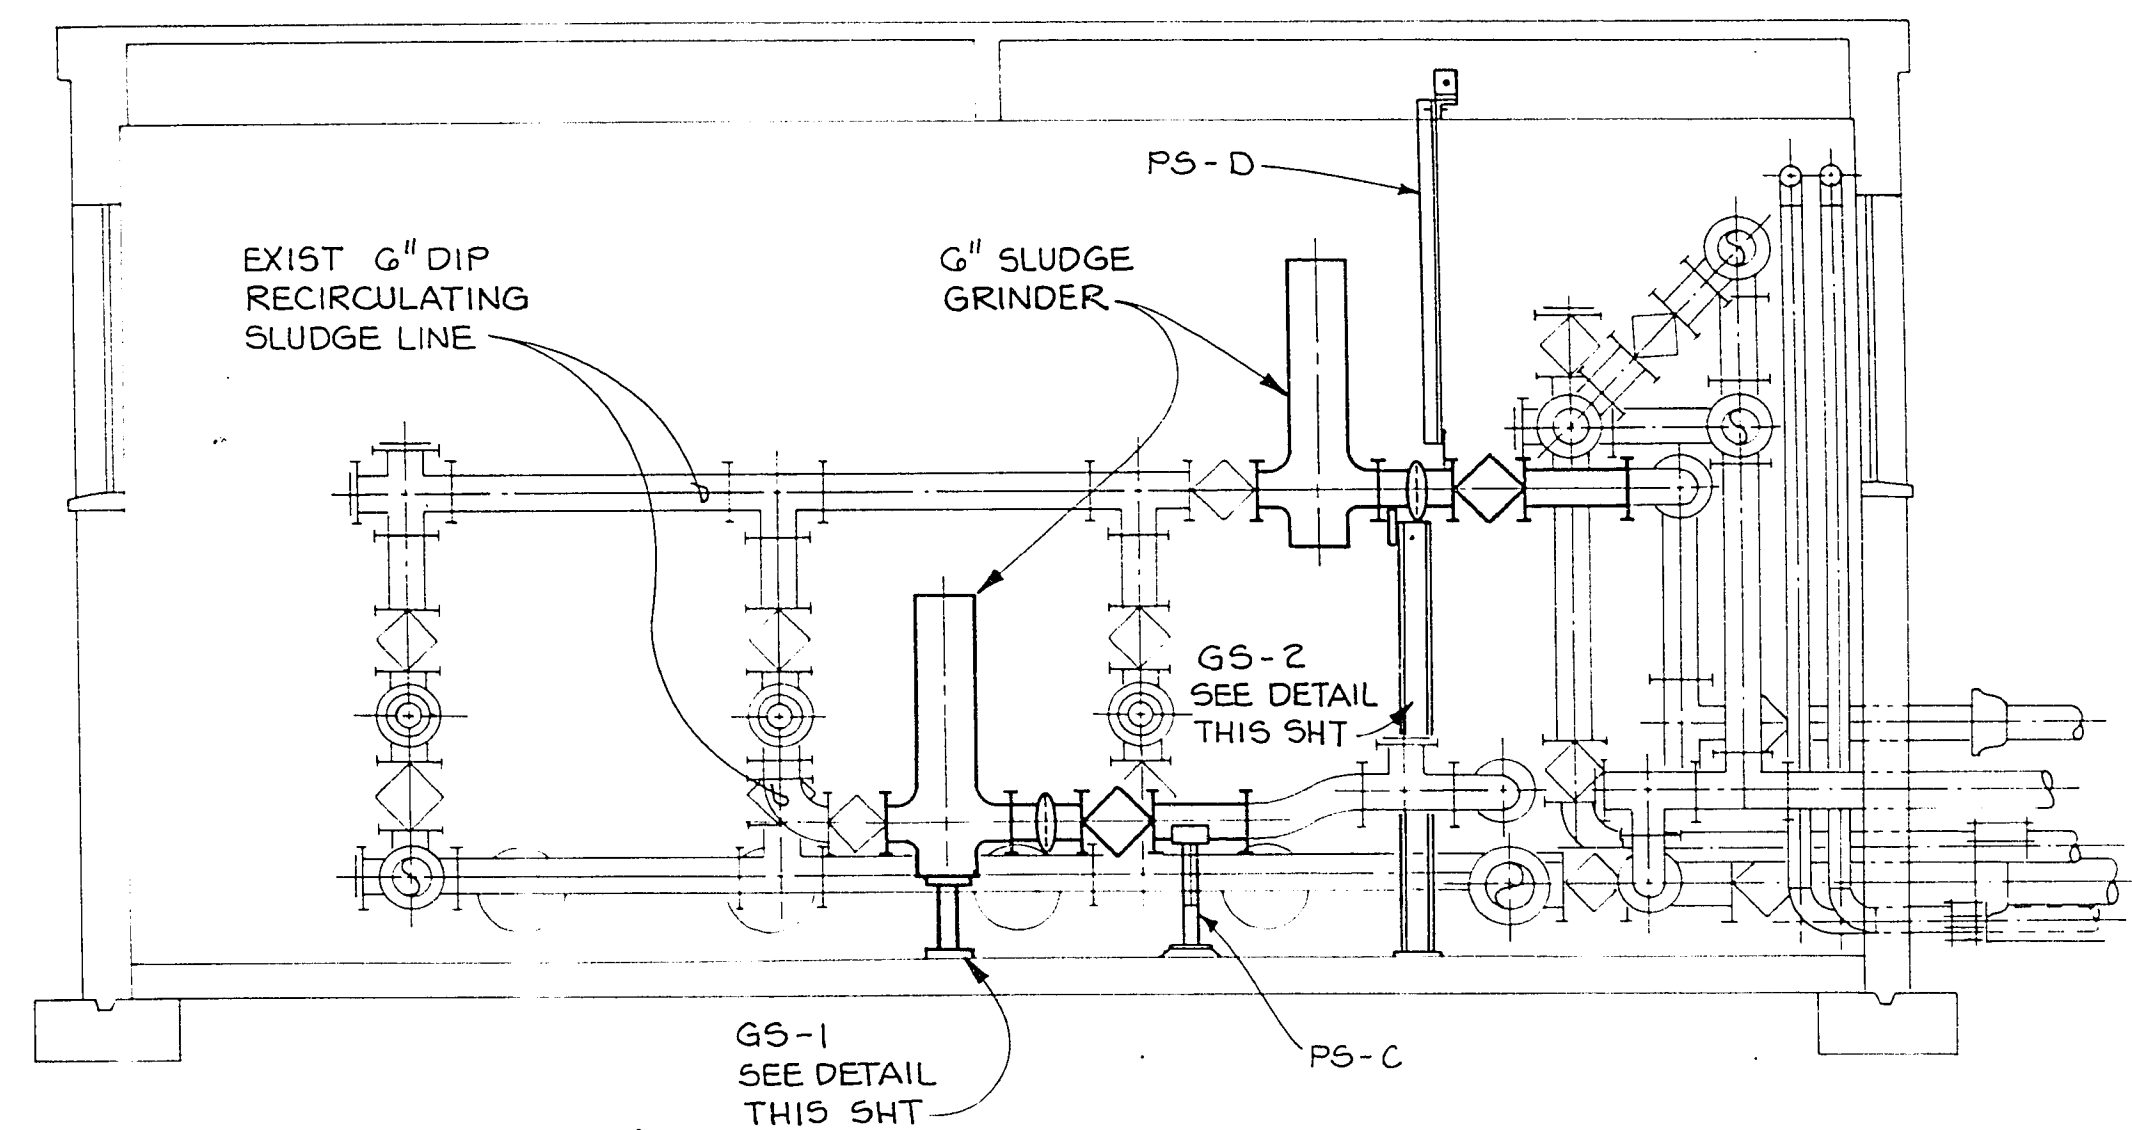

PS-C
NTS

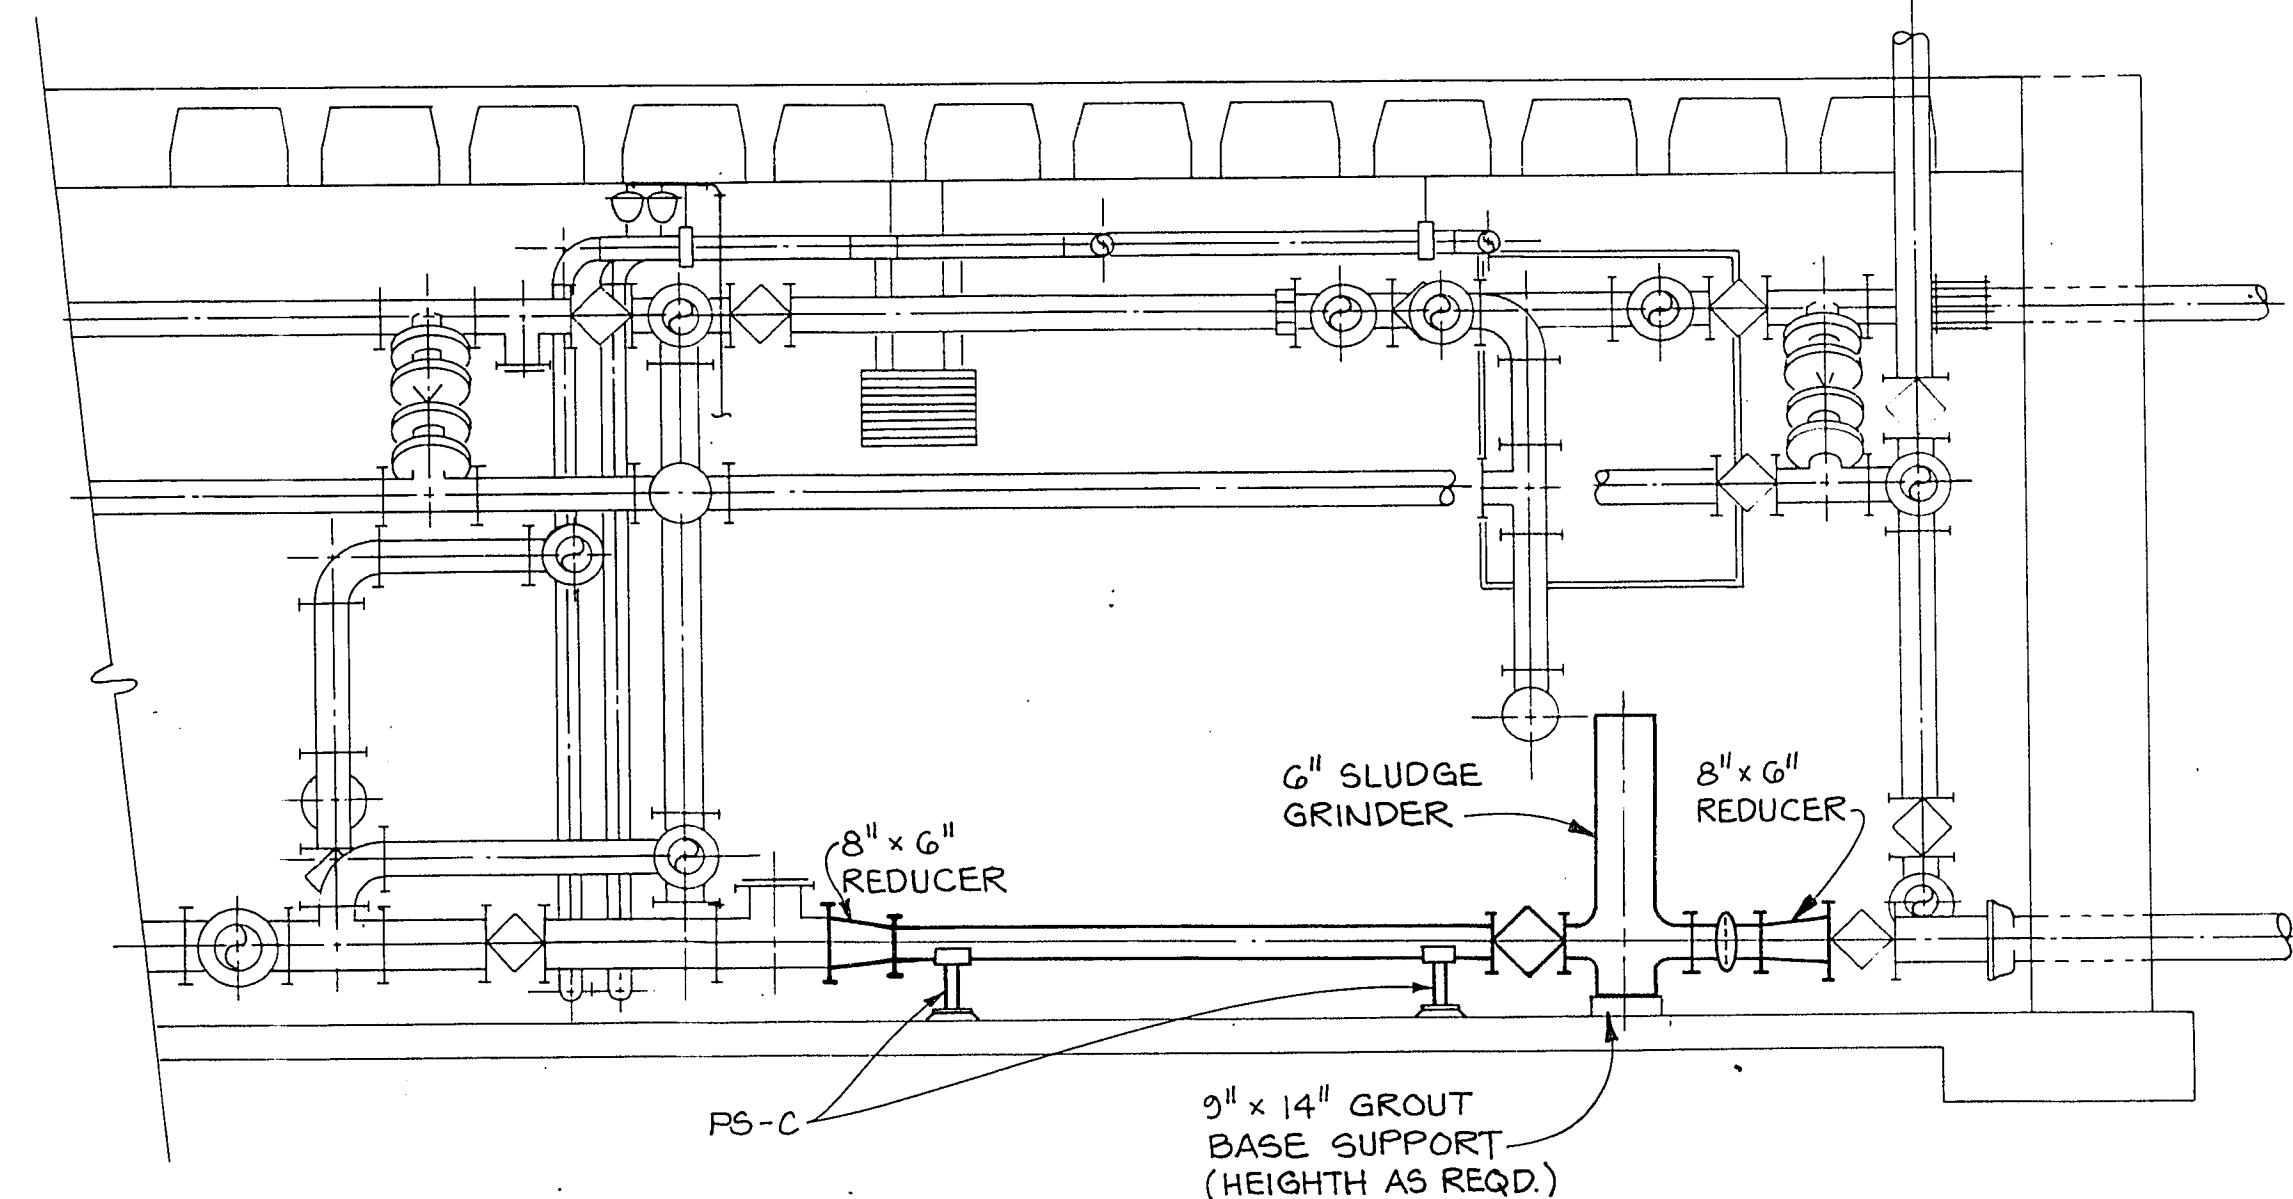


SECTION B
3/8" = 1' - 0"

CULP • WESNER • CULP
CONSULTING ENGINEERS
CAMERON PARK, CA SANTA ANA, CA
DENVER, CO EDMONDS, WA



CWC-DBI, Inc.
An HDR Infrastructure Company

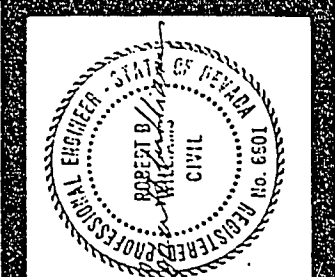

Job No. 120-12-41
Designed PSC
Drawn PDV
Checked DAP
Approved RBW
Date 2-23-87

No.	By	Revision	Description	Date
1	DAW	1	CORRECTED ACCORDING TO CONSTRUCTION RECORDS	03

BAR IS ONE INCH
ON ORIGINAL
DRAWING

City of Las Vegas
WASTEWATER TREATMENT PLANT
ODOR CONTROL & RELATED FACILITIES

DIGESTER
CONTROL BUILDING
PLANT 1

Sheet 7
7-15
311.23

CONTRACT 1

7-1-159 311.23