



LP2 LP2
ME ME
2 2

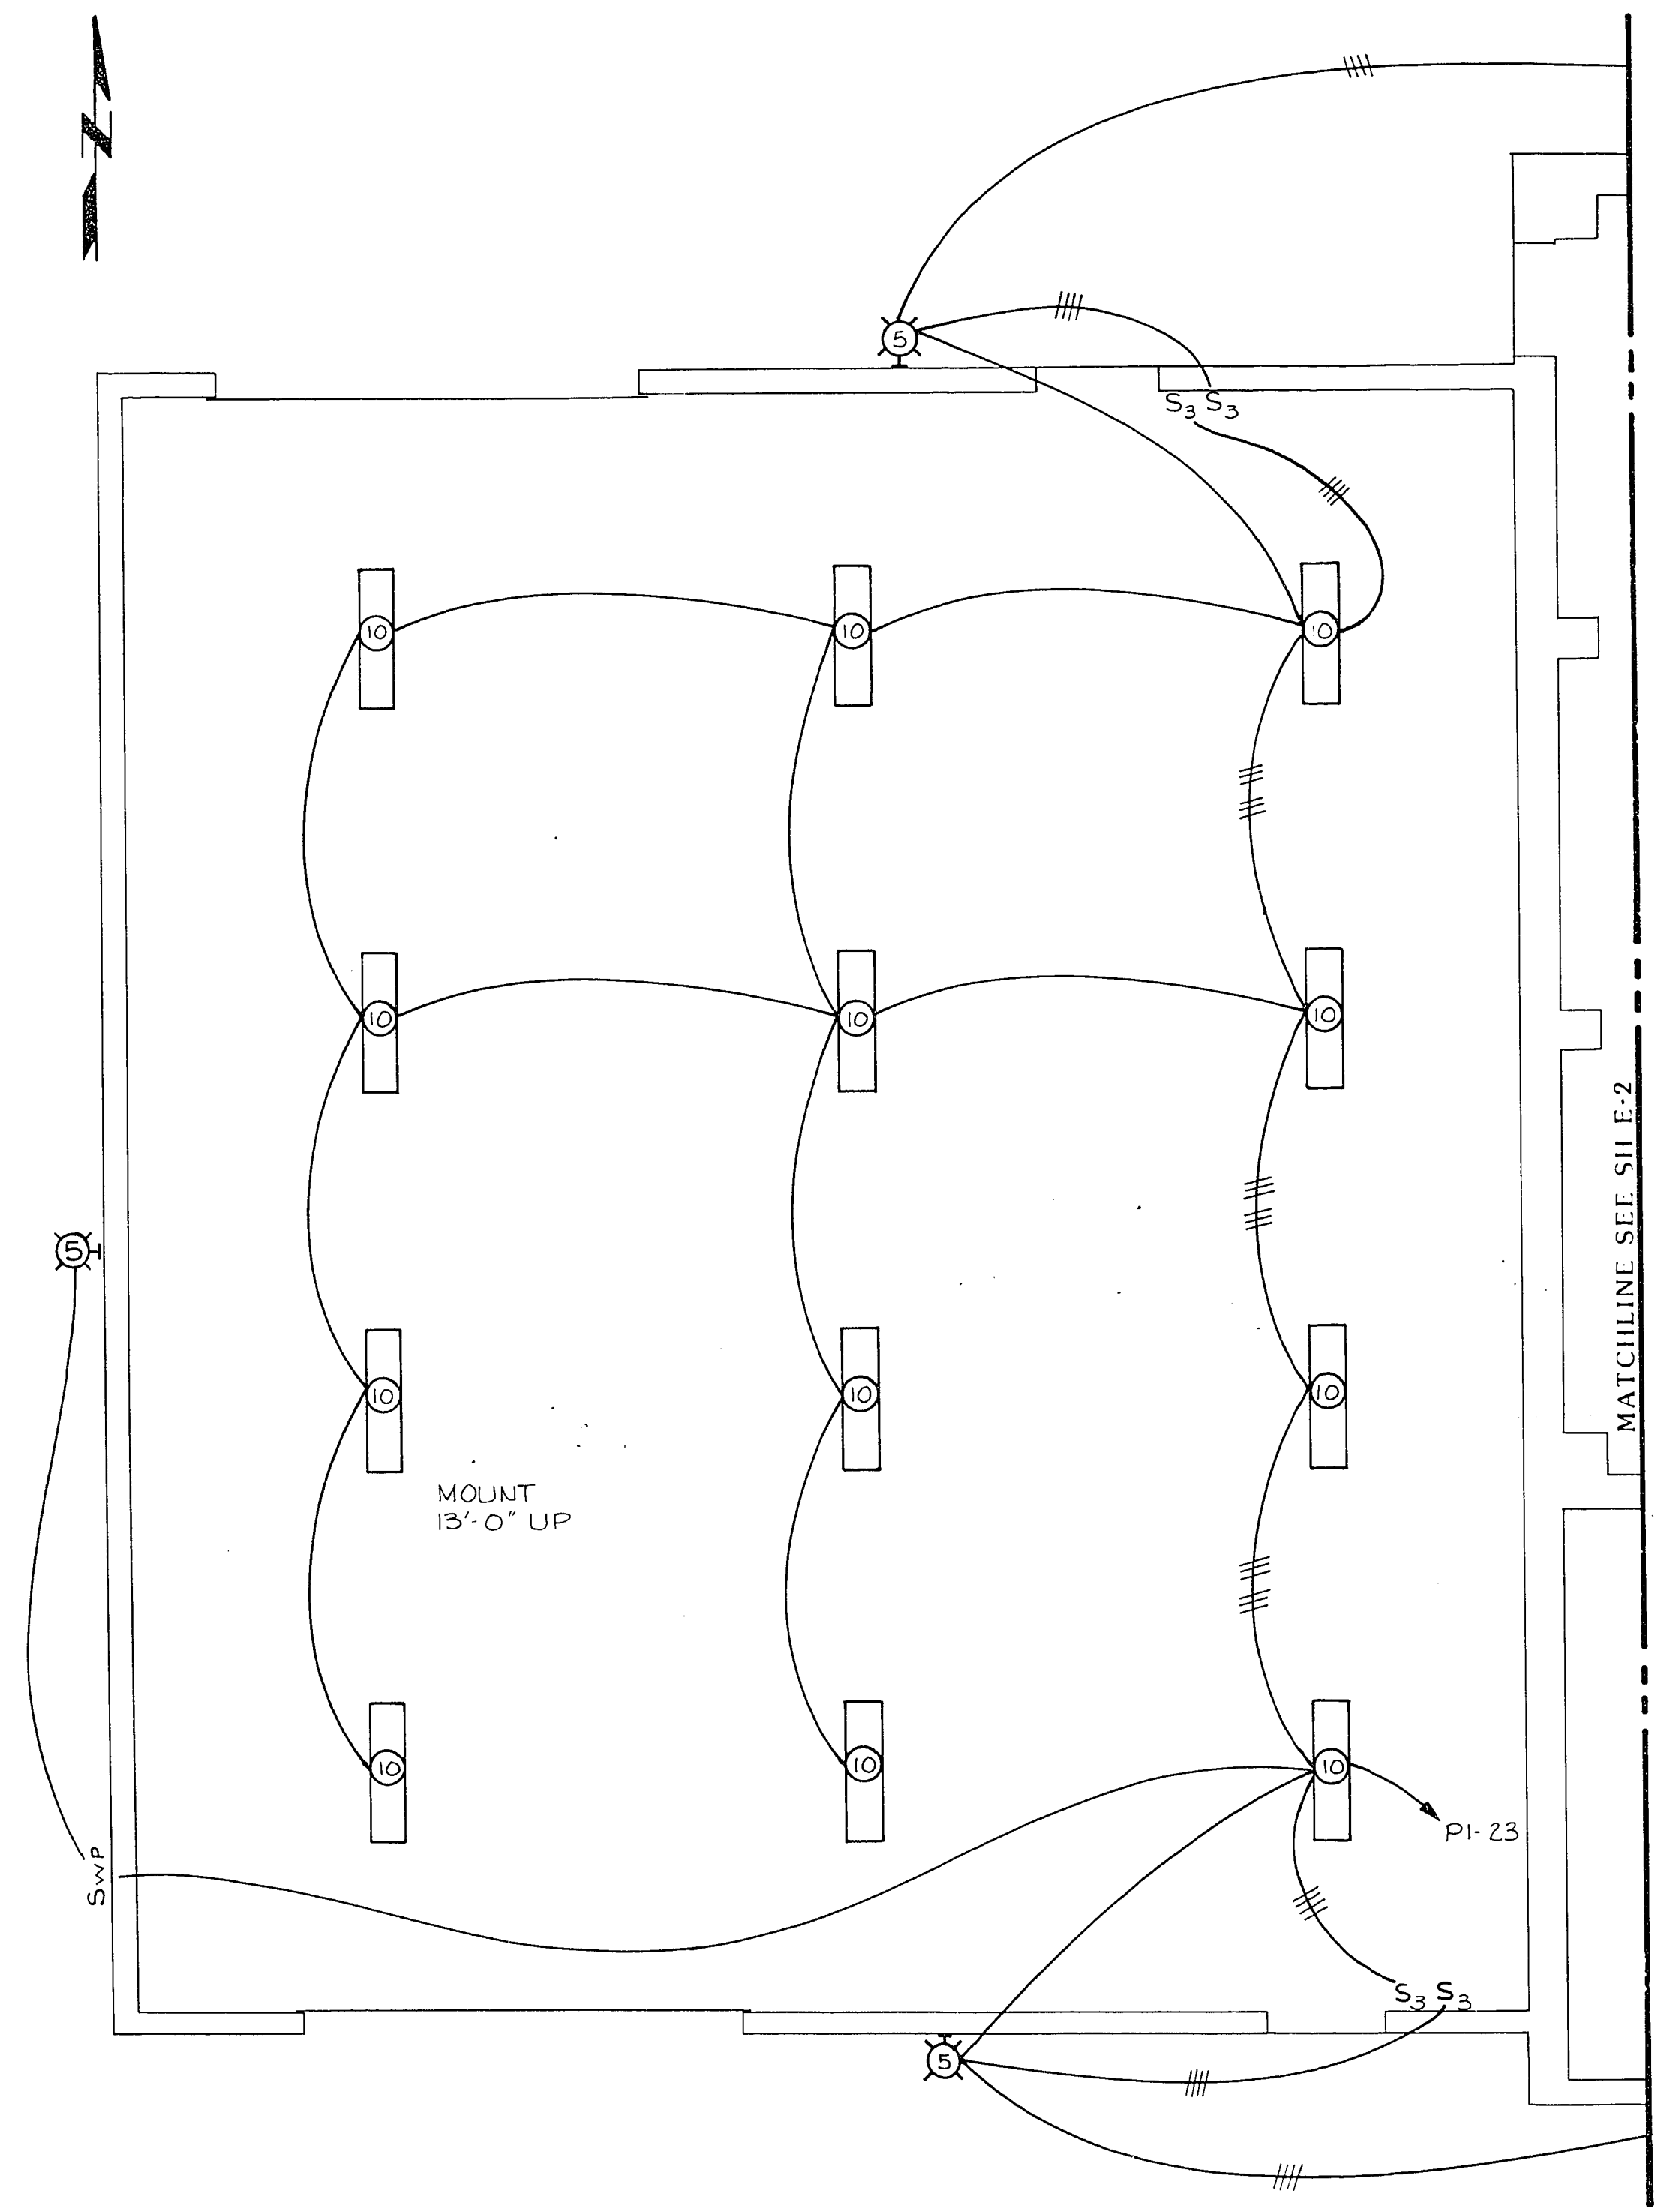

LIGHTING PLAN
1/4" = 1'-0"

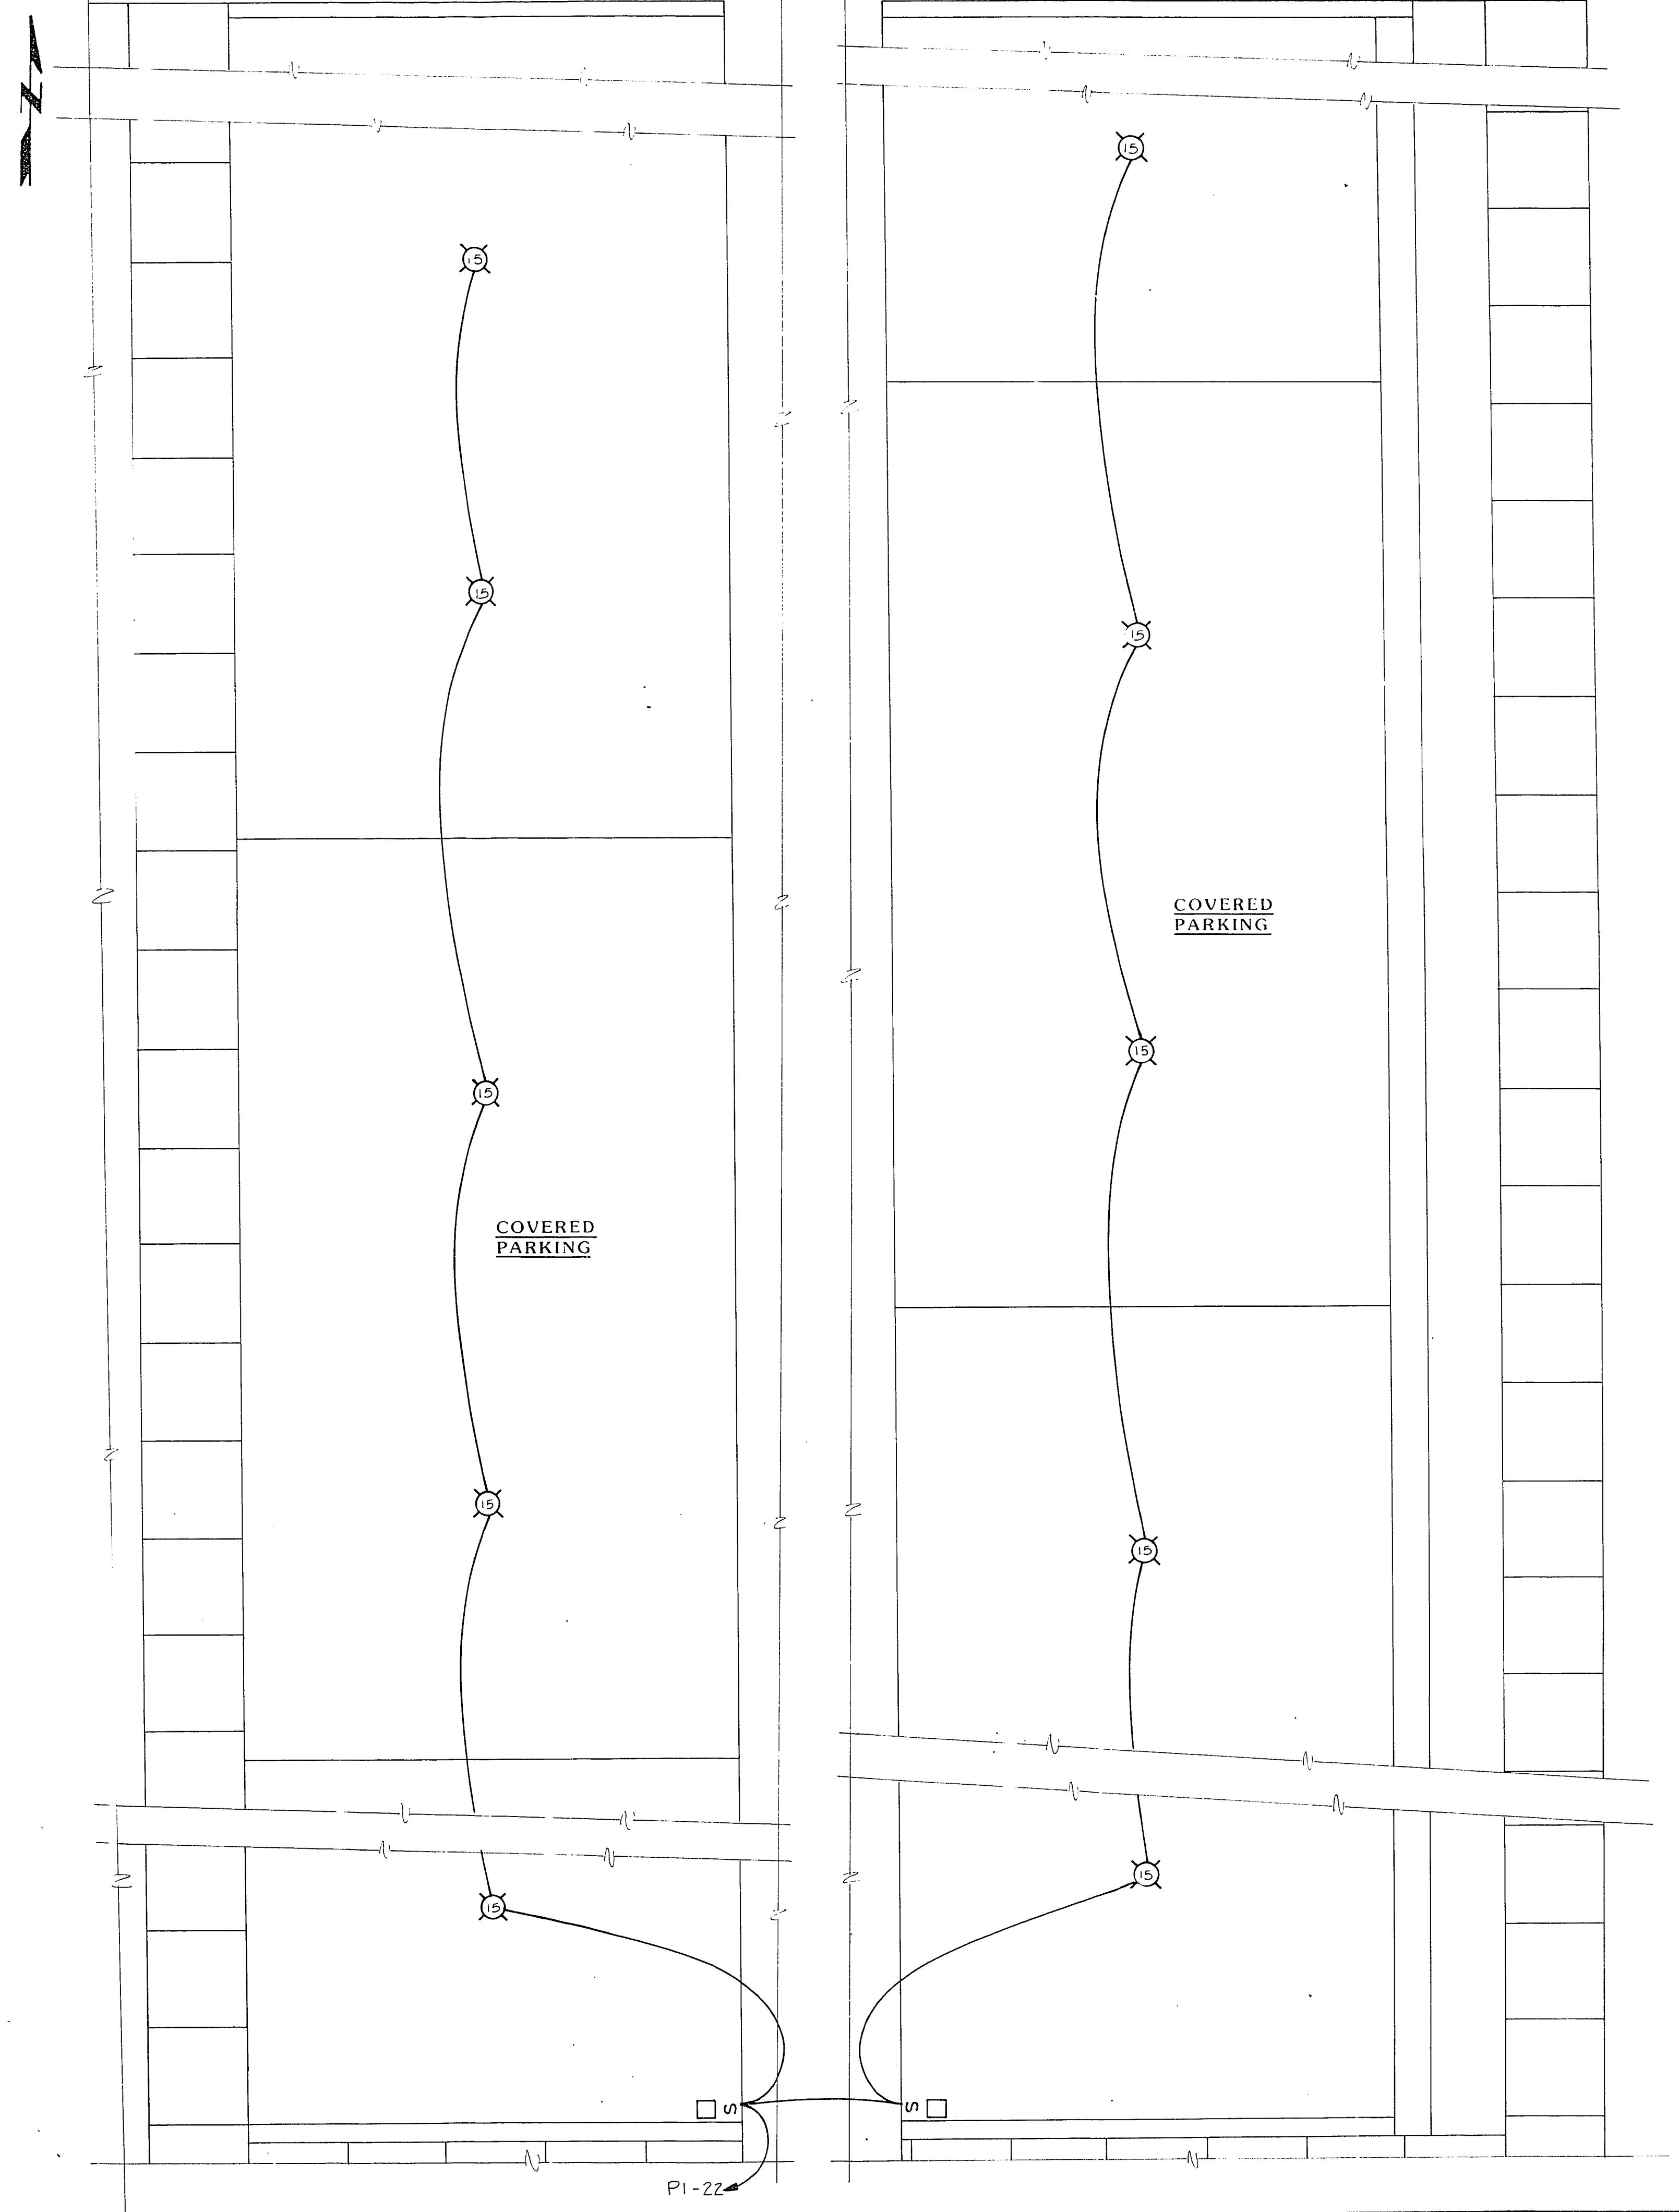

CULP/WESNER/CULP
CAMERON PARK, CALIFORNIA
SANTA ANA, CALIFORNIA · DENVER, COLORADO



STATE OF NEVADA
PROFESSIONAL ENGINEER
WILLIAM
ETHLICH
No. 1557

Job No. 740.15
Designed BY J.E.L.
Drawn BY MAVE
Checked BY DWB
Approved BY J.D.P.
Date 4/24/89

No.	By	Revision Description	Date
1		CORRECTED ALPHABETICALLY TO 12/40	
2		CONSTRUCTION REVISIONS	

City of Las Vegas
WASTEWATER TREATMENT PLANT
Contract No. 5 Maintenance & Storage Buildings

MAINTENANCE BUILDING
LIGHTING PLAN

Sheet 48
F-33
of 57

7-1-128 3/1/25