




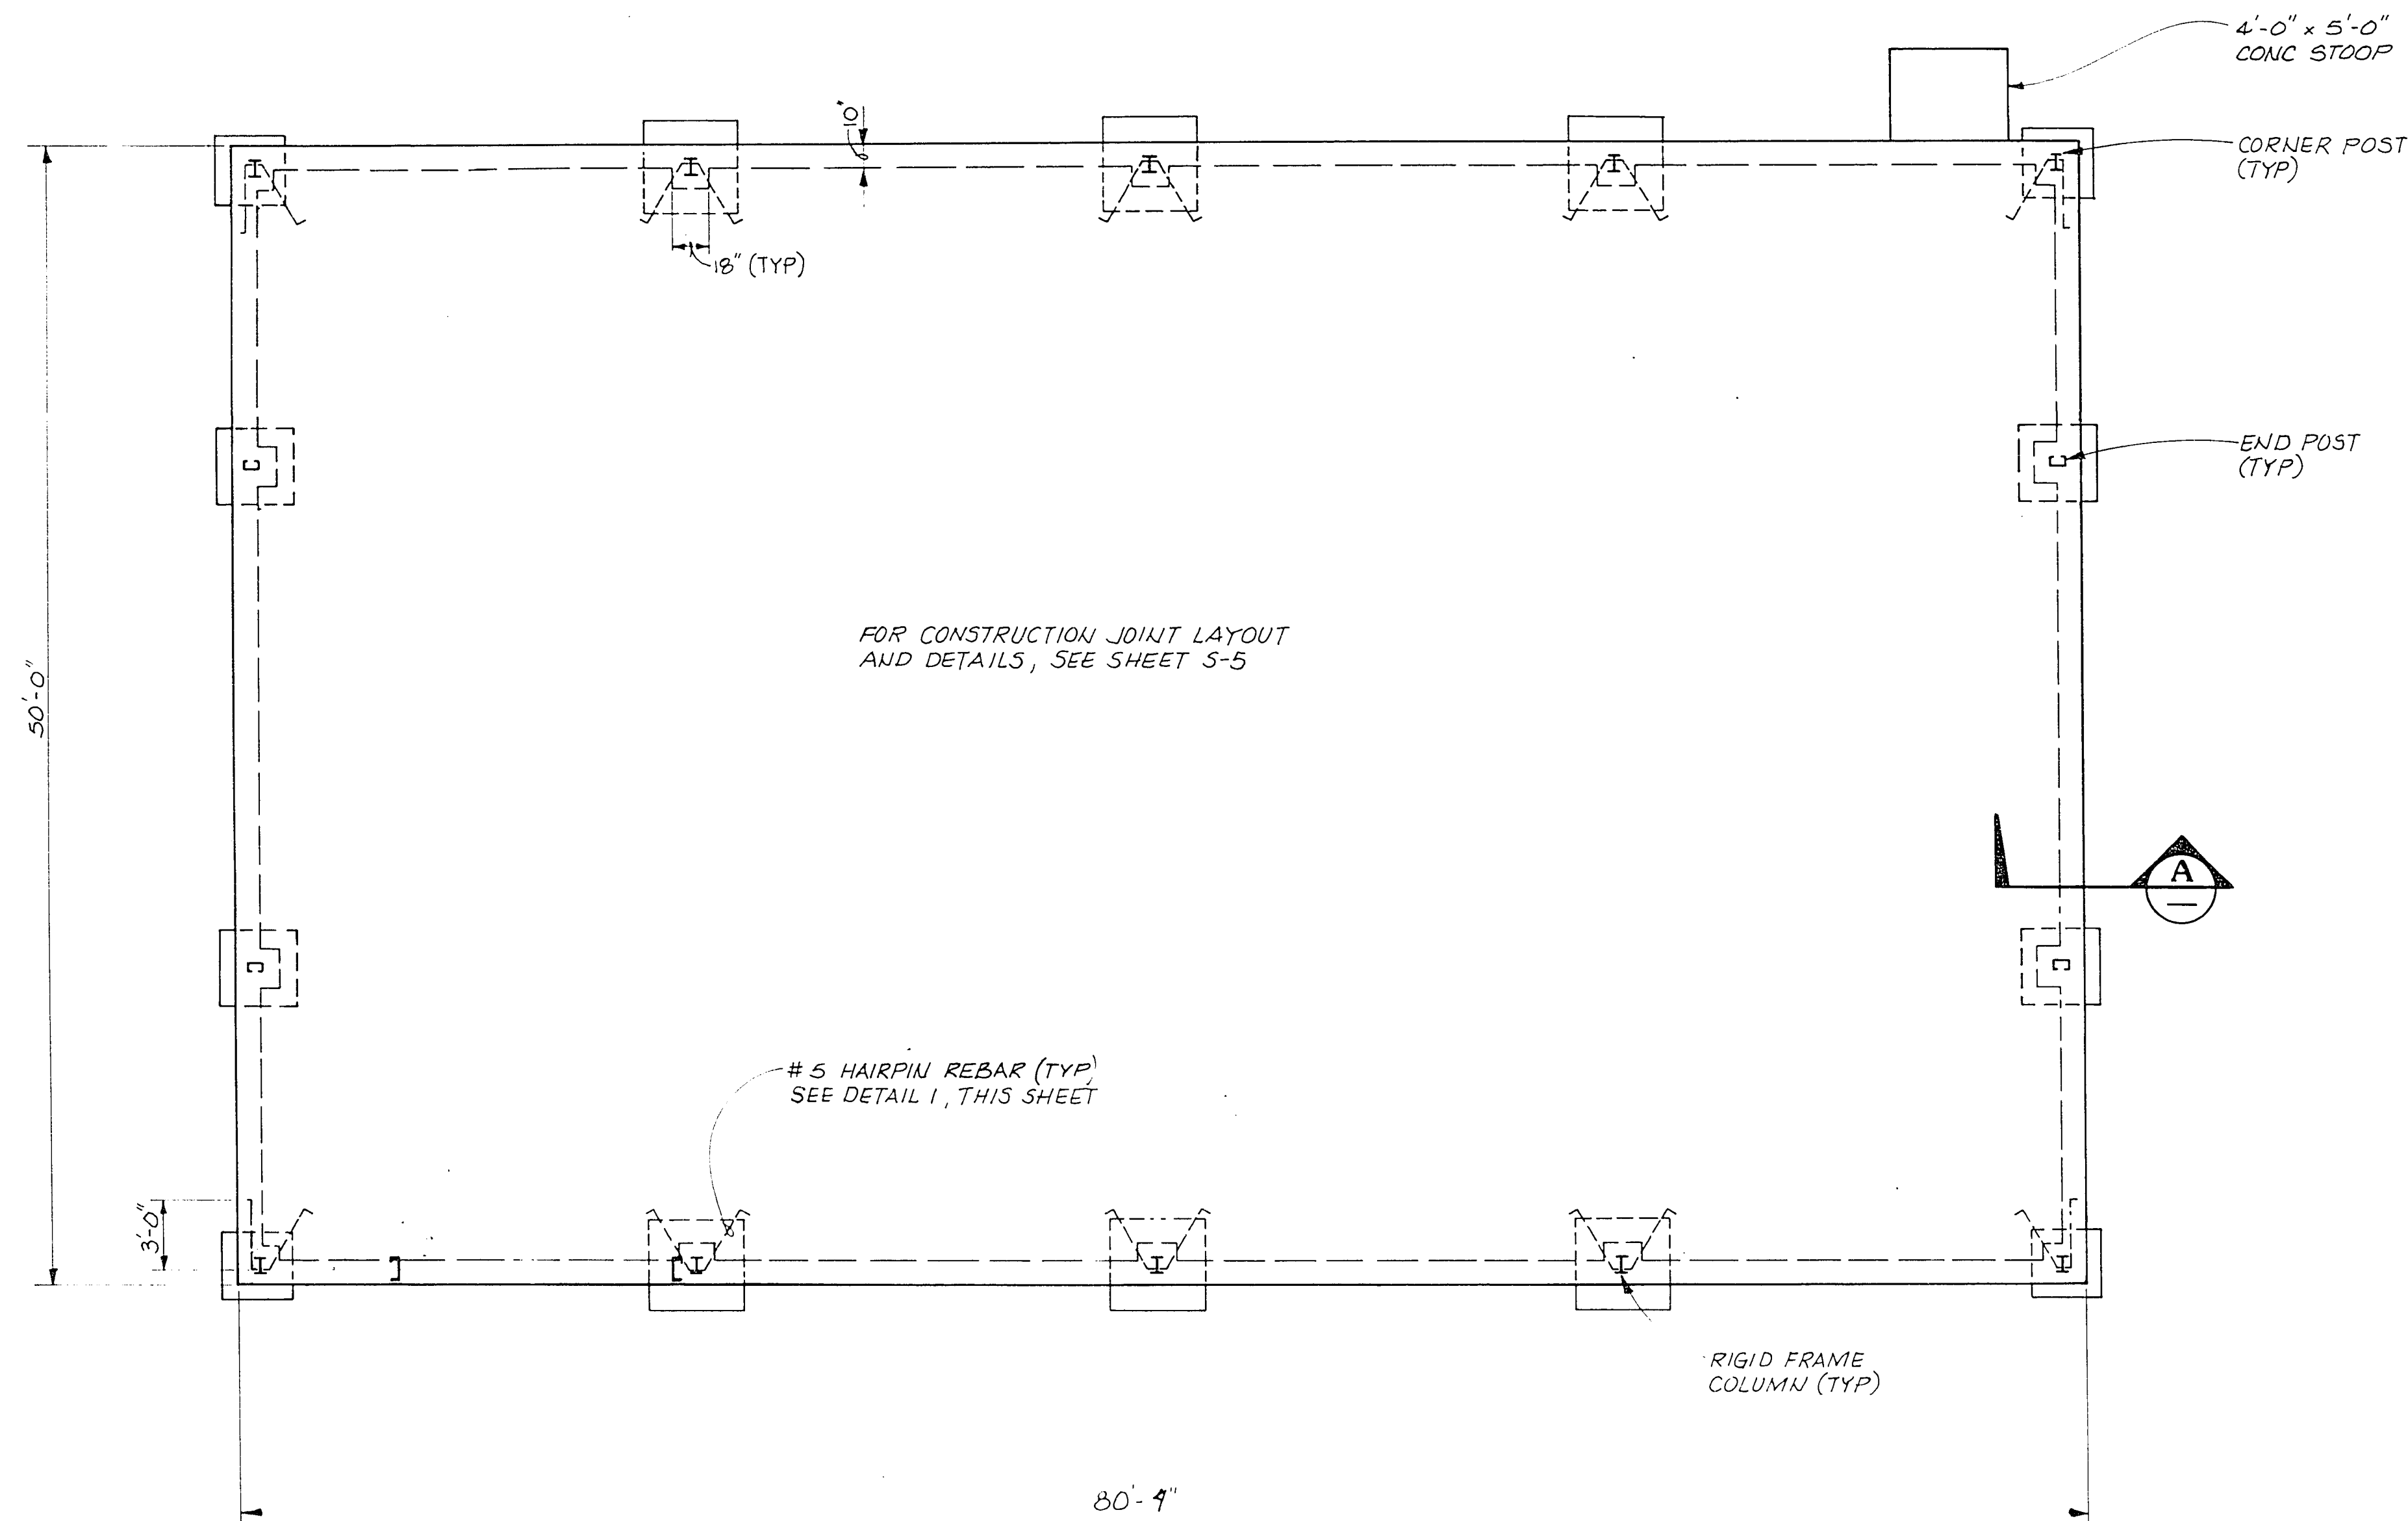


FOUNDATION PLAN
3/16" = 1'-0"

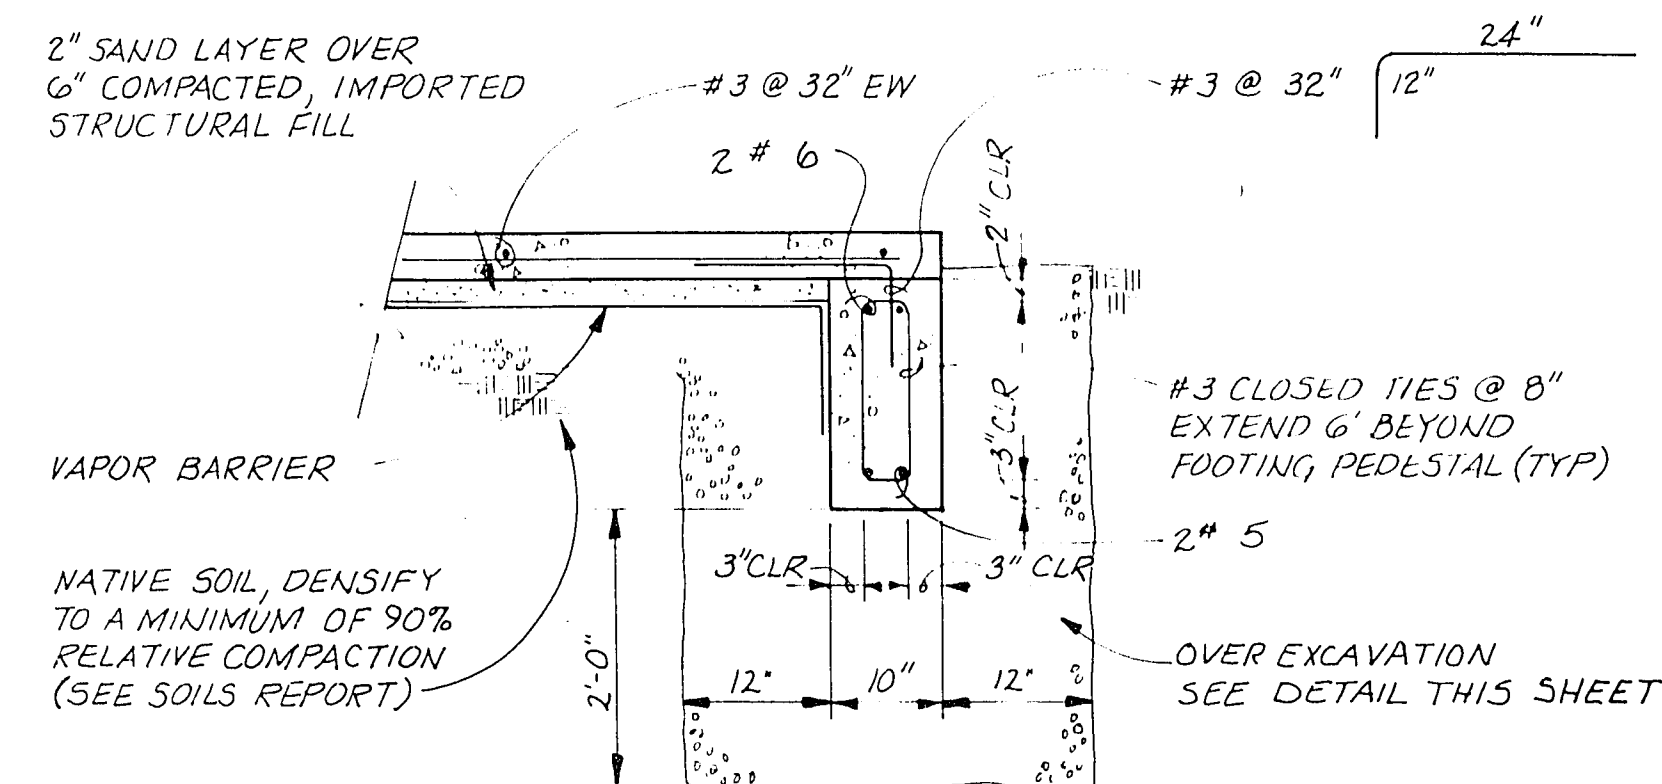

SECTION A
3/4" = 1'-0"

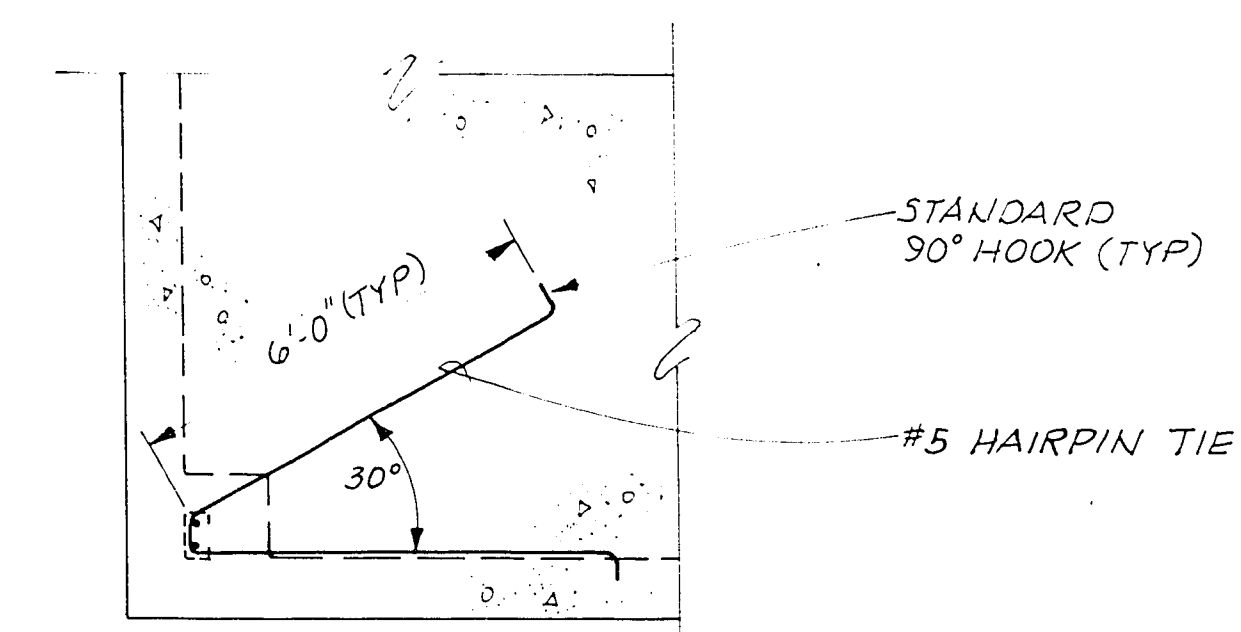


SECTIONAL PLAN AT CORNER POST

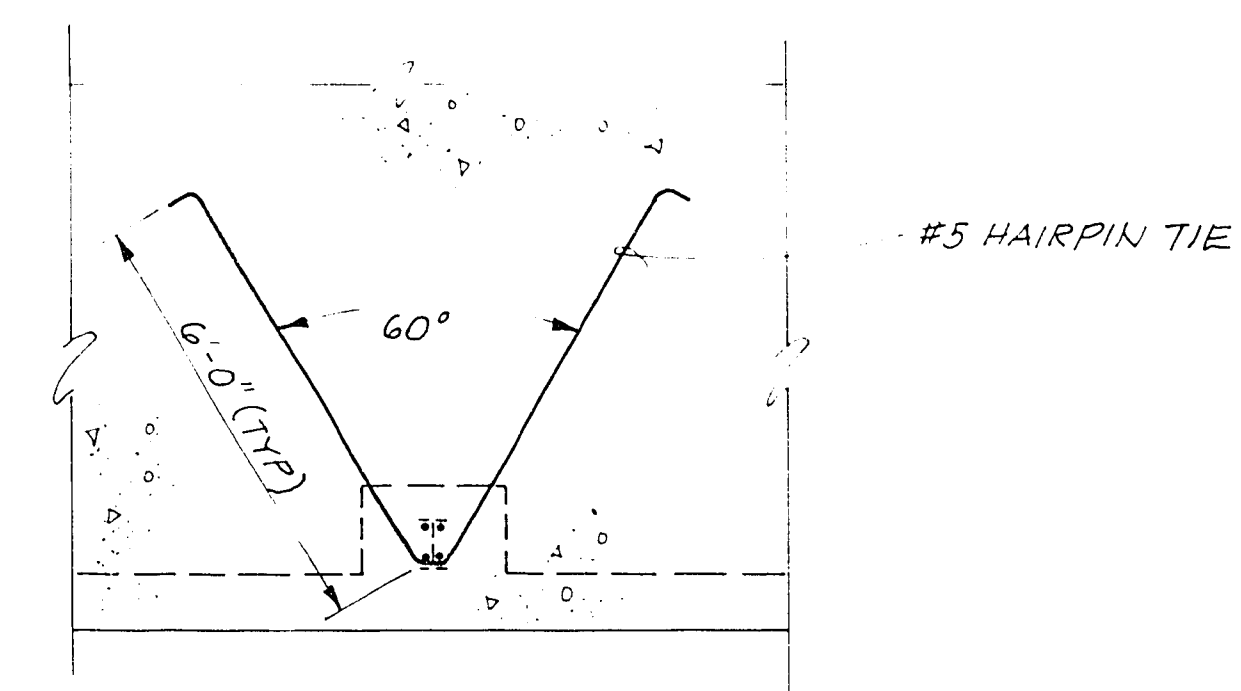


SECTIONAL PLAN AT END POST OR RIGID FRAME COLUMN

POST/COLUMN REINFORCEMENT DETAILS
3/8" = 1'-0"

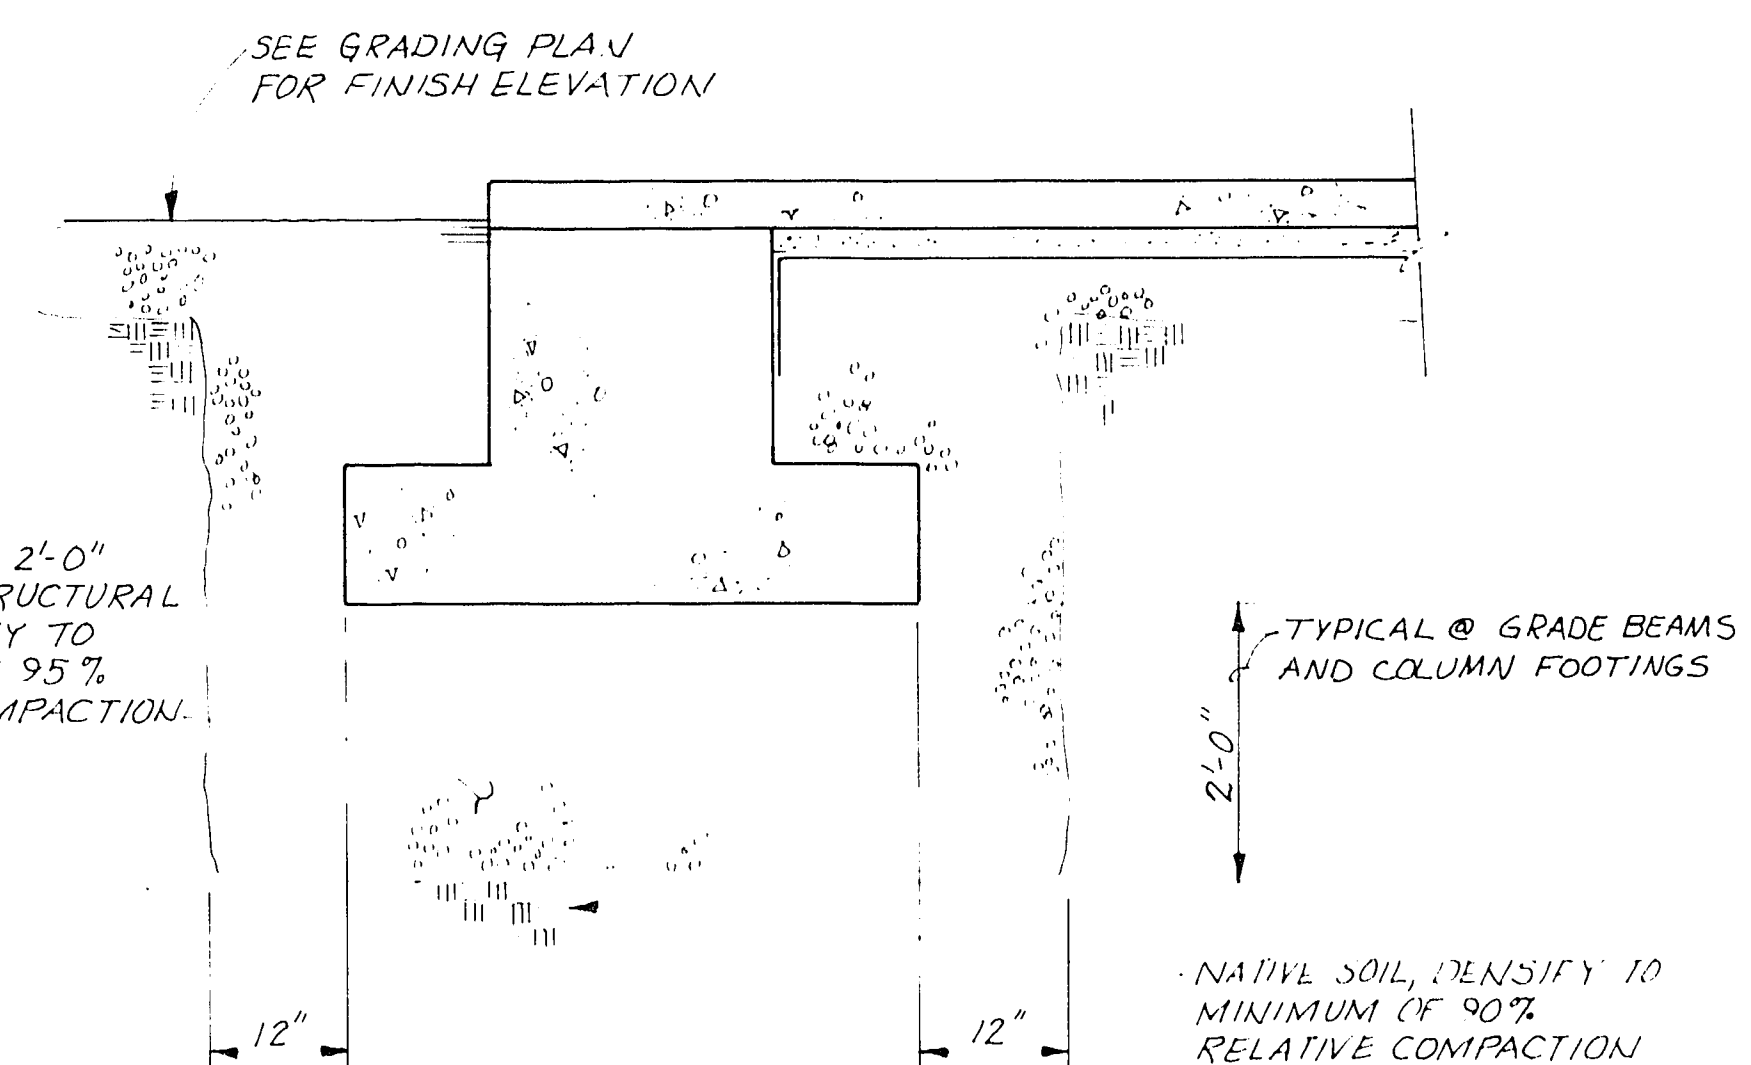


TYPICAL OVER-EXCAVATION DETAIL FOR FOOTINGS
3/4" = 1'-0"

CULP • WESNER • CULP
CONSULTING ENGINEERS
CAMERON PARK, CA SANTA ANA, CA
DENVER, CO EDMONDS, WA

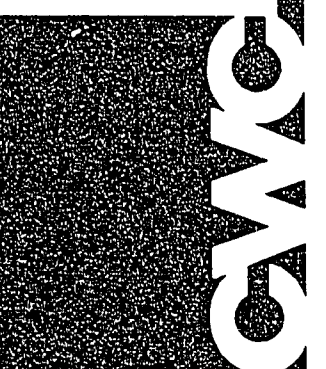

H D R
CONSULTING ENGINEERS, INC.
10000 E. HIGHWAY 100, SUITE 100
DENVER, CO 80231

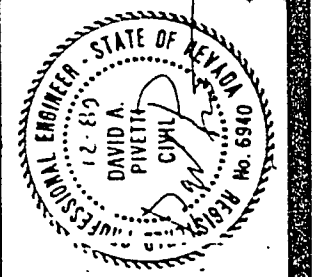

Job No. 740.15
Designed JBG
Drawn EAD
Checked JBG
Approved EAD
Date 4/24/89

No.	By	Revision Description	Date
1			

BAR IS ONE INCH ON ORIGINAL DRAWING

City of Las Vegas
WASTEWATER TREATMENT PLANT
Maintenance & Storage Buildings
Contract No. 5

STORAGE BUILDING
FOUNDATION PLAN & SECTIONS

Sheet 34
S-10
of 57

7-1-114

3/11/25