



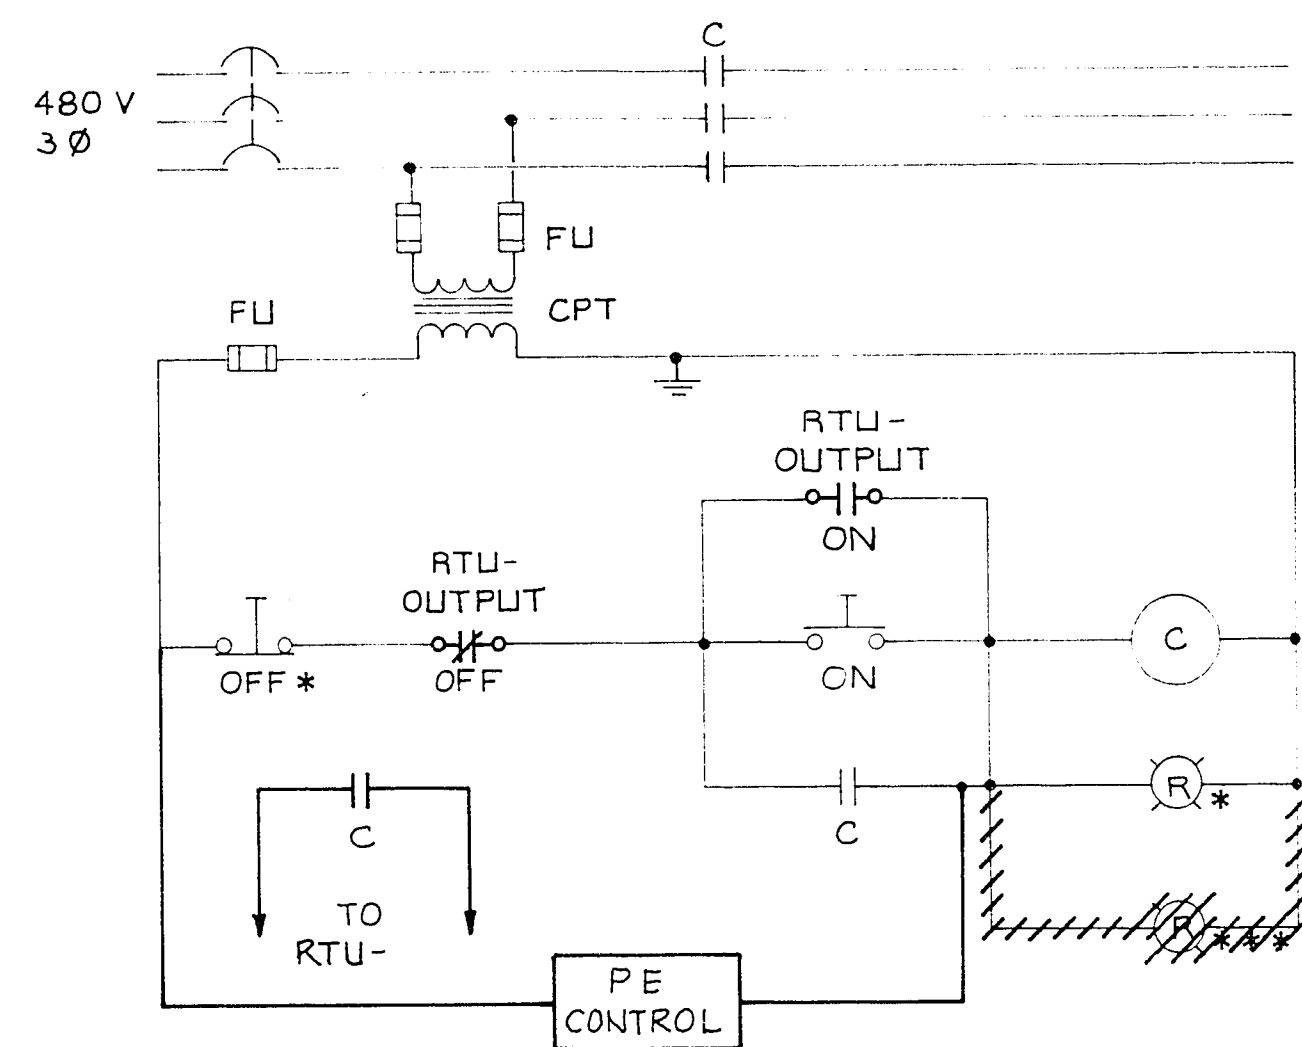


MODIFICATIONS FOR EXISTING EXTERIOR LIGHTING CONTROL

TYPICAL FOR: C403 FROM RTU-5
C403 FROM RTU-7
G4C7 FROM RTU-6

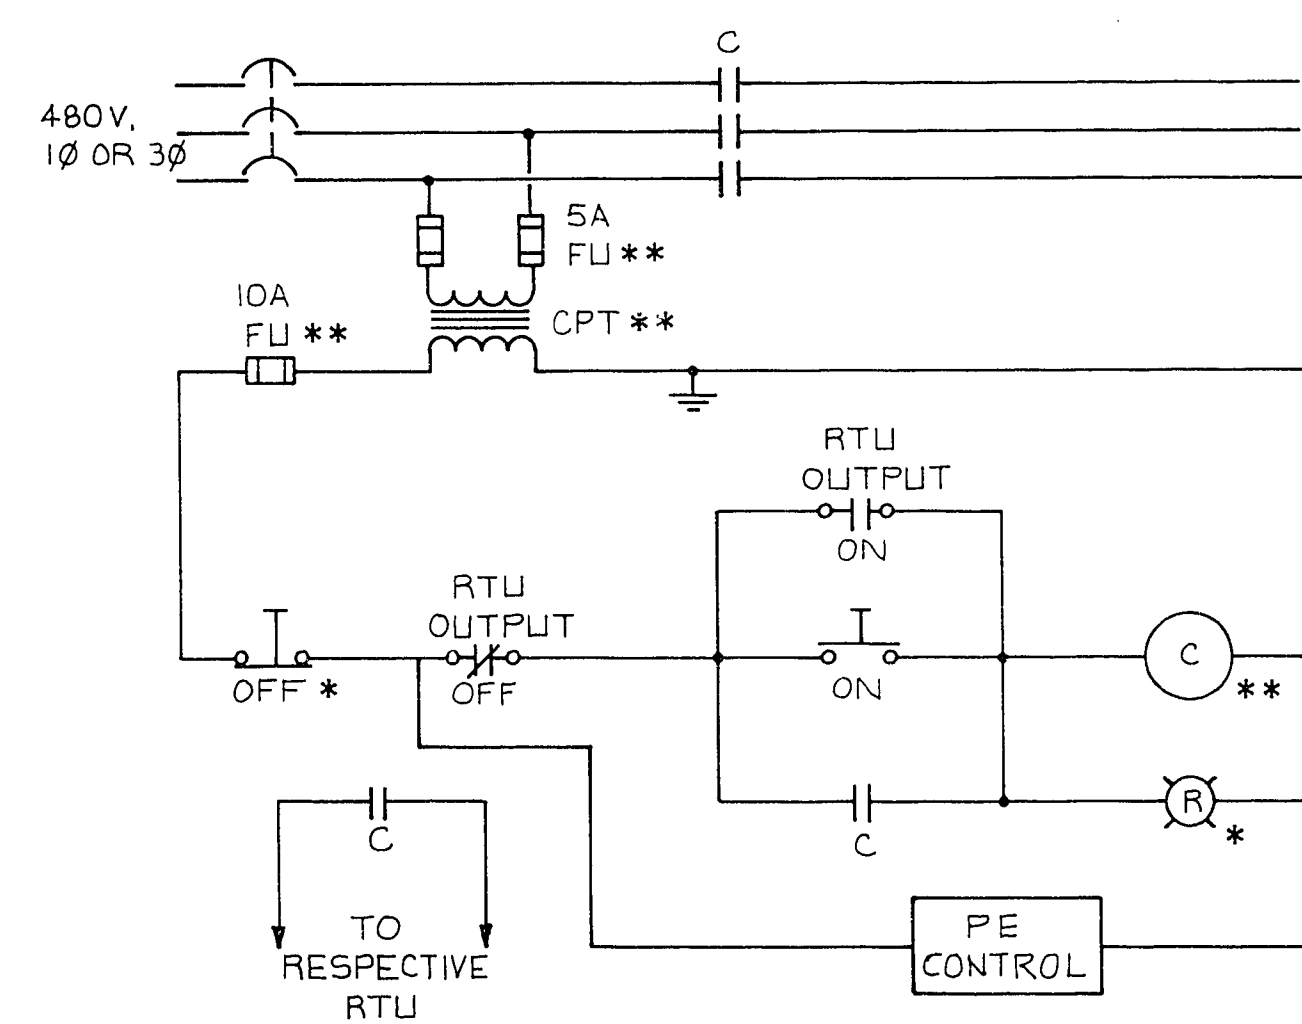


NEW EXTERIOR LIGHTING CONTROL

TYPICAL FOR: J425, RTU-2
J423, RTU-2
I430, RTU-3
J106, RTU-2

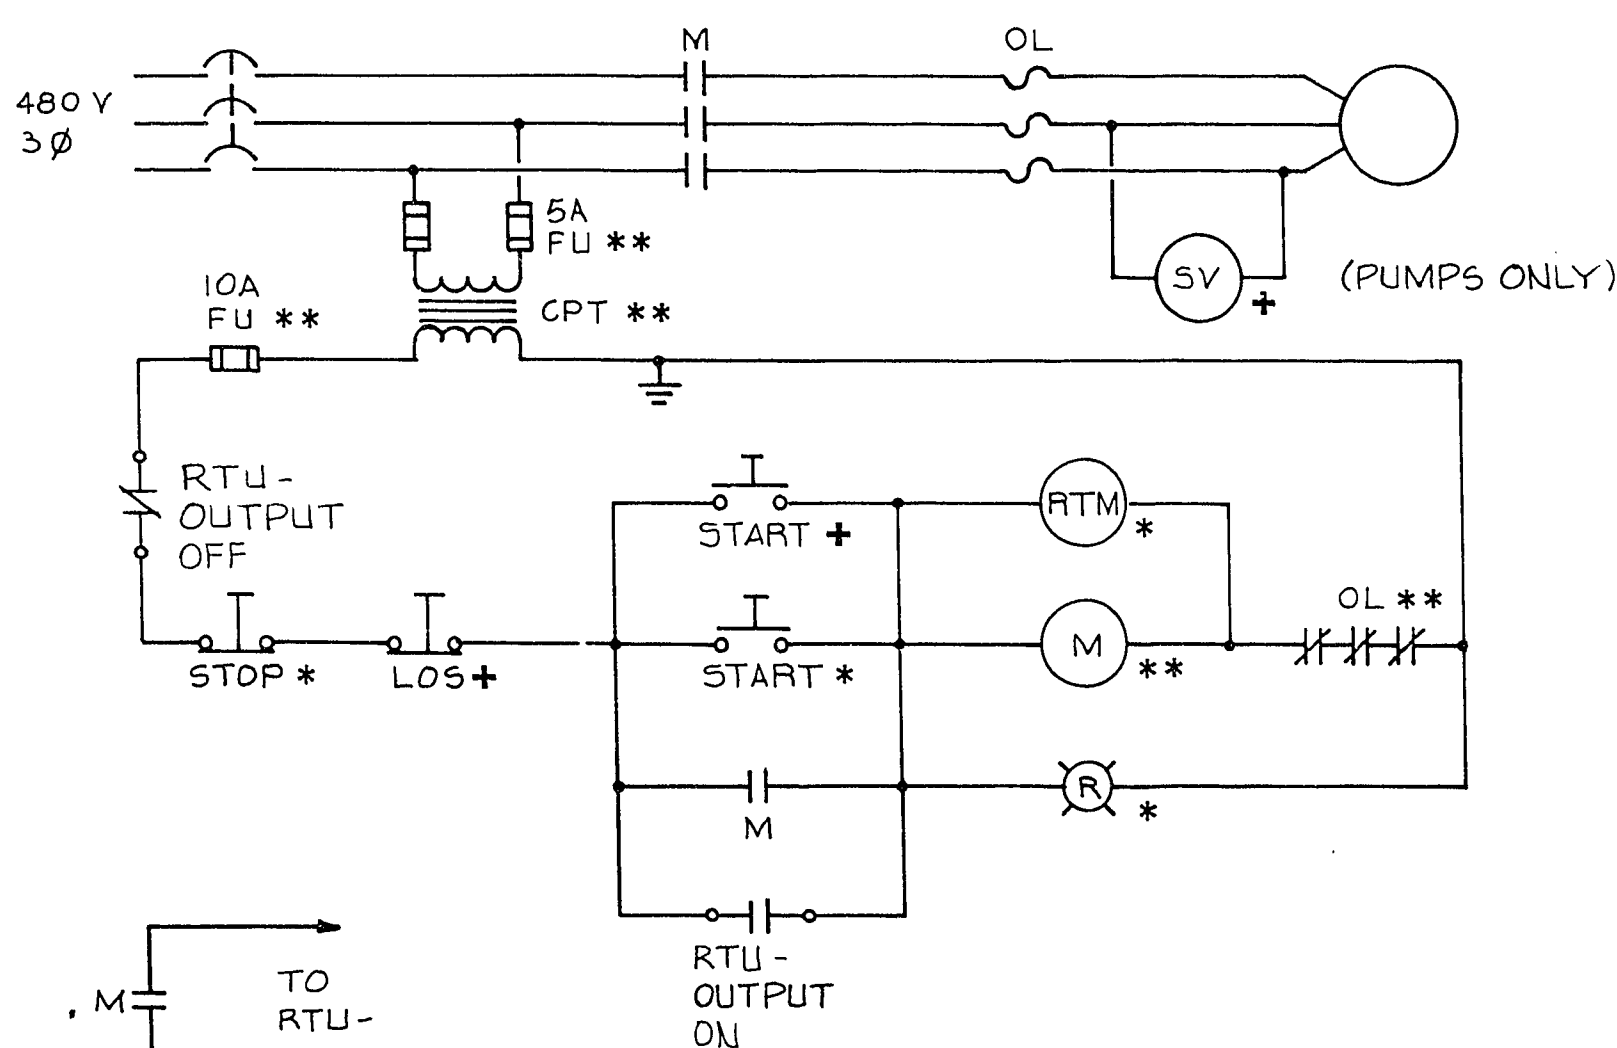


TYPICAL FOR

RTU-2
SB-3-1 FRP-3-1 FRP-4-2
SB-3-2 FRP-3-2 FRP-4-3
SB-4-1 FRP-3-3 FRP-4-4
SB-4-2 FRP-3-4 SPD-4-2
FRP-4-1

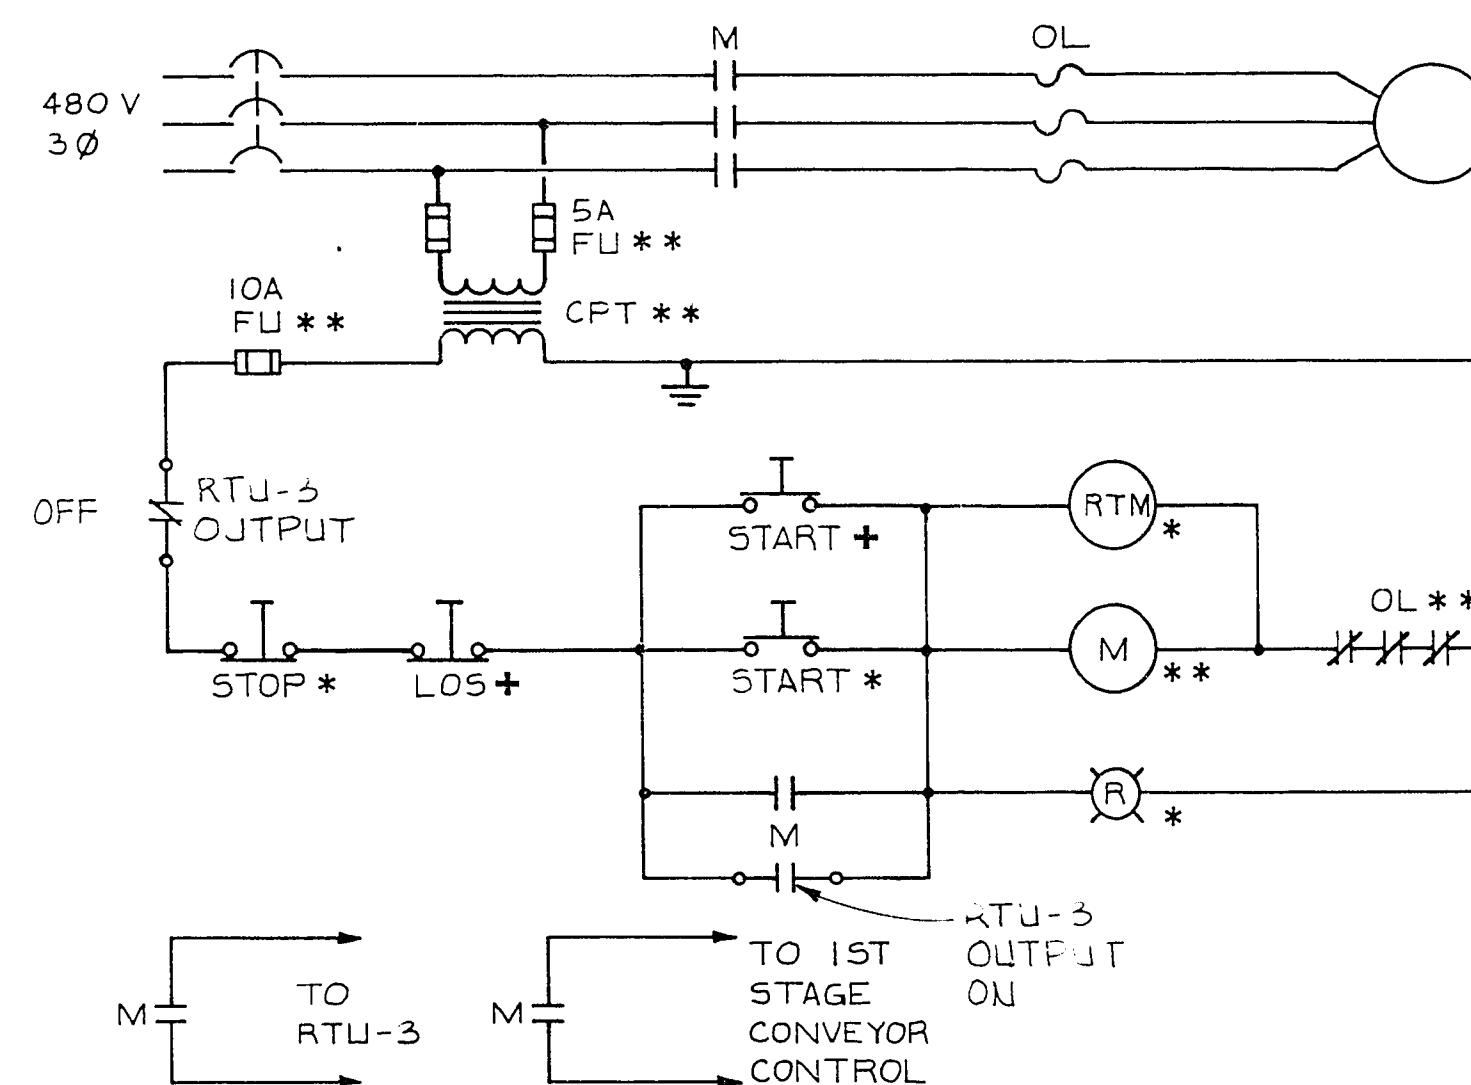


TYPICAL FOR GRIT CONVEYOR

(2nd STAGE) GS 3-2, 4-2

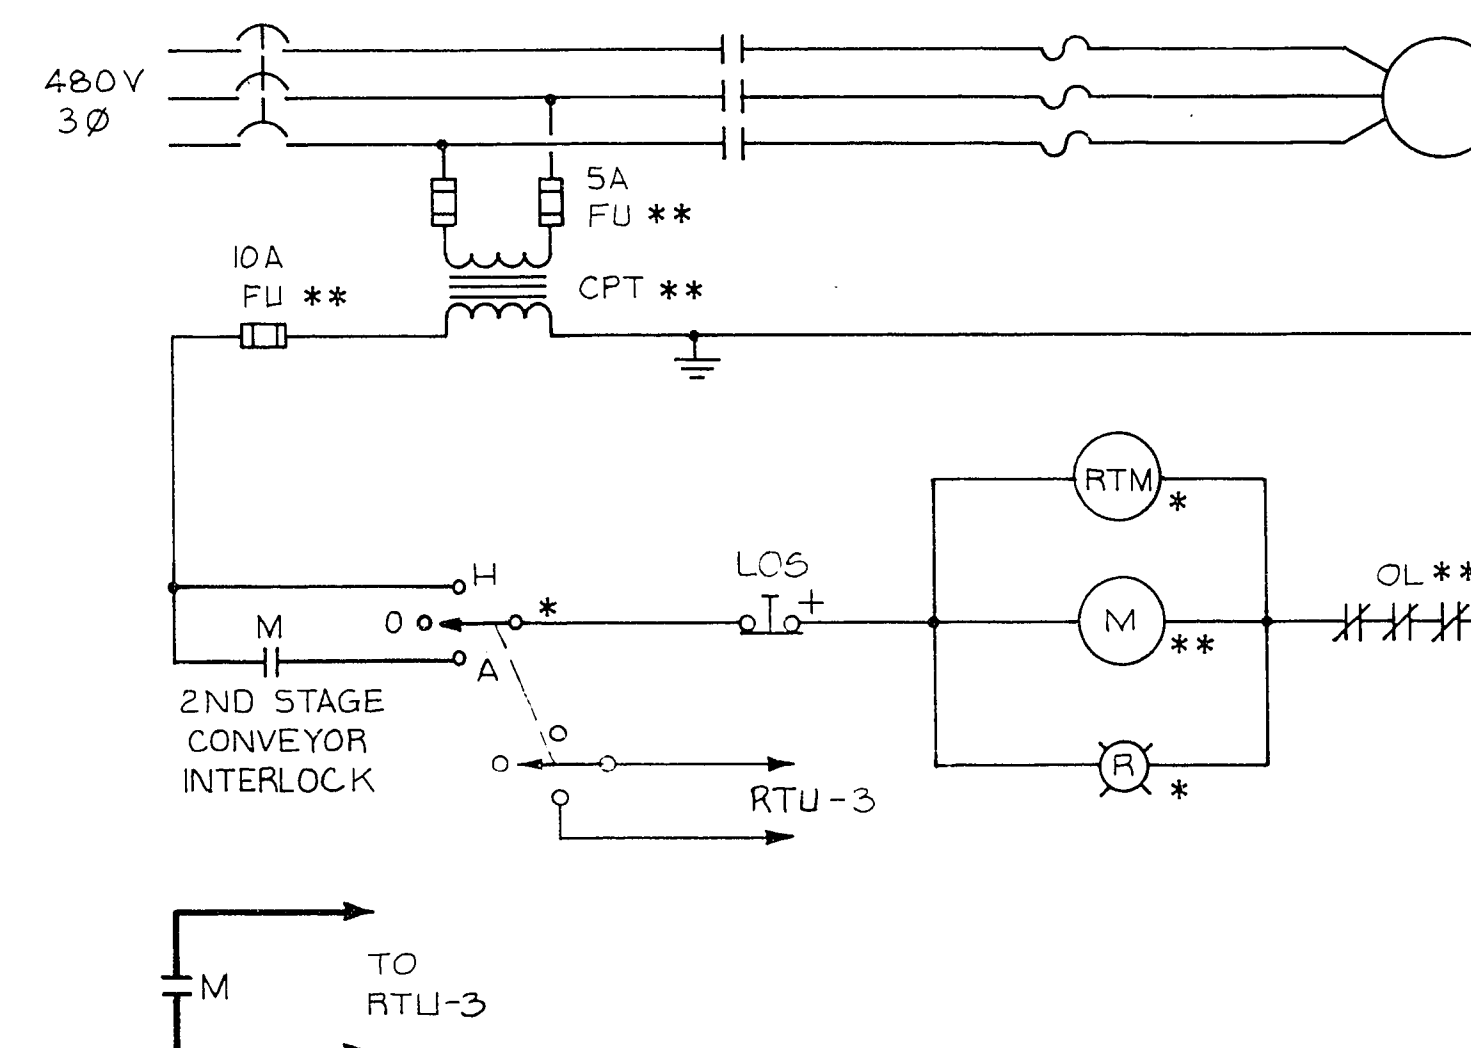

TYPICAL FOR GRIT CONVEYOR

(1st STAGE) GS 3-1, 4-1

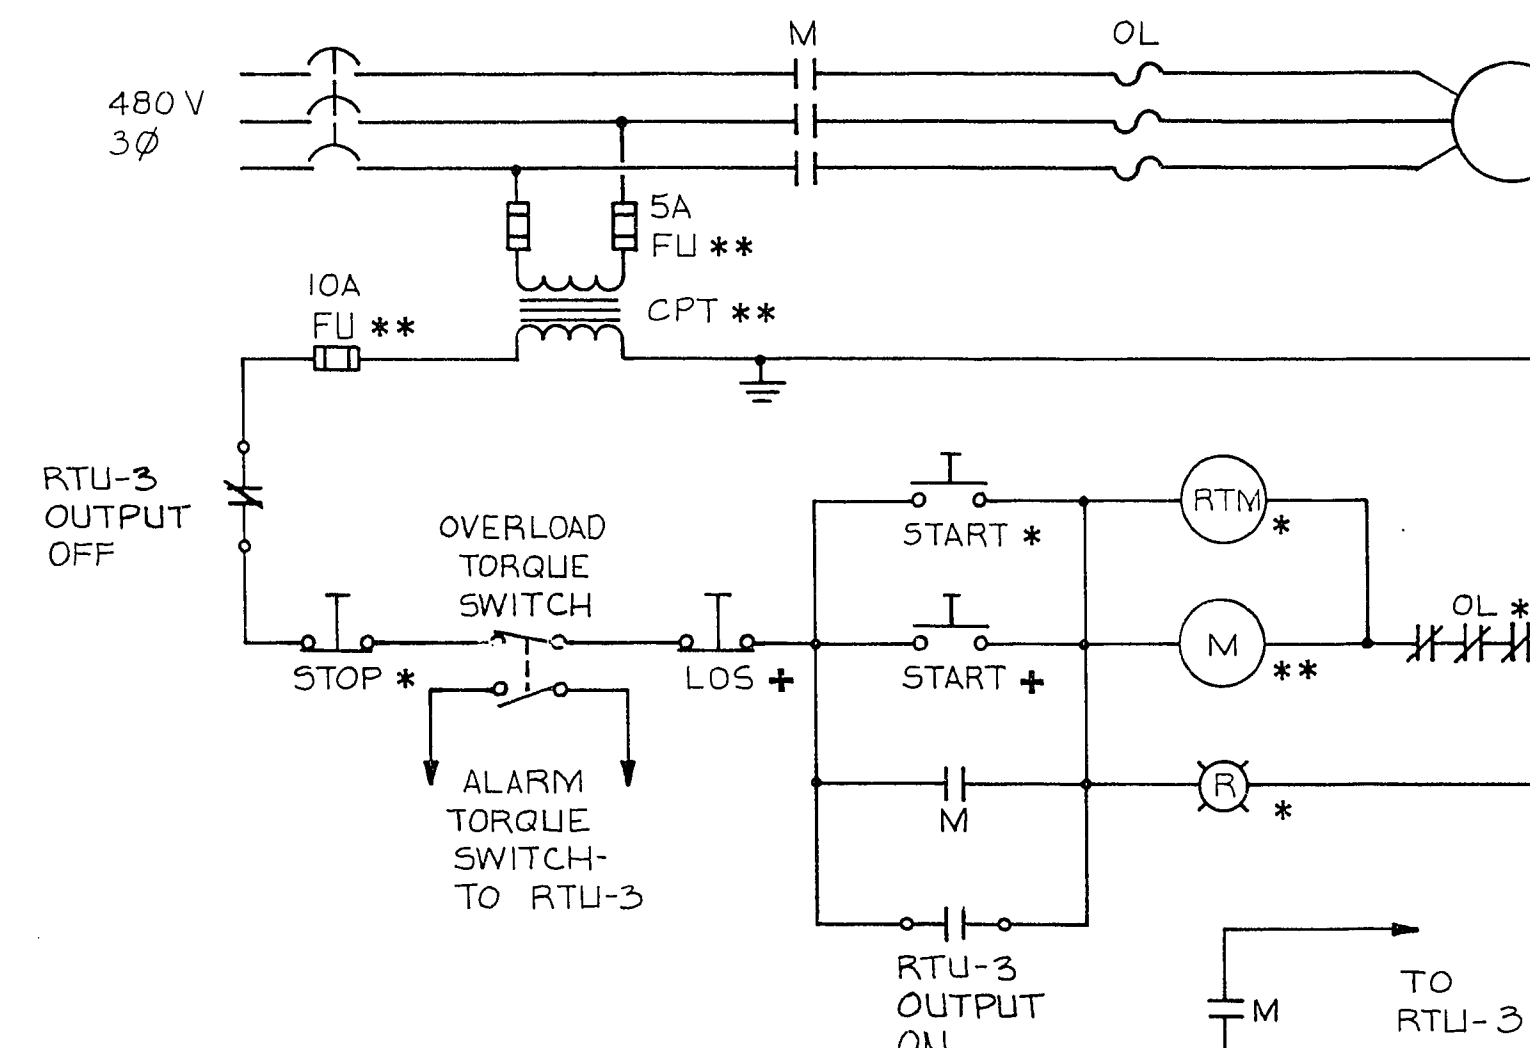

TYPICAL FOR GRIT COLLECTOR & SLUDGE THICKENER DRIVE

GC 3-1, 4-1
ST 3-1, 4-1

LOCATOR LEGEND

- * LOCATED ON STARTER COVER
- ** LOCATED INSIDE STARTER
- + LOCATED IN FIELD

CULP/WESNER/CULP

CAMERON PARK, CALIFORNIA
SANTA ANA, CALIFORNIA DENVER, COLORADO



Job No. 740.11
Designed by WFE
Drawn by GKS
Checked by DJR
Approved by DAD
Date 12/19/88

Revision	Description	Date
1	REDESIGNED ACCORDING TO CITY OF LAS VEGAS EXPANSION	12/19/88

City of Las Vegas
WASTEWATER TREATMENT PLANT
Main Plant Expansion
Contract No. 1

ELECTRICAL

CONTROL SCHEMATICS - 1

Sheet 160
of 164
E-13

6-1-160 311.21