
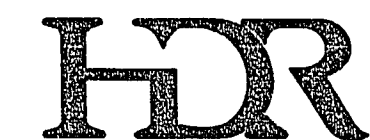
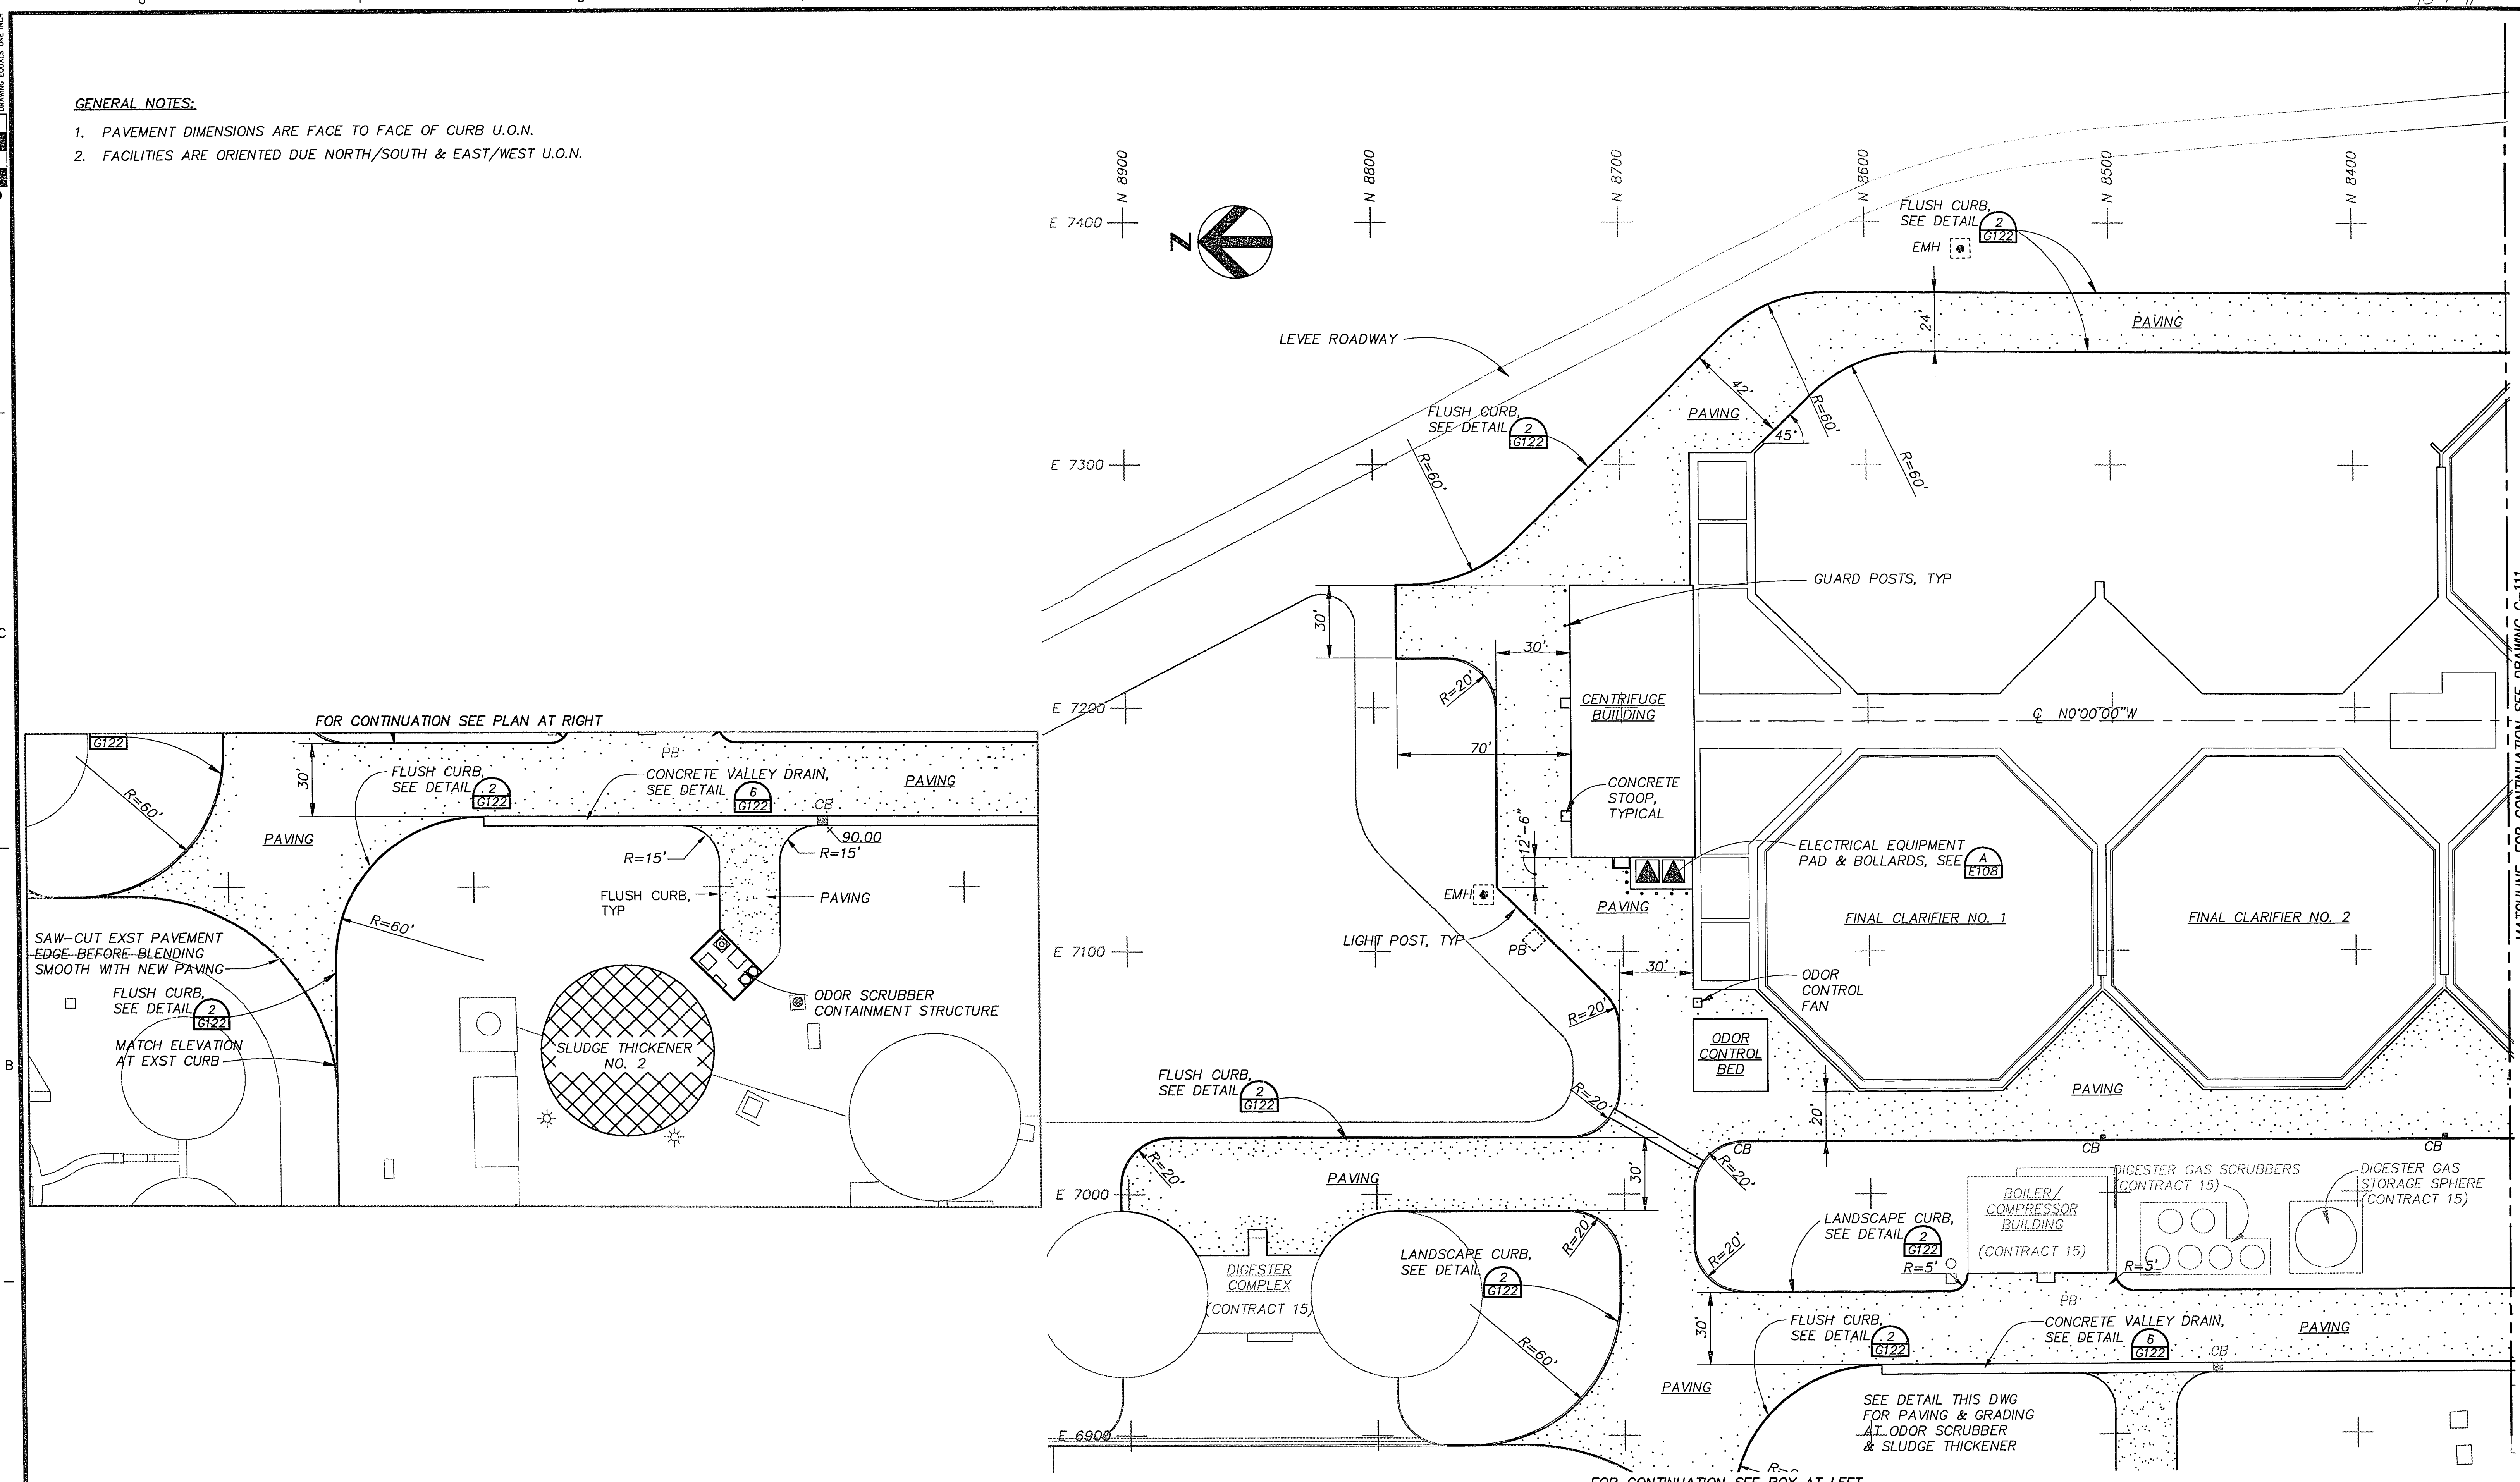


**GENERAL NOTES:**

1. PAVEMENT DIMENSIONS ARE FACE TO FACE OF CURB U.O.N.
2. FACILITIES ARE ORIENTED DUE NORTH/SOUTH & EAST/WEST U.O.N.

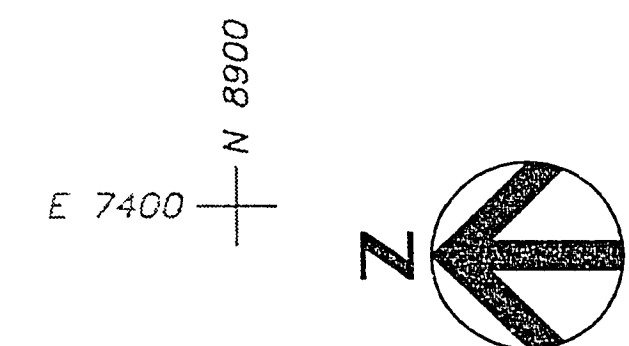

HDR Engineering, Inc.

Issue No.	Description	Date	Drawn	Chkd.	Resp. Engr.	Proj. Mgr.
2	CORRECTED ACCORDING TO CONSTRUCTION RECORD	1/95	RRL	EFH	MJH	JJC
1	CHANGE PROPOSAL REQUEST #6	9/3/92	PFB	GPC	GPC	JJC
0	ISSUED FOR CONSTRUCTION	8/20/92	RRL	GPC	GPC	JJC

Project Manager <b>JOHN J. CHUEH</b>	Architect <b>G. COSTAN</b>	Electrical	Mechanical	Structural	Drawn By <b>P. BUKOWSKI</b>
---	-------------------------------	------------	------------	------------	--------------------------------

*City of Las Vegas*  
**Water Pollution Control Facility  
 Nitrification / Filtration Facilities**  
**Contract 17  
 NITRIFICATION COMPLEX**

**PAVING PLAN**

Date SEPTEMBER 1992	Project No. 00120-084-141	Drawing No. G-110	Issue 2
Scale 1" = 30'			