



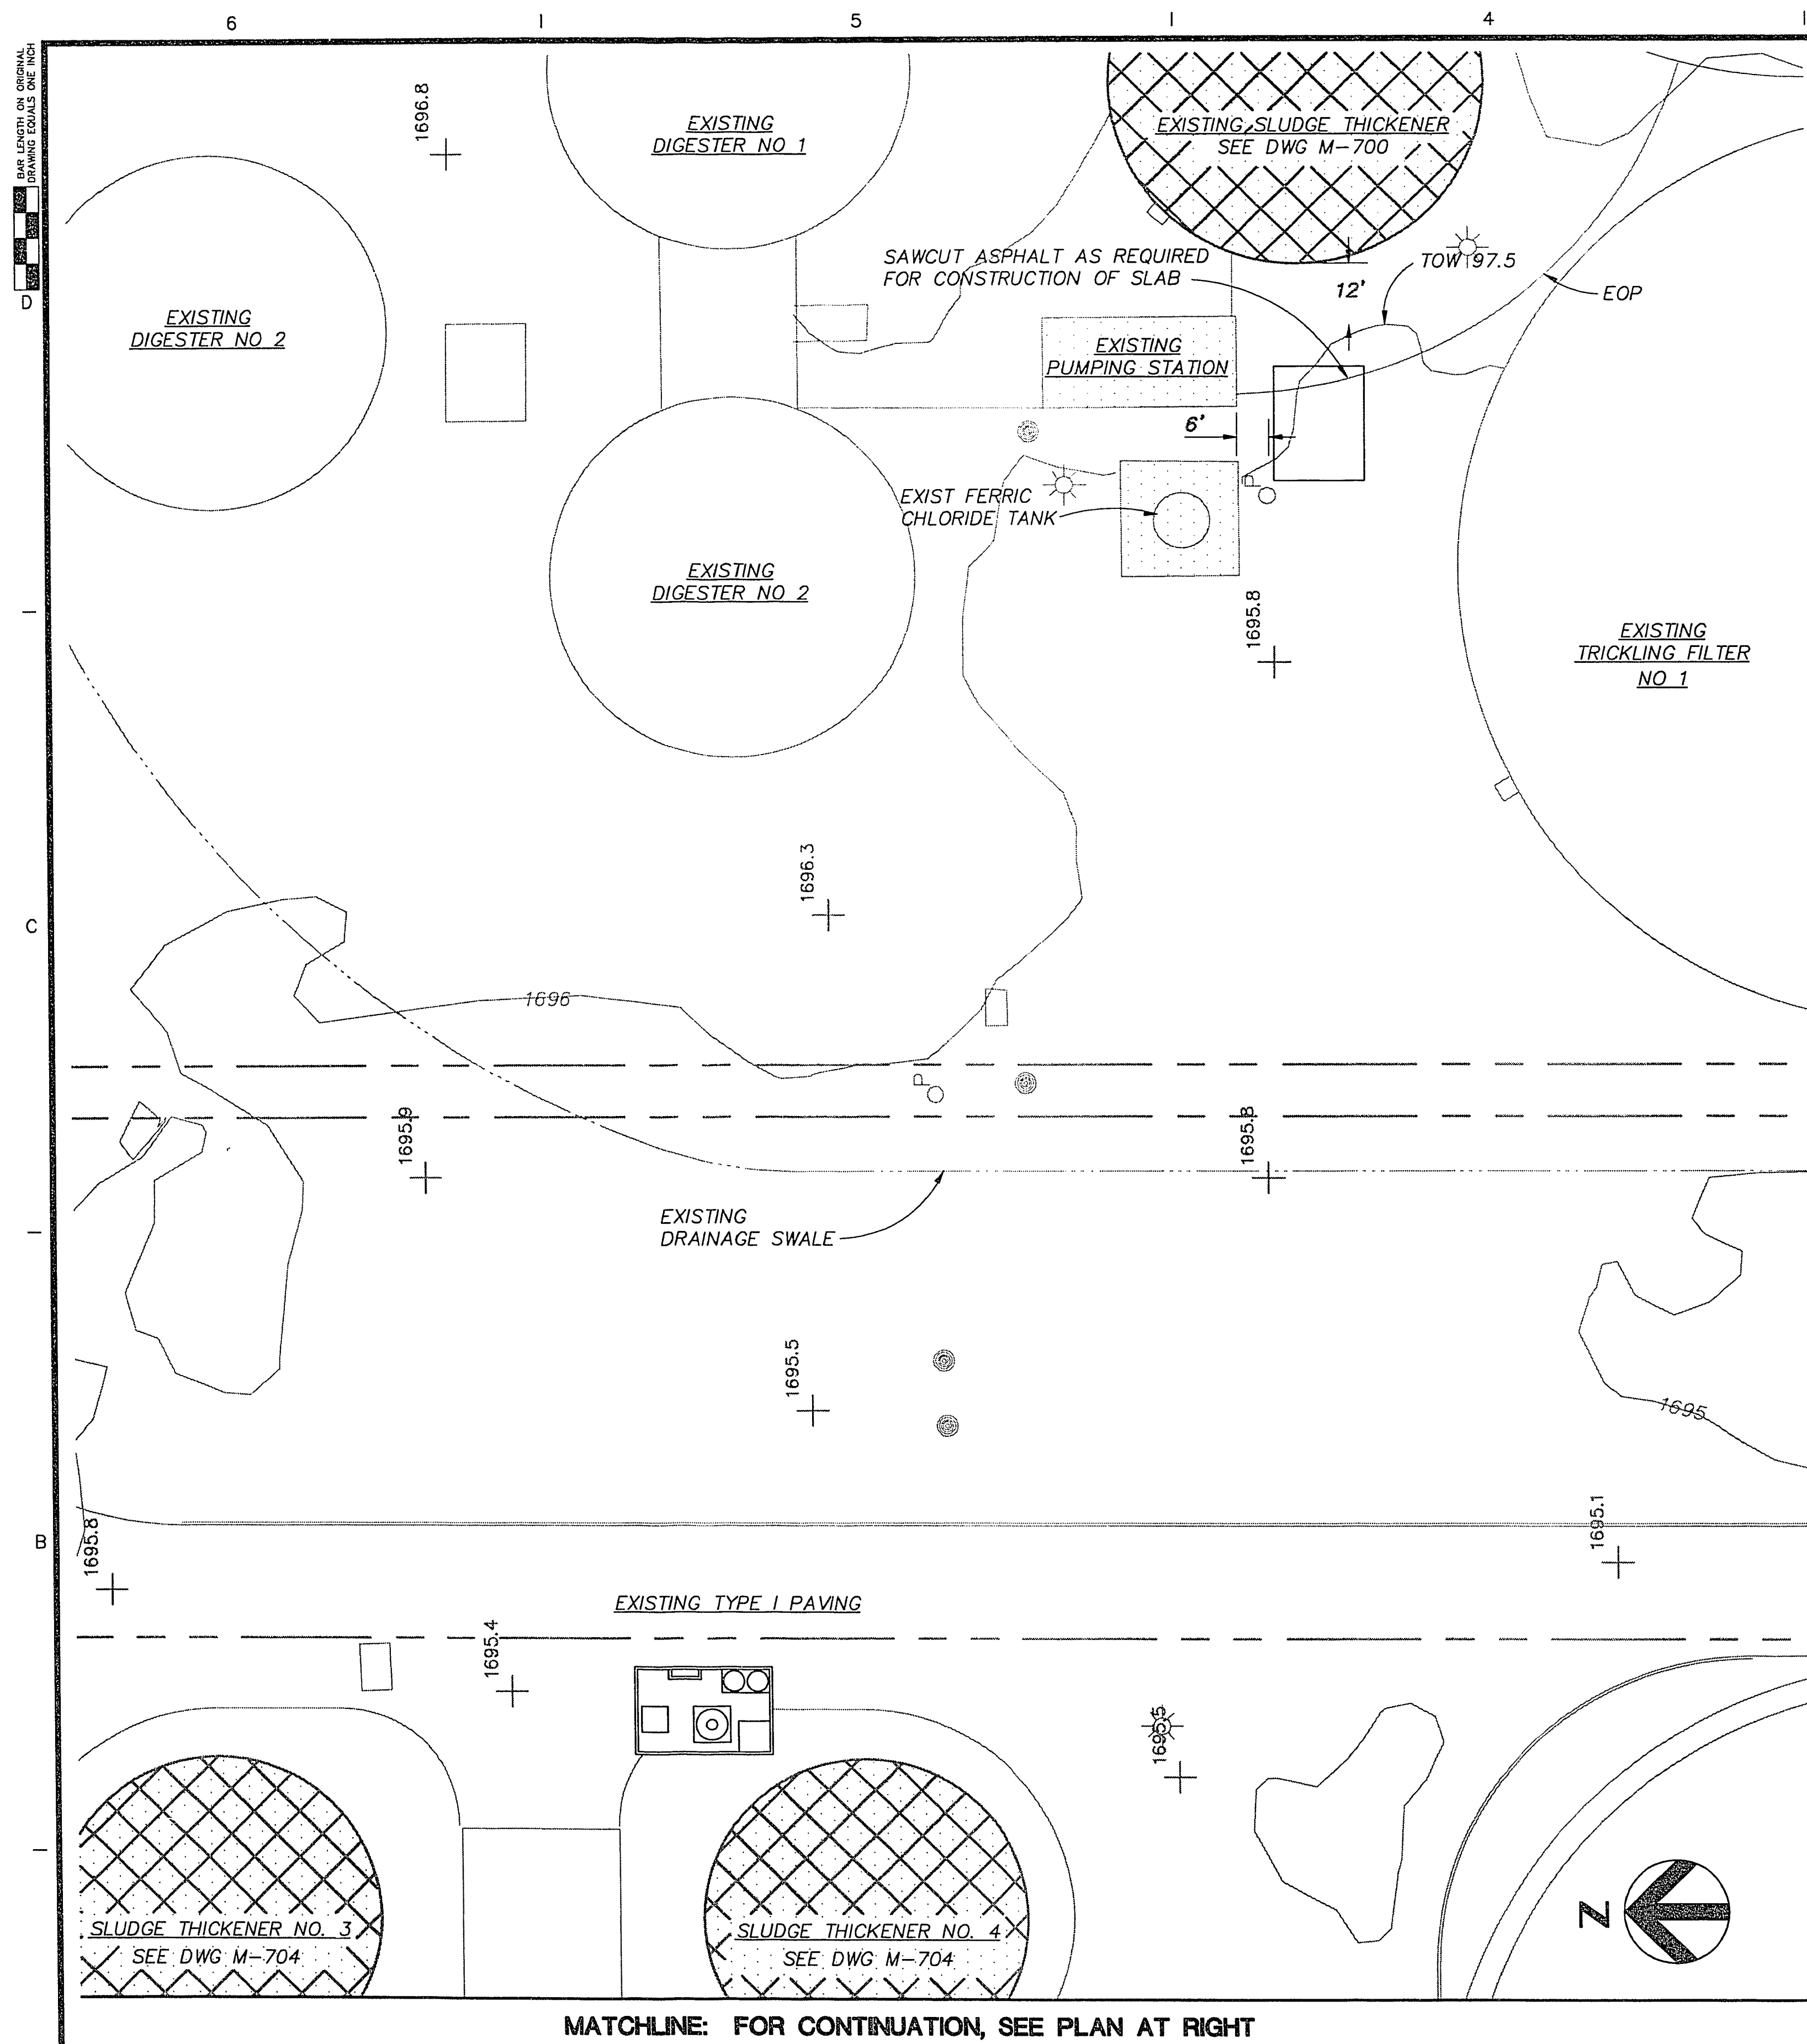


PLAN AT PLANT NO. 1

1"=20'

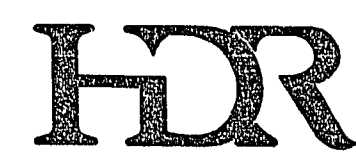

HDR Engineering, Inc.

Issue No.	Description	Date	Drawn	Chkd.	Resp. Engr.	Proj. Mgr.
2	CORRECTED ACCORDING TO CONSTRUCTION RECORD	1/95	RRL	EFH	MJH	JJC
1	CHANGE PROPOSAL REQUEST #6	9/3/92	PFB	GPC	GPC	JJC
0	ISSUED FOR CONSTRUCTION	8/20/92	FDV	GPC	GPC	JJC

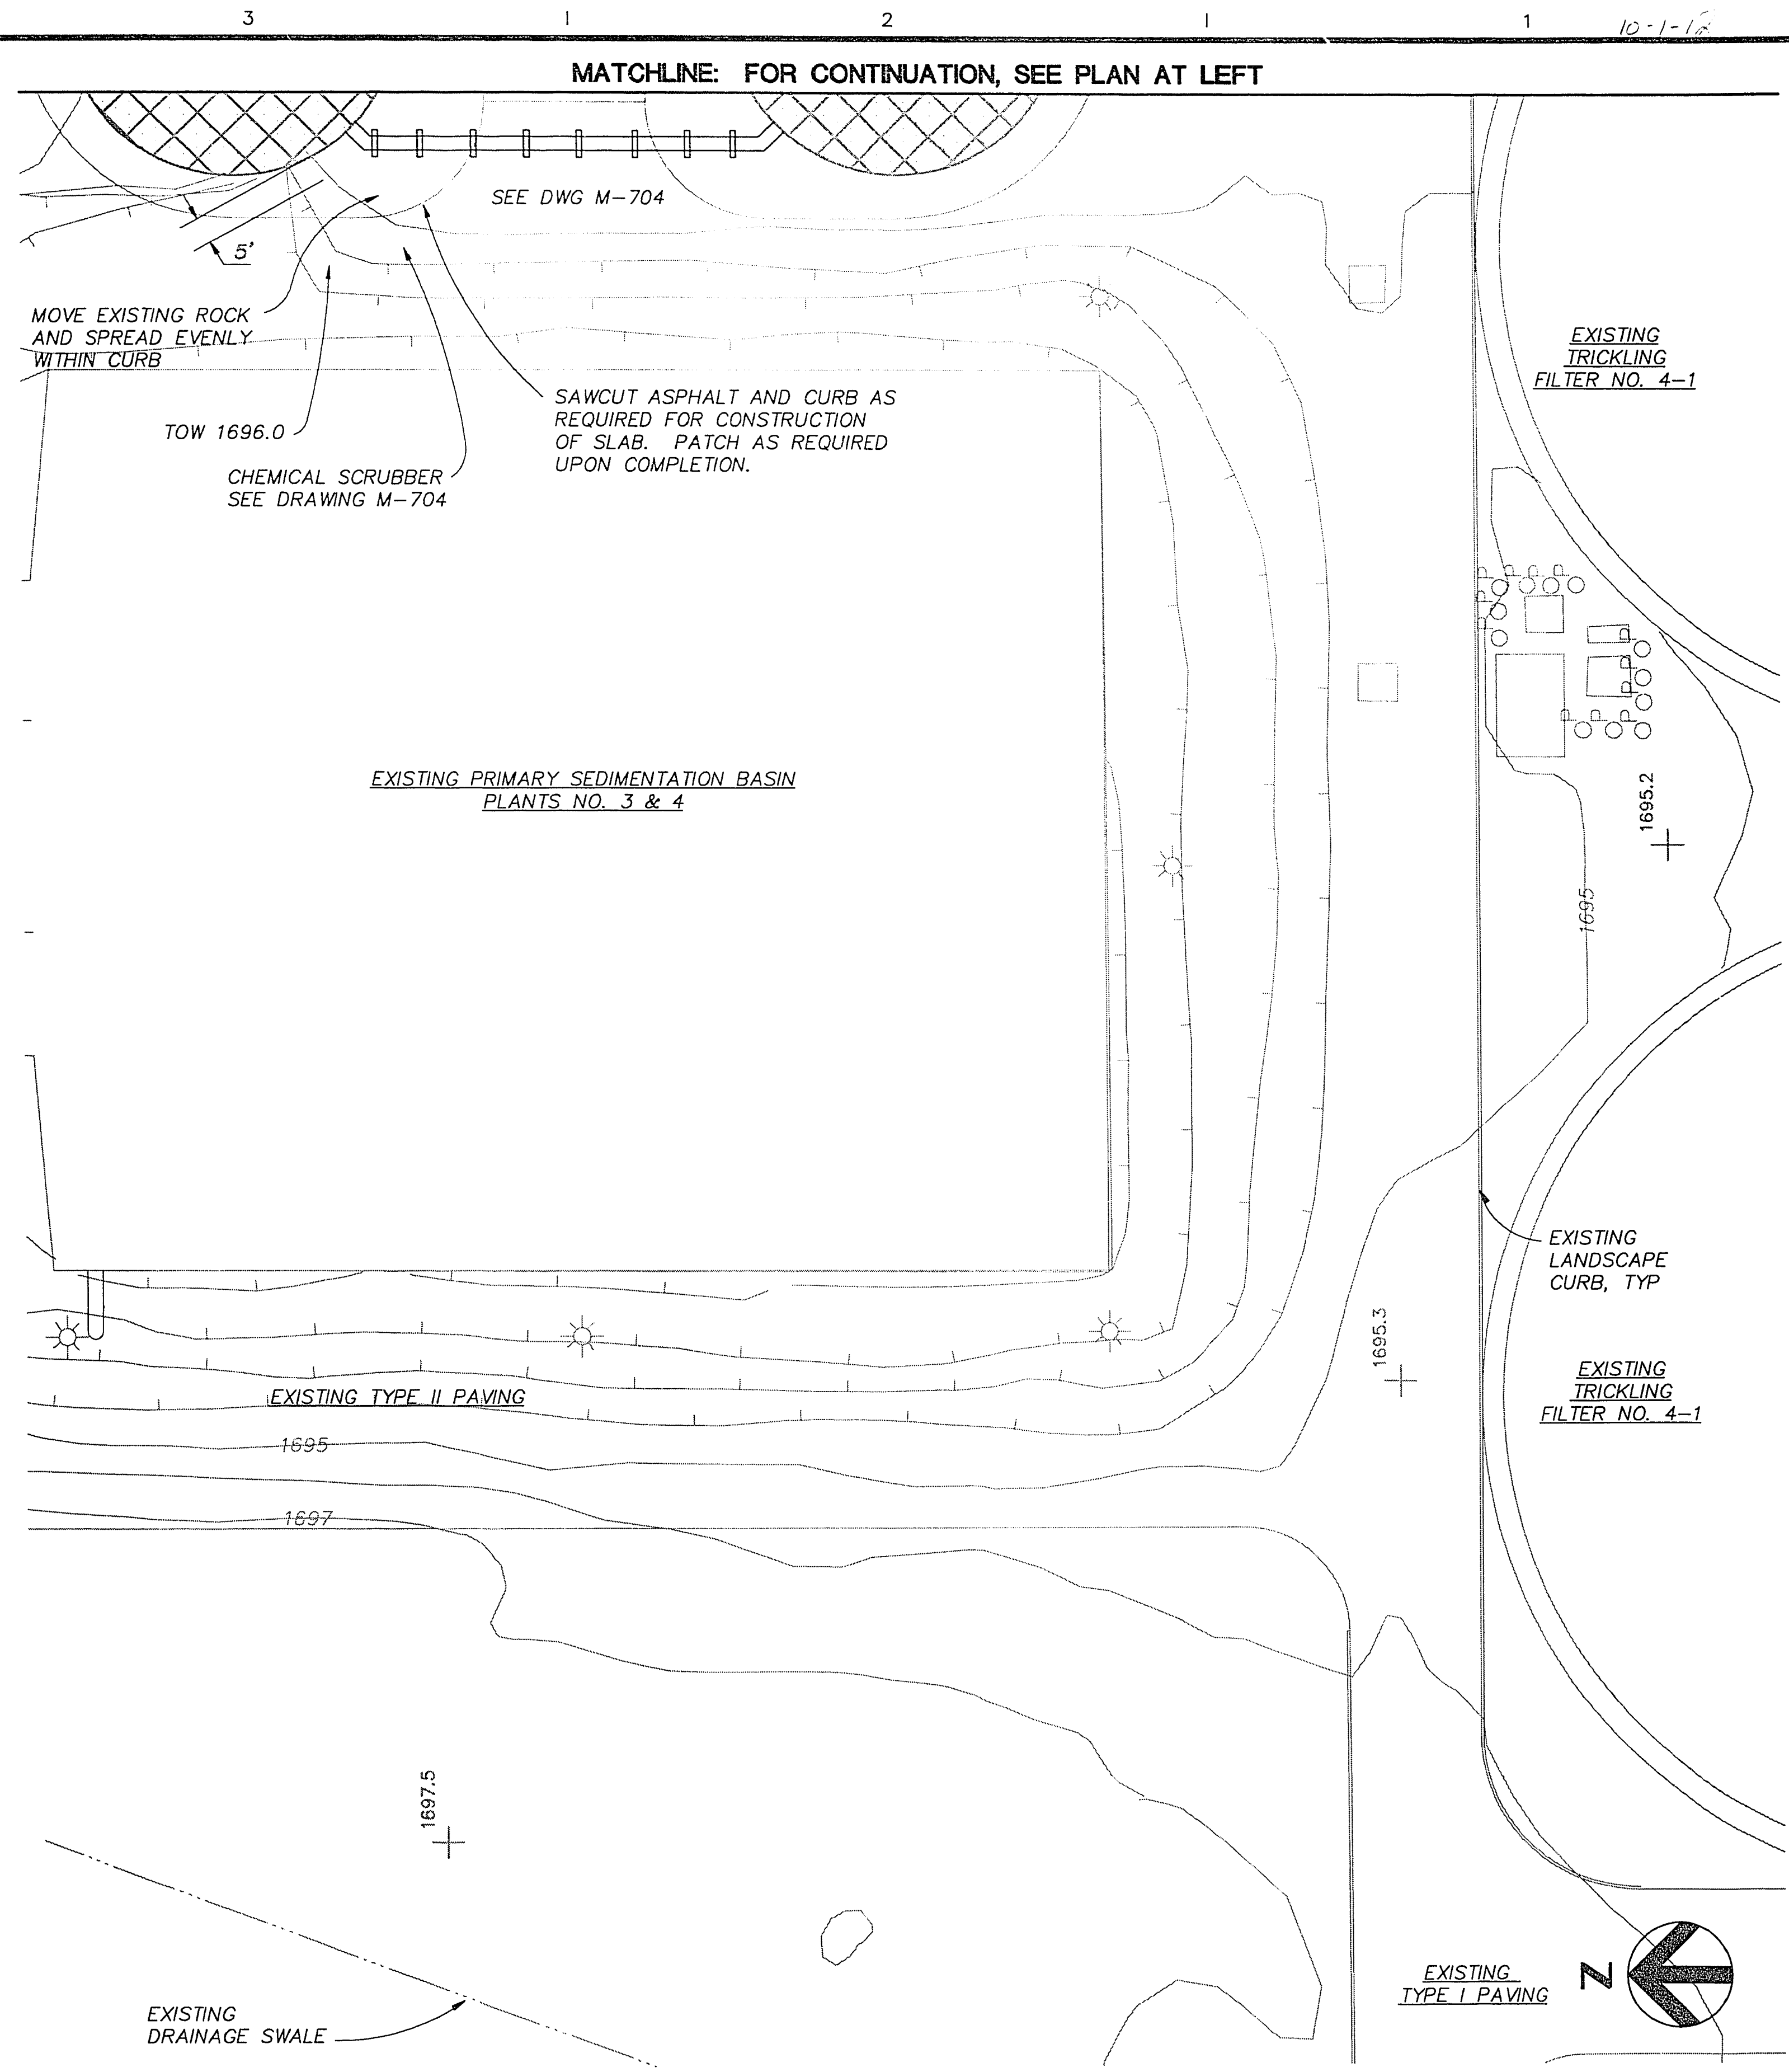

PLAN AT PLANTS NO. 3 & 4

1"=20'

Project Manager	JOHN J. CHUEH
Architect	P. COCKRELL
Civil	G. COSTAN
Electrical	P. COCKRELL
Drawn By	P. BUKOWSKI

City of Las Vegas
Water Pollution Control Facility
Nitrification / Filtration Facilities
Contract 17
NITRIFICATION COMPLEX

GRADING & PAVING PLANS

Date	SEPTEMBER 1992	Project No.	00120-084-141	Drawing No.	G-110A	Issue	2
Scale	1"=20'						