



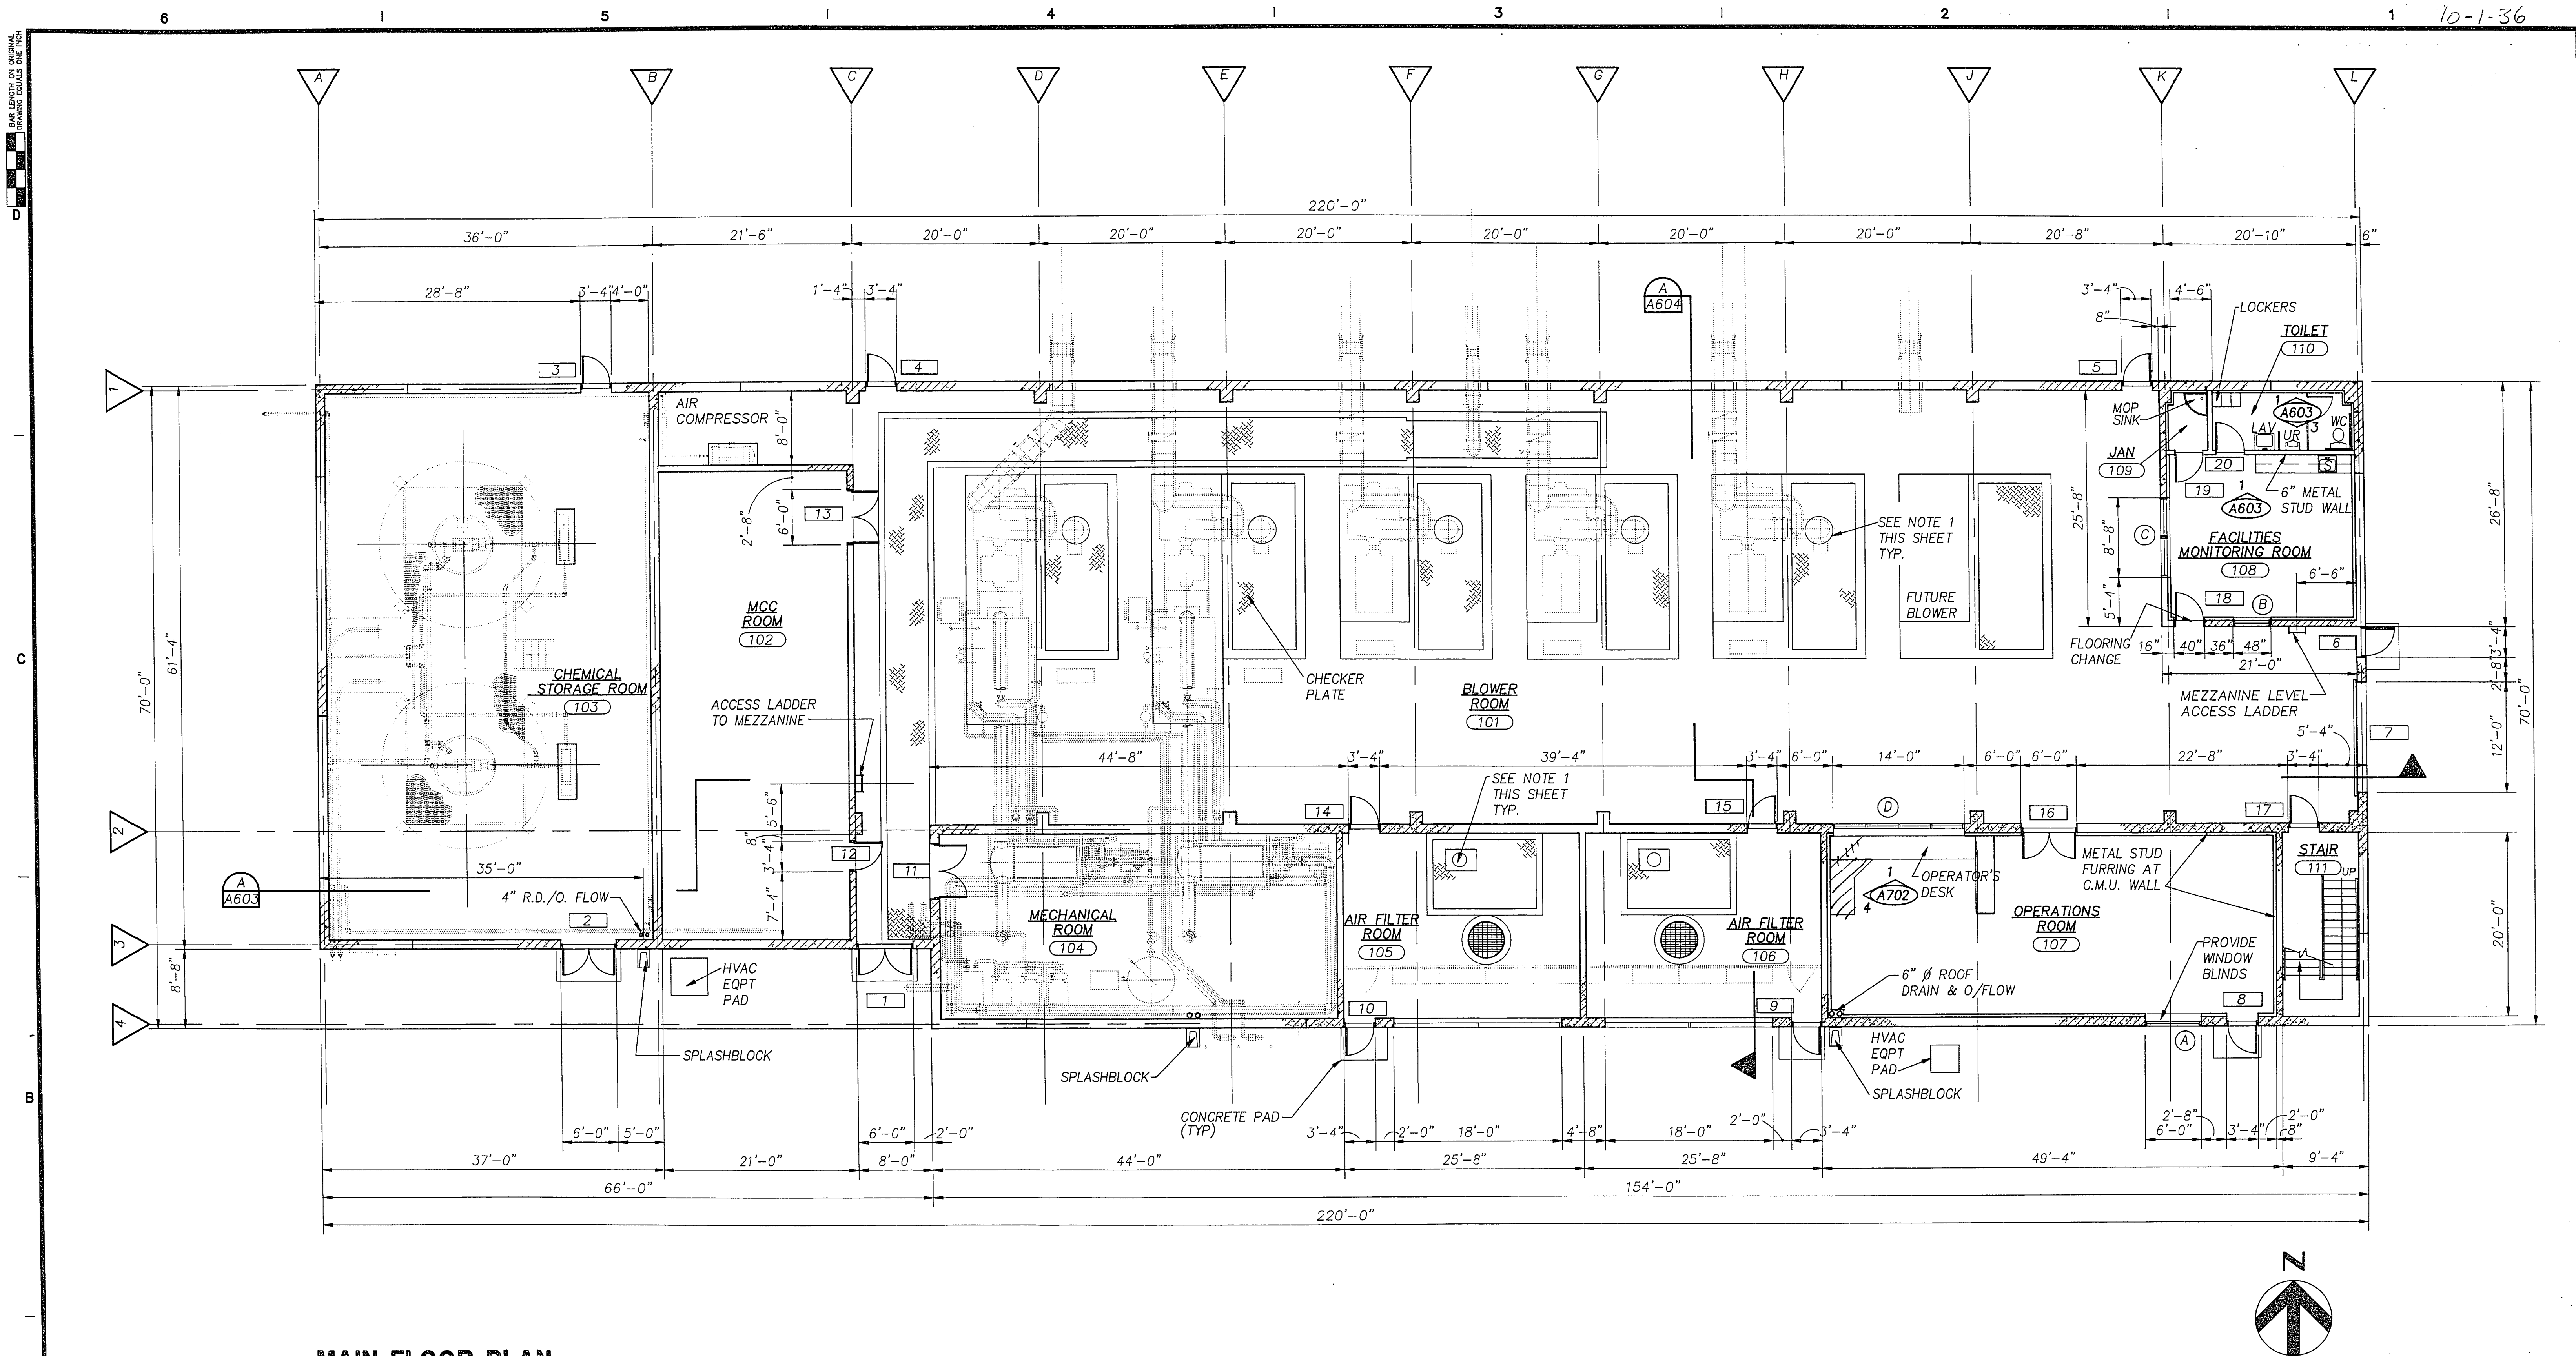

MAIN FLOOR PLAN

NOTES:

1. CONTRACTOR TO REVIEW EQUIPMENT SHOP DRAWINGS AND SIZE GRATING OPENINGS REQUIRED TO FIT THE BONNET EXTENSION OR PIPING. MAXIMUM OPENING SHALL BE O.D. OF THE PIPE PLUS 1/2".

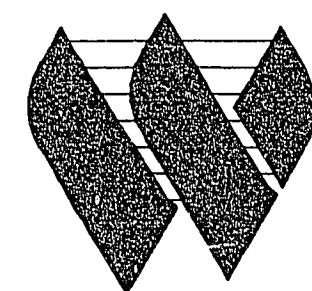


G.C. WALLACE, INC.
Engineering/Architecture



HDR Engineering, Inc.

Issue No.	Description	Date	Drawn	Checked	Reviewed	Project Mgr.
1	CORRECTED ACCORDING TO CONSTRUCTION RECORD	1/95	RRL	EFH	MJH	JJC
0	ISSUED FOR CONSTRUCTION	8/20/92	DCL	DSD	DSD	JJC

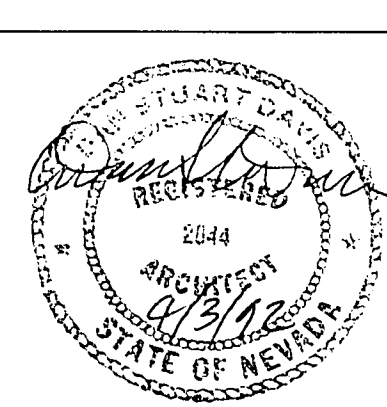

Project Manager	JOHN J. CHUEH
Architect	D. DAVIS
Civil	
Electrical	
Mechanical	
Structural	
Drawn By	D. LEEHAN

City of Las Vegas
**Water Pollution Control Facility
Nitrification / Filtration Facilities**
**Contract 17
NITRIFICATION COMPLEX**

**BLOWER BUILDING
MAIN FLOOR PLAN**

Date	APRIL 1992	Project No.	00120-084-141	Drawing No.	A-600	Issue	1
Scale	1/8" = 1'-0"						