




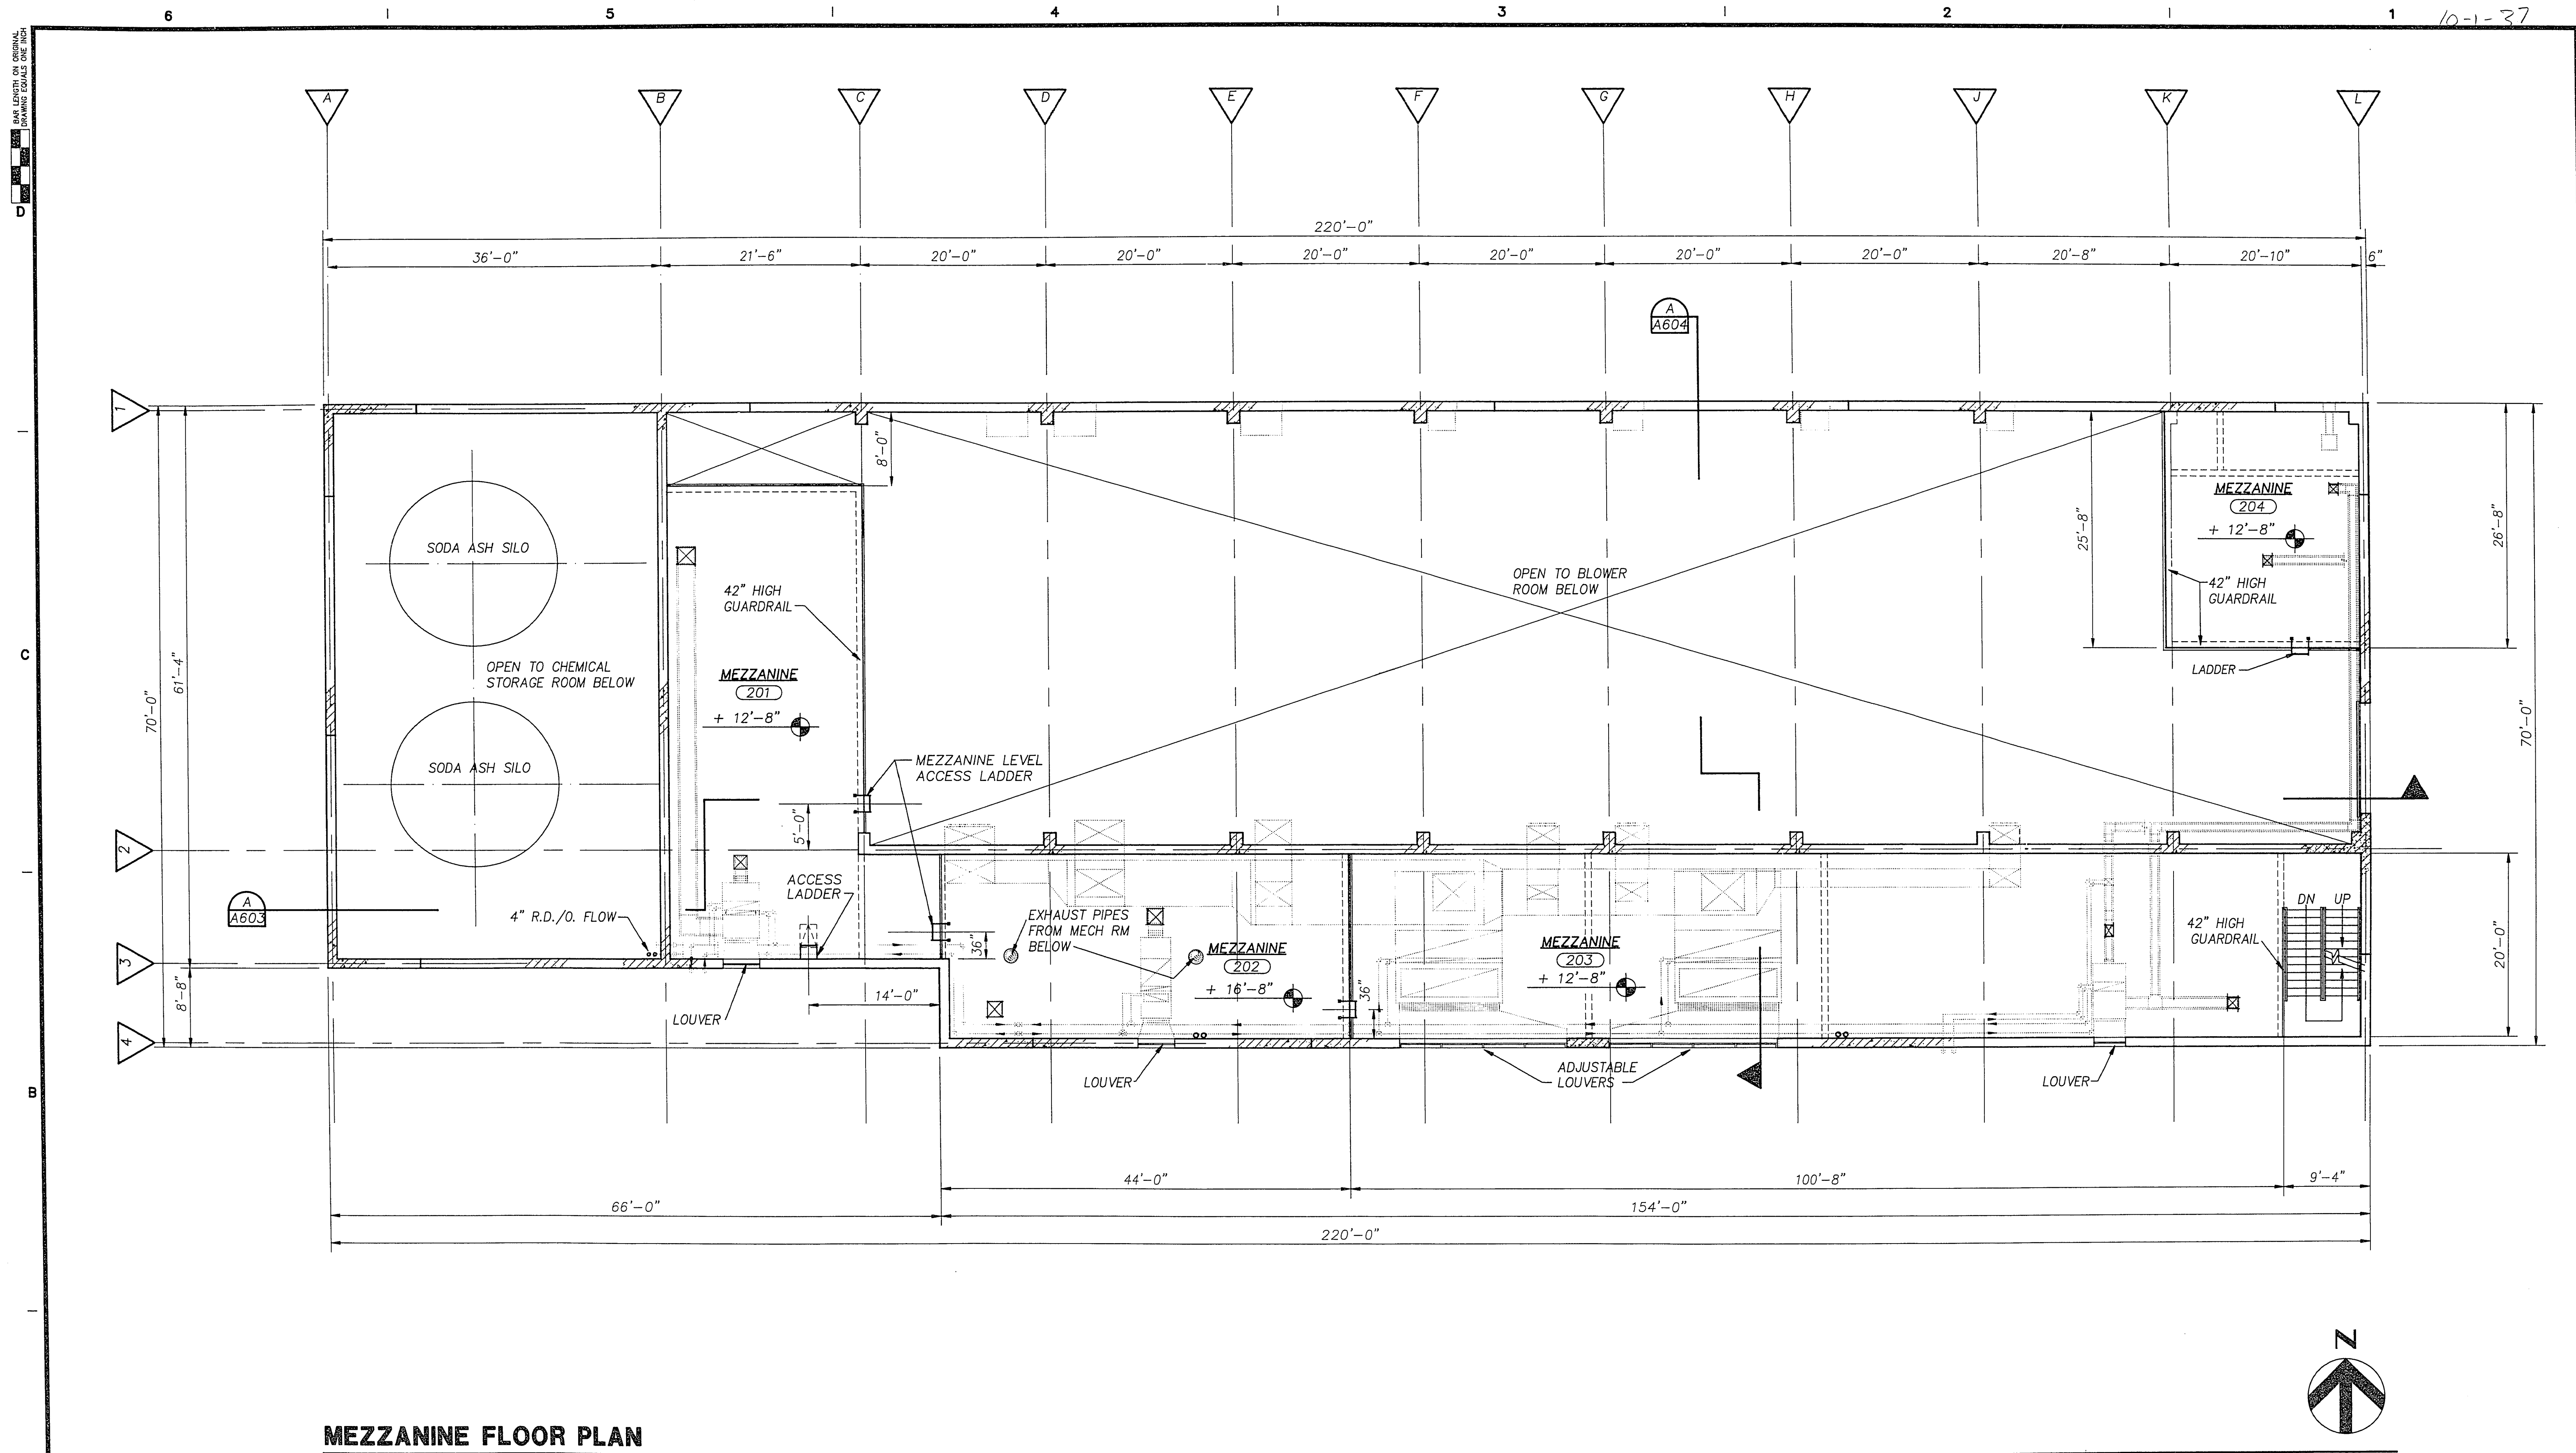

MEZZANINE FLOOR PLAN

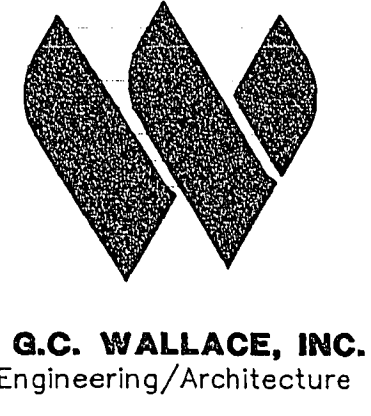

1	CORRECTED ACCORDING TO CONSTRUCTION RECORD	1/95	RRL	EFH	MJH	JJC
0	ISSUED FOR CONSTRUCTION	8/20/92	DCL	DSO	DSO	WJC
Issue No.	Description	Date	Drawn	Chkd.	Resp. Engr.	Proj. Mgr.

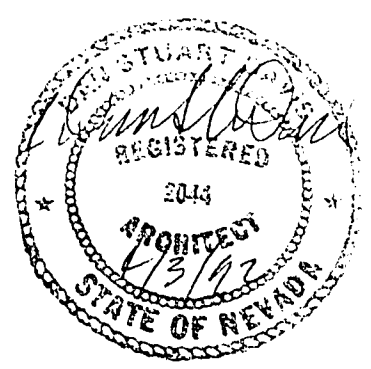

Project Manager	JOHN J. CHUEH
Architect	D. DAVIS
Civil	
Electrical	
Structural	
Drawn By	D. LEEHAN

City of Las Vegas
**Water Pollution Control Facility
 Nitrification / Filtration Facilities**
**Contract 17
 NITRIFICATION COMPLEX**

**BLOWER BUILDING
 MEZZANINE FLOOR PLAN**

Date	APRIL 1992	Project No.	00120-084-141	Drawing No.	A-601	Issue	1
Scale	1/8" = 1'-0"						