




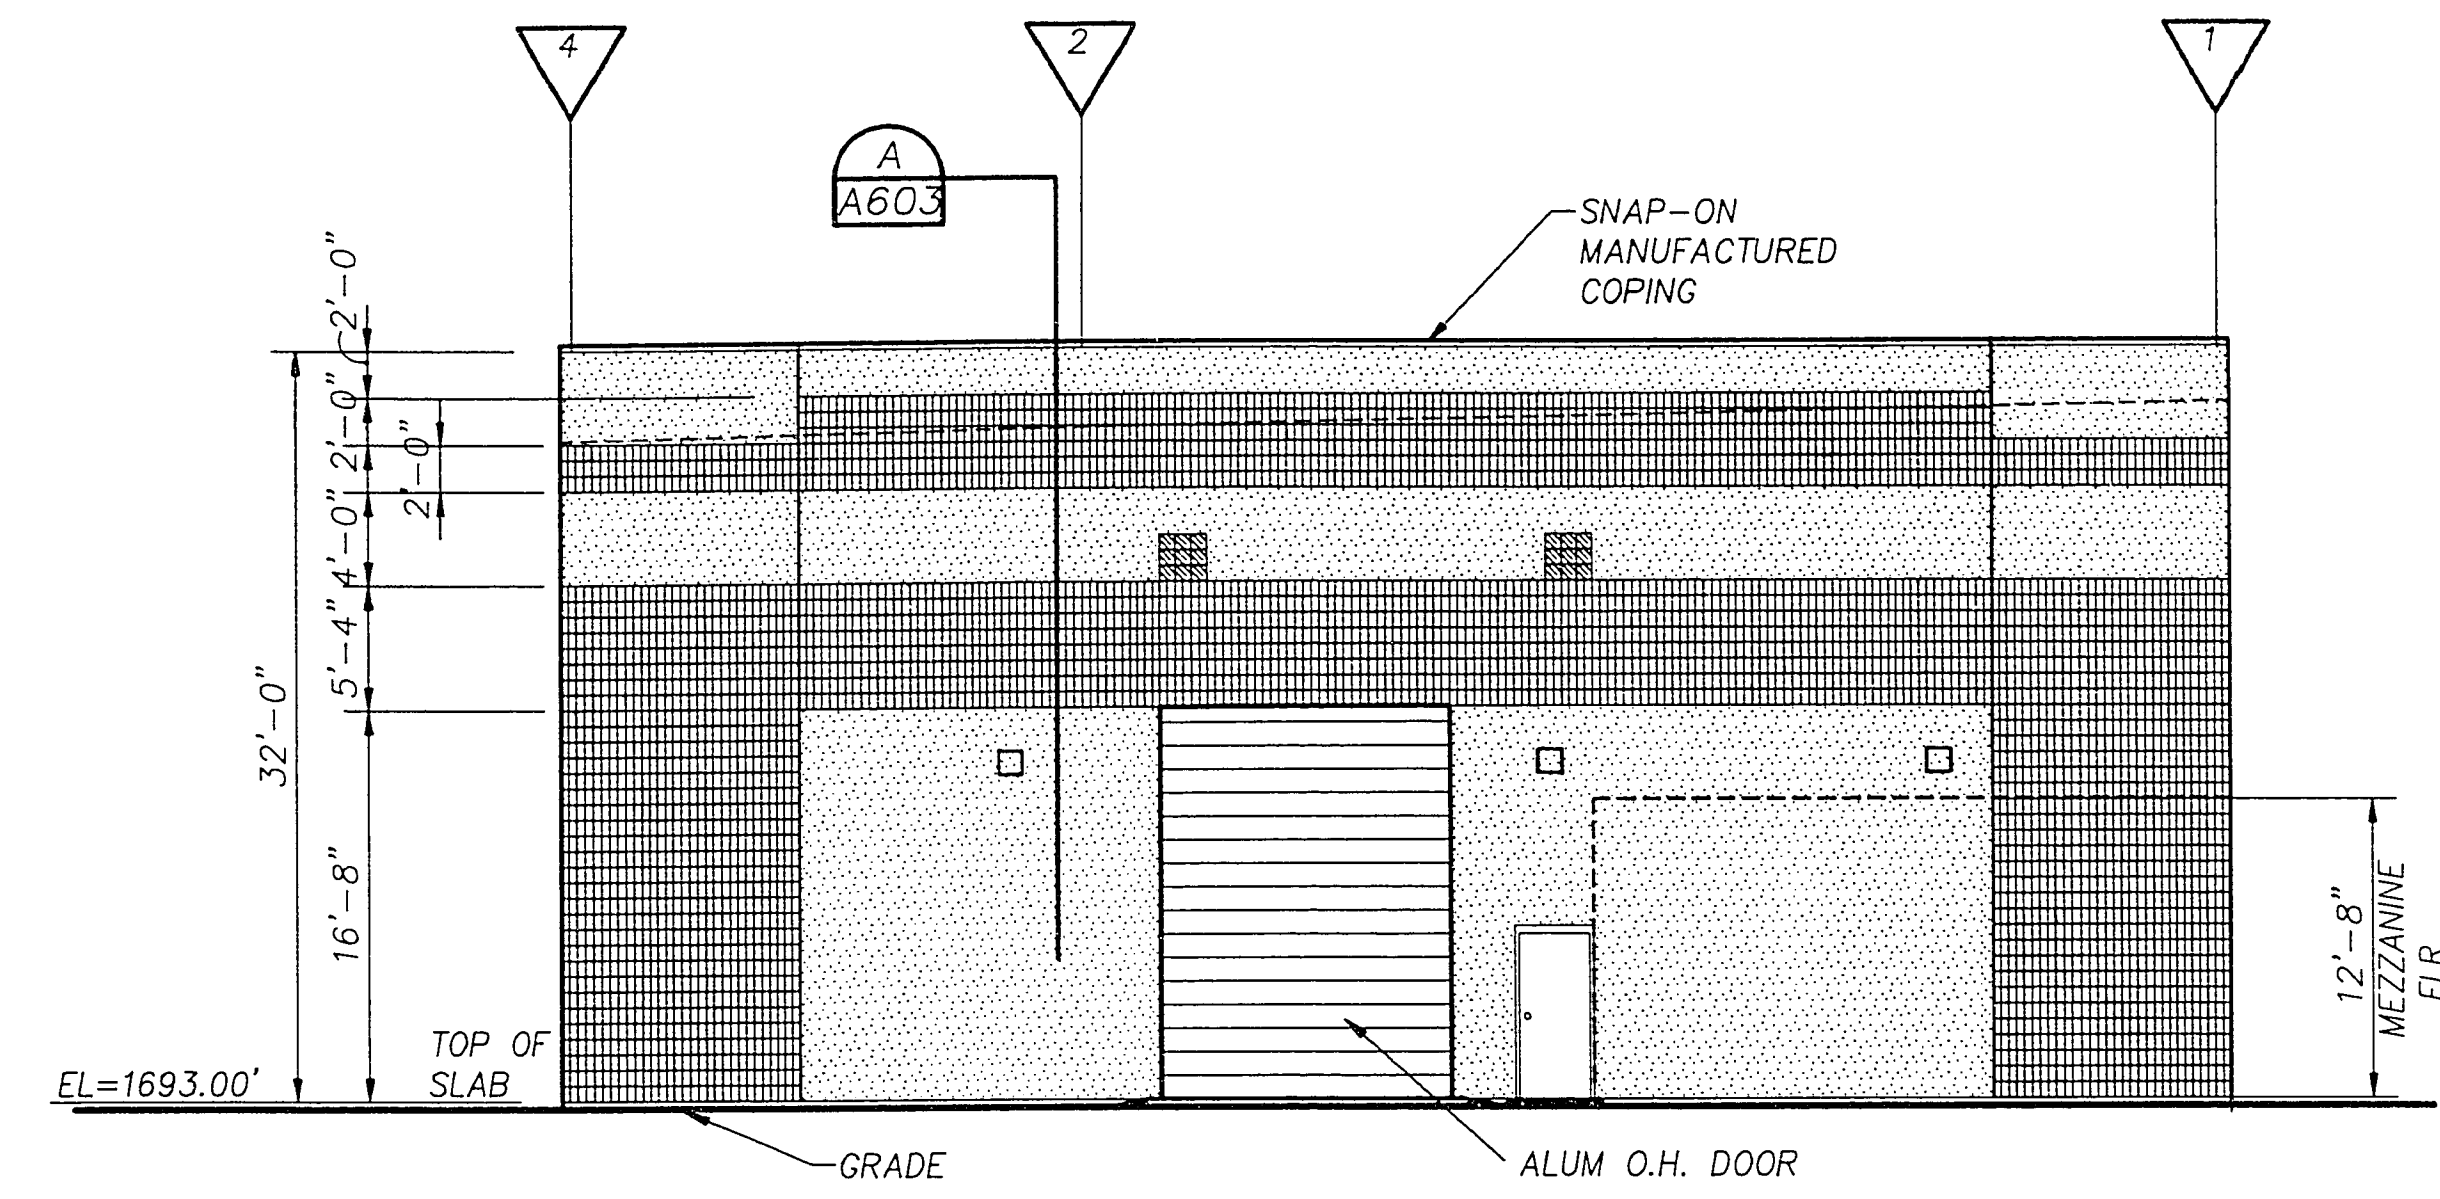


EAST ELEVATION

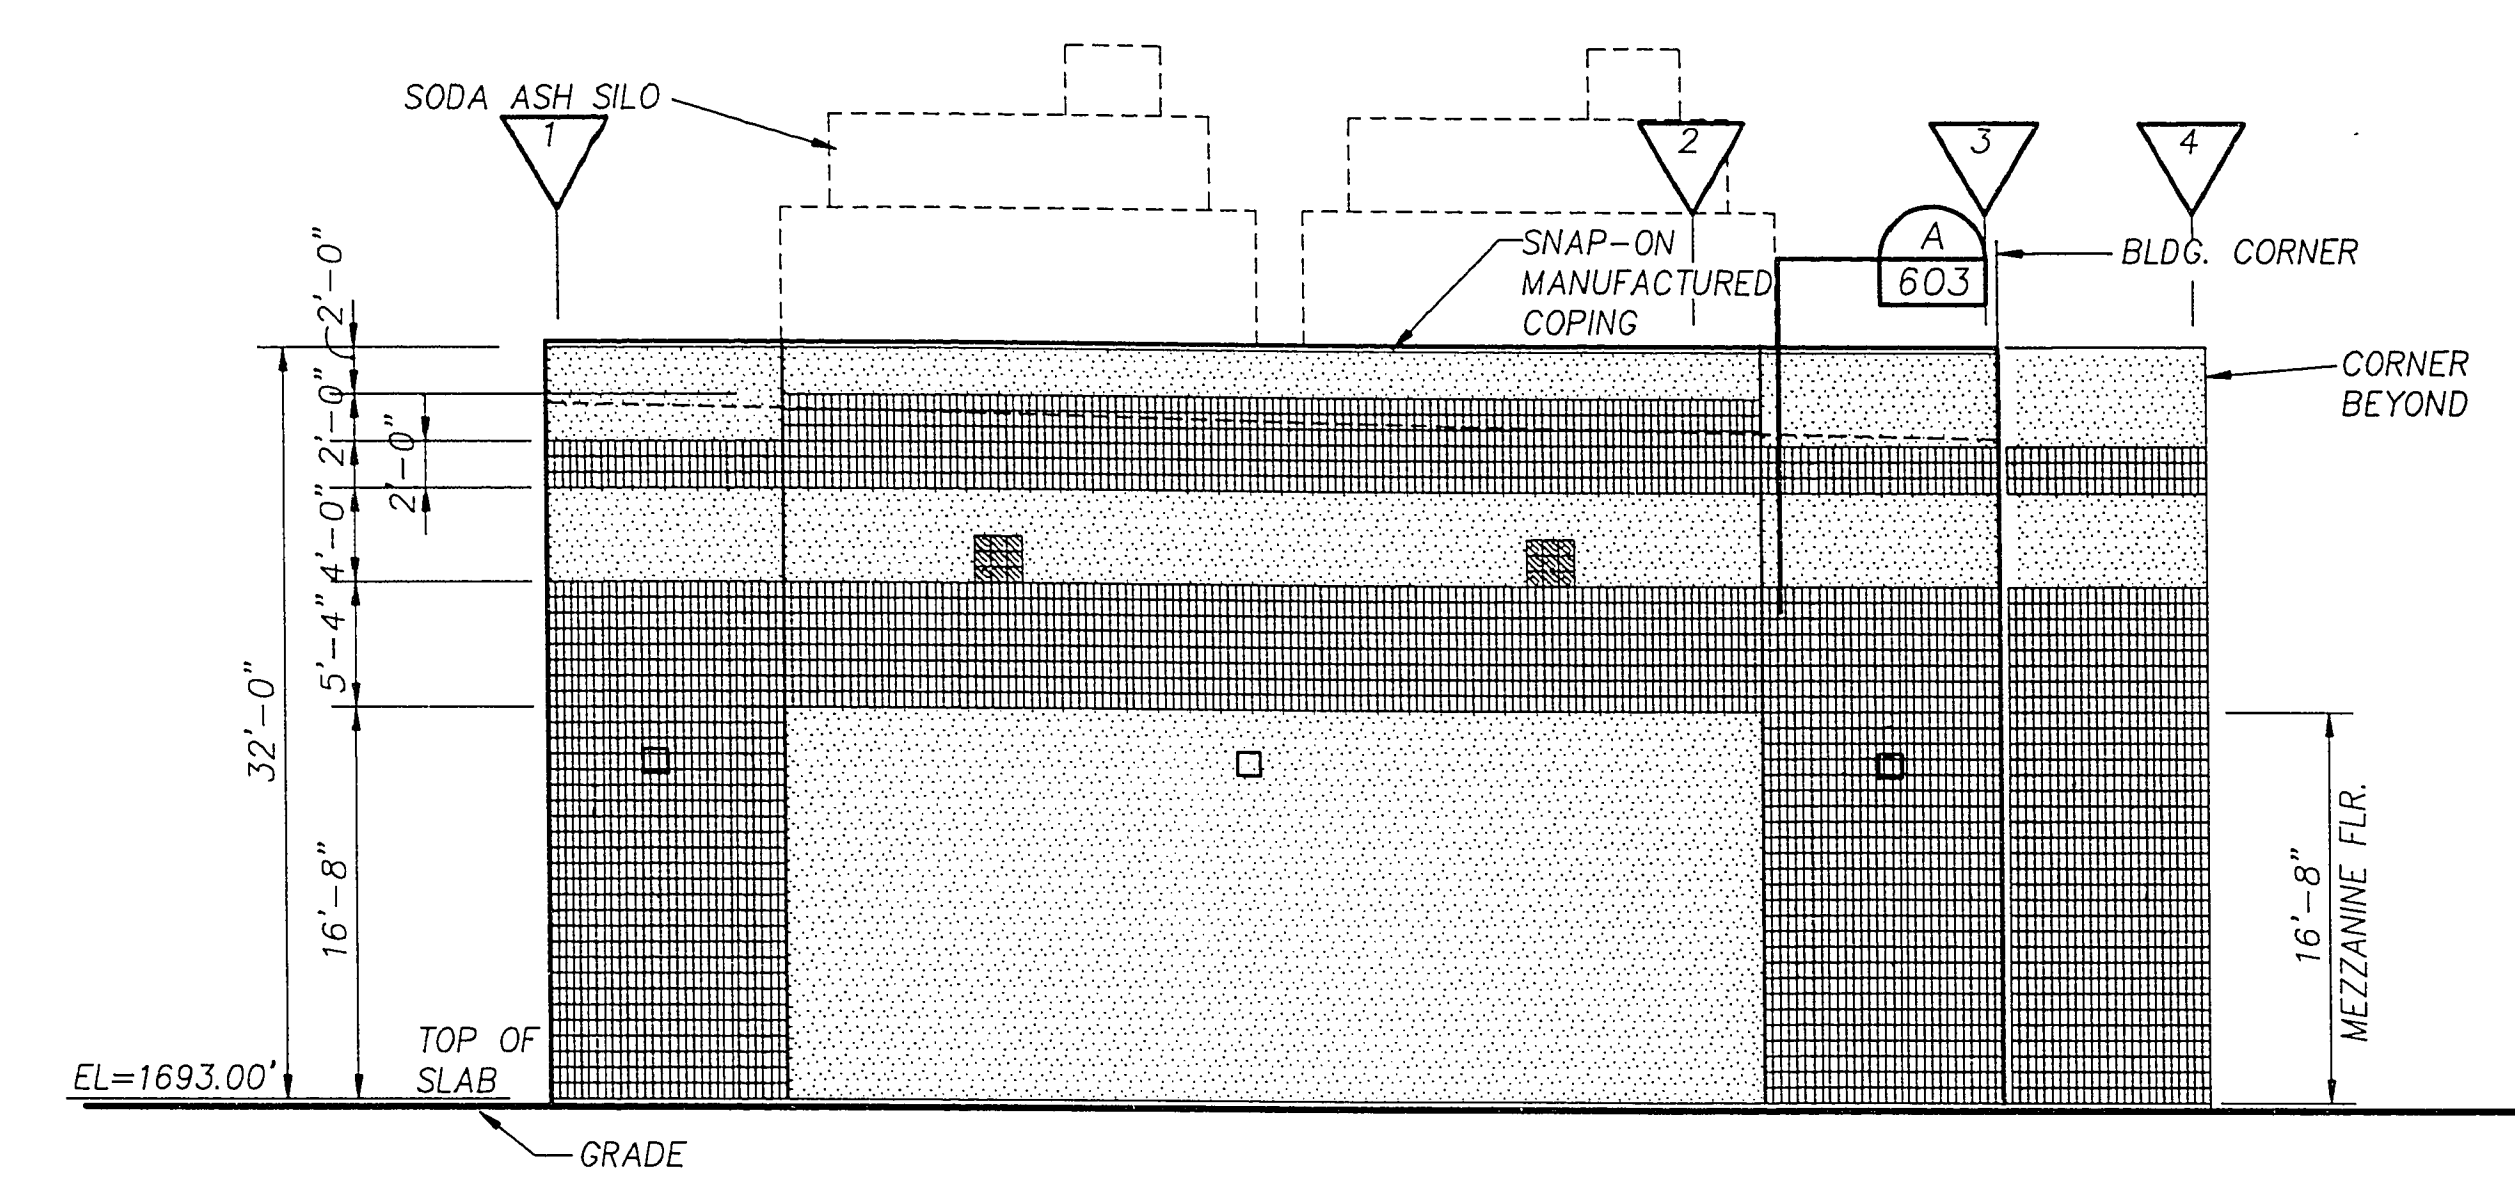


WEST ELEVATION

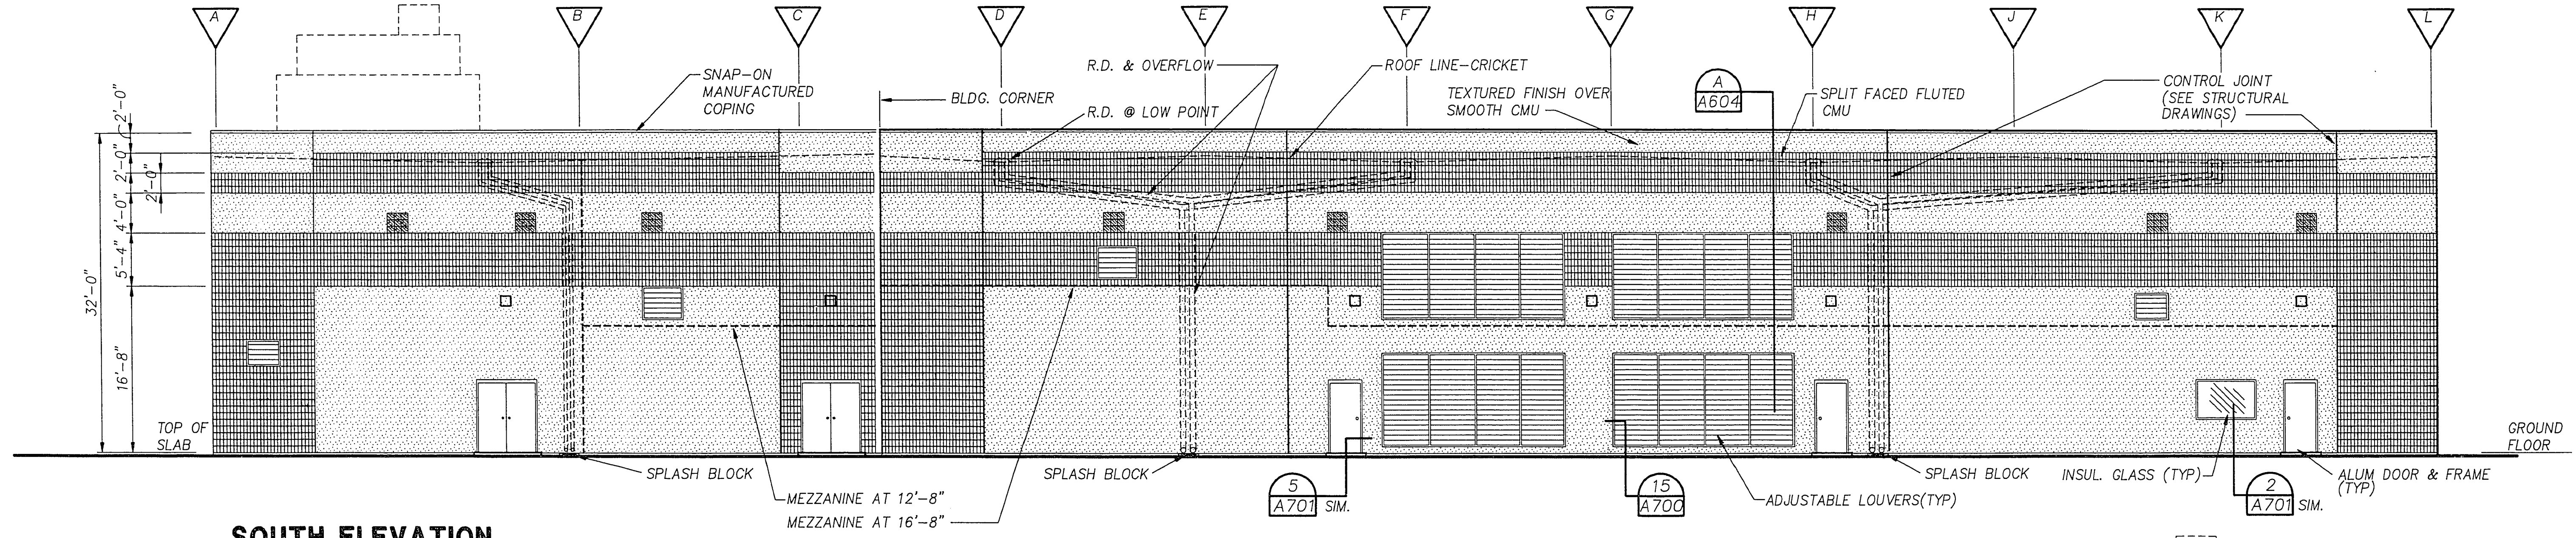


SOUTH ELEVATION

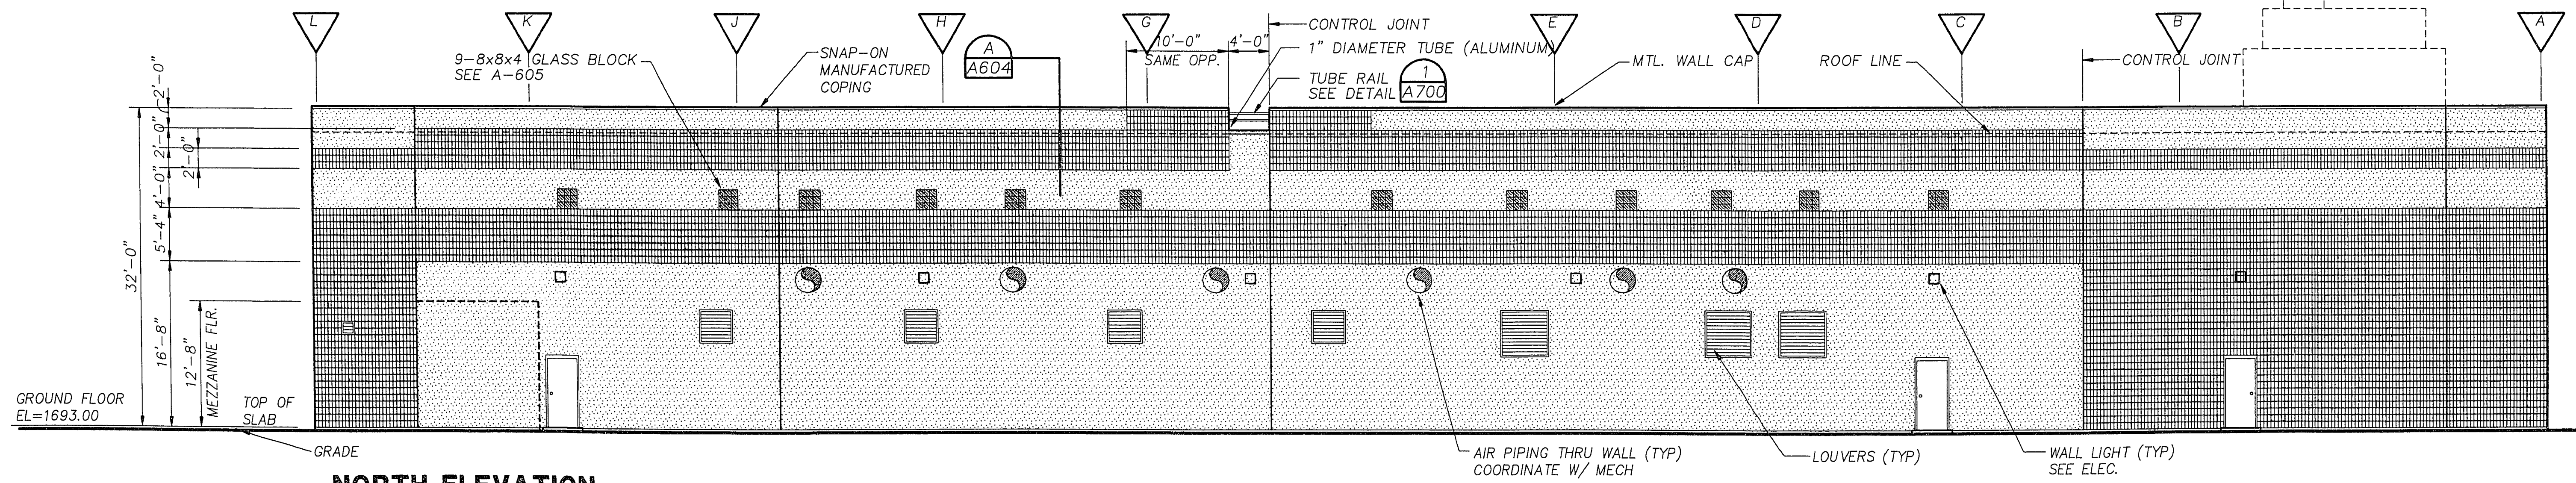

NORTH ELEVATION

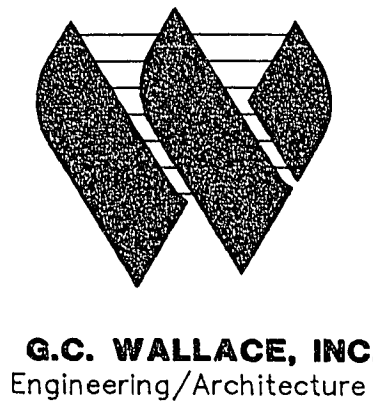

1	CORRECTED ACCORDING TO CONSTRUCTION RECORD	11/95	RRL	EFH	MJH	JJC
0	ISSUED FOR CONSTRUCTION	8/20/92	DSD	DSD	JJC	
Issue No.	Description	Date	Drawn	Chd.	Resp. Engr.	Proj. Mgr.

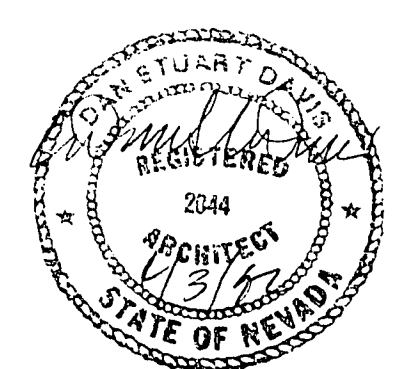

Project Manager	JOHN J. CHUEH
Architect	D. DAVIS
Civil	
Electrical	
Structural	
Drawn By	D. LEEHAN

City of Las Vegas
Water Pollution Control Facility
Nitrification / Filtration Facilities
Contract 17
NITRIFICATION COMPLEX

BLOWER BUILDING
EXTERIOR
ELEVATIONS

Date	APRIL 1992	Project No.	00120-084-141	Drawing No.	A-602	Issue	1
Scale	1/8" = 1'-0"						