



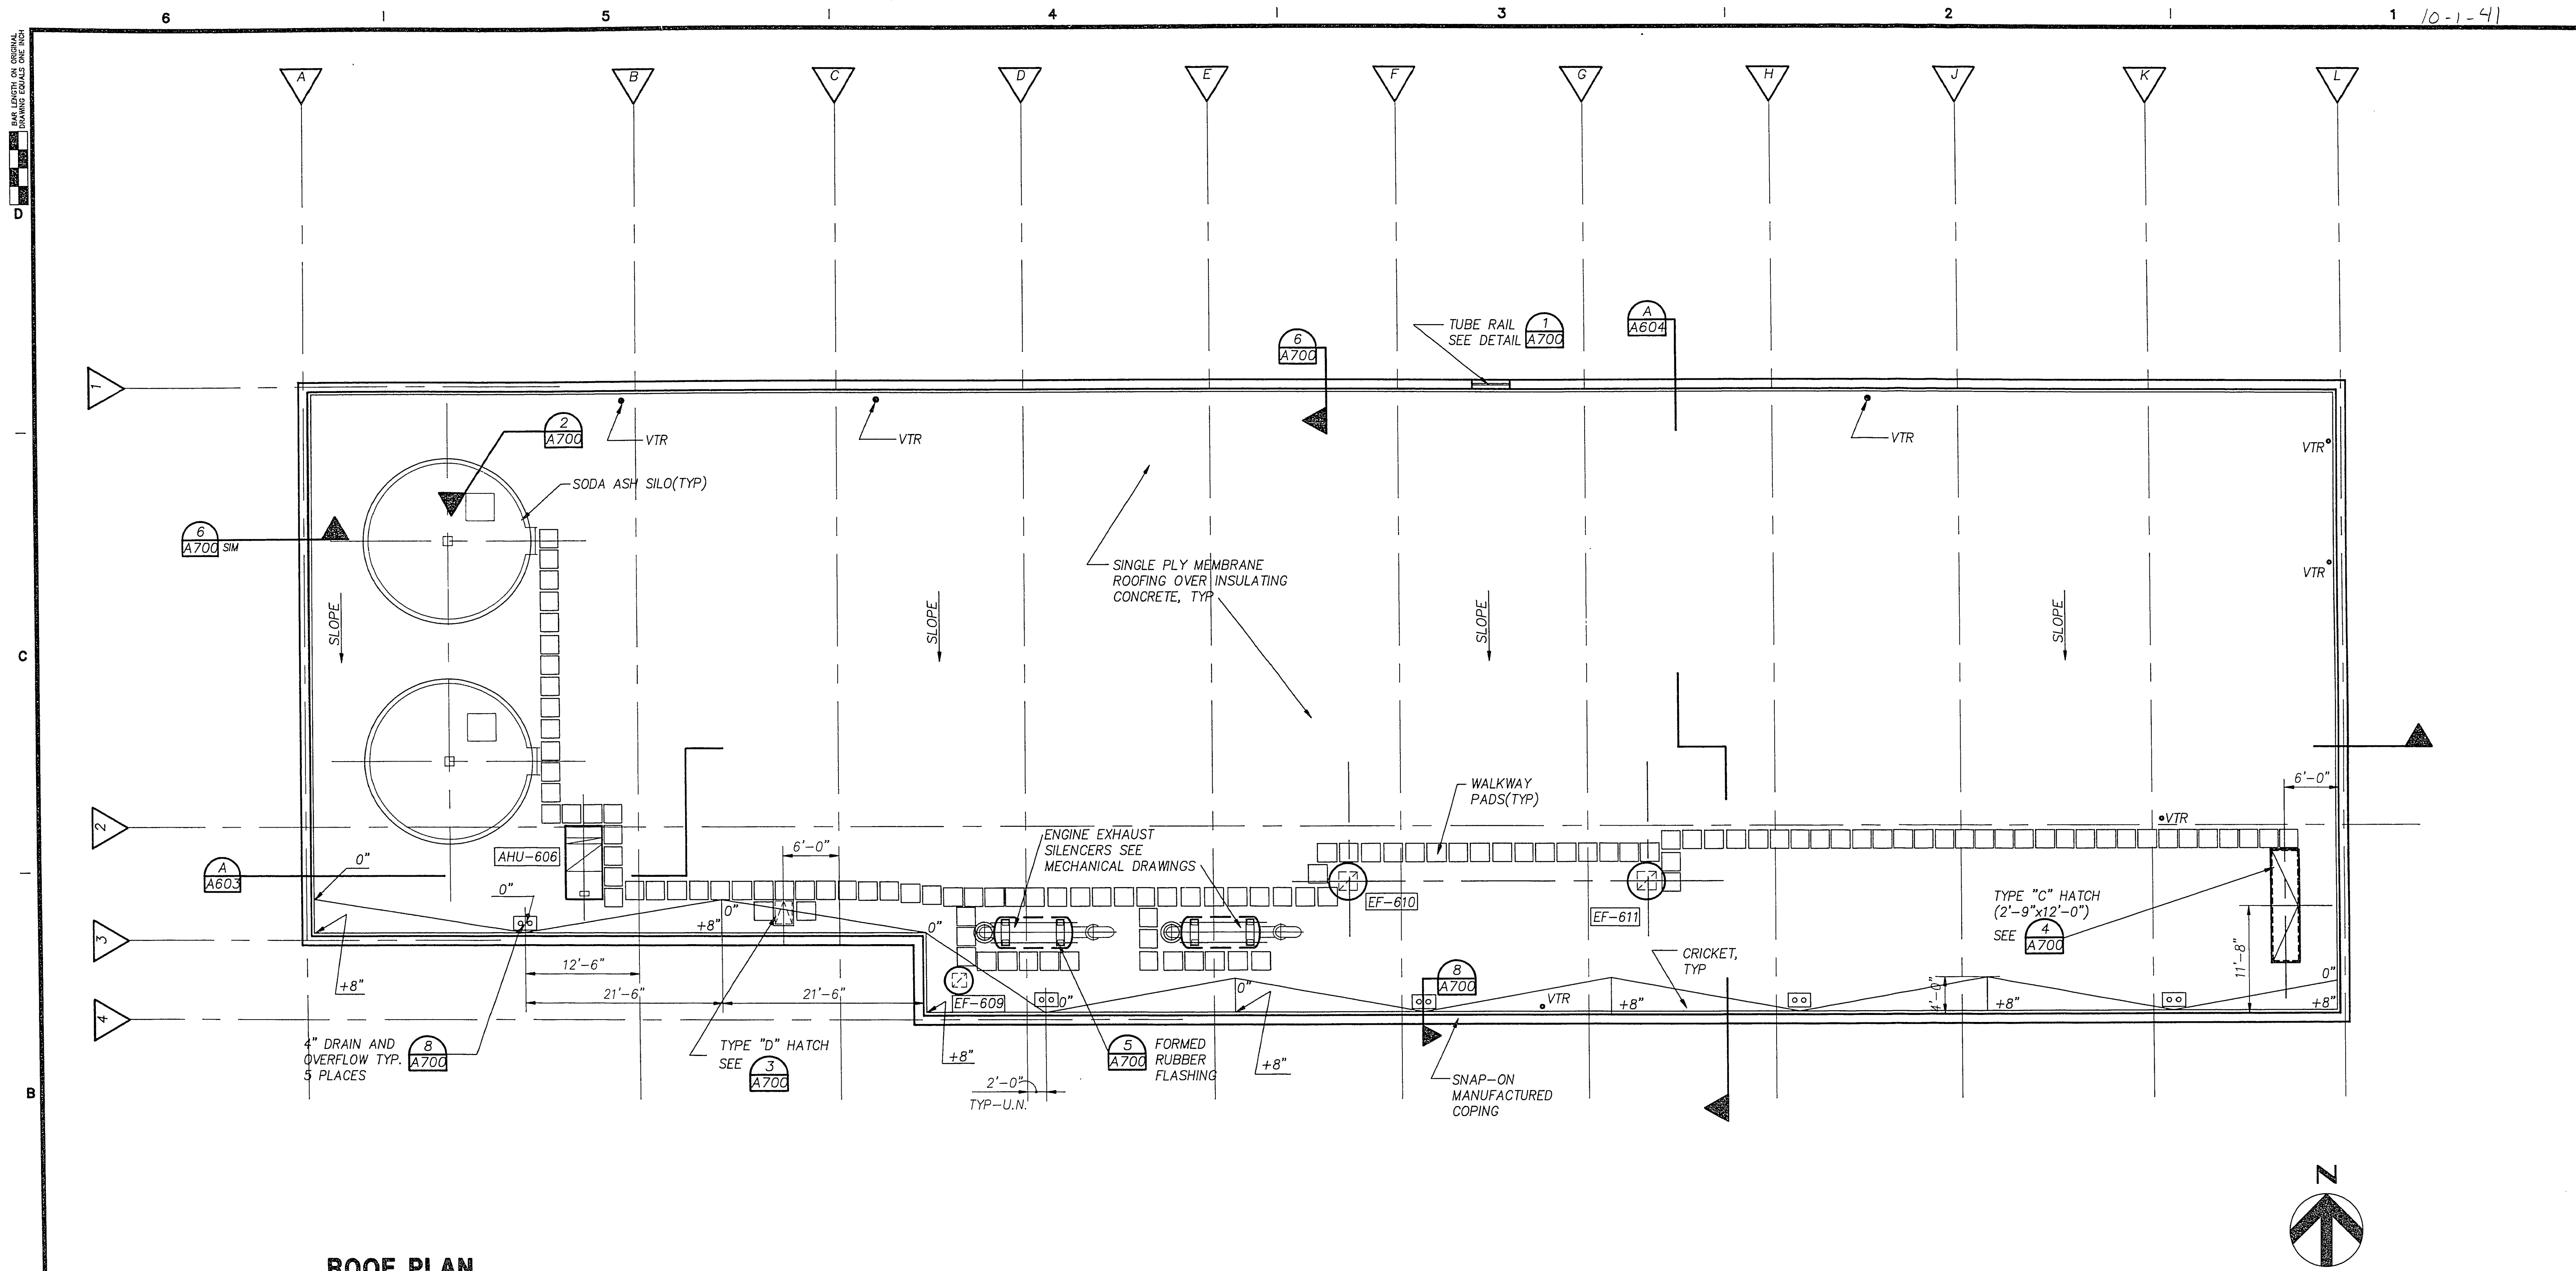


ROOF PLAN

- NOTES:
1. ROOF SYSTEM TO HAVE R-30 TOTAL THERMAL INSULATING VALUE. TOTAL THICKNESS OF INSULATING CONCRETE IS DETERMINED BY R-VALUE.
 2. USE THE SAME INSULATING CONCRETE FILL TO BUILD CRICKETS. SPOT ELEVATIONS SHOWN MEAN TOP OF CRICKETS, ELEVATION 0" BEING TOP OF R-30 INSULATING CONCRETE.

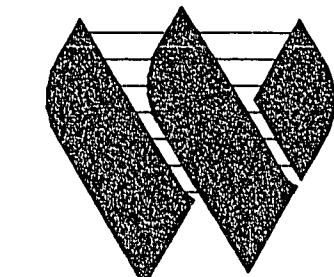

1	CORRECTED ACCORDING TO CONSTRUCTION RECORD	1/95	RRL	EFH	MJH	JJC
0	ISSUED FOR CONSTRUCTION	8/20/92	BDL	DSD	DSD	JJC
Issue No.	Description	Date	Drawn	Chkd.	Rep. Engr.	Proj. Mgr.

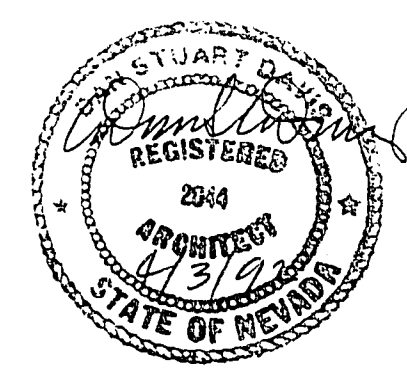

Project Manager	JOHN J. CHUEH
Architect	D. DAVIS
Civil	
Electrical	
Structural	
Drawn By	B. DeLUNA

City of Las Vegas

**Water Pollution Control Facility
Nitrification / Filtration Facilities**

**Contract 17
NITRIFICATION COMPLEX**

**BLOWER BUILDING
ROOF PLAN**

Date	APRIL 1992	Project No.	00120-084-141	Drawing No.	A-605	1
Scale	1/8" = 1'-0"					