


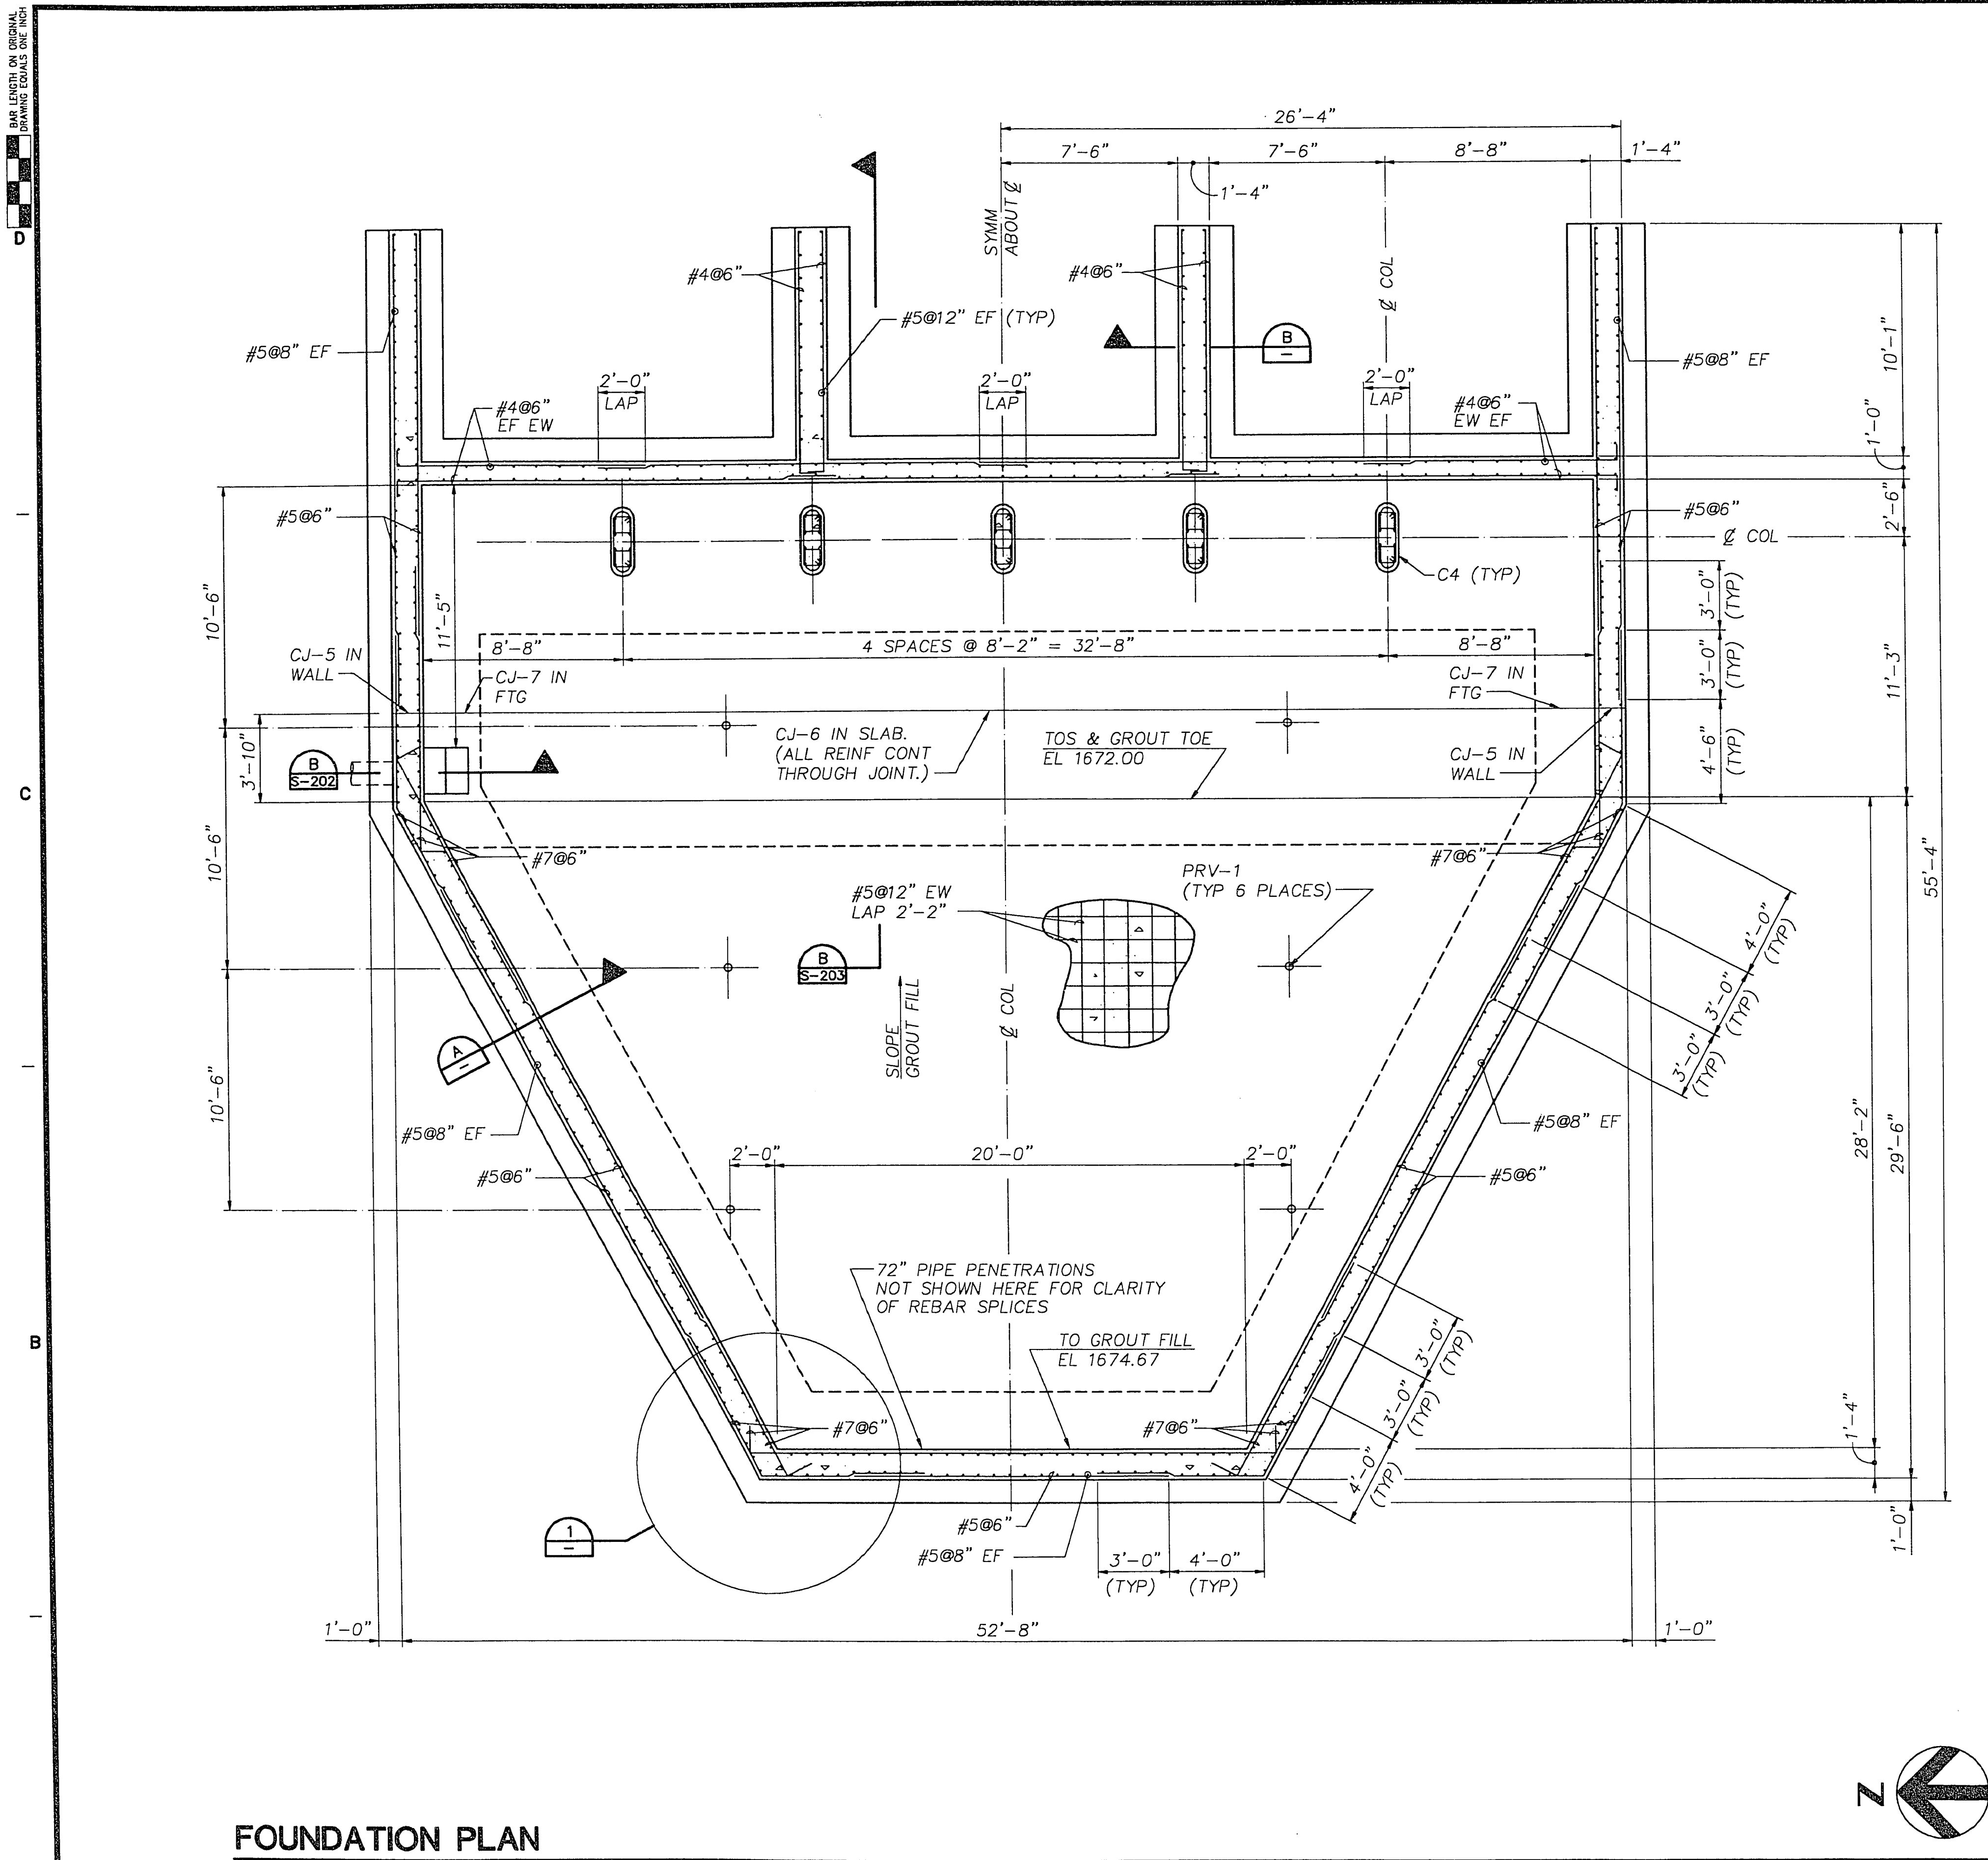

FOUNDATION PLAN


1/4"=1'-0"

SECTION

3/8"=1'-0"


SECTION

3/8"=1'-0"

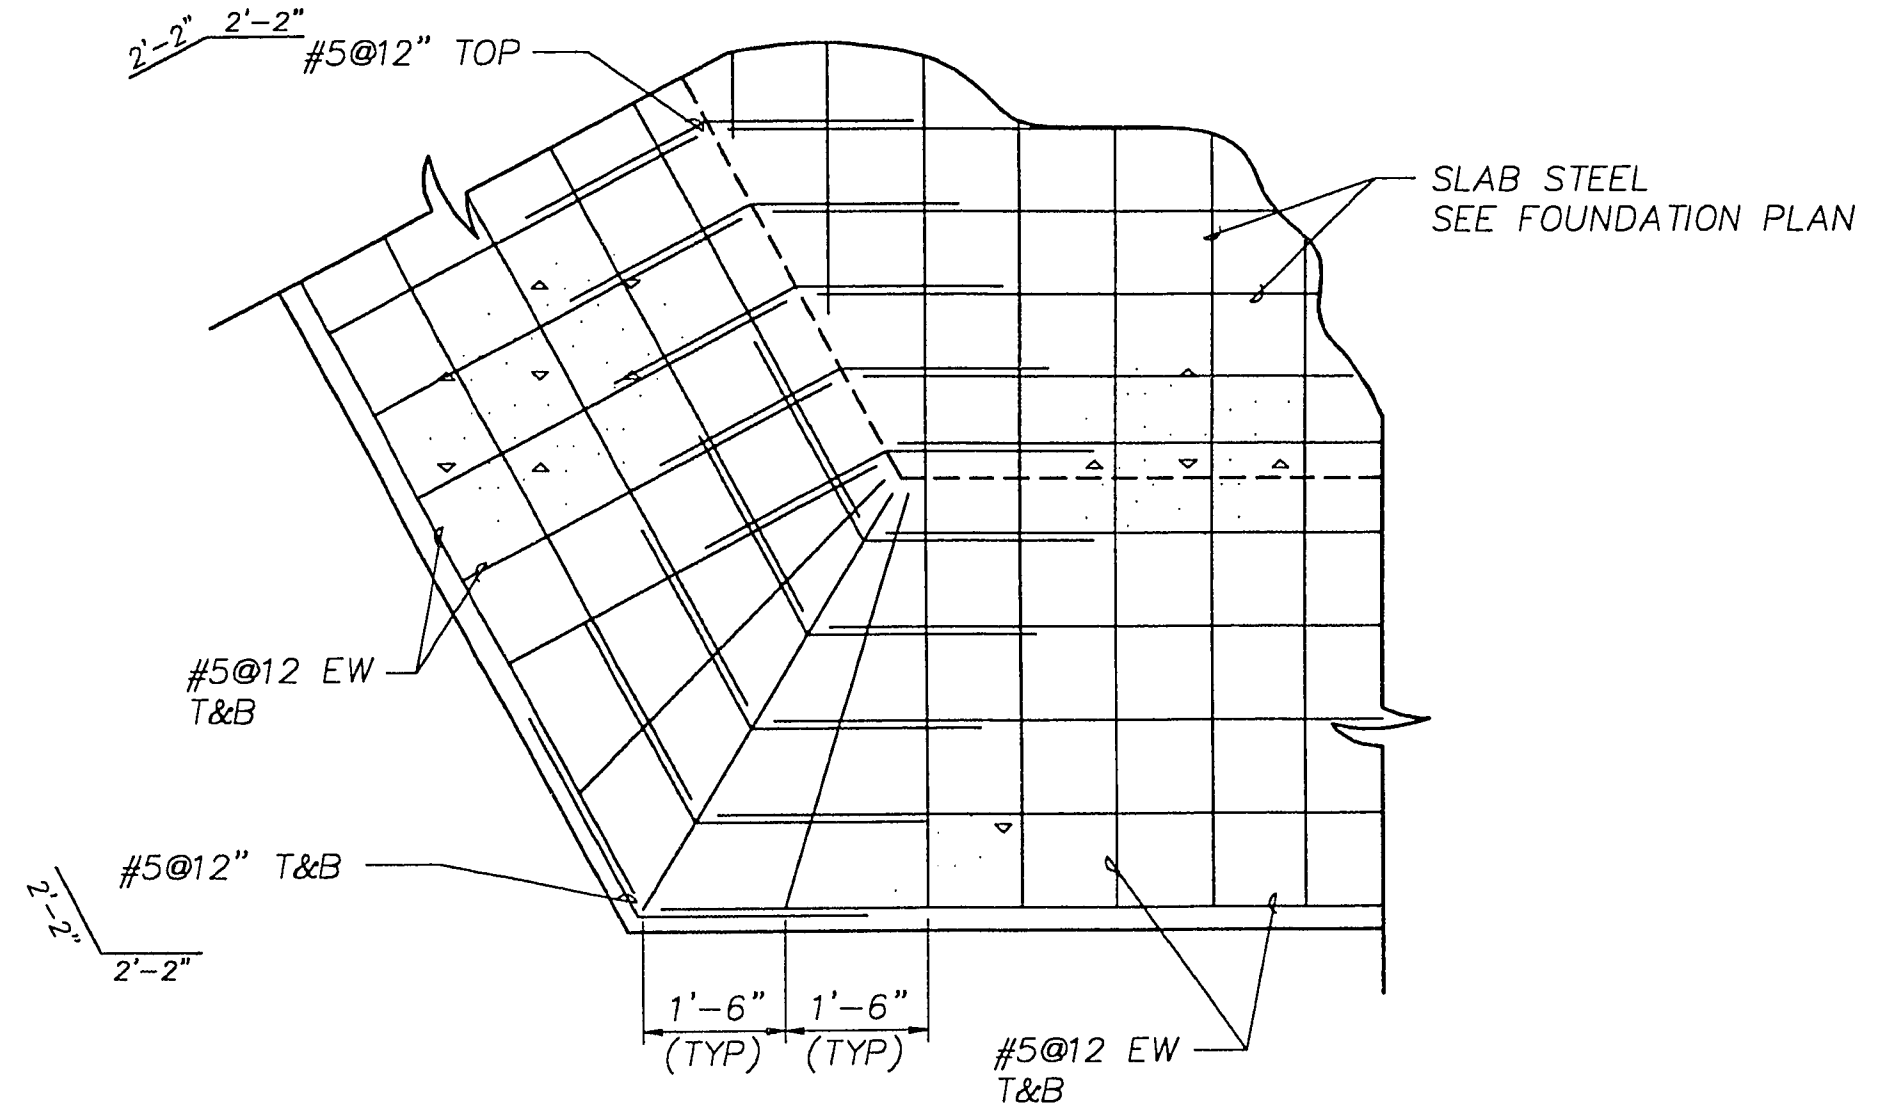

DETAIL

1/2"=1'-0"

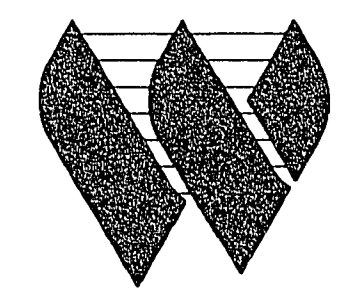

G.C. WALLACE, INC.
Engineering/Architecture



HDR Engineering, Inc.

1	CORRECTED ACCORDING TO CONSTRUCTION RECORD	1/95	RRL	EFH	MJH	JJC
O	ISSUED FOR CONSTRUCTION	8/20/92	JH	CLS	CRD	JJC
A	ISSUED FOR BID	4/20/92	JH	CLS	CRD	JJC
Issue No.	Description	Date	Drawn	Chkd.	Rep. Eng.	Proj. Mgr.

Professional Engineer - State of Nevada
C. RUSSELL DAVIS
No. 8255
4/28/92

Project Manager
JOHN J. CHUEH
Architect
Civil
Mechanical
Electrical
Structural
R. DAVIS
Drawn By
J. HIRSHOUER

City of Las Vegas
Water Pollution Control Facility
Nitrification / Filtration Facilities
Contract 17
NITRIFICATION COMPLEX

NITRIFICATION INFLUENT PUMP STATION FOUNDATION PLAN			
Date APRIL 1992	Project No. 00120-084-141	Drawing No. S-201	Issue 1
Scale AS NOTED			