

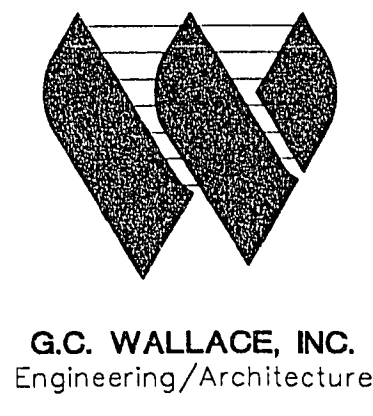


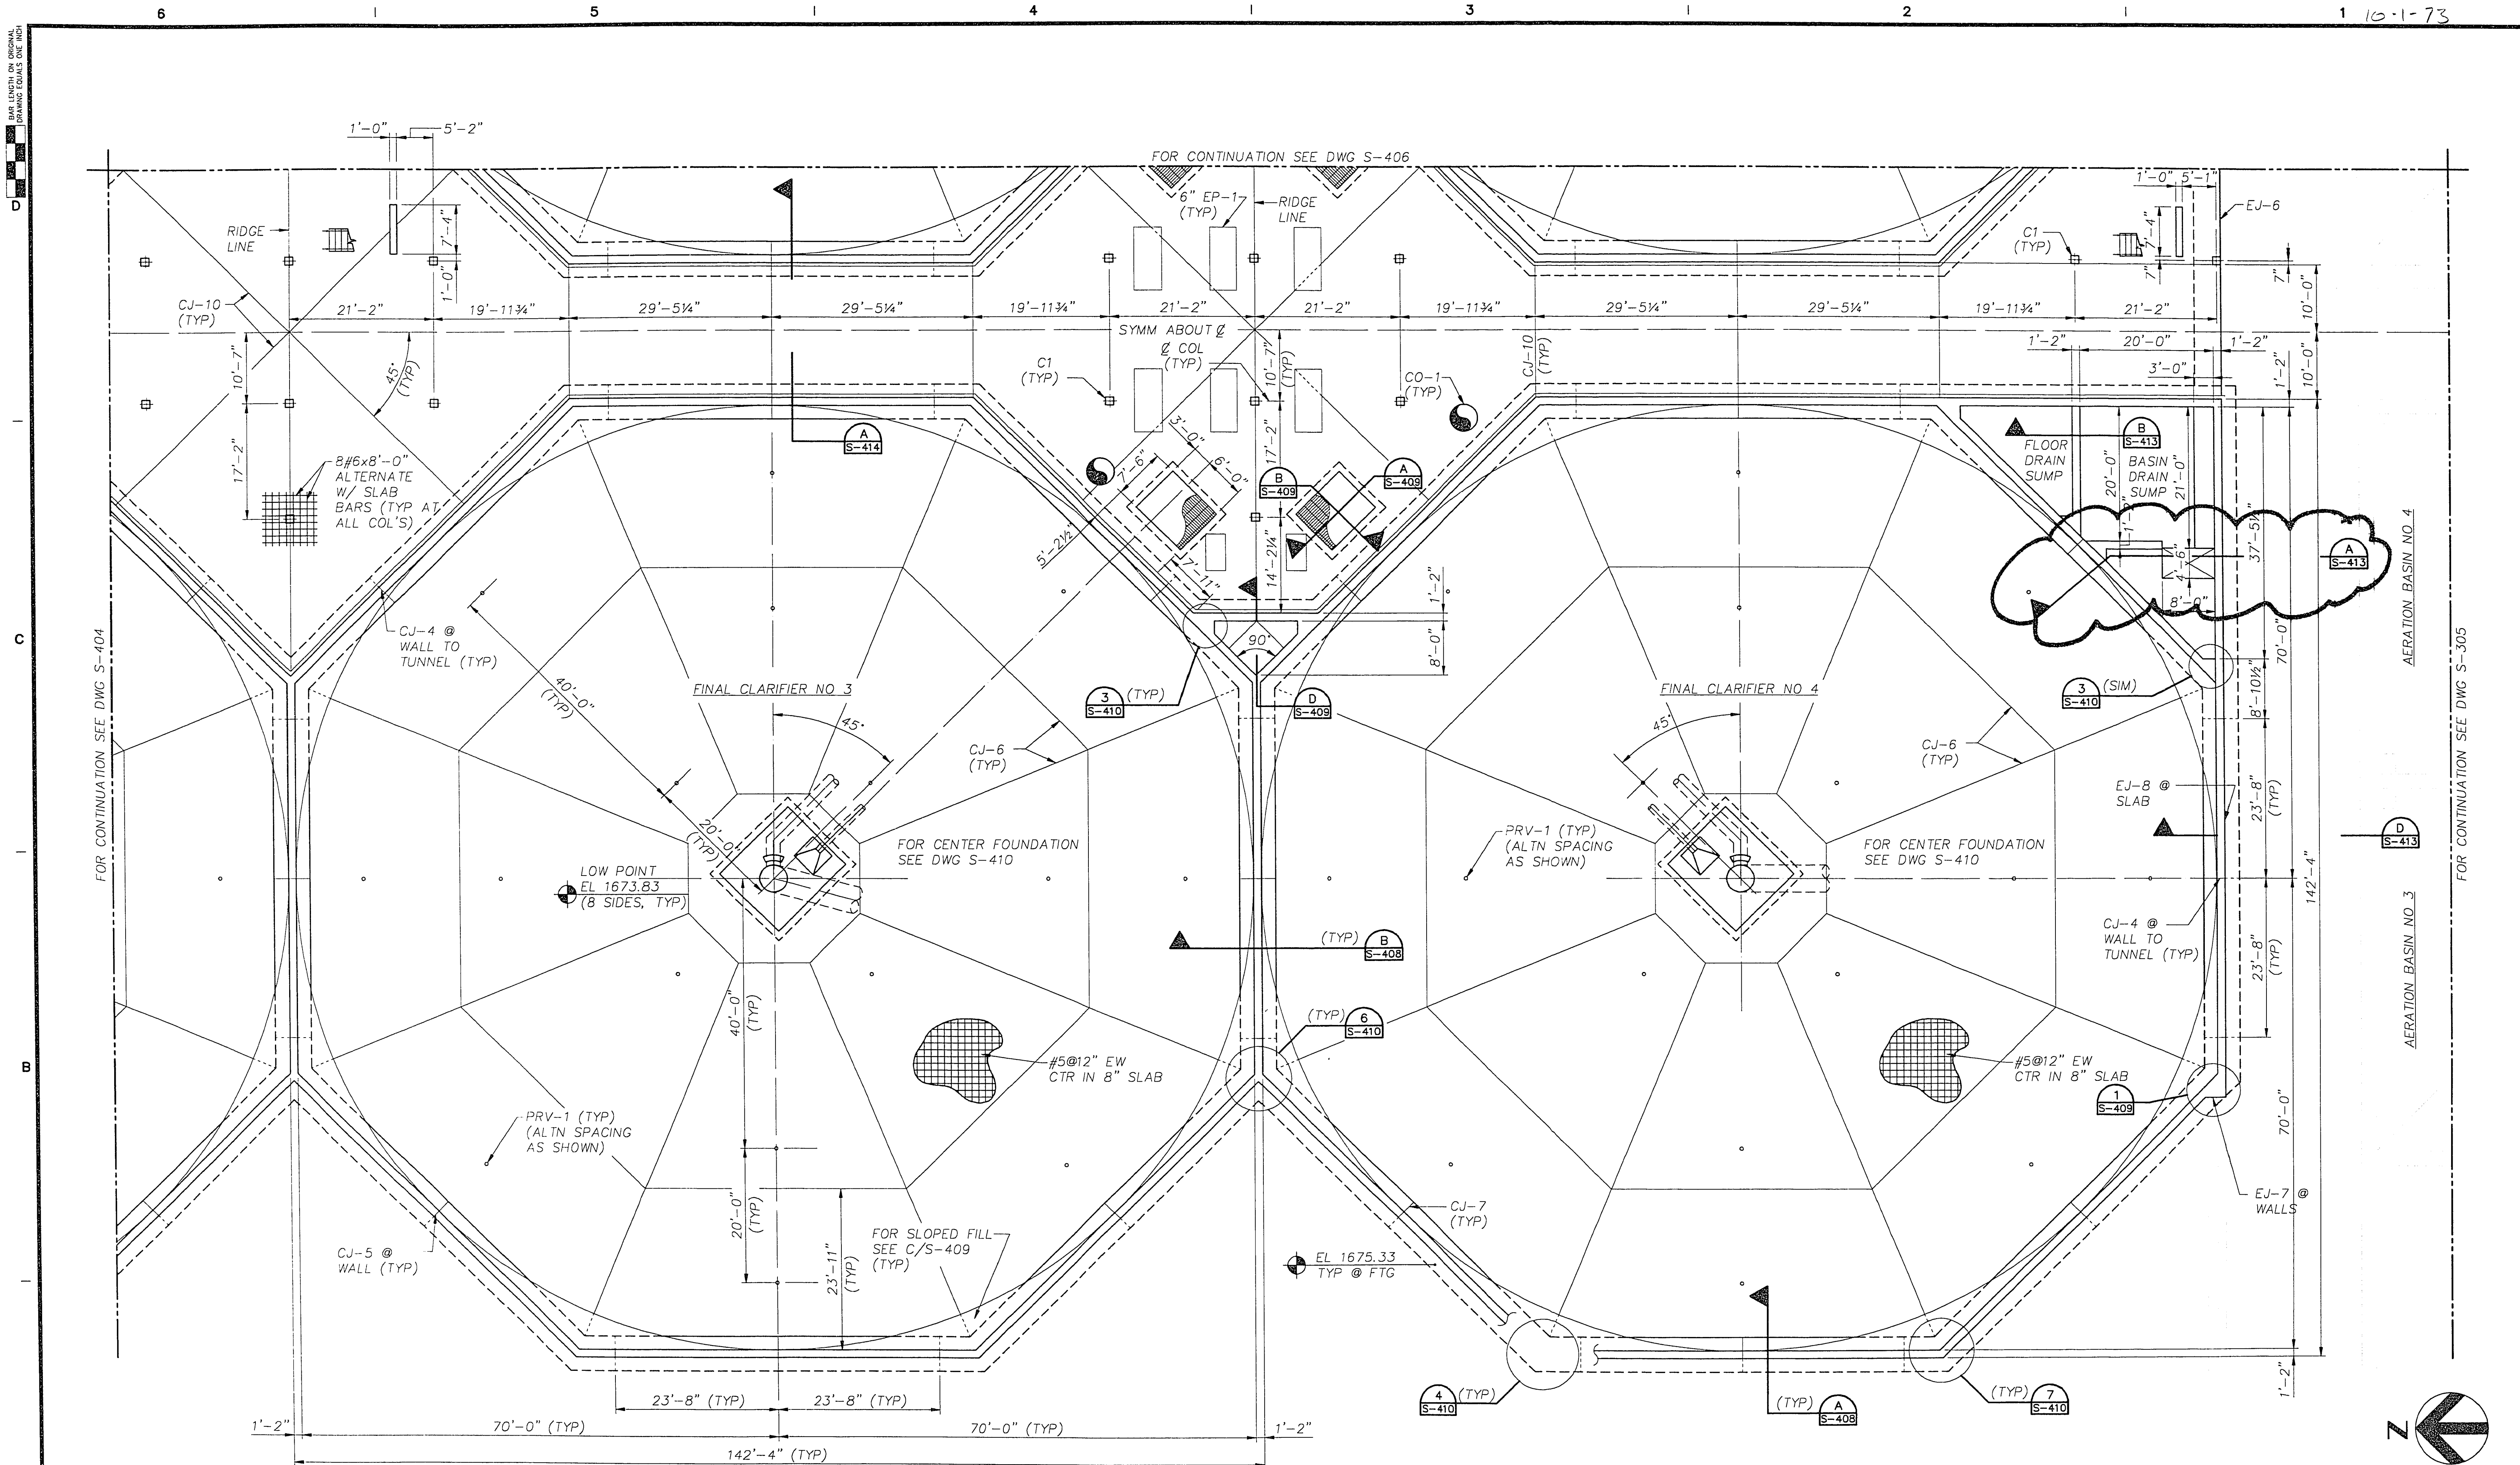

1	CORRECTED ACCORDING TO CONSTRUCTION RECORD	1/95	RRL	EFH	MJH	JJC
0	ISSUED FOR CONSTRUCTION	8/20/92	JH	RCH	CRD	JJC
A	ISSUED FOR BID	4/20/92	JH	RCH	CRD	JJC
Issue No.	Description	Date	Drawn	Chkd.	Rep. Engr.	Proj. Mgr.

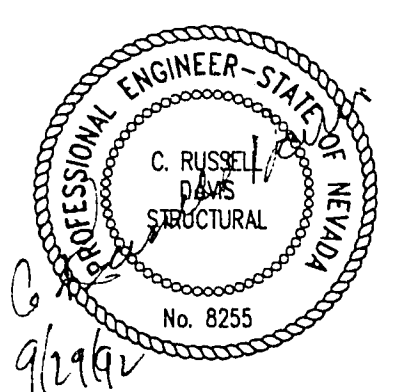

Project Manager	JOHN J. CHUEH
Architect	
Civil	
Electrical	
Structural	
Drawn By	J. HIRSHOUER

City of Las Vegas
Water Pollution Control Facility
Nitrification / Filtration Facilities
Contract 17
NITRIFICATION COMPLEX

FINAL CLARIFIERS			
FINAL CLARIFIERS NO. 3 & 4			
FOUNDATION PLAN			
Date	APRIL 1992	Project No.	00120-084-141
Scale	3/32" = 1'-0"	Drawing No.	S-405
		Issue	1