

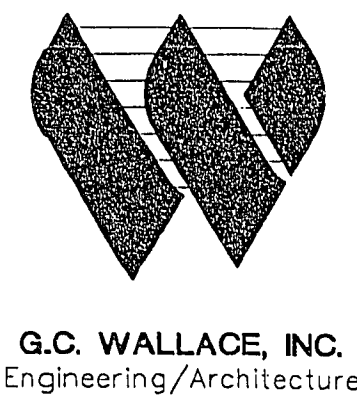


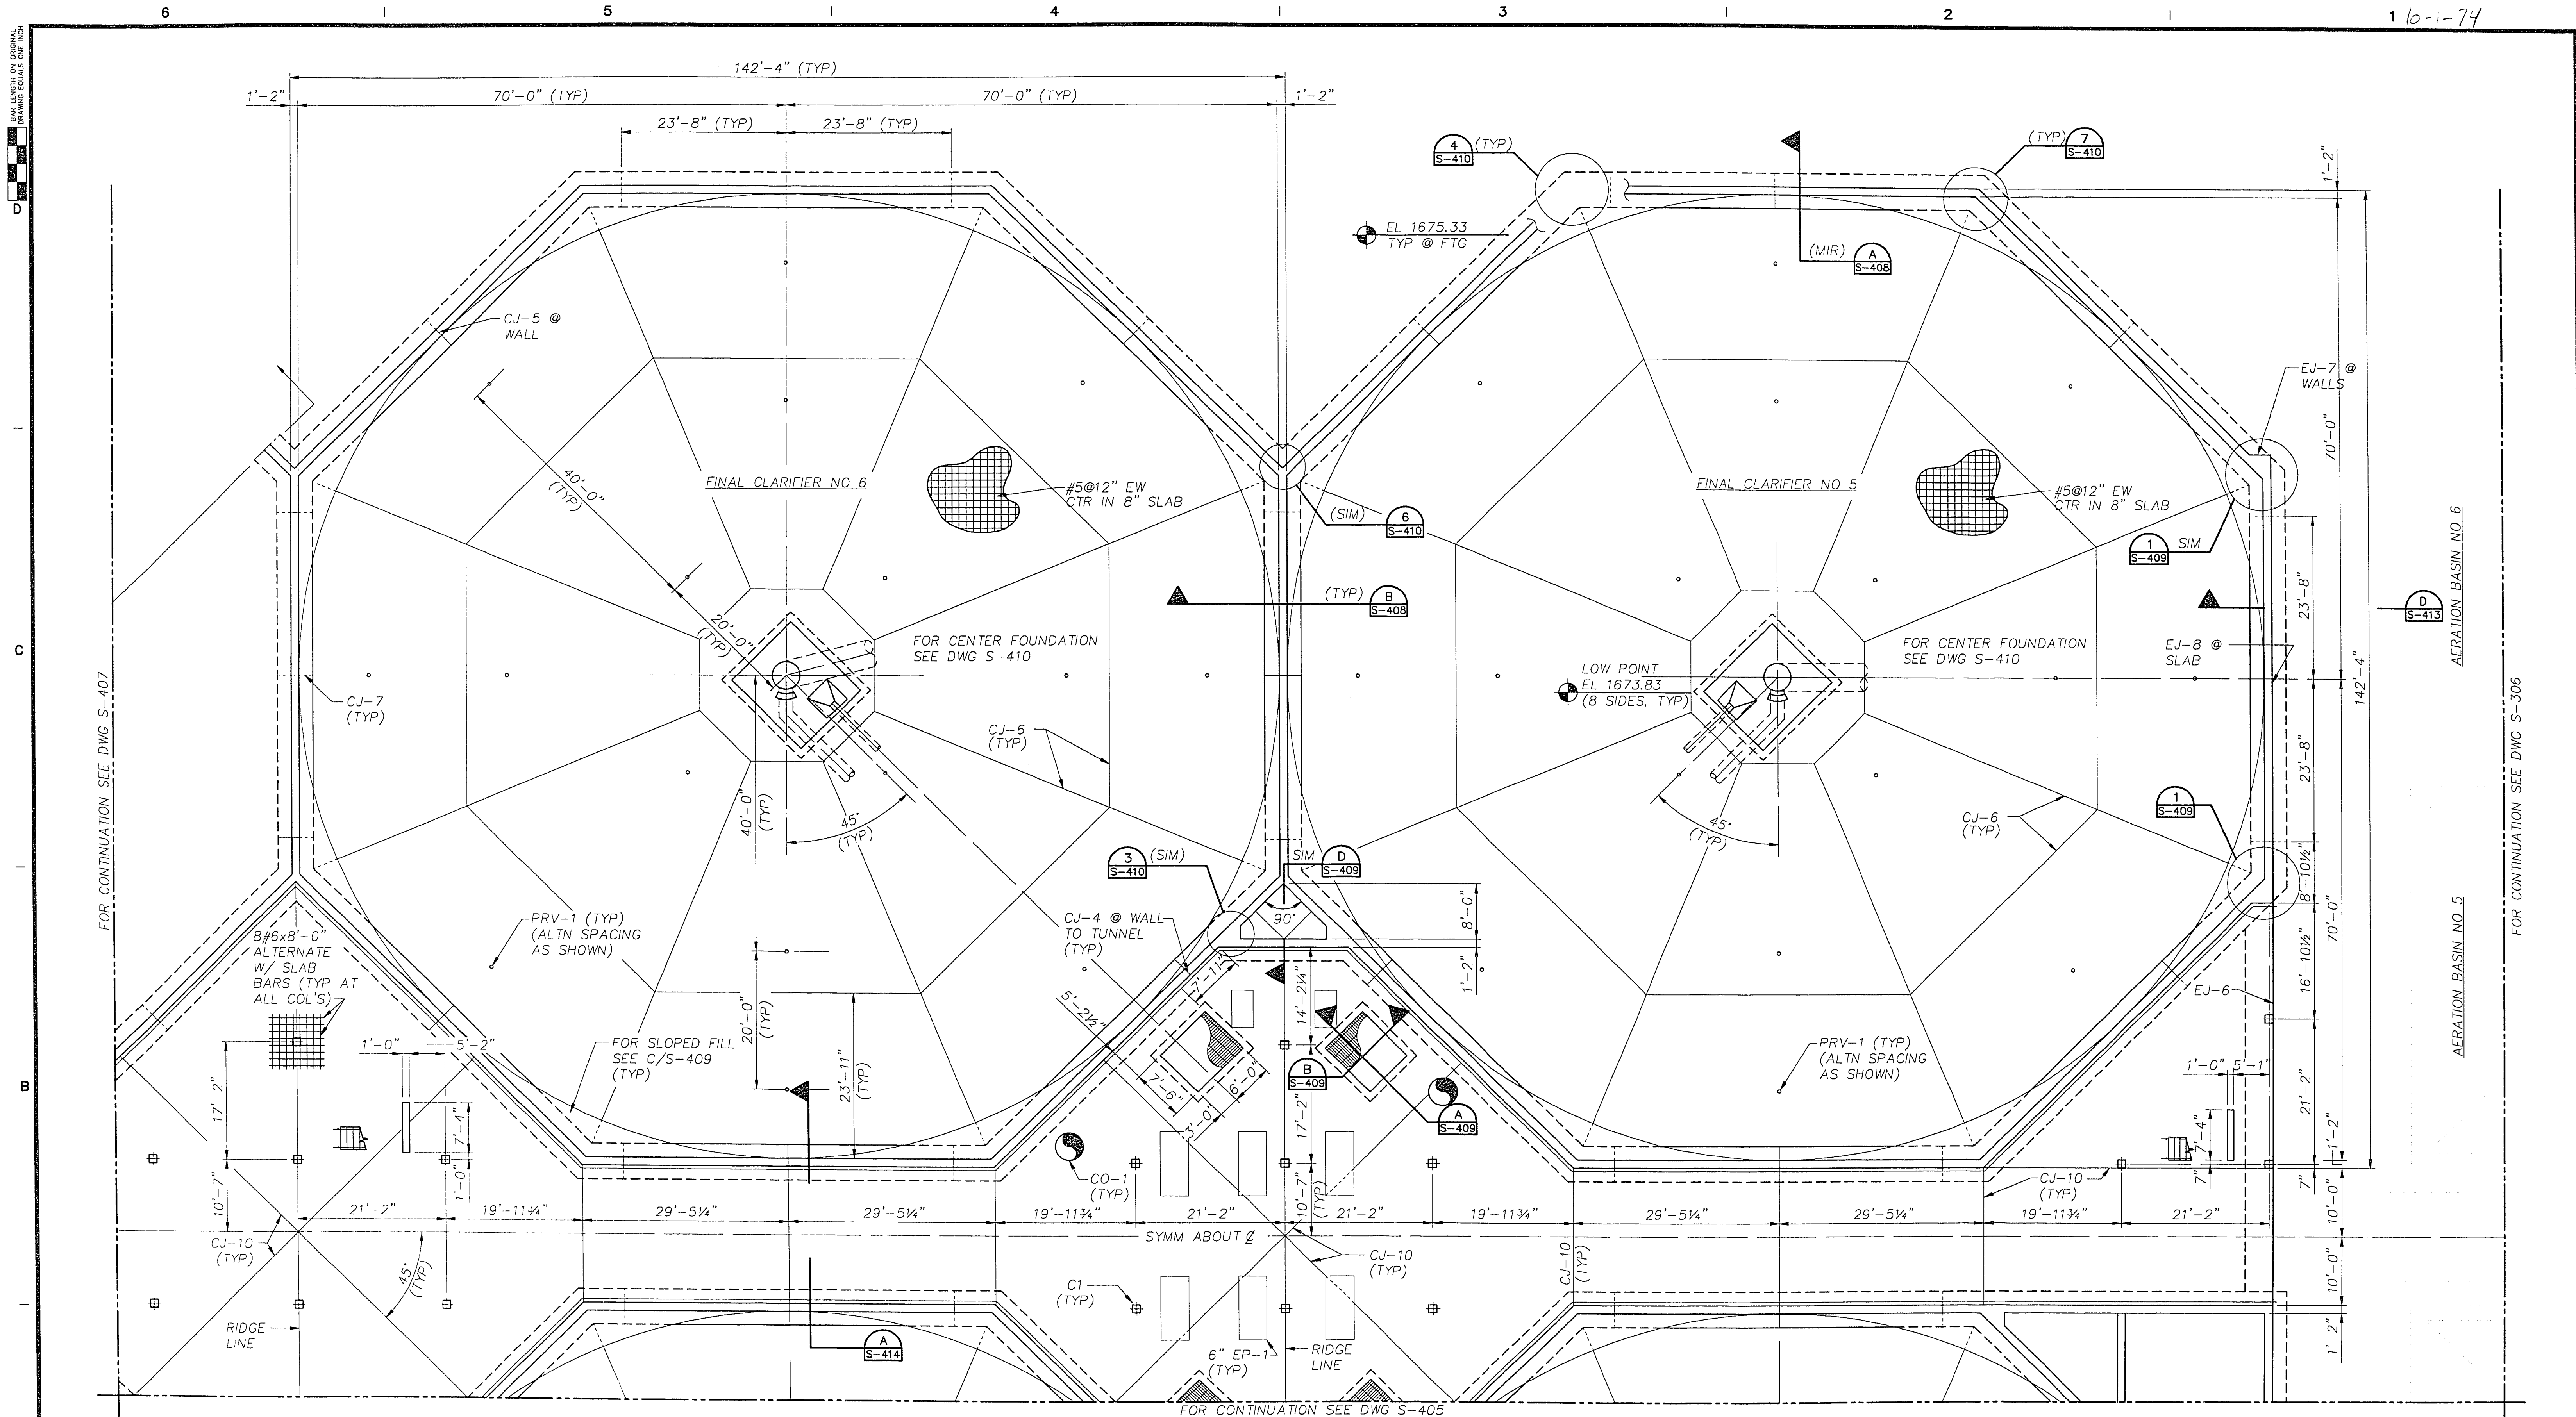

1	CORRECTED ACCORDING TO CONSTRUCTION RECORD	1/95	RRL	EFH	MJH	JJC
0	ISSUED FOR CONSTRUCTION	8/20/92	JH	RCH	CRD	JJC
A	ISSUED FOR BID	4/20/92	JH	RCH	CRD	JJC
Issue No.	Description	Date	Drawn	Checked	Revised	Project Mgr.

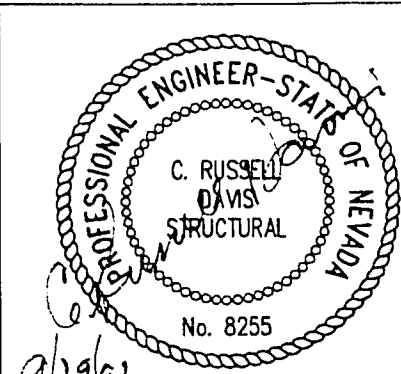

Project Manager	JOHN J. CHUEH
Architect	
Civil	
Electrical	
Mechanical	
Structural	R. DAVIS
Drawn By	J. HIRSHOUER

City of Las Vegas
Water Pollution Control Facility
Nitrification / Filtration Facilities
Contract 17
NITRIFICATION COMPLEX

FINAL CLARIFIERS

FINAL CLARIFIERS NO. 5 & 6 FOUNDATION PLAN

Date	APRIL 1992	Project No.	00120-084-141	Drawing No.	S-406	Sheet	1
Scale	3/32" = 1'-0"						

