


6 1 5 1 4 1 3 1 2 1 10-1-81

D

C

B

A

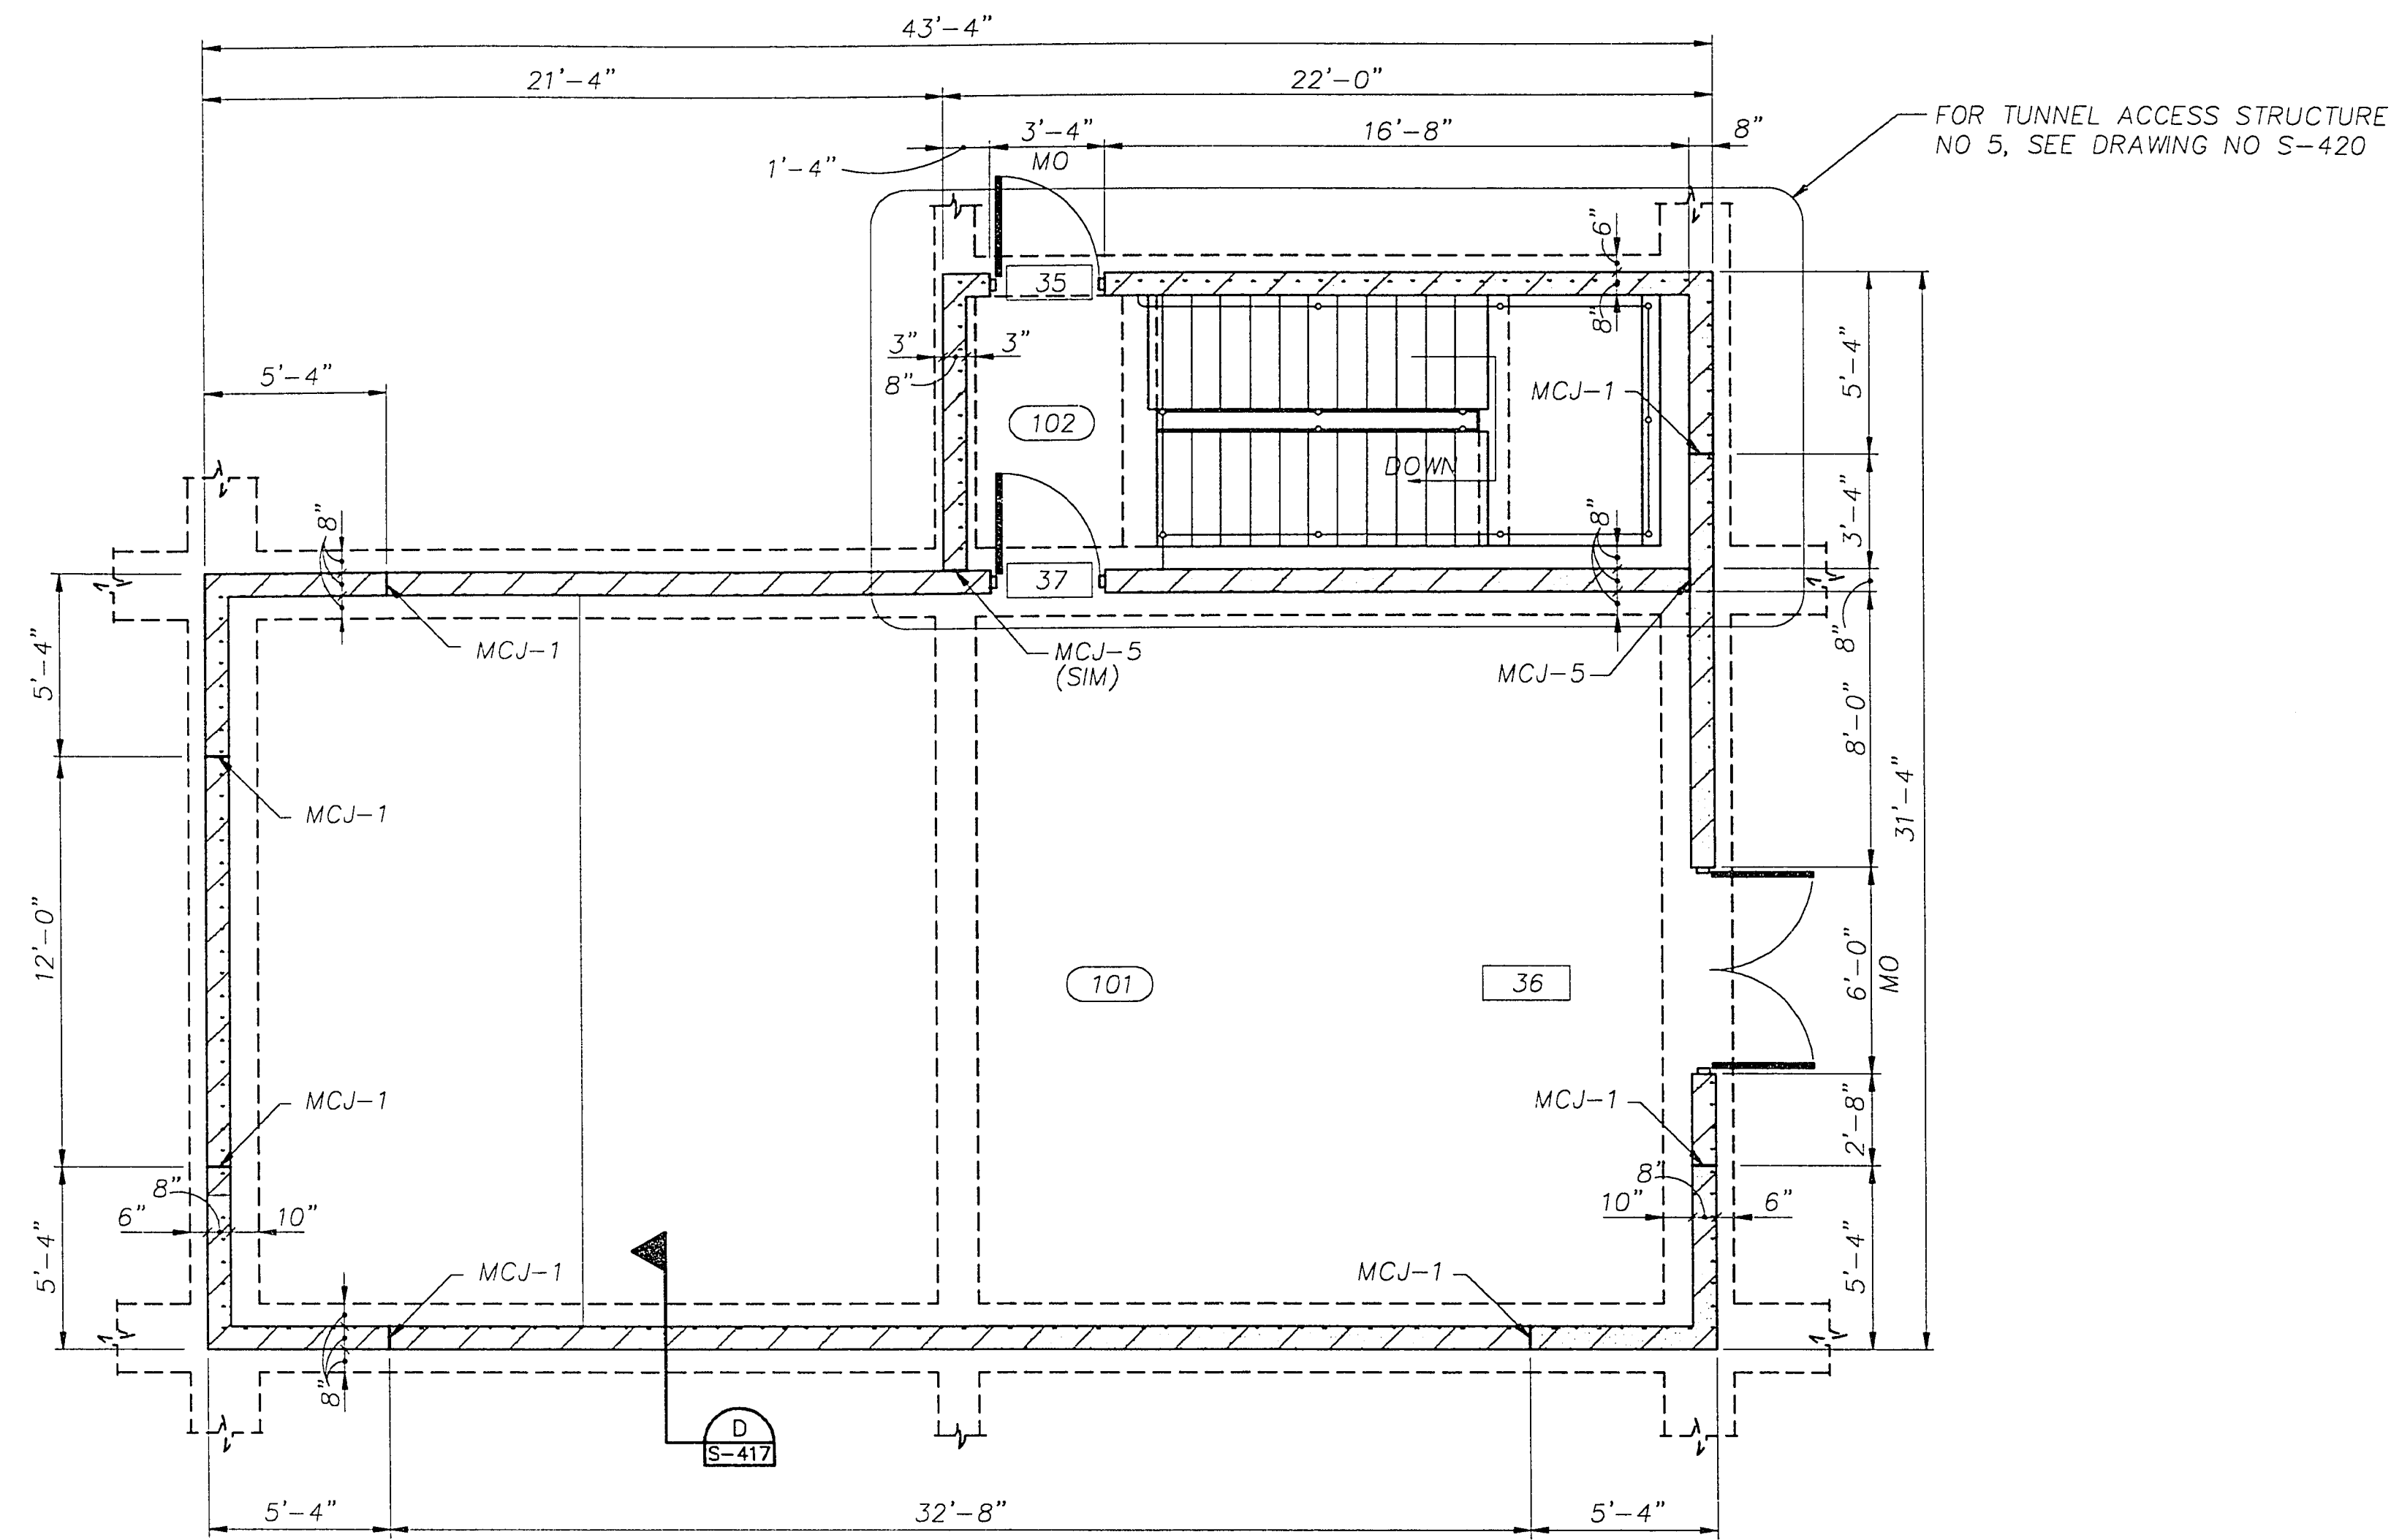


NOTES:

1. FOR DIMENSIONAL INFORMATION ON PIPING, CONDUIT, & EQUIPMENT, REFER TO M,P, & E DRAWINGS.
2. SEE DWG A-702 FOR DOOR AND ROOM FINISH SCHEDULE.

FLOOR PLAN

1/4"=1'-0"

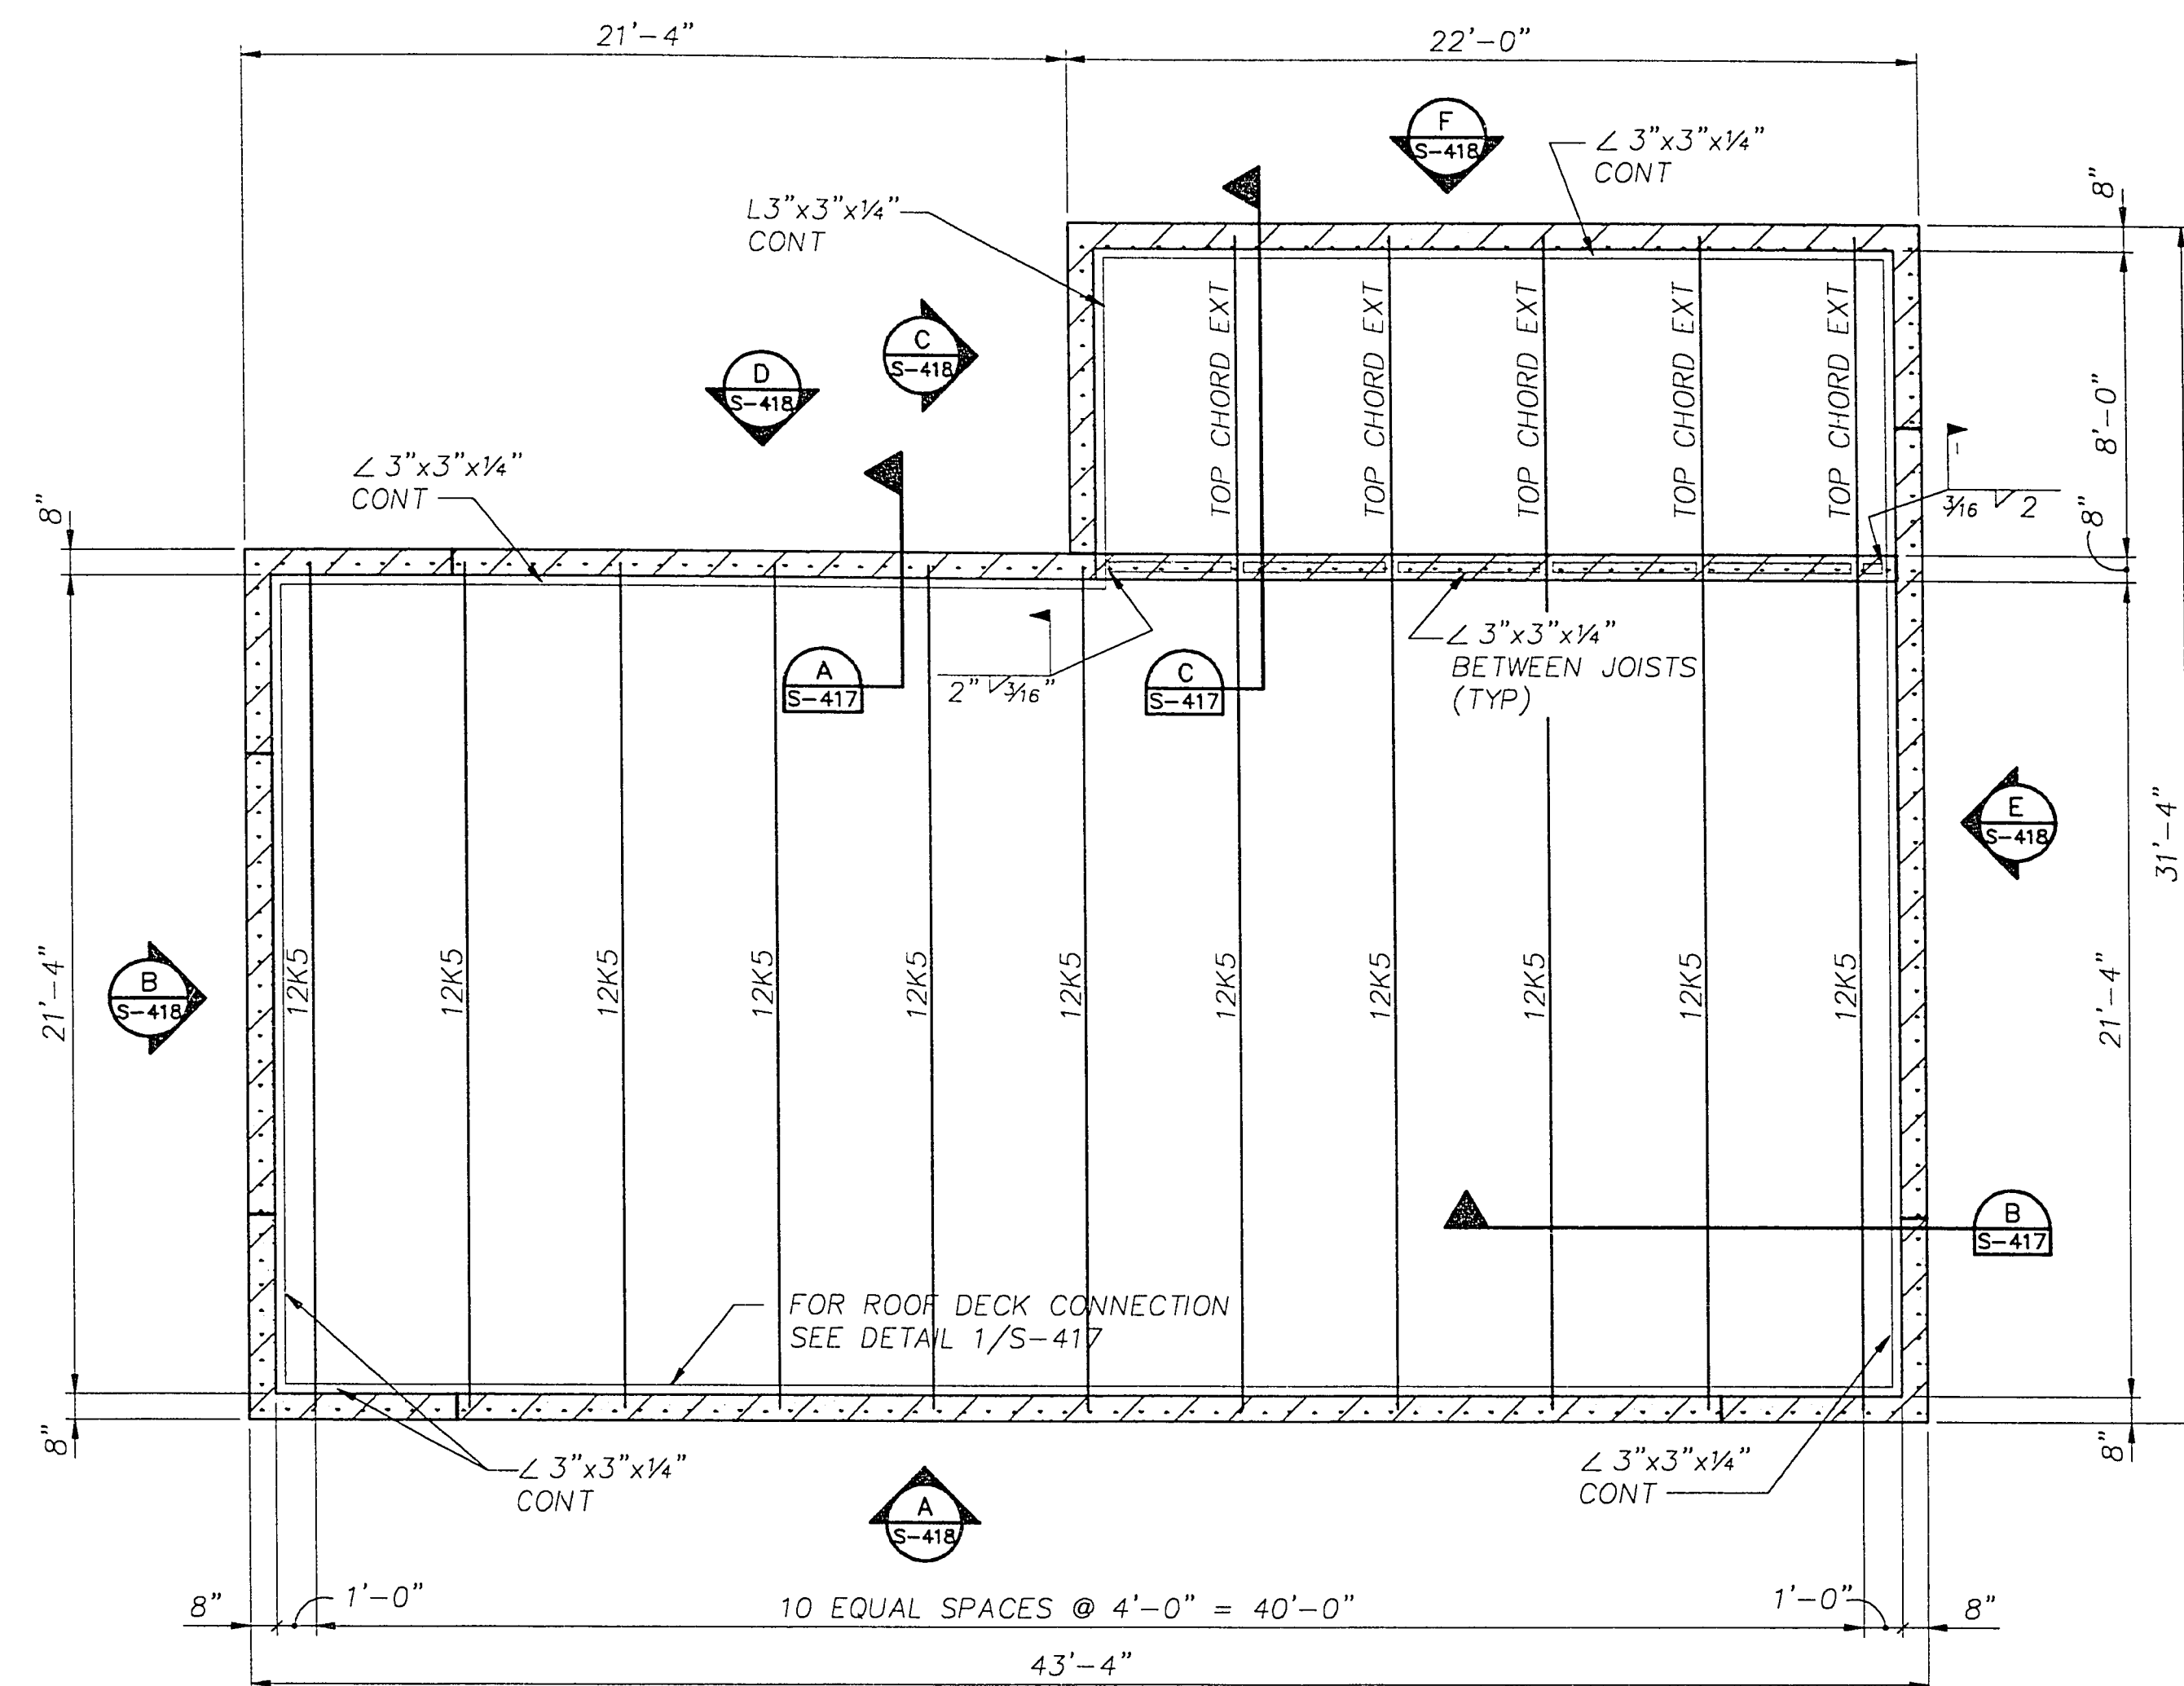


NOTES:


1. FOR EXACT LOCATION OF ROOF PENETRATIONS, REFER TO MECHANICAL AND ARCHITECTURAL DRAWINGS.
2. ROOF OPENING SIZES SHALL CONFORM TO MANUFACTURERS SPECIFICATIONS.
3. CONTINUOUS ROOF DECK EDGE ANGLE MAY BE SPLICED AT CONTRACTORS OPTION PER DETAIL 6/S-702.

ROOF FRAMING PLAN

1/4"=1'-0"

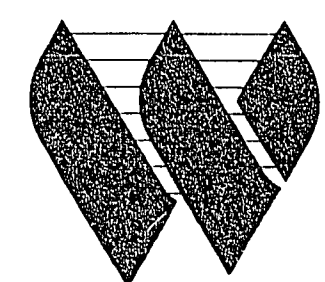


G.C. WALLACE, INC.
Engineering/Architecture

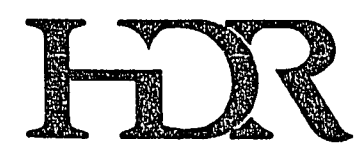

HDR Engineering, Inc.

Issue No.	Description	Date	Drawn	Checked	Responsible	Project Manager
1	CORRECTED ACCORDING TO CONSTRUCTION RECORD	1/95	RRL	EFH	MJH	JJC
0	ISSUED FOR CONSTRUCTION	8/20/92	RCH	CRD	CRD	JJC
A	ISSUED FOR BID	4/20/92	JH	RCH	CRD	JJC

Issue No.	Description	Date	Drawn	Checked	Responsible	Project Manager
1	CORRECTED ACCORDING TO CONSTRUCTION RECORD	1/95	RRL	EFH	MJH	JJC
0	ISSUED FOR CONSTRUCTION	8/20/92	RCH	CRD	CRD	JJC
A	ISSUED FOR BID	4/20/92	JH	RCH	CRD	JJC

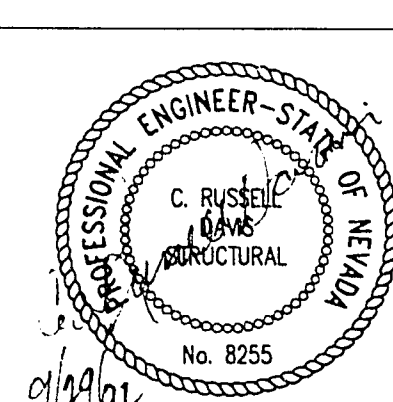

Project Manager	JOHN J. CHUEH
Architect	
Civil	
Electrical	
Structural	
Drawn By	R. DAVIS
	J. HIRSHOUER

City of Las Vegas
Water Pollution Control Facility
Nitrification / Filtration Facilities
Contract 17
NOTRIFICATION COMPLEX

FINAL CLARIFIERS

ELECTRICAL BUILDING
FLOOR AND ROOF PLAN

Date	APRIL 1992	Project No.	00120-084-141	Drawing No.	S-416	Issue	1
Scale	AS NOTED						