

BAR LENGTHS ON ORIGINAL
DRAWING EQUALS ONE INCH

D

C

B

A

6

5


4

3

2

1

10-1-56

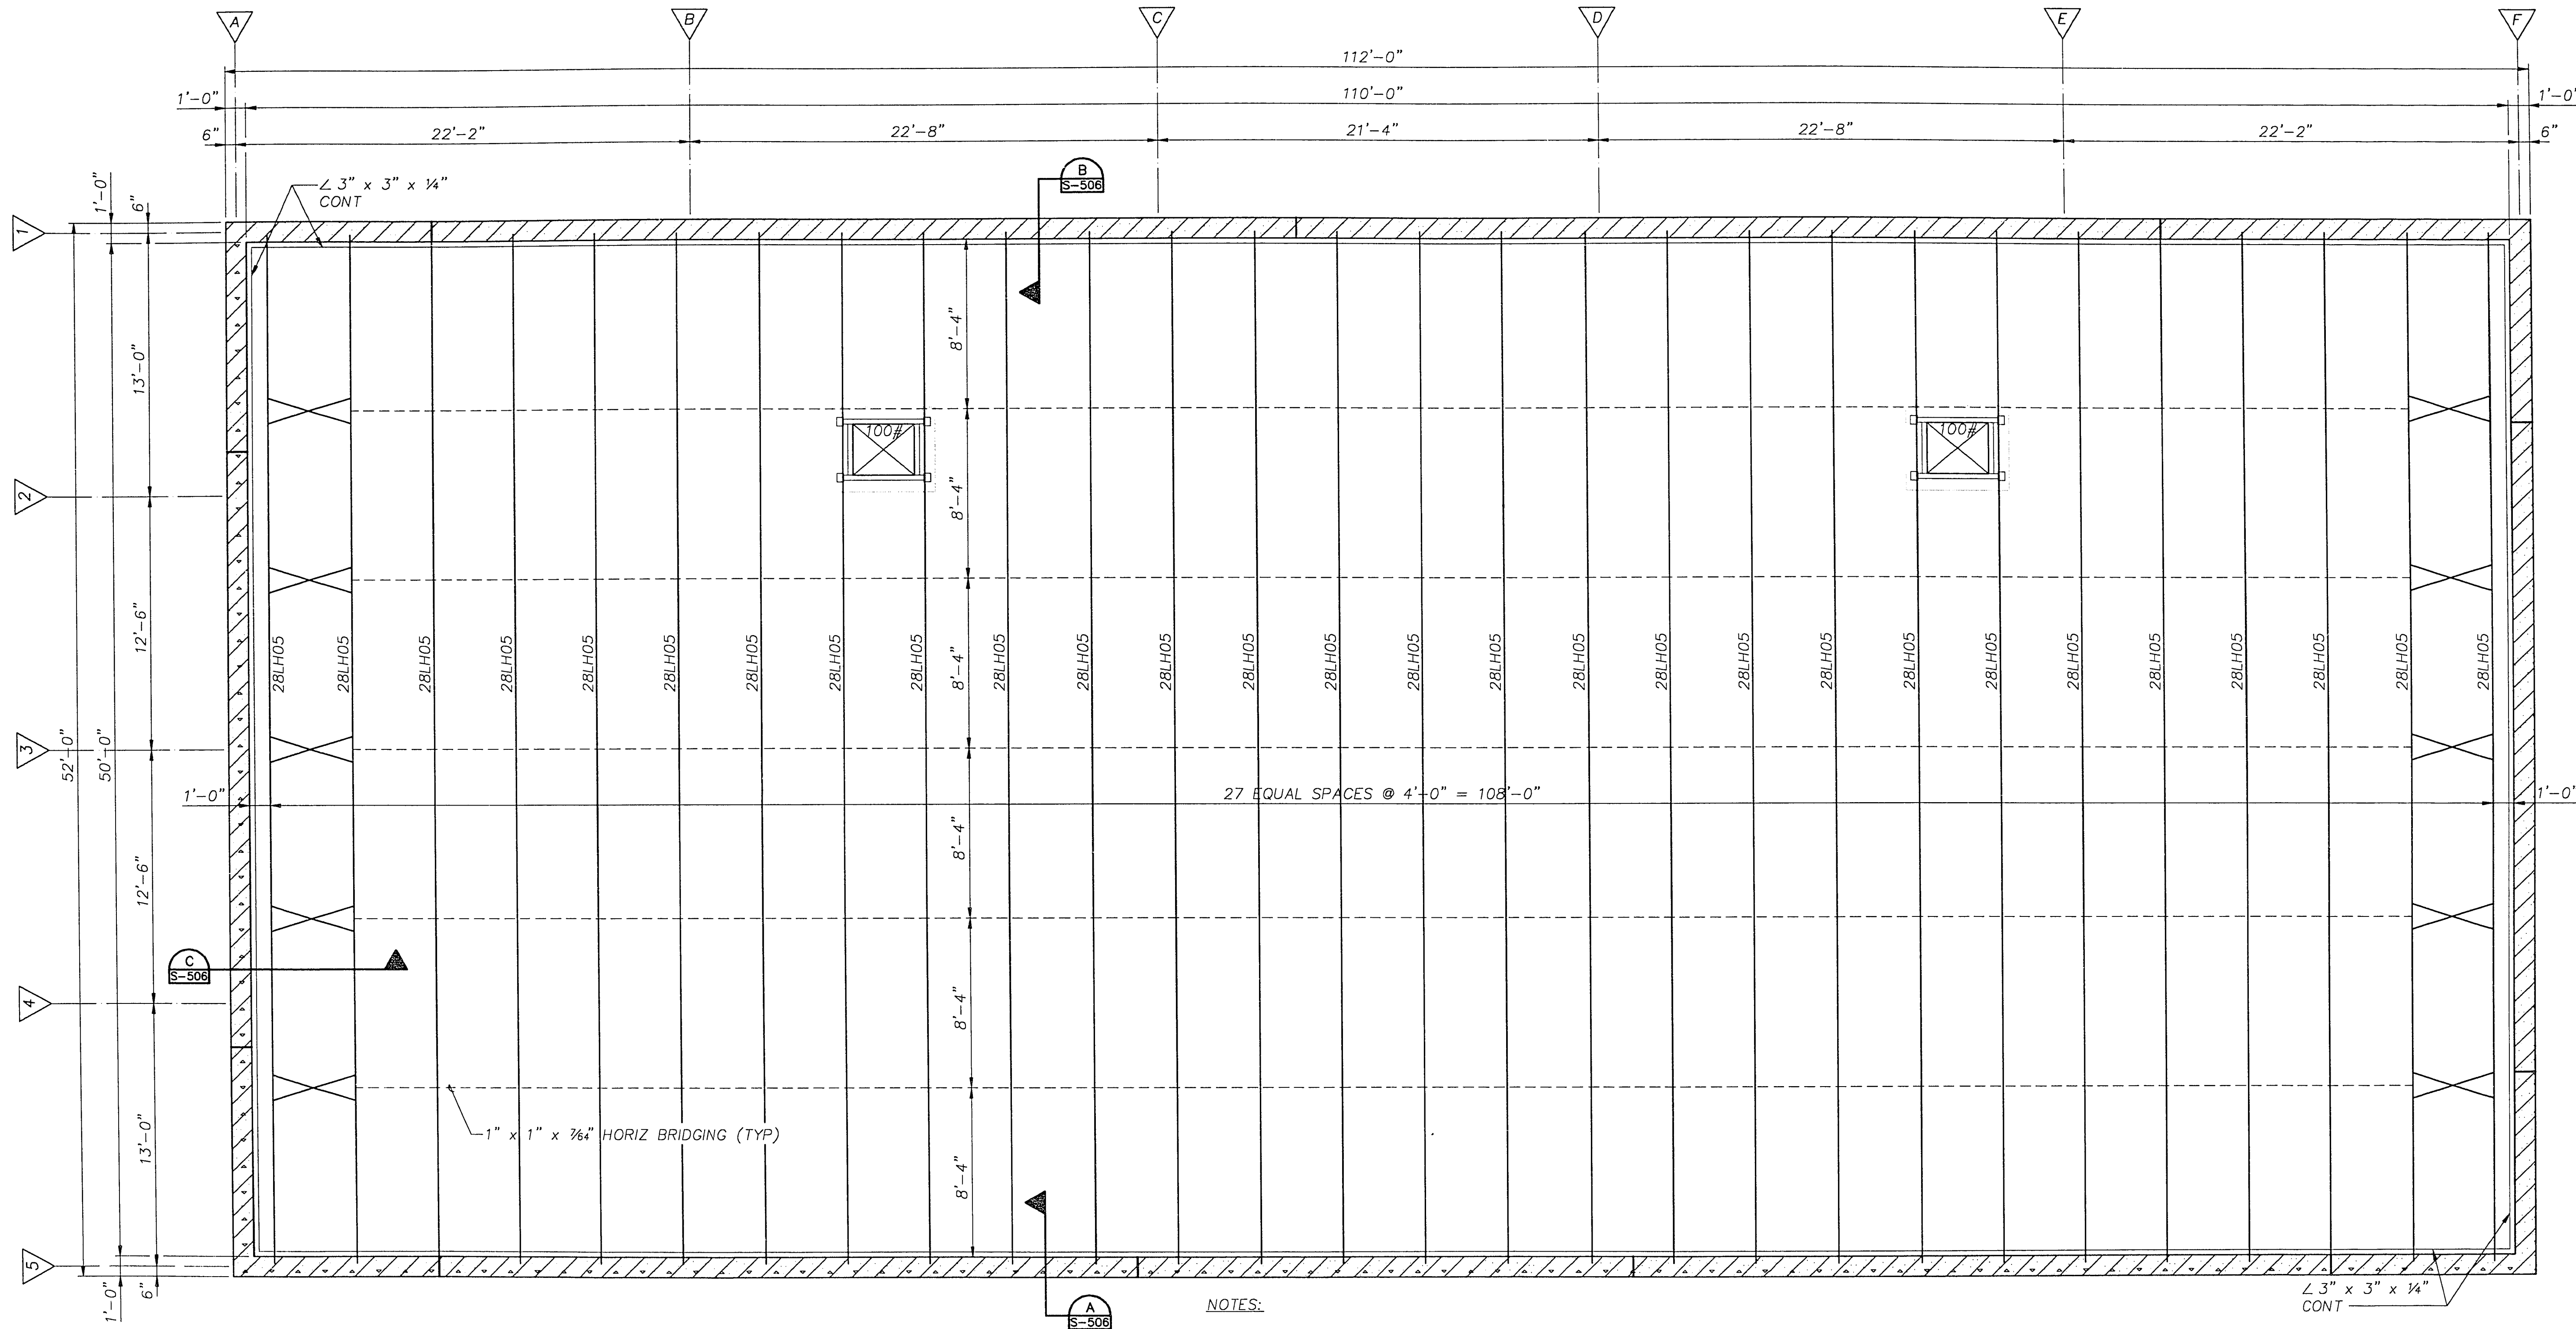


NOTES:

1. SEE DETAIL 5, DWG S-702 FOR OPENING FRAMING.
2. FOR EXACT LOCATION OF ROOF PENETRATIONS, REFER TO MECHANICAL AND ARCHITECTURAL DRAWINGS.
3. ROOF OPENING SIZE SHALL CONFORM TO MANUFACTURER'S SPECIFICATIONS.
4. CONTINUOUS ROOF DECK ANGLE ($\angle 3"x3"x\frac{1}{4}"$) MAY BE SPLICED AT CONTRACTOR'S OPTION PER DETAIL 6, DWG S-702.
5. JOISTS SHALL BE DESIGNED TO SUPPORT A UNIFORM TOTAL LOAD OF 225 PLF INCLUDING A UNIFORM LIVE LOAD OF 80 PLF.

NOTE:

IT IS THE CONTRACTOR'S RESPONSIBILITY TO COORDINATE THE STRUCTURAL DRAWINGS WITH ALL OTHER CONTRACT DOCUMENTS. STRUCTURAL DRAWINGS DO NOT ATTEMPT TO SHOW ALL MECHANICAL AND ELECTRICAL PENETRATIONS AND ROUTING.

ROOF FRAMING PLAN

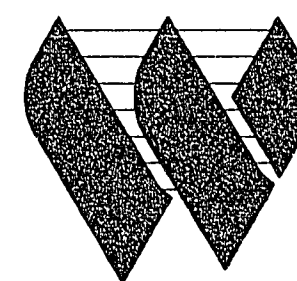


G.C. WALLACE, INC.
Engineering/Architecture



HDR Engineering, Inc.

Issue No.	Description	Date	Drawn	Checked	Reviewed	Approved
1	CORRECTED ACCORDING TO CONSTRUCTION RECORD	11/95	RRL	EFH	MJH	JJC
0	ISSUED FOR CONSTRUCTION	8/20/92	RCH	CRD	CRD	JJC
A	ISSUED FOR BID	4/20/92	JH	CLS	CRD	JJC

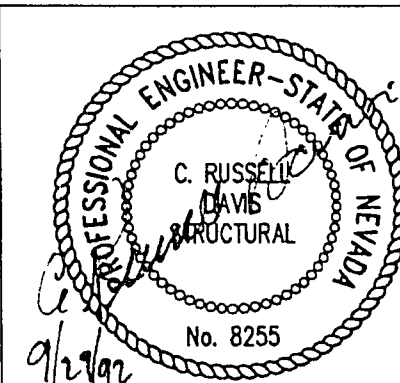

Project Manager	JOHN J. CHUEH
Architect	100/Process
Civil	Mechanical
Electrical	Structural
Drawn By	R. DAVIS
Check By	J. HIRSHOUER

City of Las Vegas
Water Pollution Control Facility
Nitrification / Filtration Facilities
Contract 17
NITRIFICATION COMPLEX

CENTRIFUGE BUILDING
ROOF FRAMING PLAN

Date	APRIL 1992	Project No.	00120-084-141	Drawing No.	S-500	Issue	1
Scale	1/4" = 1'-0"						

