




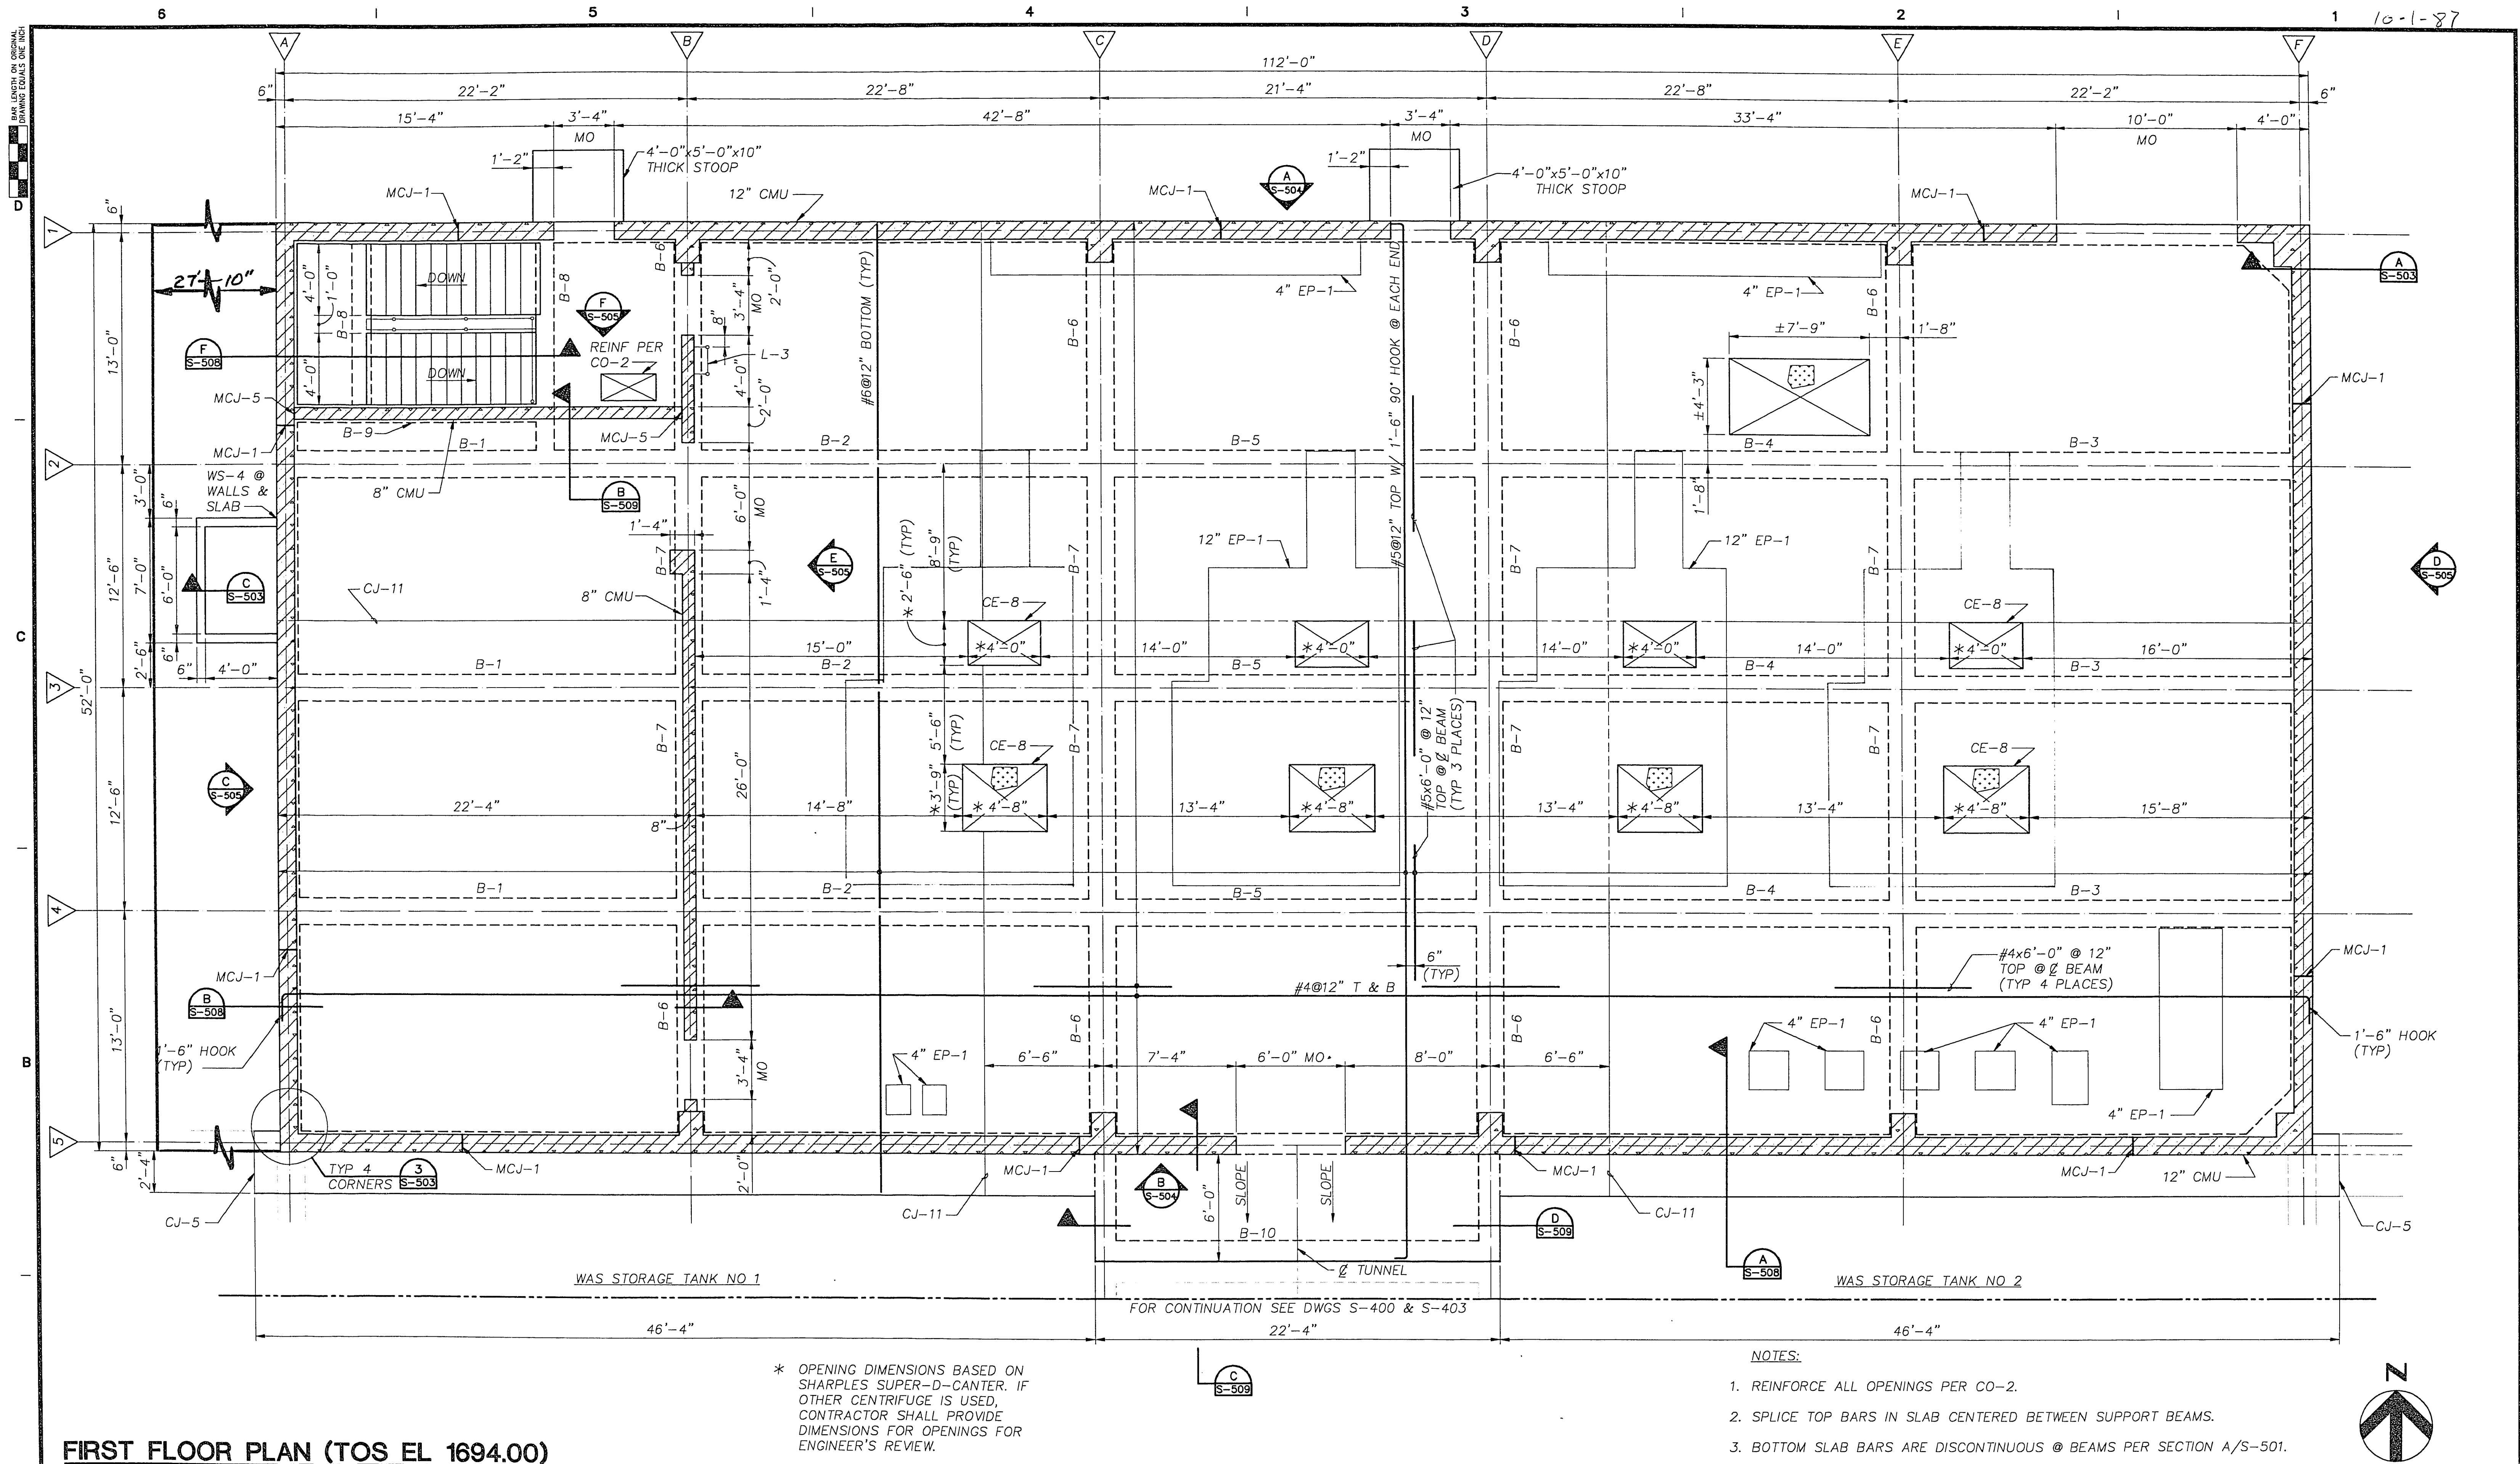

FIRST FLOOR PLAN (TOS EL 1694.00)

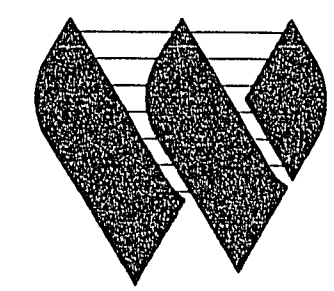


G.C. WALLACE, INC.
Engineering/Architecture

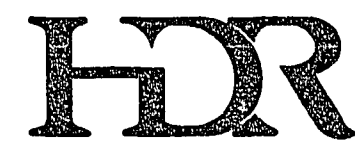

HDR Engineering, Inc.

Issue No.	Description	Date	Drawn	Checked	Revised	Project Mgr.
1	CORRECTED ACCORDING TO CONSTRUCTION RECORD	1/95	RRL	EFH	MJH	JJC
0	ISSUED FOR CONSTRUCTION	8/20/92	RCH	CRD	CRD	JJC
A	ISSUED FOR BID	4/20/92	JH	CLS	CRD	JJC

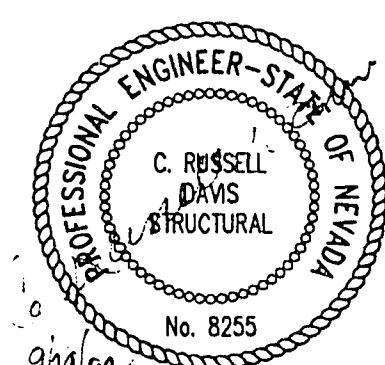

Project Manager	JOHN J. CHUEH
Architect	MC/Process
Civil	Mechanical
Electrical	Structural
Drawn By	R. DAVIS
Checked By	J. HIRSHOUER

City of Las Vegas
**Water Pollution Control Facility
Nitrification / Filtration Facilities**
Contract 17
NITRIFICATION COMPLEX

**CENTRIFUGE BUILDING
FIRST FLOOR PLAN**

Date	APRIL 1992	Project No.	00120-084-141	Drawing No.	S-501	Sheet	1
Scale	1/4" = 1'-0"						