



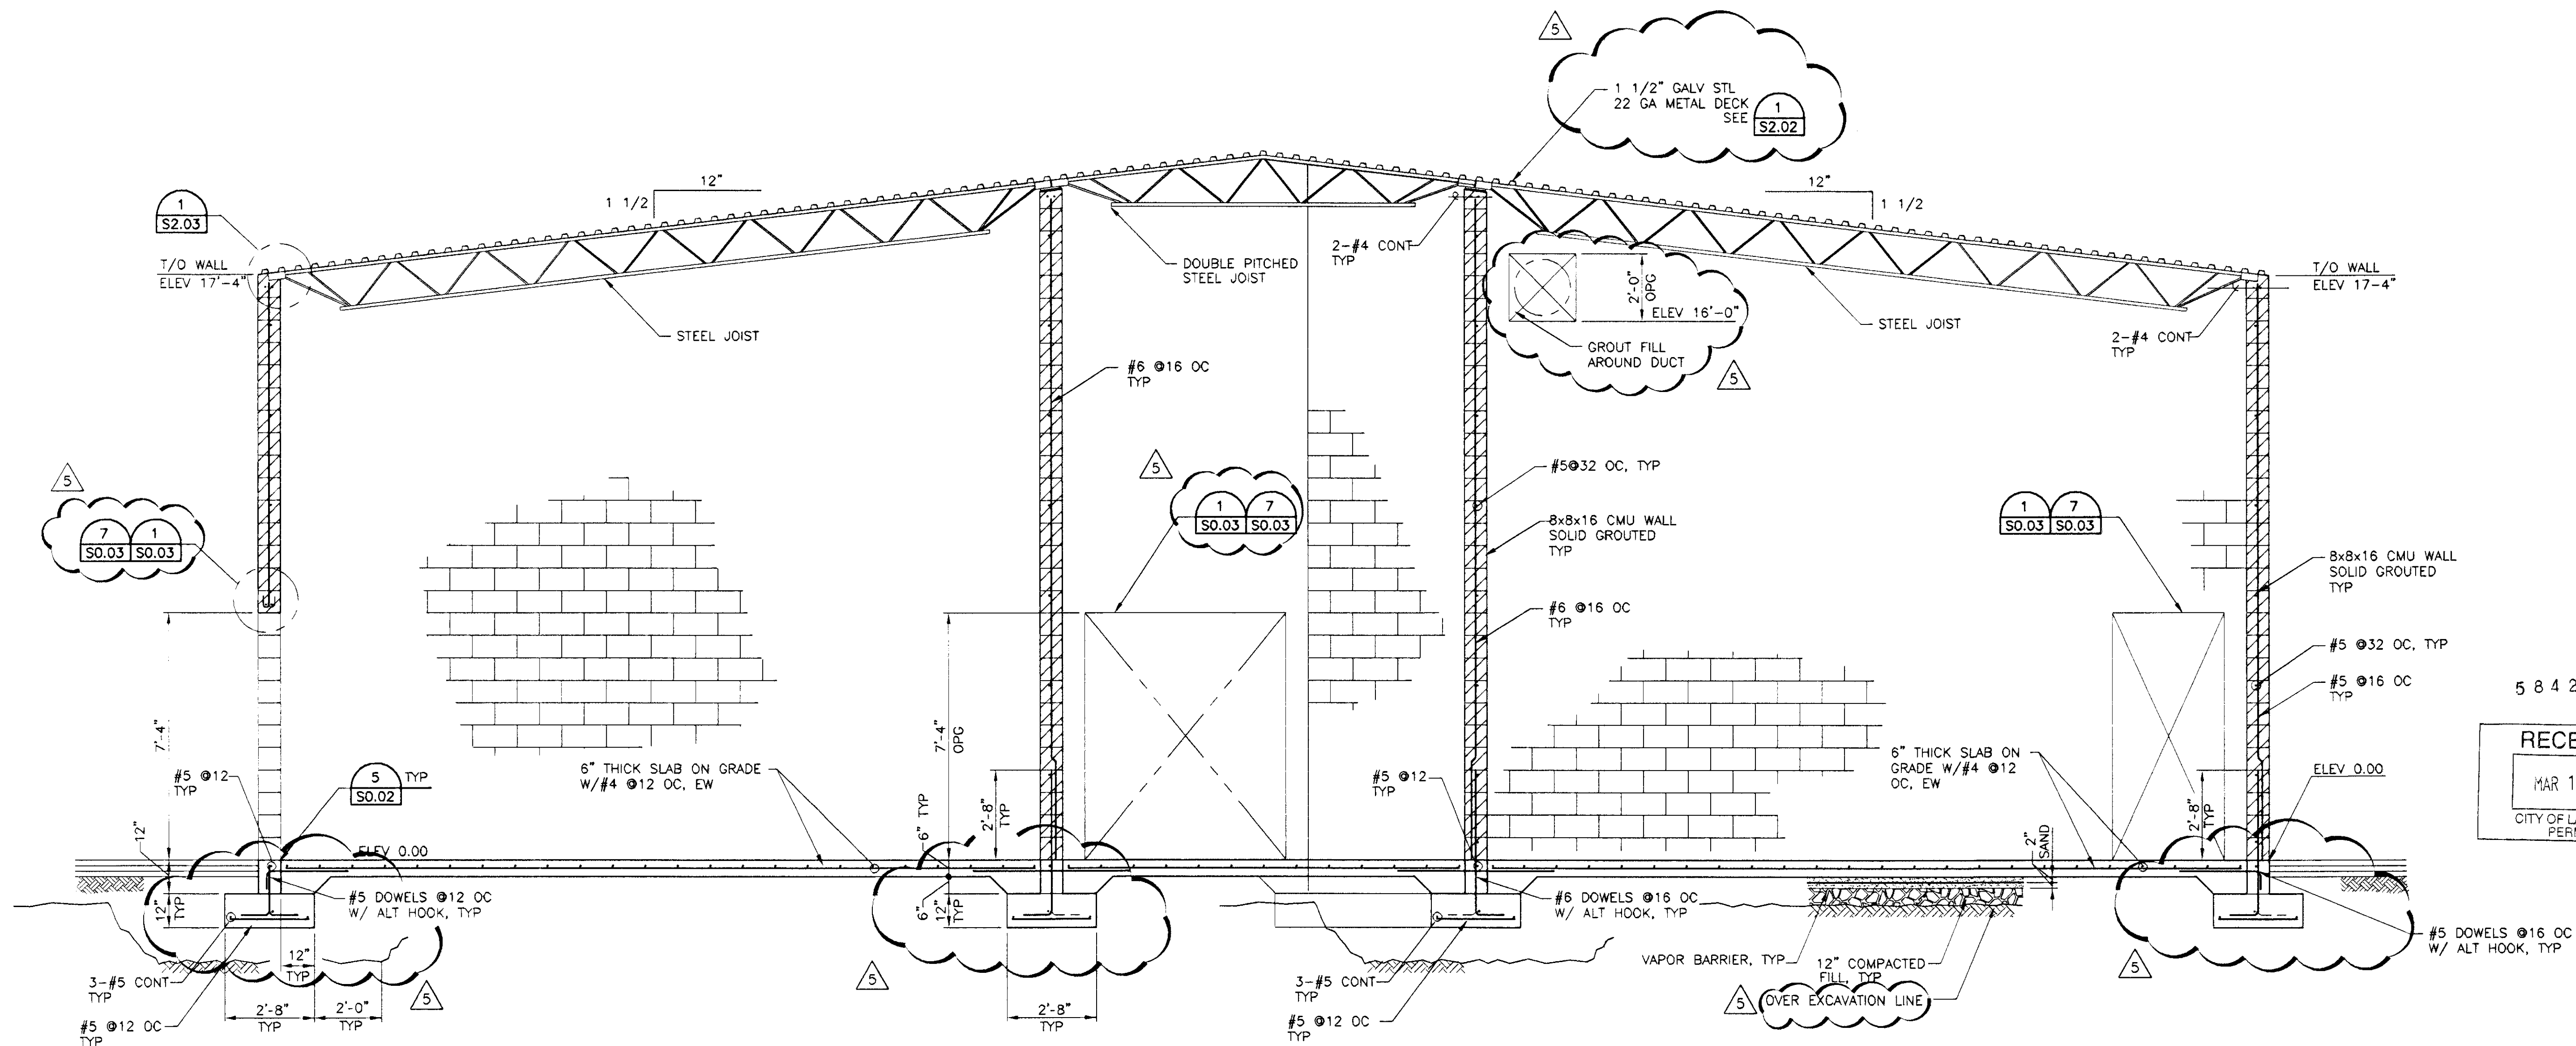

SECTION
A
S2.01

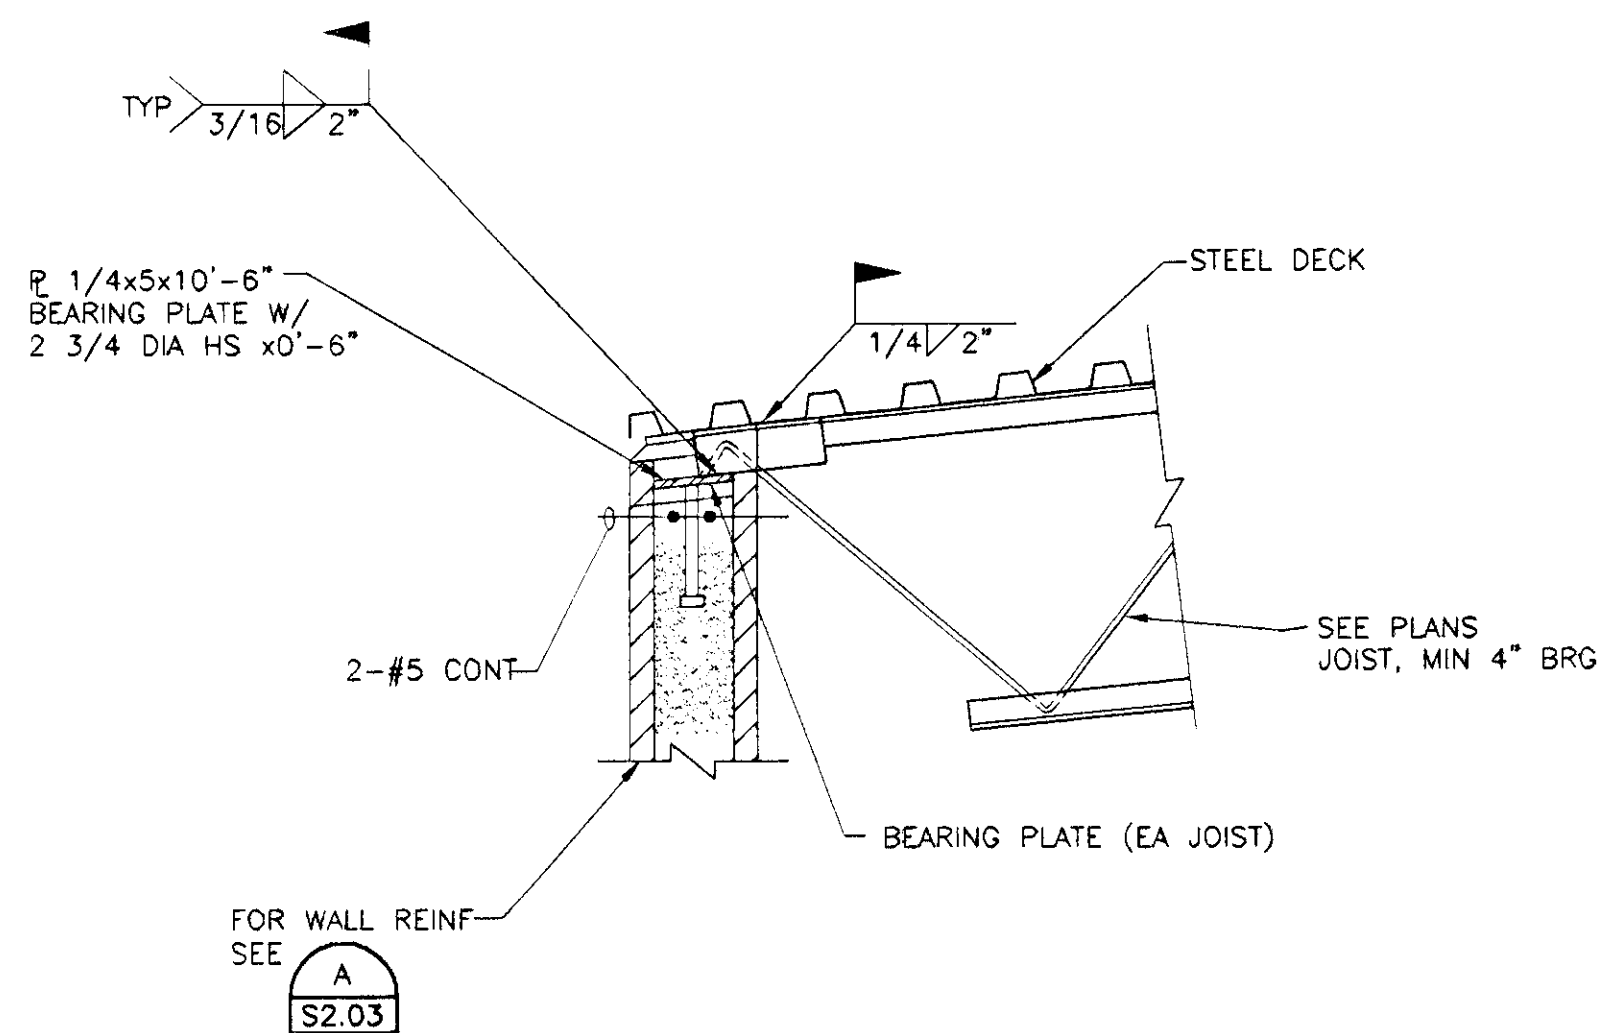

DETAIL
1/2" = 1'-0"
A
S2.03

APPROVAL IS FOR CLOUDED
AREAS OR LATEST REVISIONS
ONLY. SEE ORIGINALS
FOR OTHER REQUIREMENTS



REVISIONS
5 03.14.03

CONSULTANT

poggemeyer
design group, inc.
engineers • planners • surveyors • landscape architects
2601 North Energy Way • Las Vegas, NV 89128 • 702.255.8100 • 702.255.8175


CITY OF LAS VEGAS WEST SERVICE YARD
BUFFALO DRIVE AND PEAK ROAD
LAS VEGAS, NEVADA
SECTION
FIELD MAINTENANCE BUILDING

APPROVED
STRUCTURAL
Engineering & Safety Dept.
City of Las Vegas, Nevada

LTB APR 10 2003

Does Not Include: 1. Structural Steel
2. Plumbing & Mechanical Details

STAMP: Without Expiration Date
Not a Permit to Construct

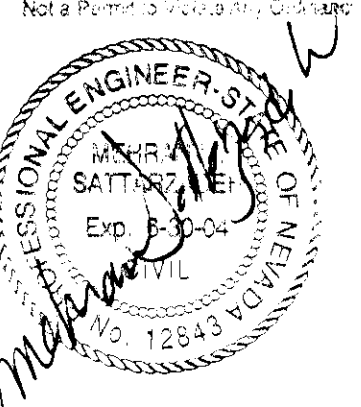

OWNER: CITY OF LAS VEGAS
DEPARTMENT OF PUBLIC WORKS
ARCHITECTURAL SERVICES

400 EAST STEWART AVENUE
LAS VEGAS, NEVADA 89101
PHONE: (702) 229-5939
FAX: (702) 382-3232
TDD: (702) 386-9108

DRAWN: SMK
FILE: 0475203
DATE: 03.14.03
SCALE: 3/8"=1'-0"
JOB NO: 02.15341.09
CLVDWG NO: 107.V3548

SHEET NO
S2.03

OF