


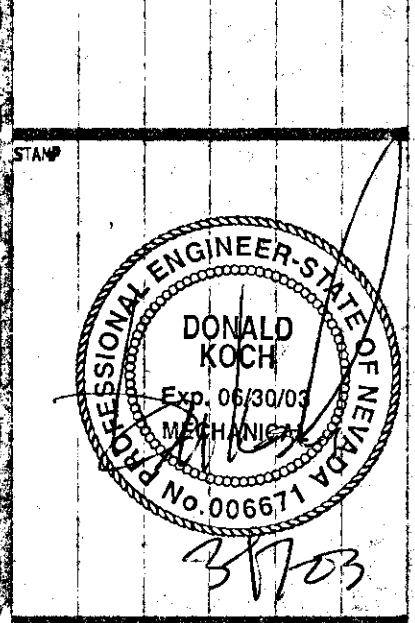

REVISION #	AUGUST 30, 2002
REVISION #	OCTOBER 16, 2002
REVISION #	JANUARY 22, 2003
PLAN CHECK	MARCH 14, 2003

STATE ENGINEER	PLUMBING
STATE ENGINEER	ELECTRICAL
STATE ENGINEER	M.E.C.
STATE ENGINEER	M.E.C.
STATE ENGINEER	M.E.C.

CITY OF LAS VEGAS  
DEPARTMENT OF PUBLIC WORKS  
BUFFALO DRIVE AND PEAK ROAD  
LAS VEGAS, NEVADA  
FLOOR PLAN  
MATERIALS HANDLING BUILDING




OWNER: CITY OF LAS VEGAS  
DEPARTMENT OF PUBLIC WORKS  
ARCHITECTURAL SERVICES

400 EAST STEWART AVENUE
LAS VEGAS, NEVADA 89101
PHONE: (702) 229-8535
FAX: (702) 382-3232
TDD: (702) 386-9108

DRWR	DD
FILE	6431P112.DWG
DATE	06/26/02
SCALE	1/8" = 1'-0"
DWG NO	02.15341.09
C.V. DWG NO	107-V3548
SHEET NO	P1.12


**NOTES**

- ① 6" FIRE SPRINKLER SERVICE, RISER AND FIRE DEPARTMENT CONNECTION. ④
- ② 2" DOMESTIC COLD WATER SERVICE. ④
- ③ 6" SANITARY SEWER SERVICE. ④
- ④ SEE C5.03 FOR CONTINUATION.
- ⑤ FIRE SPRINKLER DRAIN STANDPIPE, SEE DETAIL ③/23.0'
- ⑥ SEE DETAIL ①/23.0'
- ⑦ 2" V. UP FROM BELOW GRADE.
- ⑧ 3" C.W. UP TO SIAMESE CONNECTION. PROVIDE AMES 2000 BACKFLOW PREVENTER ON RISER. INSULATE & HEAT TRACE EXPOSED PIPING.
- ⑨ NOT USED.
- ⑩ 2" I.C.W. UP FROM BELOW FLOOR TO HORIZONTAL ELBOW AT +18" A.F.F. TEE I.C.W. TO (2) POTTER ROEMER #4141 1 1/2" HYDRANTS AT +48" A.F.F. & (1) POTTER ROEMER #2868 1 1/2" VALVE & HOSE REEL ASSEMBLY W/ 100' HOSE & BRASS FOG NOZZLE. PROVIDE 3/4" H.B. AT BOTTOM. PROVIDE 2" S.O.V. JUST ABOVE FLOOR.
- ⑪ PIPING ABOVE GRADE TO BE SCH. 40 GALV. STEEL.
- ⑫ SEE ③/17.32'
- ⑬ 1 1/2" C.W. TO WSS ① & 1 1/2" S.C.W. UP.
- ⑭ STUB OUT 1 1/2" S.C.W. FOR FS ①.
- ⑮ VERIFY INVERT W/ CIVIL SITE UTILITY PLAN SHEET C5.03.
- ⑯ POINT OF CONNECTION TO ON SITE UTILITIES - SEE SHEET C5.03.
- ⑰ I.P.-2 W/ S.O.V. & 1/2" LINE DOWN TO BELOW SLAB TO TRAP OF STANDPIPE.


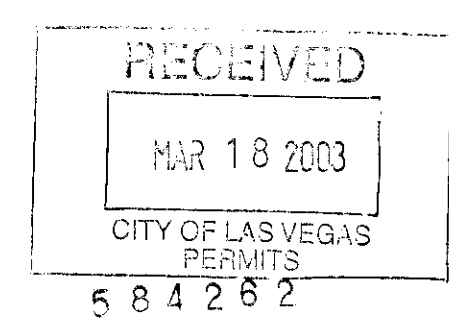


APPROVAL IS FOR CLOUDED AREAS ONLY. SEE ORIGINALS FOR OTHER REQUIREMENTS

PLANS APPROVED  
PLUMBING/MECHANICAL  
JCF MAR 28 2003

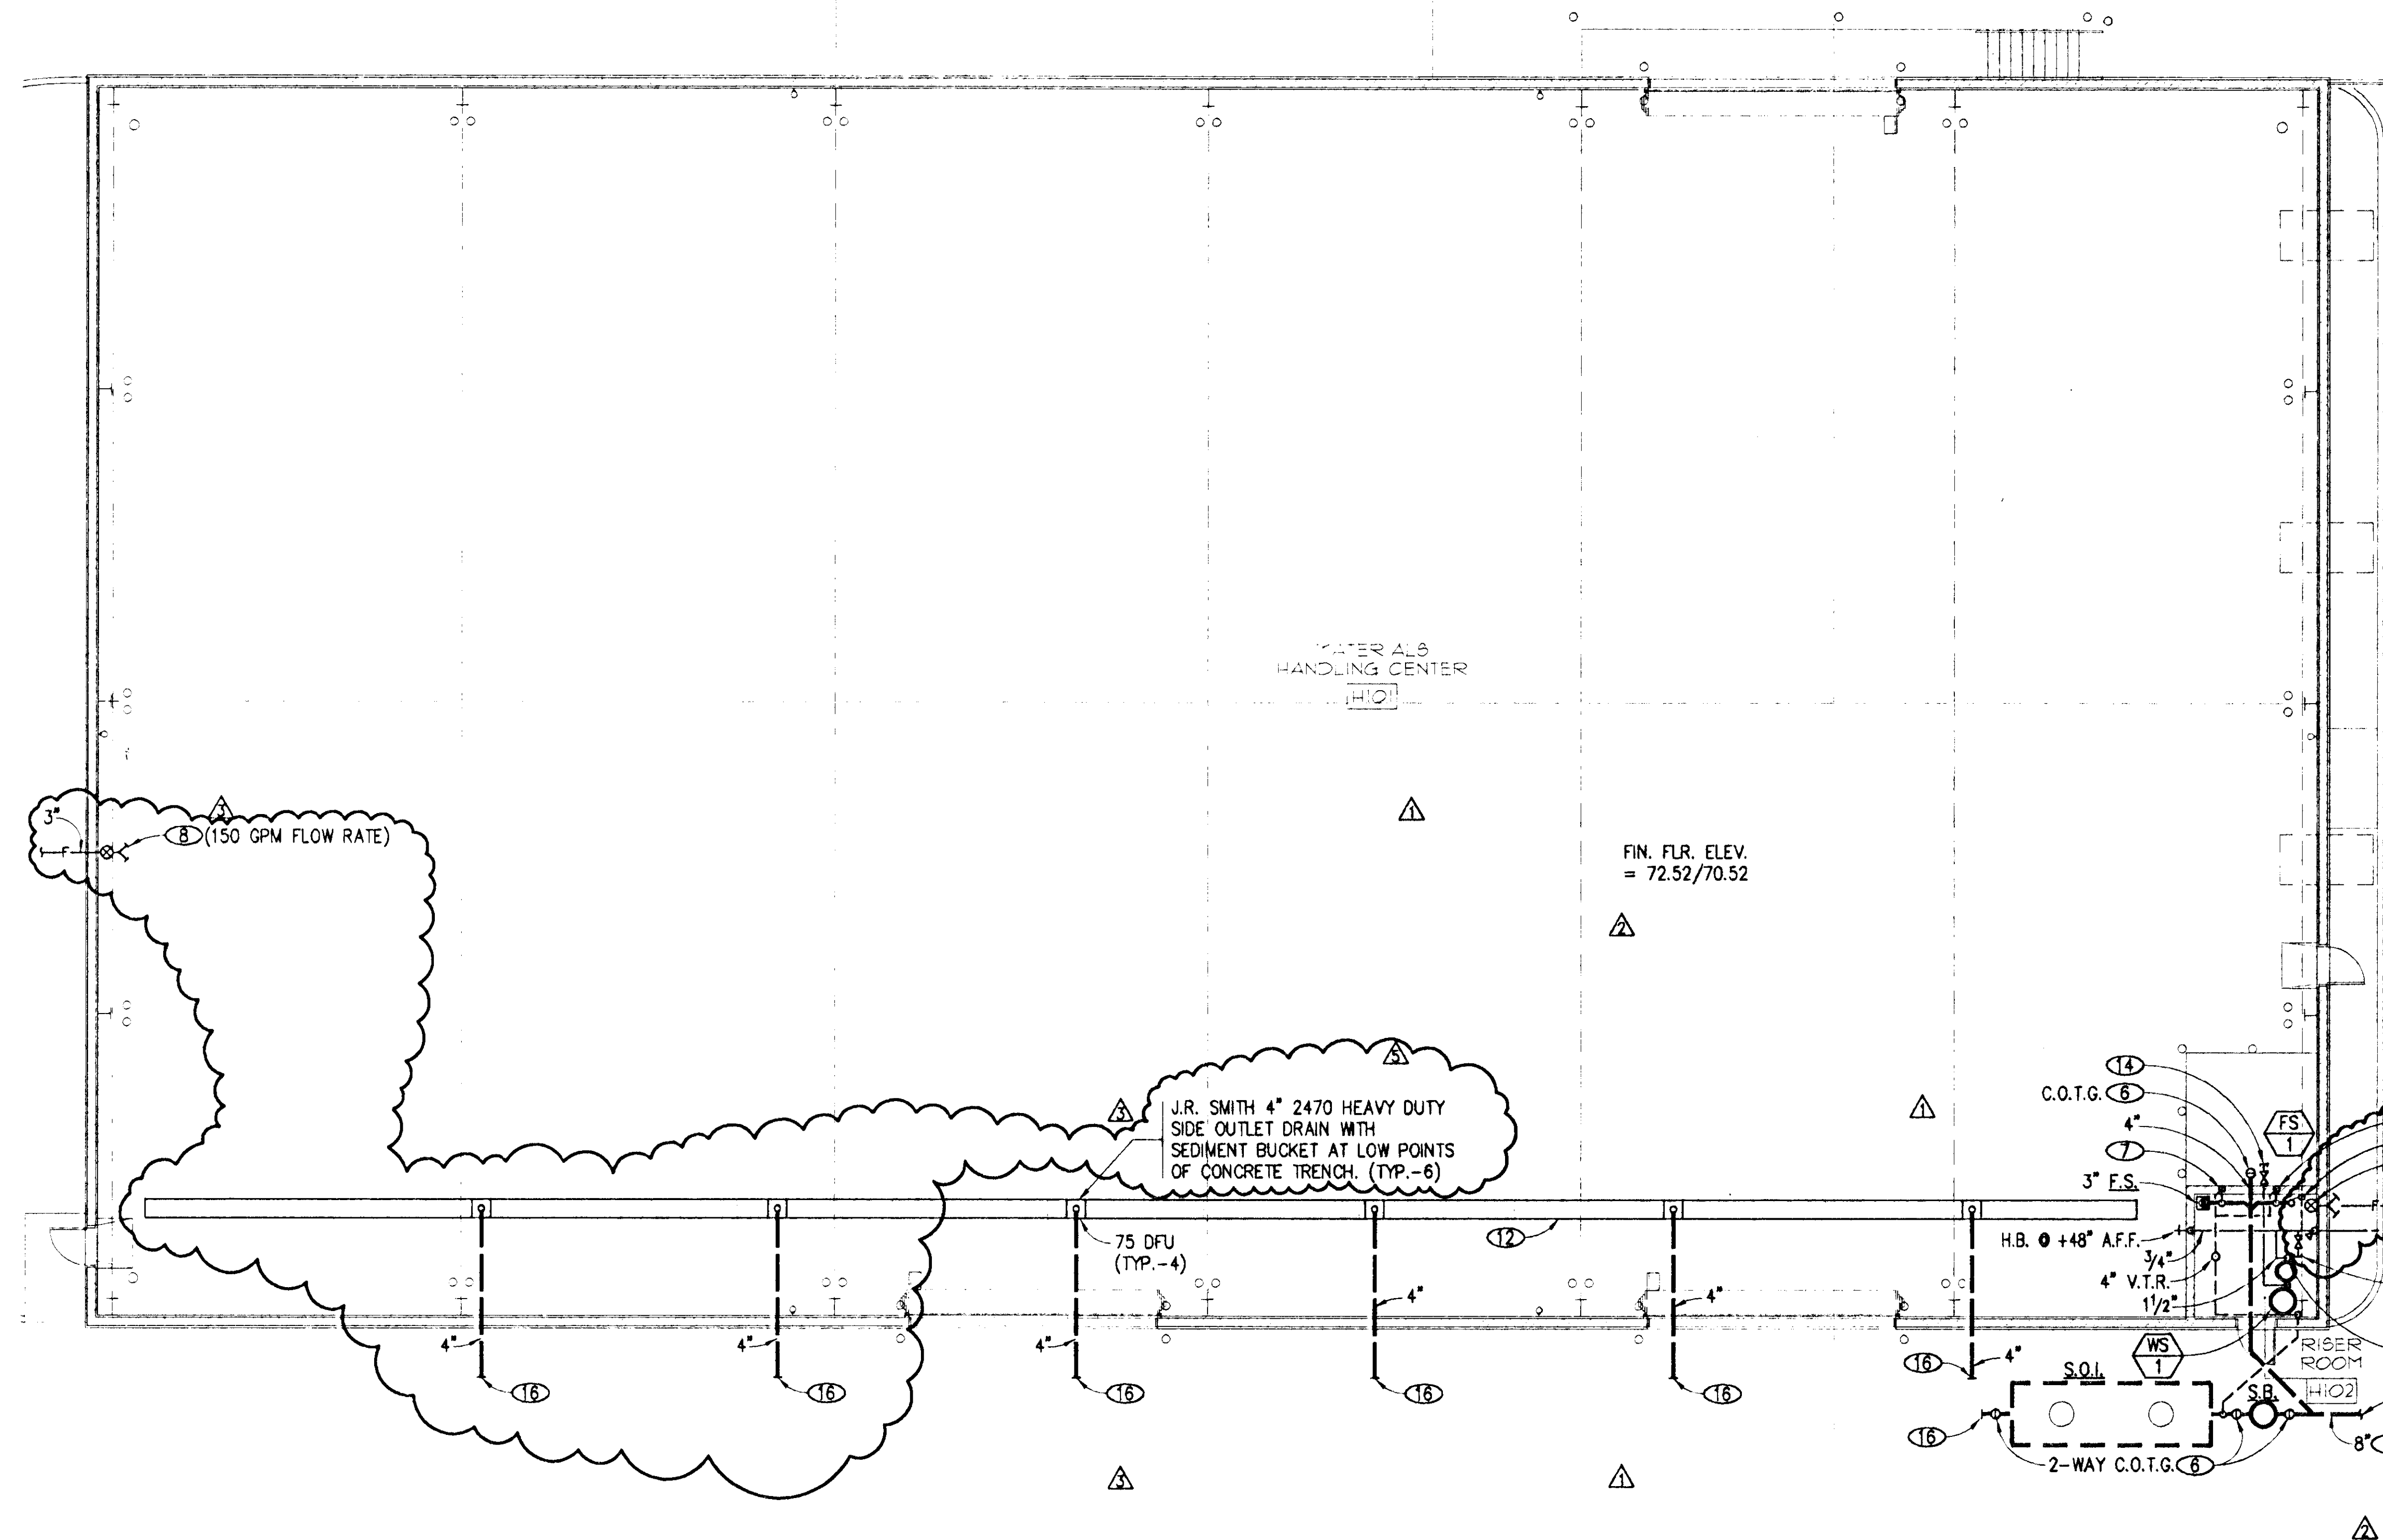

**FLOOR PLAN**  
SCALE: 1/8" = 1'-0"

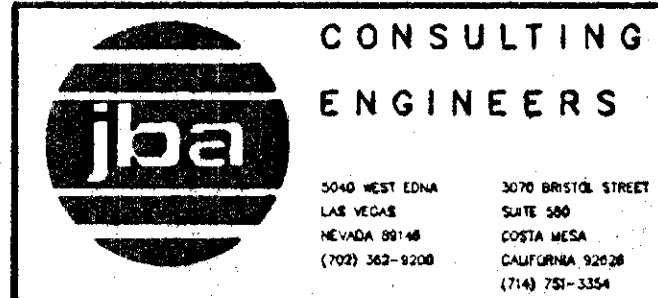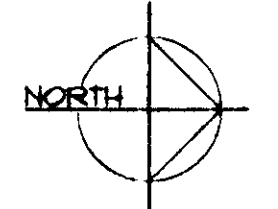

3070 WEST EDNA  
LAS VEGAS, NEVADA 89102  
(702) 363-1208

3070 BRITISH STREET  
SUITE 500  
DUSTY WICK  
CALIFORNIA 92028  
(714) 751-3354

D:\0431\Drawings\PLUMBING\64310112.dwg, 03/17/2003 12:58:44 PM, dhg2