

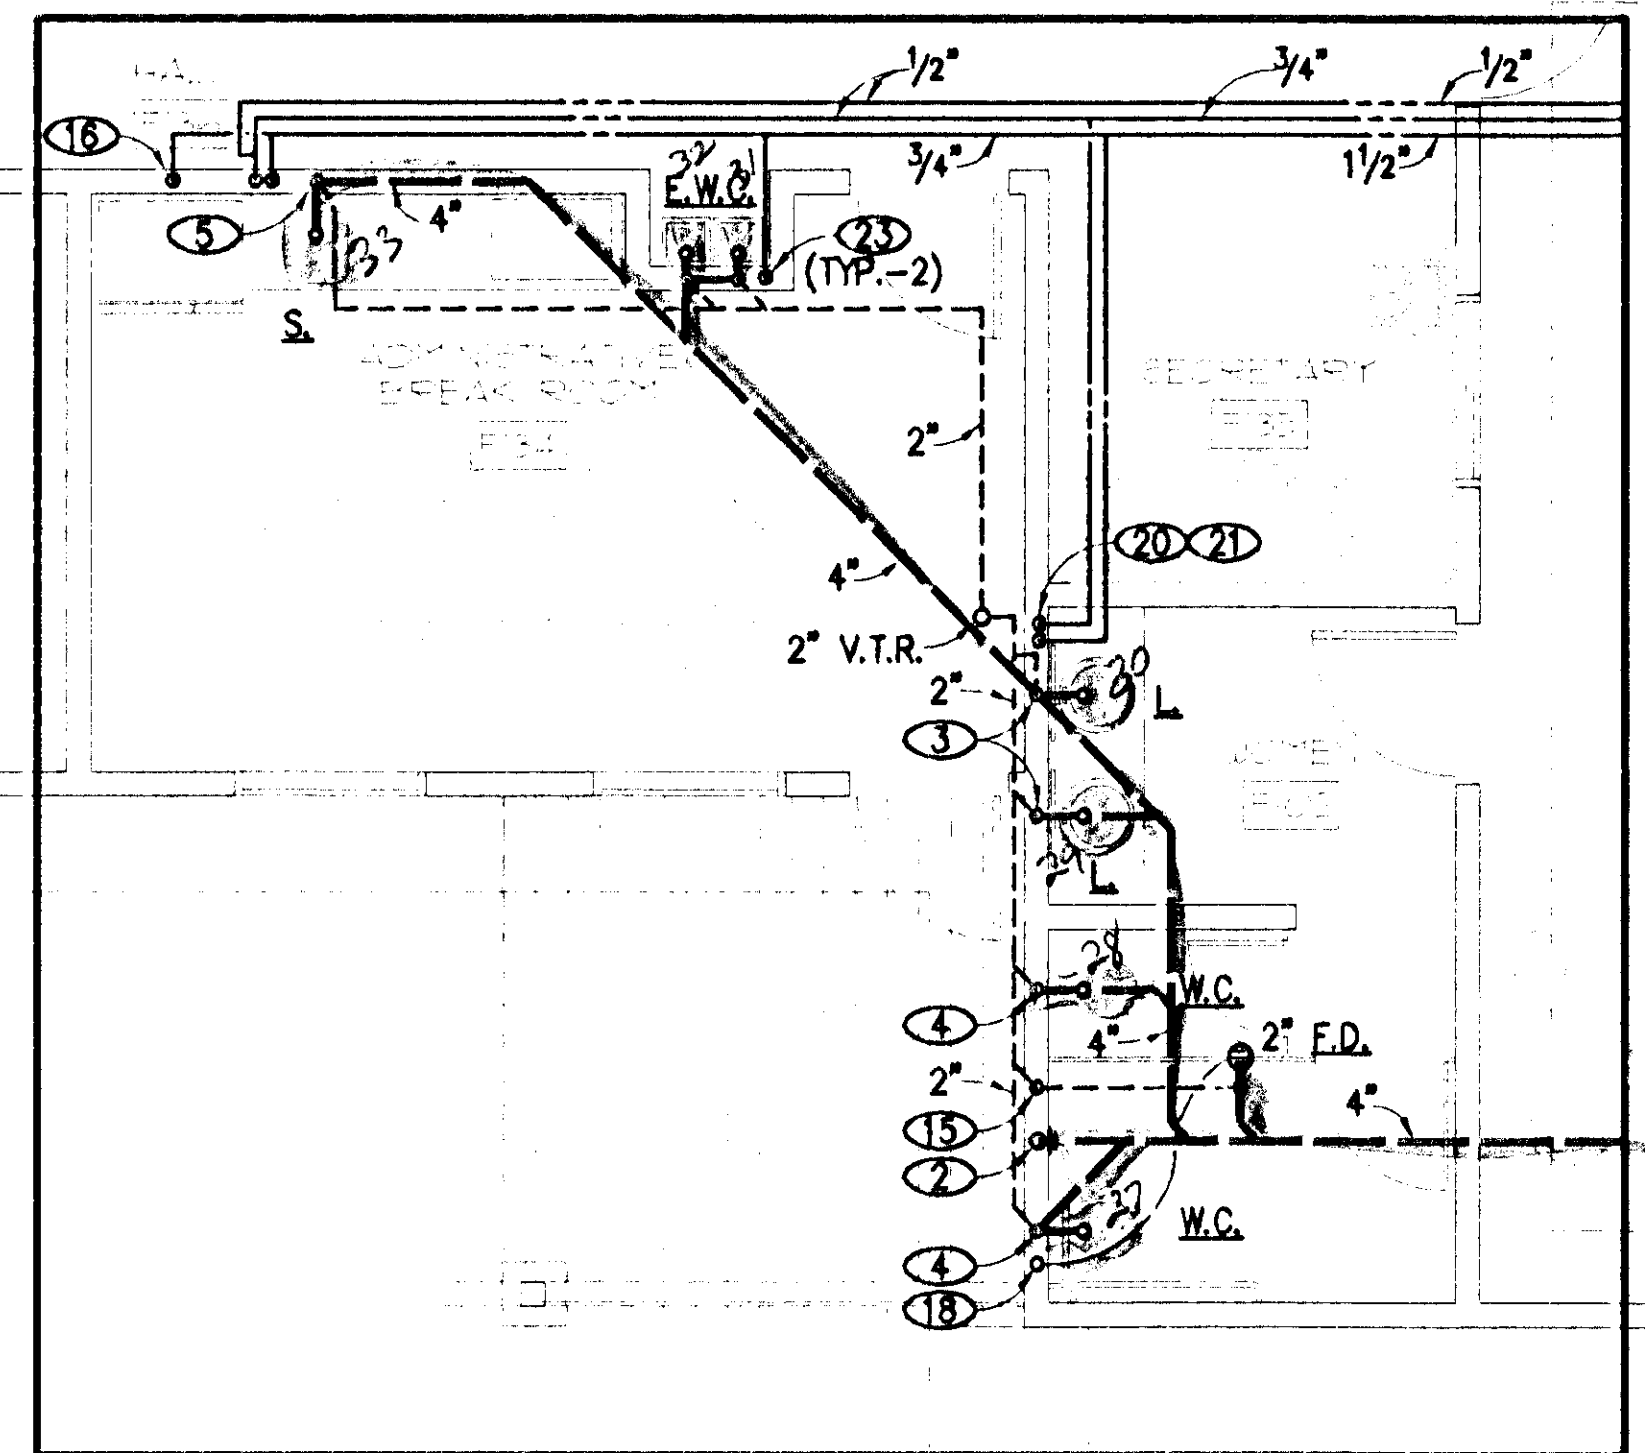


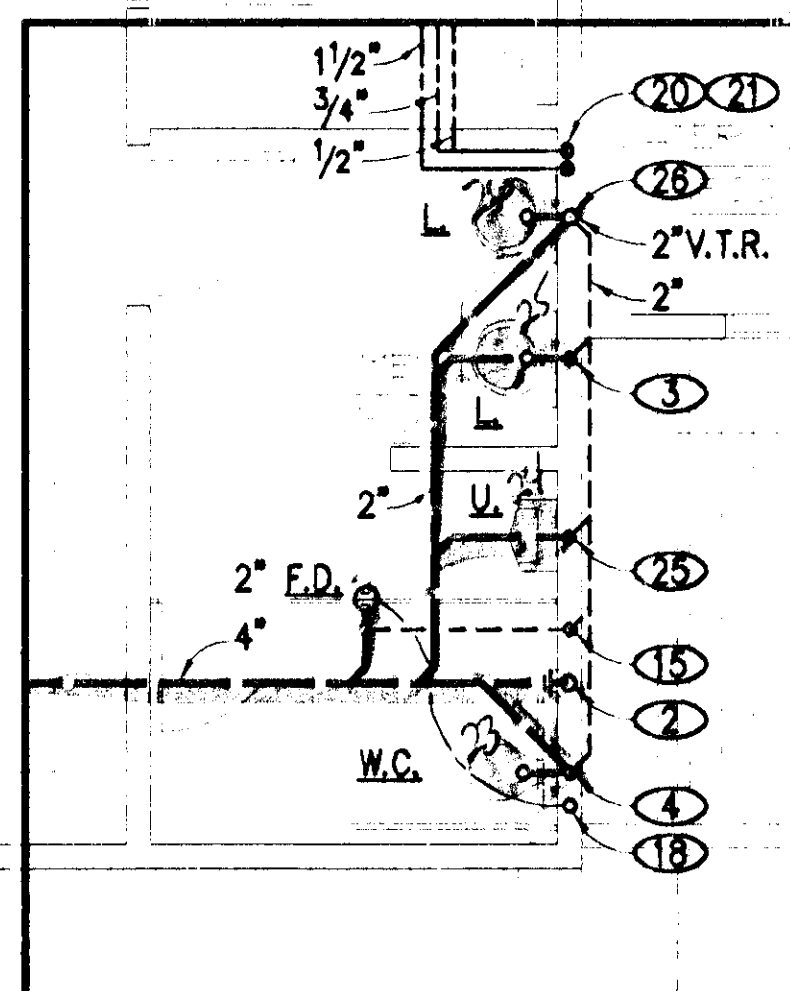



PARTIAL FLOOR PLAN
SCALE: 1/4" = 1'-0"

C

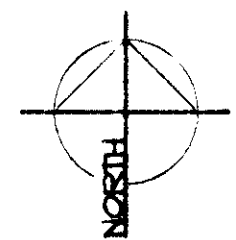



PARTIAL FLOOR PLAN
SCALE: 1/4" = 1'-0"

D

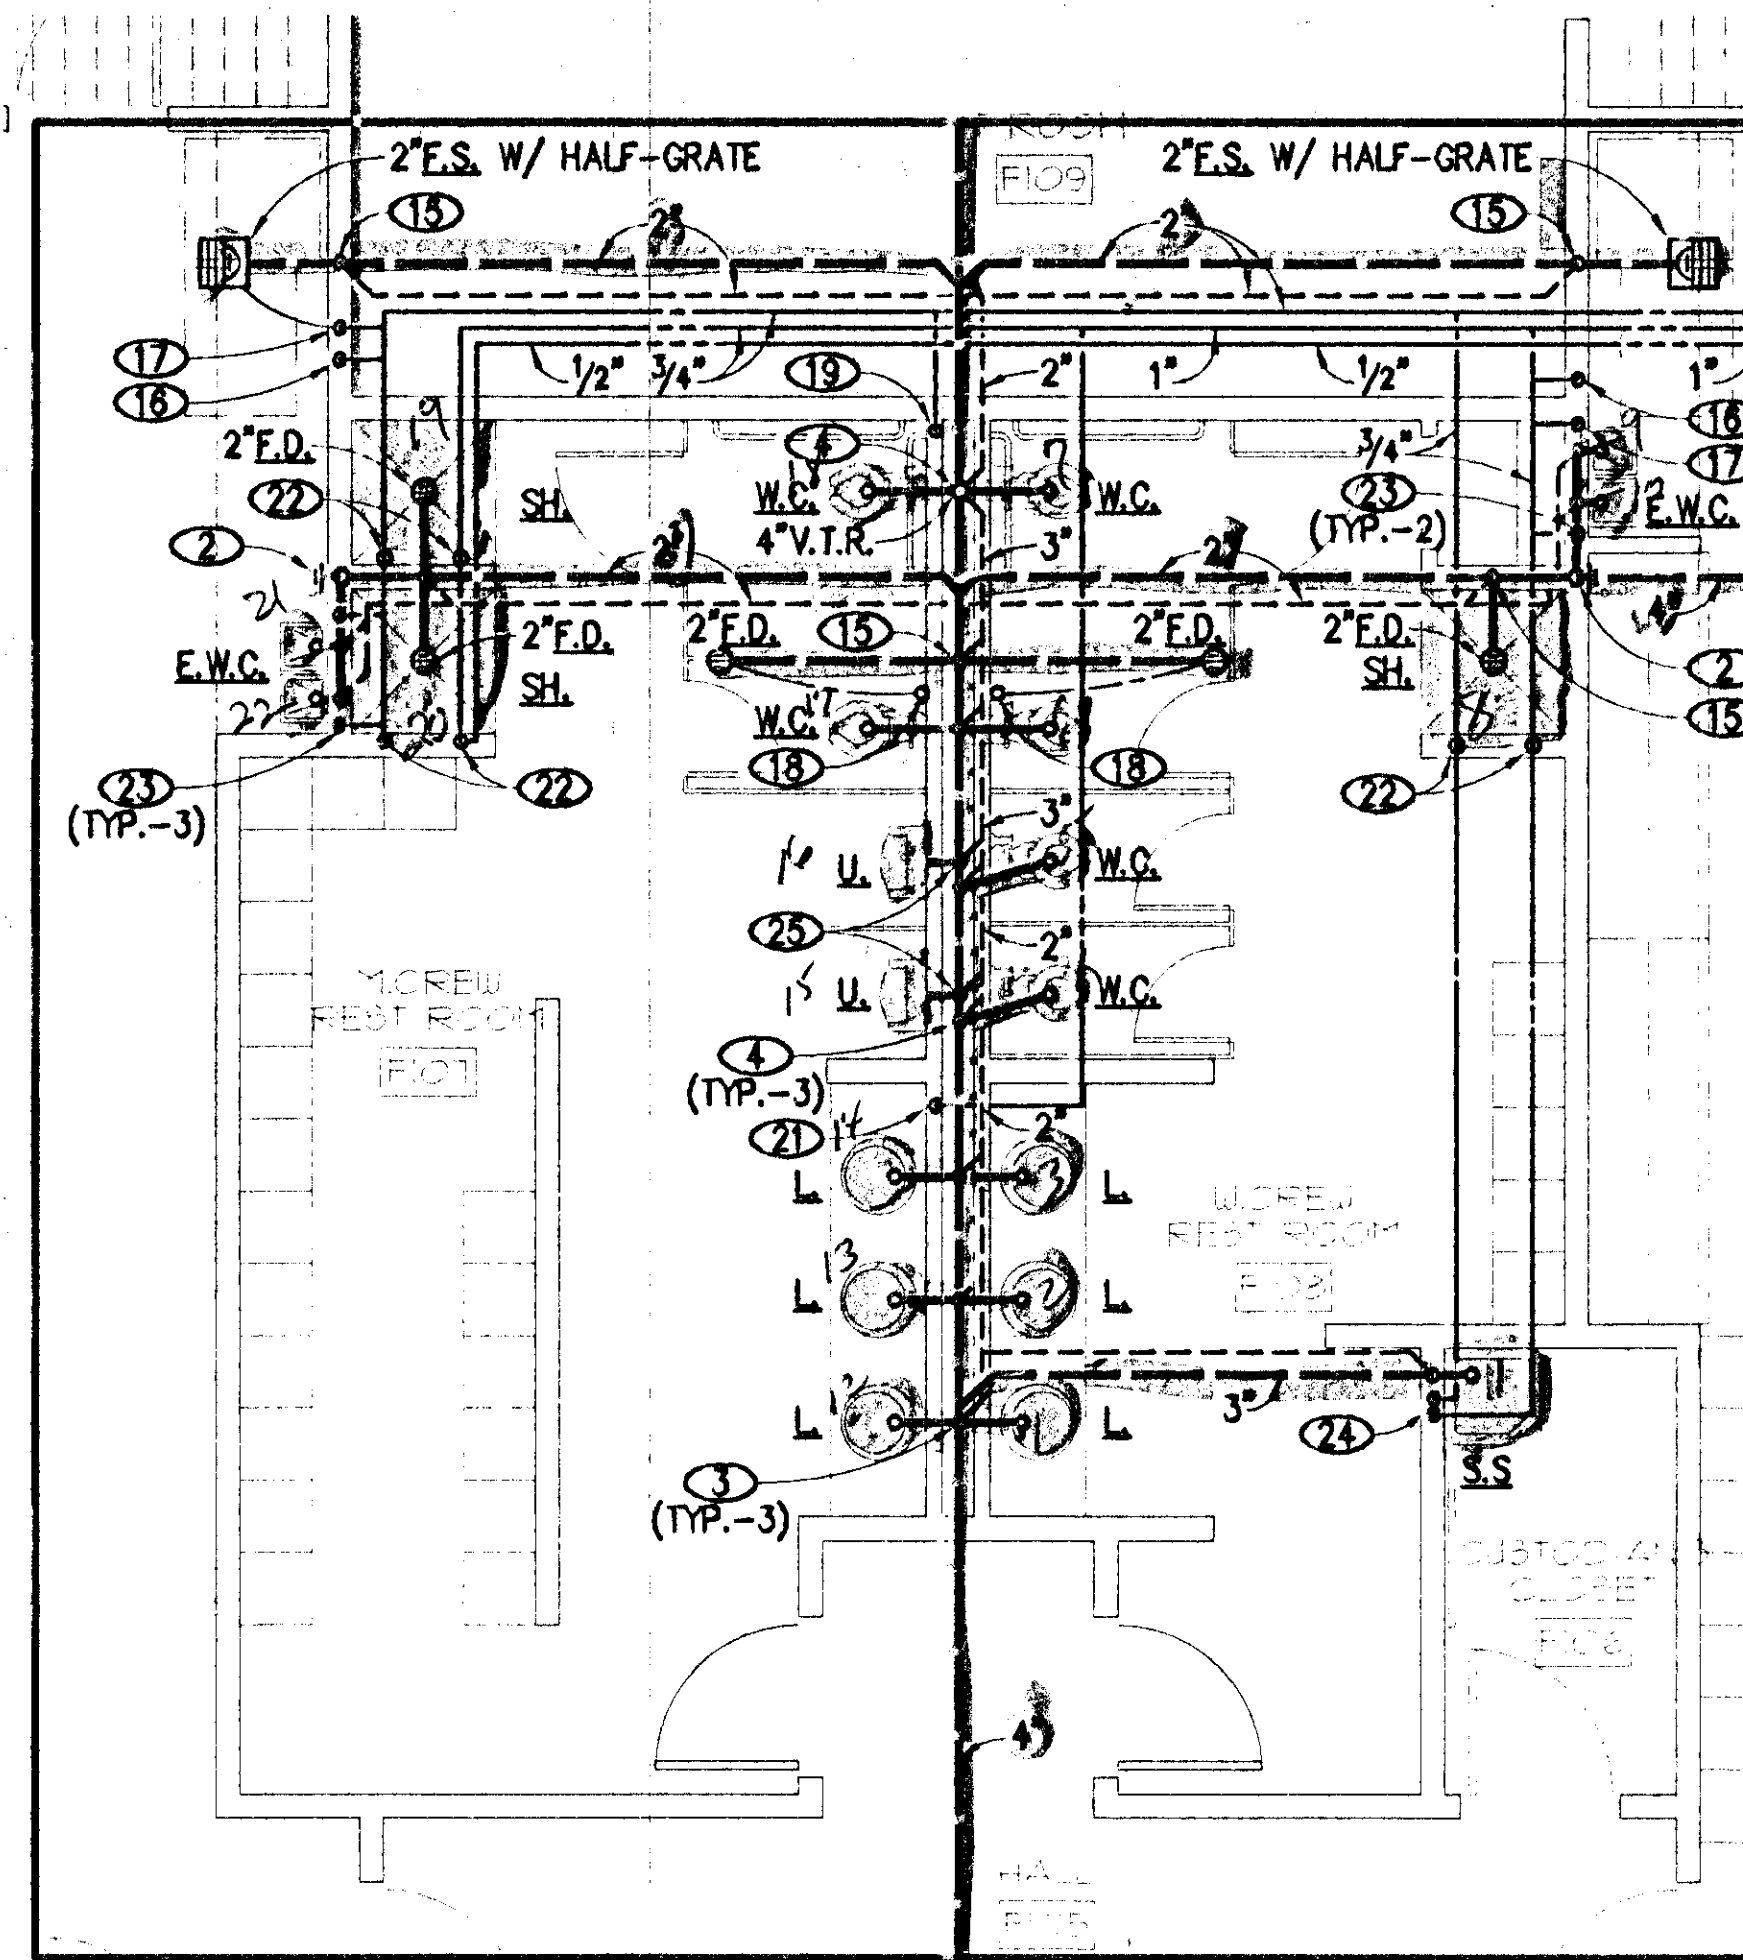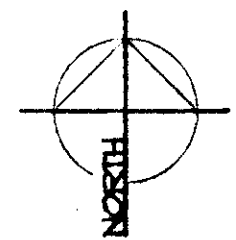


PARTIAL FLOOR PLAN
SCALE: 1/4" = 1'-0"

A

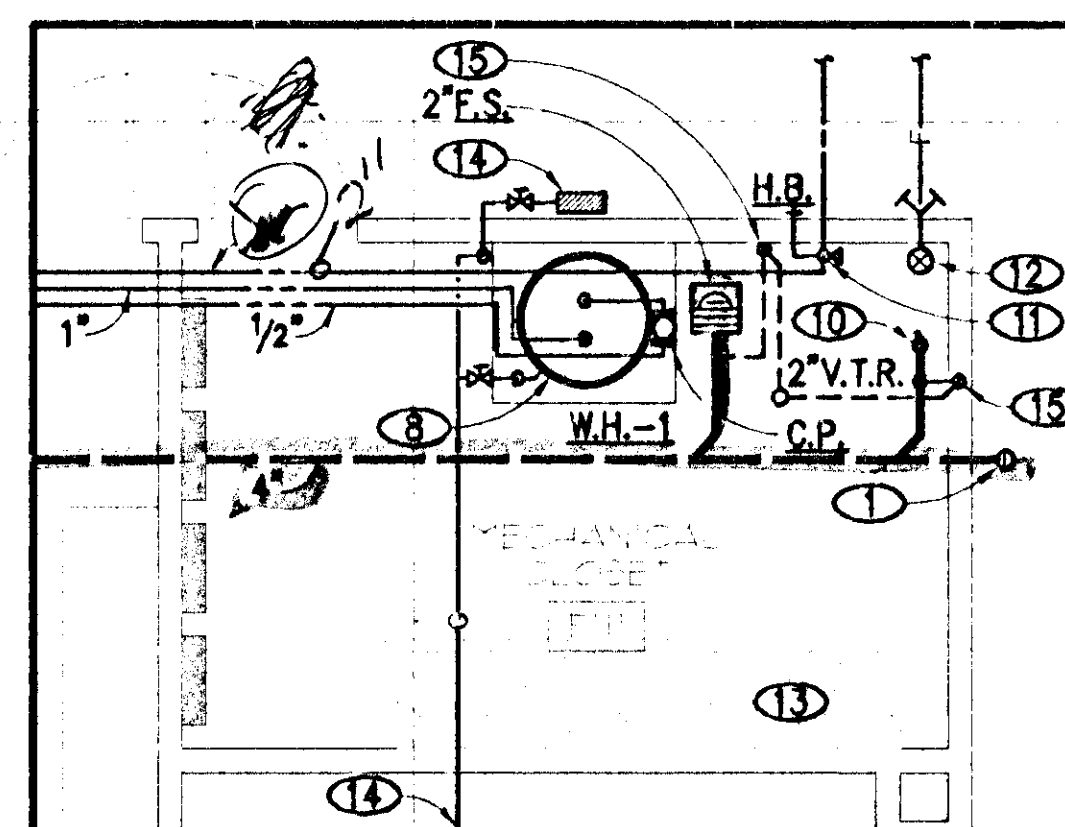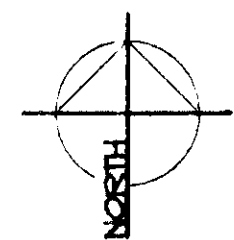

PARTIAL FLOOR PLAN
SCALE: 1/4" = 1'-0"

B

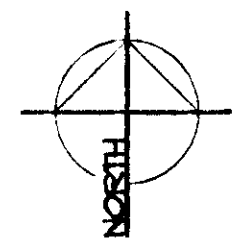

NOTES

- 1 LINE SIZE C.O.T.G. SEE DETAIL 1/3.07.
- 2 LINE SIZE W.C.O.
- 3 2" W. DOWN, 1/2" V. UP, 1/2" C.W./H.W.
- 4 4" W. DOWN, 2" V. UP, 1" C.W. DOWN.
- 5 2" W. DOWN WITH 4" W.C.O., 1/2" V. UP, 1/2" C.W./H.W.
- 6 1/2" C.W. DOWN TO ICE MAKER HOOK-UP VALVE BOX, GUY GRAY MODEL #BIM875. PROVIDE WITH 48" LONG 1/4" SPIRAL COPPER TUBING.
- 7 TP&R VALVE WITH FULL SIZE LINE TO TERMINATE OVER E.S.
- 8 WATER HEATER. SEE DETAIL 2/3.07.
- 9 3/4" C.W. DOWN IN WALL TO H.B. @ +24" A.F.F.
- 10 FIRE SPRINKLER STANDPIPE. SEE DETAIL 3/3.07.
- 11 2" DOMESTIC WATER SERVICE UP FROM BELOW GRADE TO S.O.V. AT +48" A.F.F.
- 12 6" FIRE SPRINKLER SERVICE ENTRANCE, RISER, & FIRE DEPT. CONN.
- 13 ELECTRICAL GEAR. (REF.) COORDINATE WORK TO PERMIT INSTALLATION OF PIPING WHILE MAINTAINING CLEARANCES REQUIRED BY THE NATIONAL ELECTRICAL CODE.
- 14 SEE P1.11 FOR GAS METER & PIPING.
- 15 2" V. UP FROM BELOW SLAB.
- 16 PROVIDE 3/8" STOP VALVE @ +48" A.F.F. FOR FUTURE ICE MACHINE.
- 17 1/2" DOWN TO S.O.V. & I.P.-2 @ +24" A.F.F. PROVIDE A.D. 1/2" CONNECTION TO E.S.
- 18 I.P.-3 WITH 1/2" CONN. TO F.D.
- 19 2" C.W. HEADER DOWN IN WALL TO SERVE EACH FIXTURE.
- 20 1/2" C.W. HEADER DOWN IN WALL TO SERVE EACH FIXTURE.
- 21 3/4" H.W. HEADER DOWN IN WALL TO SERVE EACH LAV.
- 22 1/2" C.W./H.W. DOWN.
- 23 2" W. DOWN, 1/2" V. UP, 1/2" C.W. DOWN.
- 24 3" W. DOWN, 2" V. UP, 1/2" C.W./H.W. DOWN.
- 25 2" W. DOWN W/ W.C.O., 1/2" V. UP, 1/2" C.W./H.W.
- 26 2" W. DOWN W/ W.C.O., 1/2" V. UP, 1/2" C.W./H.W.

APPROVAL OF THIS PLAN DOES NOT ALLOW THE DESIGN PROFESSIONAL NOR THE CONTRACTOR TO VIOLATE THE EQUIPMENT CLEARANCE REQUIREMENTS OF CHAPTER 3 OF THE U.M.C. AND/OR CHAPTER 5 OF THE U.P.C.

SEE ATTACHED DOCUMENTS AND REQUIREMENTS

PLANS APPROVED
PLUMBING MECHANICAL
JCF JAN 31 2003

ALL PLUMBING FIXTURES MUST COMPLY WITH THE REQUIREMENTS OF WATER CONSERVATION CHAPTER 4 OF U.P.C. ADOPTING ORDINANCE

Refer To The U.P.C. Section 408 For Installation of Pressure Relief Valves & Regulators

PROVIDE BACKFLOW PREVENTION DEVICE FOR ALL HOSE BIBBS AND LAWN HYDRANTS AS PER U.P.C. SEC. 608

iba CONSULTING ENGINEERS
3075 WEST TOWN
LAS VEGAS, NEVADA 89102
(702) 362-1000
3075 WEST TOWN
SUITE 100
LAS VEGAS, NEVADA 89102
(702) 362-1000



CITY OF LAS VEGAS WEST SERVICE YARD
BUFFALO DRIVE AND PEAK ROAD
LAS VEGAS, NEVADA
PARTIAL FLOOR PLANS
FIELD OPERATIONS BUILDING

OWNER: CITY OF LAS VEGAS
DEPARTMENT OF PUBLIC WORKS
ARCHITECTURAL SERVICES

400 EAST STEWART AVENUE
LAS VEGAS, NEVADA 89101
PHONE: (702) 229-5533
FAX: (702) 362-5232
TDD: (702) 366-2108

PROJECT	DD
FILE	6431P211.DWG
DATE	06.26.02
SCALE	1/4" = 1'-0"
BID NO.	02.15341.09
REVISED	107-V3548

P2.11