




AUG. 30, 2002

CONSULTANT

CITY OF LAS VEGAS
DEPARTMENT OF PUBLIC WORKS
ARCHITECTURAL SERVICES

CITY OF LAS VEGAS WEST SERVICE YARD
BUFFALO DRIVE AND PEAK ROAD
LAS VEGAS, NEVADA
FLOOR PLAN - LIGHTING
FIELD OPERATIONS BUILDING

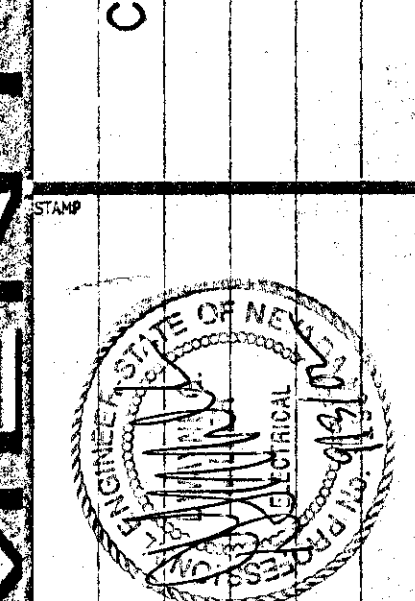

OWNER: CITY OF LAS VEGAS
DEPARTMENT OF PUBLIC WORKS
ARCHITECTURAL SERVICES


400 EAST STEWART AVENUE
LAS VEGAS, NEVADA 89101
PHONE: (702) 229-5535
FAX: (702) 582-5232
TDD: (702) 586-9109

DRAWN: TES
FILE: 6431E111.DWG
DATE: 03.15.02
SCALE: 1/8" = 1'-0"
SHEET NO: 02.15341.09
DIVISION NO: 107-V3548

E1.11

NOTES

- 1 FURNISH WITH 1200 LUMEN EMERGENCY BATTERY PACK, WIRED FOR SWITCHED OPERATION.
- 2 FIXTURE WITH (1) LAMP UNSWITCHED FOR NIGHT LIGHTING.
- 3 PROVIDE DEAD FRONT GFI TO PROTECT SHOWER FIXTURES.
- 4 SEE 2/EG1.02 FOR REQUIREMENTS.
- 5 ROUTE VIA RELAY 'R-1'.
- 6 #10 THRU-OUT CIRCUIT.
- 7 PROVIDE SLAVE PACK FOR TWO CIRCUIT CONTROL.

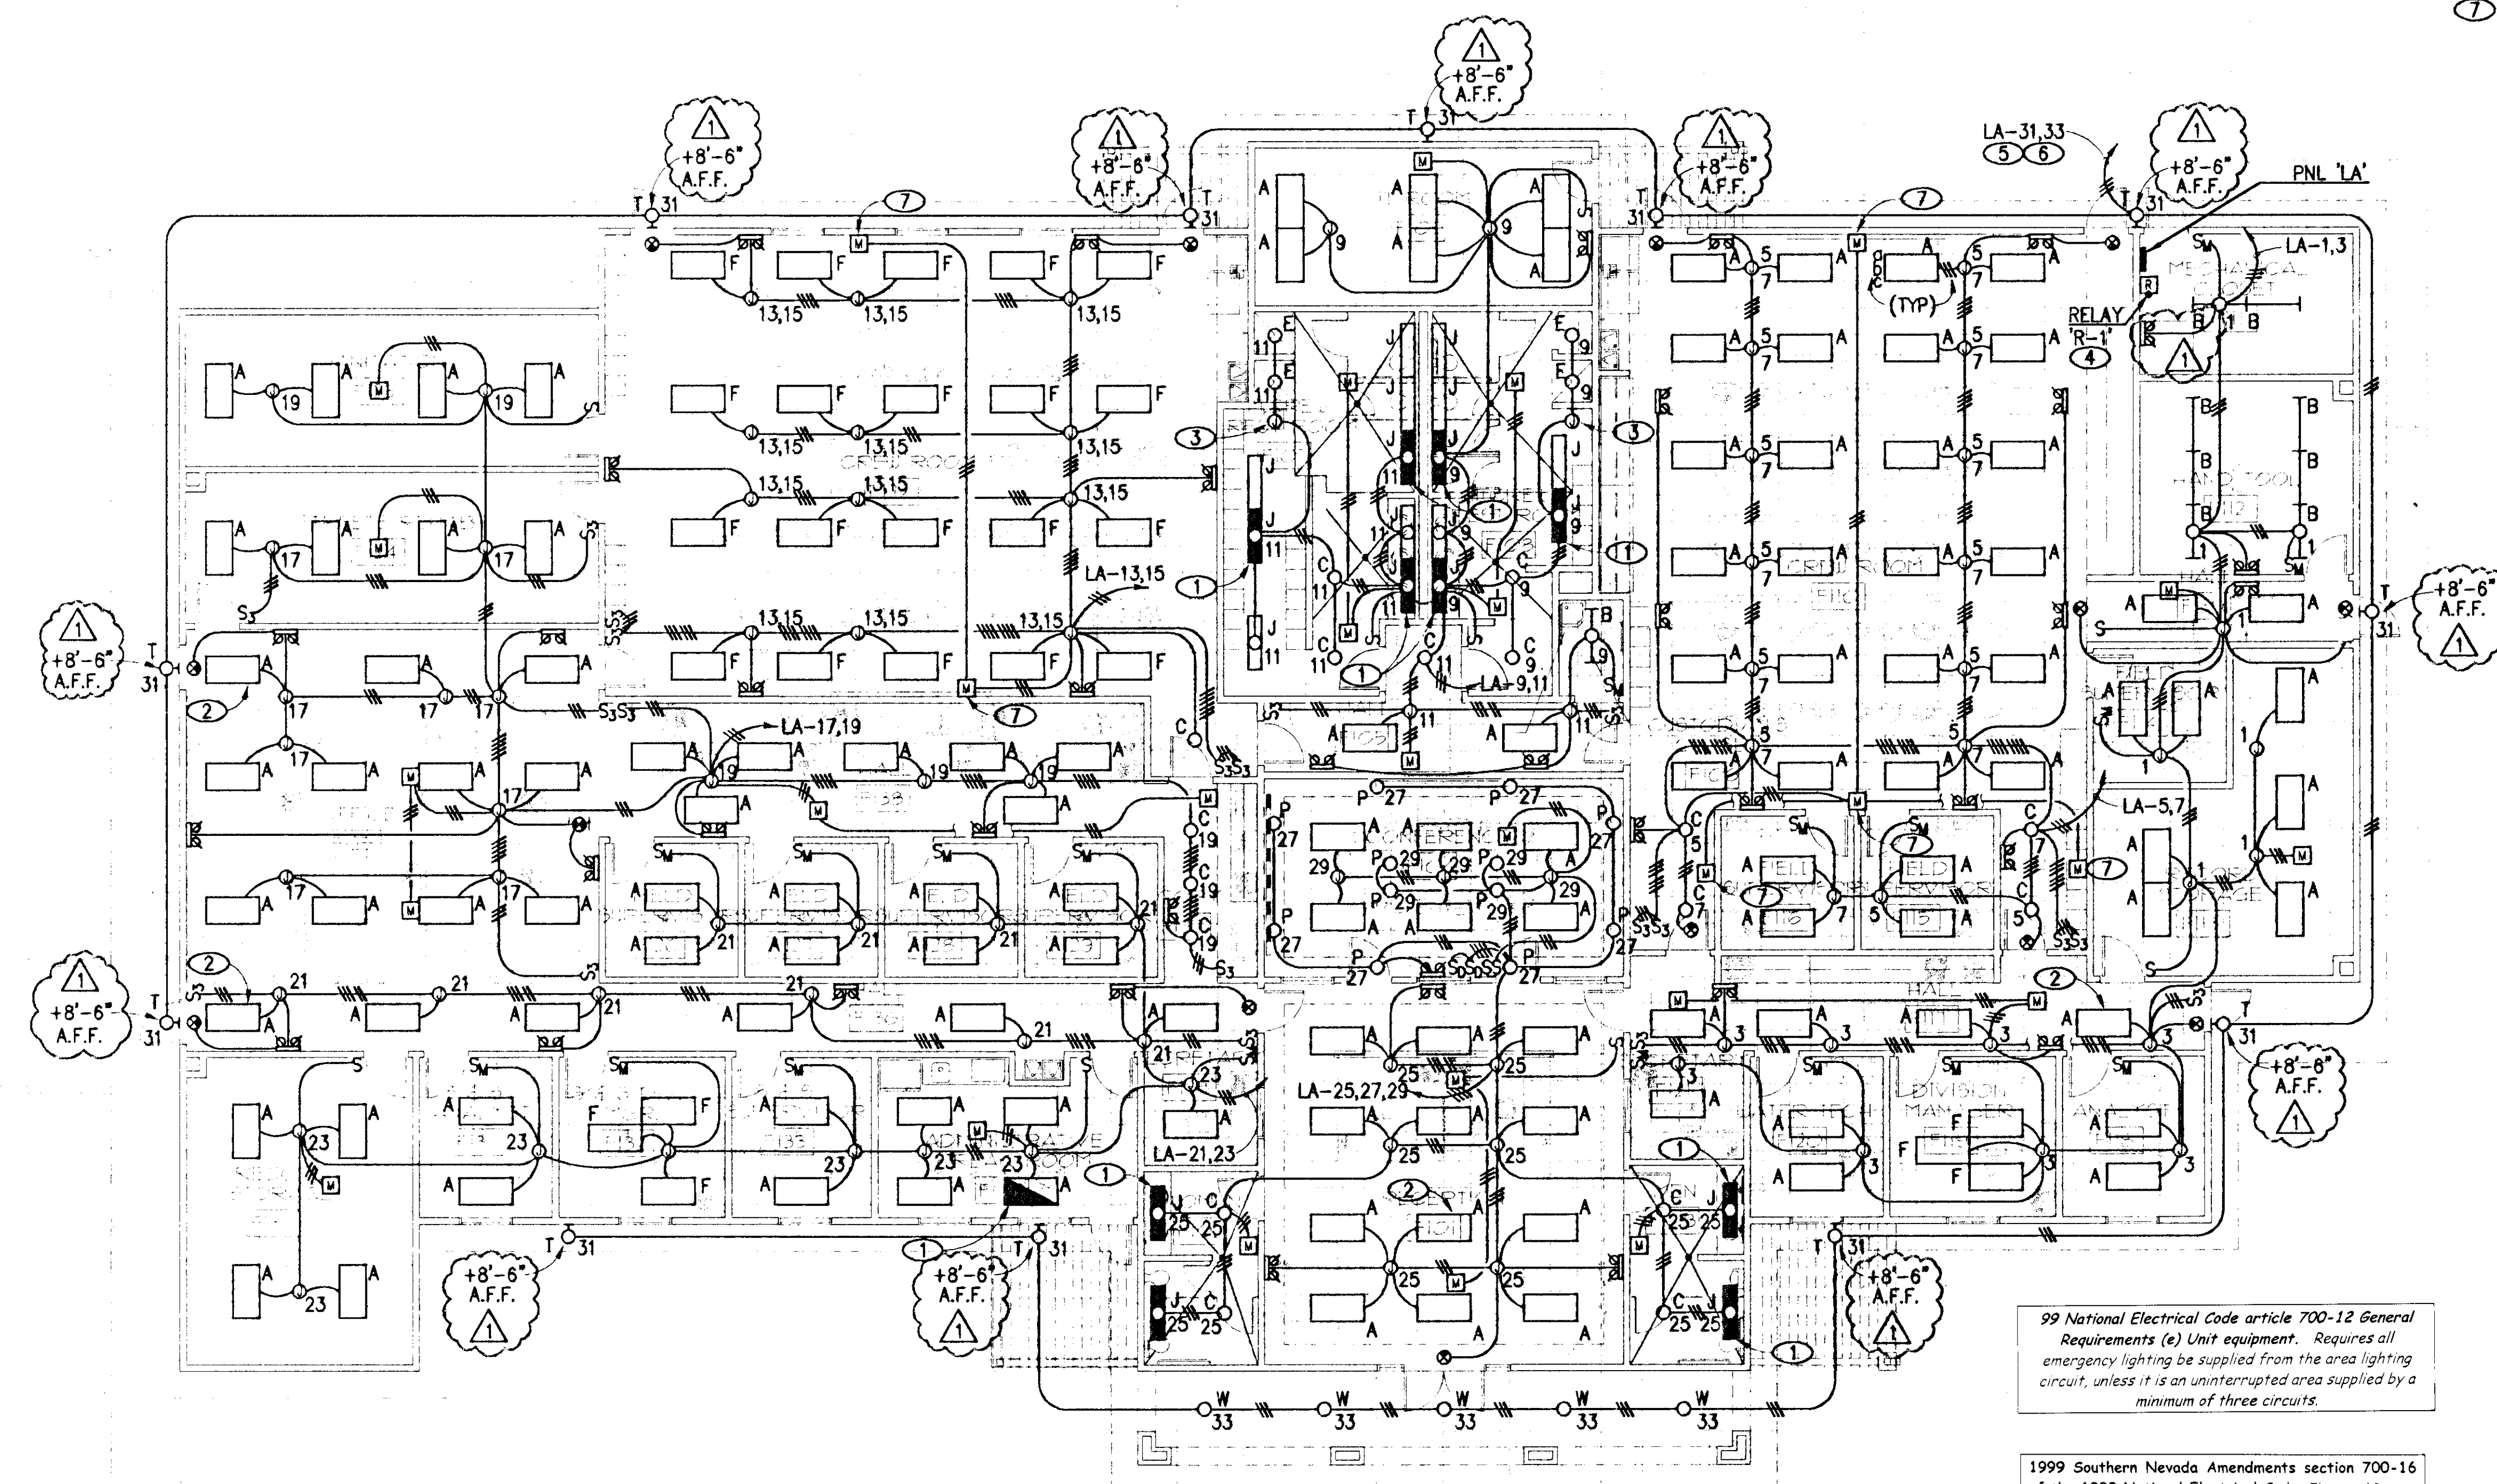



99 National Electrical Code article 700-12 General Requirements (e) Unit equipment. Requires all emergency lighting be supplied from the area lighting circuit, unless it is an uninterrupted area supplied by a minimum of three circuits.

1999 Southern Nevada Amendments section 700-16 of the 1999 National Electrical Code: Electrical Rooms, Fire Control Rooms, Fire Pump Rooms, PBX Rooms, Generator Rooms and Accessible Restrooms shall require emergency illumination.

FLOOR PLAN - LIGHTING

SCALE 1/8" = 1'-0"

1

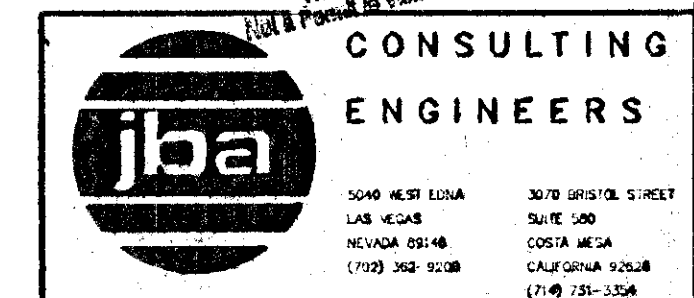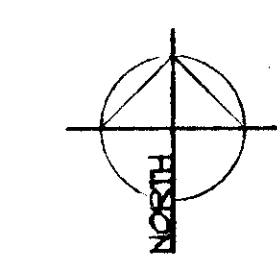

3040 WEST LINCOLN
LAS VEGAS, NEVADA 89109
3070 UNIVERSITY STREET
SUITE 300
COSTA MESA, CALIFORNIA 92626
(702) 586-9109
(714) 738-3324