



NOTES

- RELAY 'R-4', 20A, 8 POLE, NEMA 1 ENCLOSURE, 120V COIL.
- FURNISH WITH 1200 LUMEN EMERGENCY BATTERY PACK, WIRED FOR SWITCHED OPERATION.
- WIRING METHODS IN THIS ROOM SHALL COMPLY WITH NEC 502 FOR CLASS 2, DIVISION 2 LOCATIONS. PROVIDE BOXES, RACEWAYS, DEVICES, ETC. AS REQUIRED FOR COMPLIANCE.

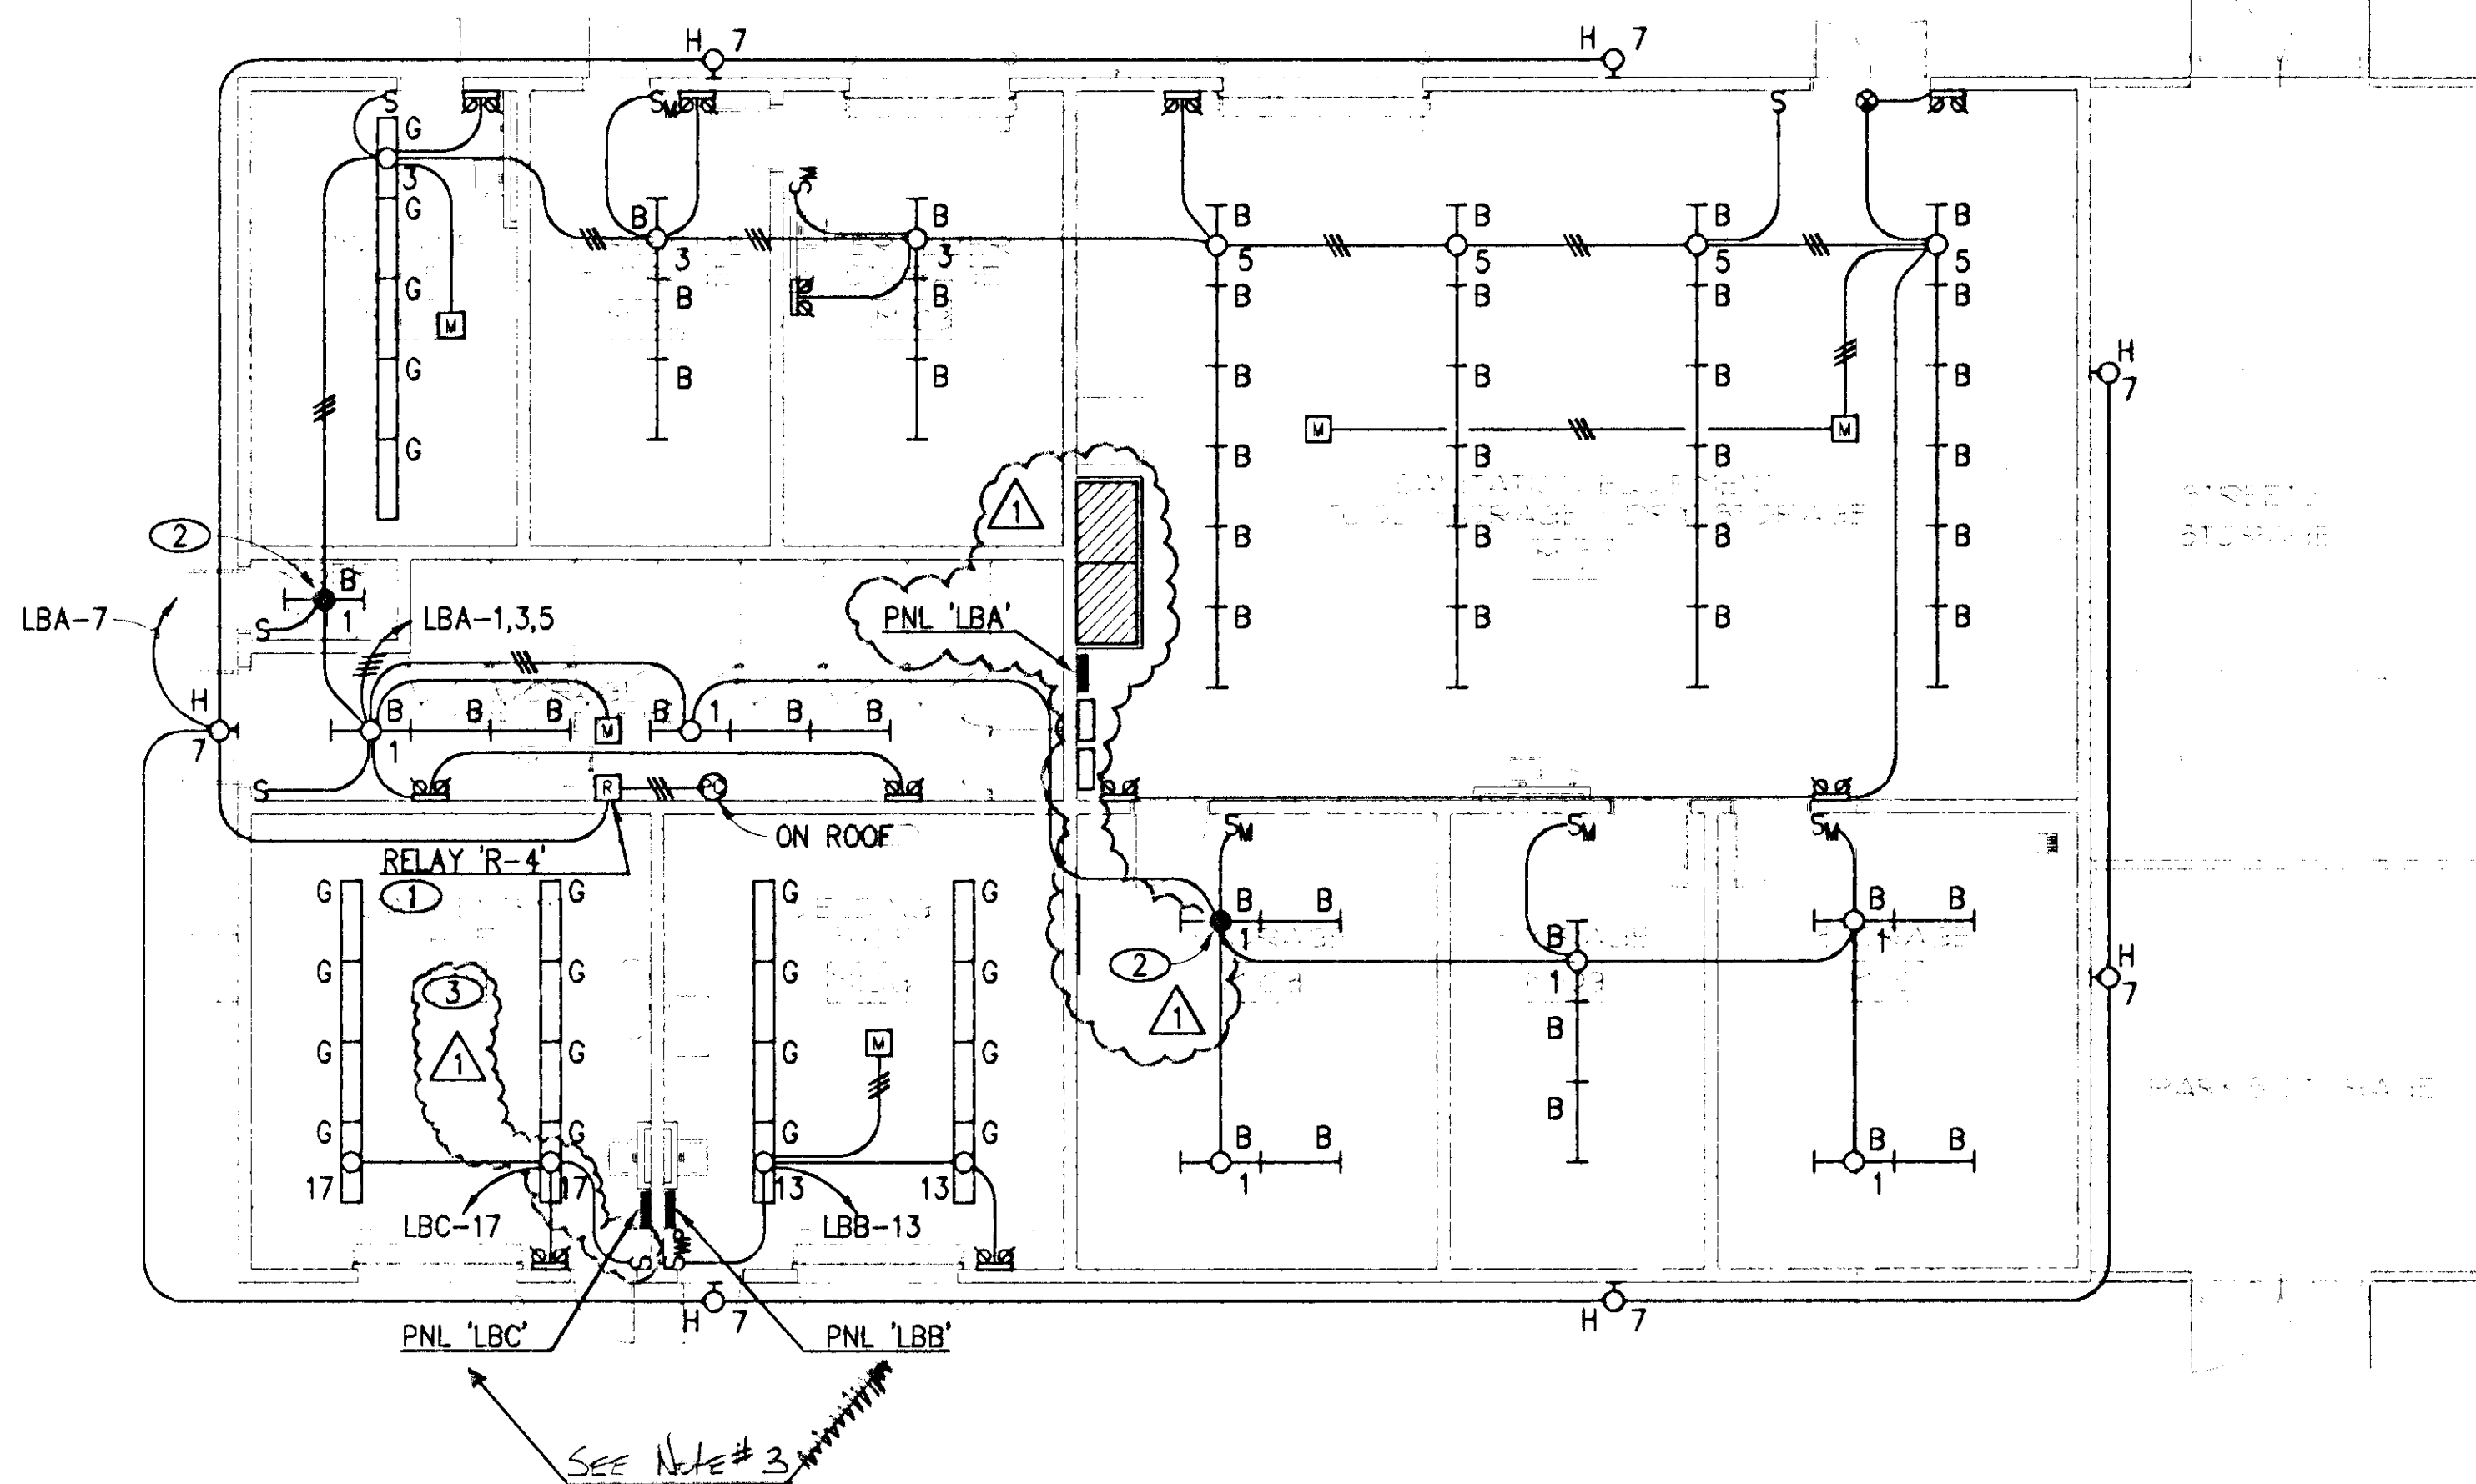


FLOOR PLAN - LIGHTING
SCALE 1/8" = 1'-0"

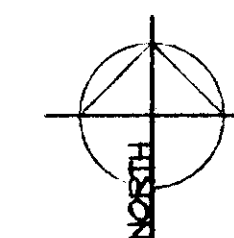

PLANS APPROVED
ELECTRICAL
SLACK & Bailey, Inc.
City of Las Vegas, Nevada
SEP 13 2002
RECEIVED
City of Las Vegas, Nevada
Building Dept.

CONSULTING ENGINEERS
jba
3040 WEST CONA
LAS VEGAS, NEVADA 89102
(702) 366-8500
(702) 366-8501
3010 WEST STREET
SUITE 200
LAS VEGAS, NEVADA 89102
(702) 366-8500
(702) 366-8501

CITY OF LAS VEGAS
DEPARTMENT OF PUBLIC WORKS
ARCHITECTURAL SERVICES
400 EAST STEWART AVENUE
LAS VEGAS, NEVADA 89101
(702) 229-6535
(702) 382-3232
(702) 386-2108

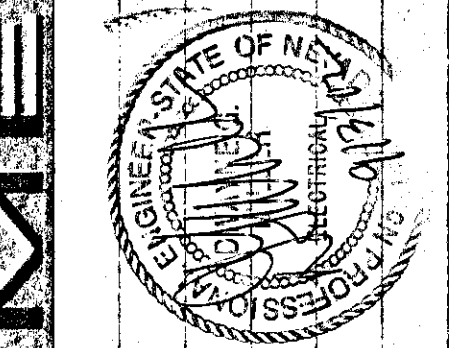

OWNER: CITY OF LAS VEGAS
DEPARTMENT OF PUBLIC WORKS
ARCHITECTURAL SERVICES

DRAWN	TES
FILE	6431E113.DWG
DATE	03.15.02
SCALE	1/8" = 1'-0"
REV NO	02.15341.09
CLW DWG NO	107-V3548

E1.13