


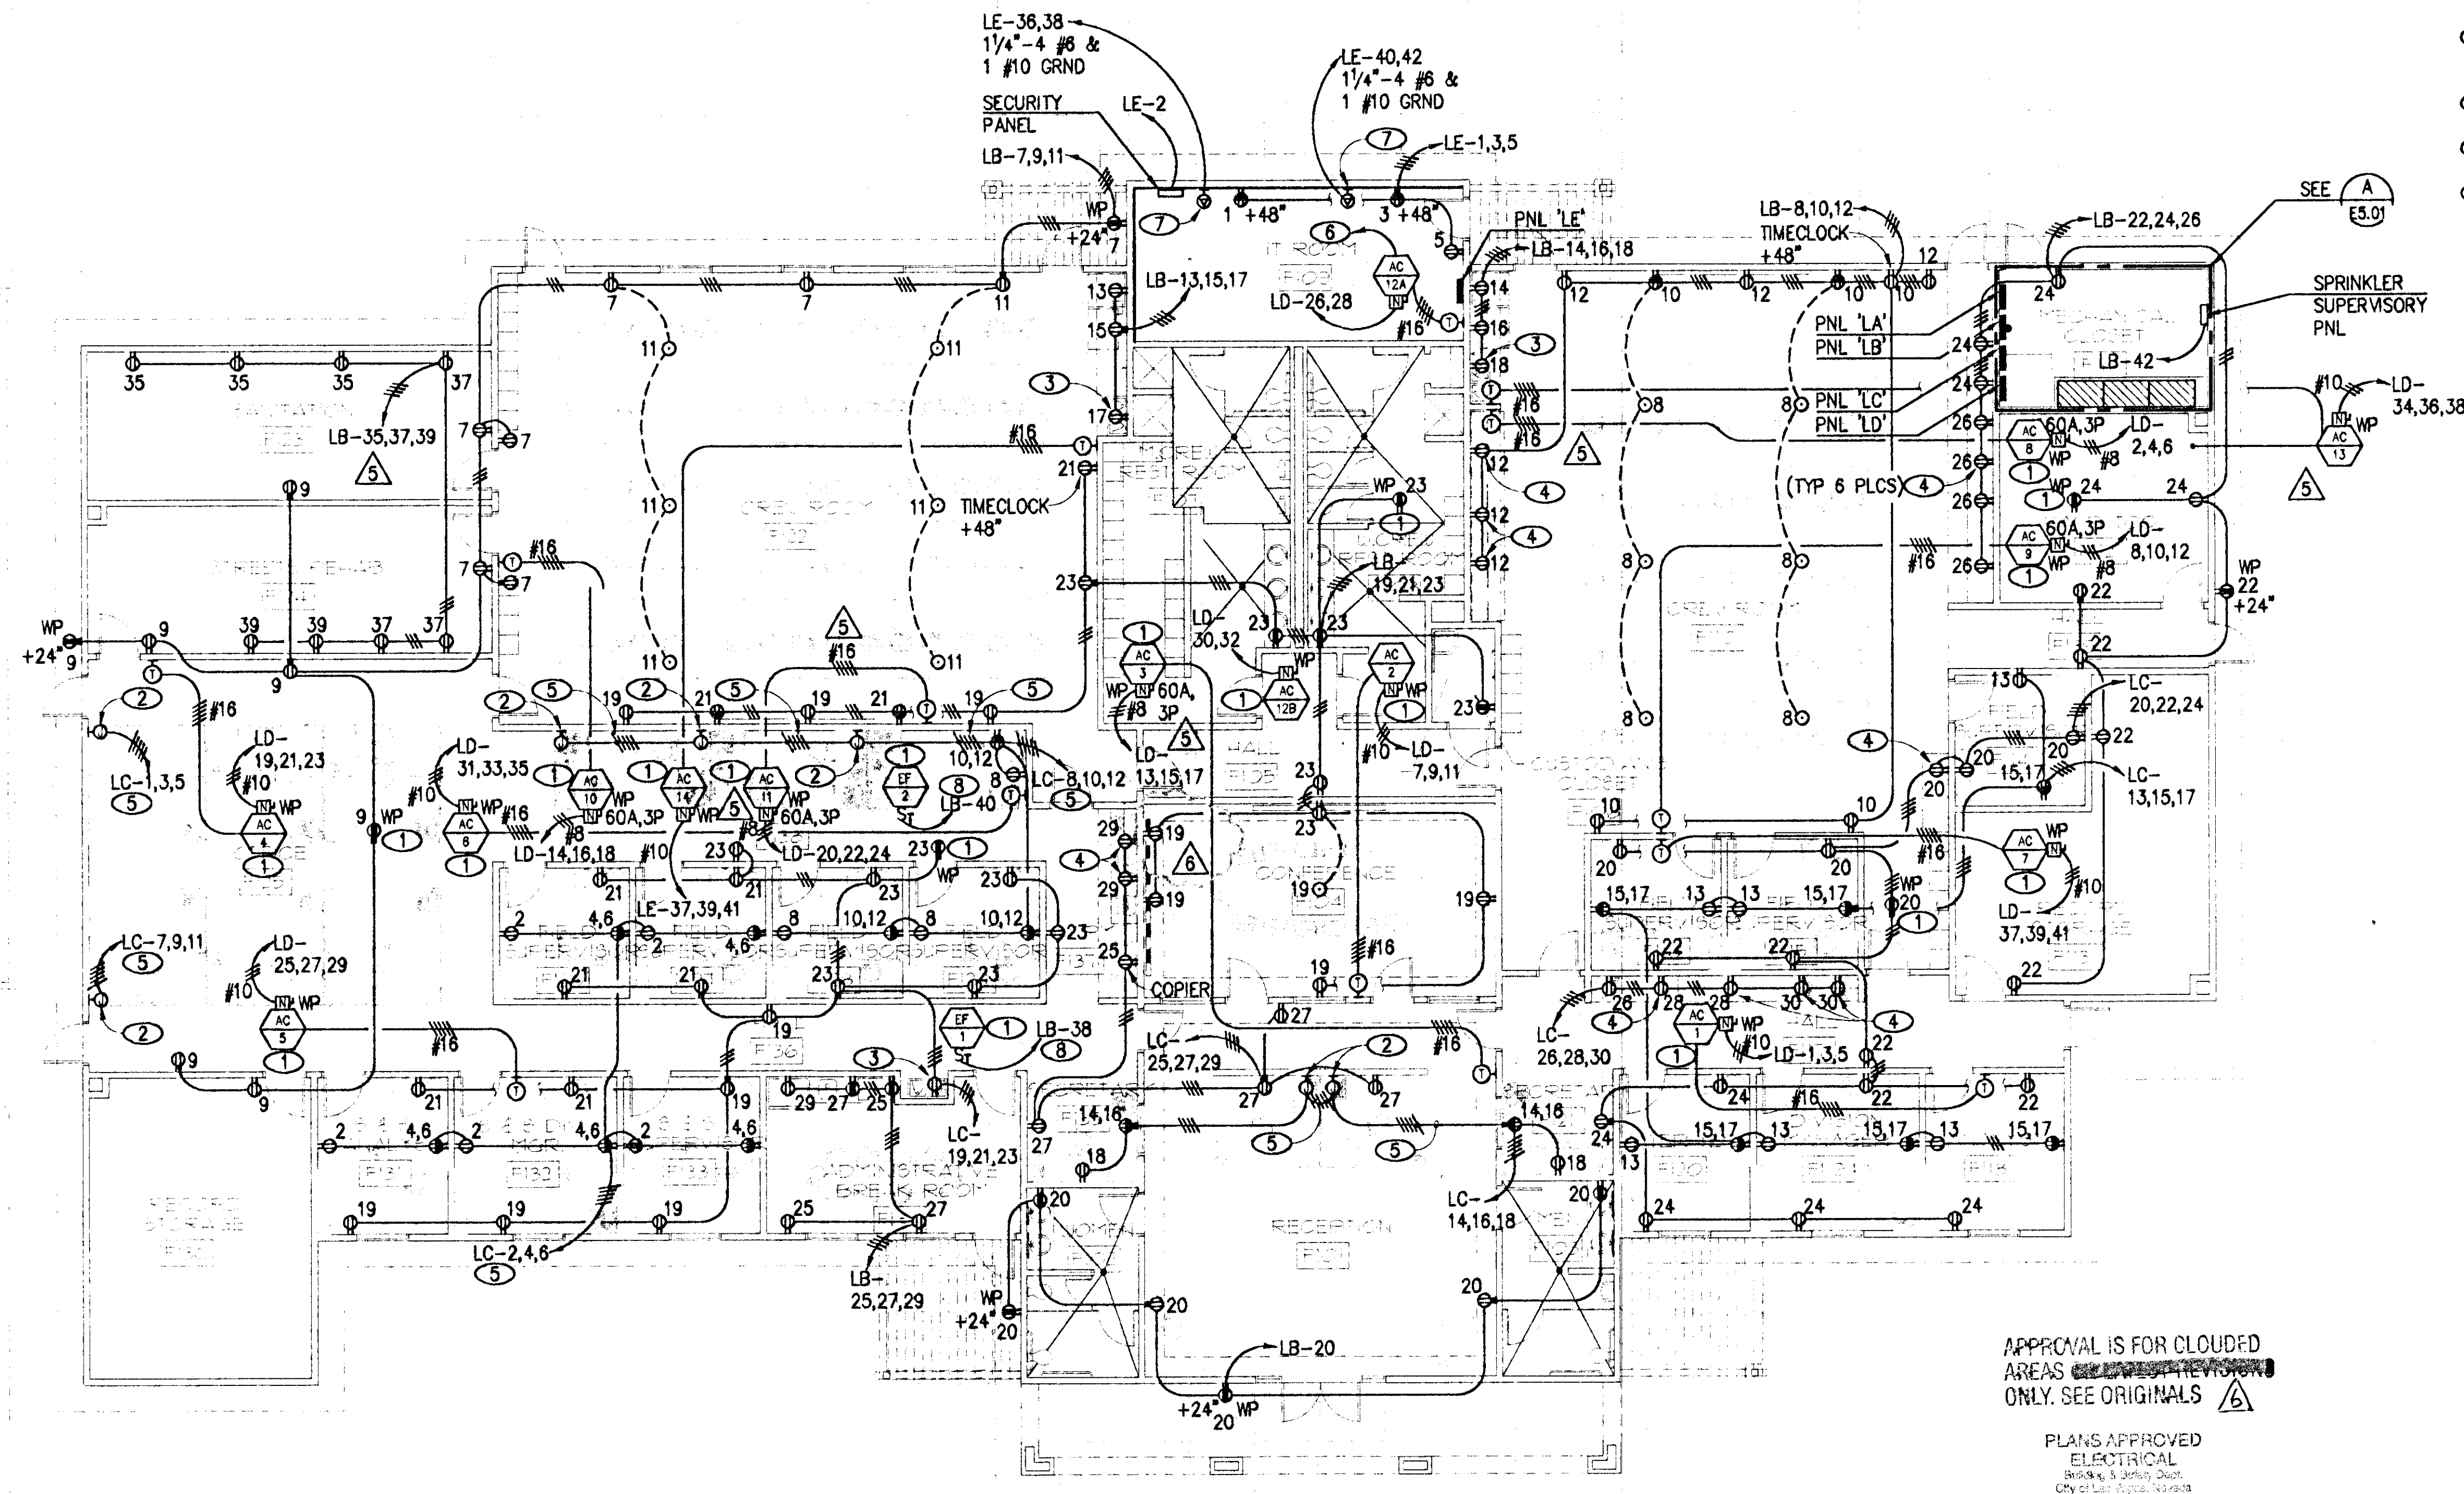

APPROVAL IS FOR CLOUDED
AREAS ONLY. SEE ORIGINALS

PLANS APPROVED
ELECTRICAL
Brocking, S. J. Smith, Esq.
City of Las Vegas, Nevada


SAZ MAY 06 2003

Does Not Include Structural, Architectural,
Mechanical, Electrical, or Civil
Improvements And No Change
Without Approval From SA
Not a Permit to Violate Any Ordinance

FLOOR PLAN - POWER

SCALE: 1/8" = 1'-0"

1

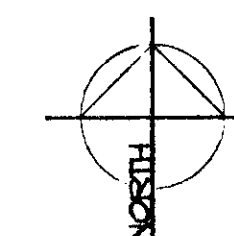

NOTES



- EQUIPMENT LOCATED ON ROOF.
- PROVIDE HARWIRE CONNECTION TO MODULAR FURNITURE. COORDINATE ROUGH-IN AND CONNECTION REQUIREMENTS WITH EQUIPMENT FURNISHED.
- RECEPTACLE FOR EWC. COORDINATE ROUGH-IN AND CONNECTION REQUIREMENTS WITH DIVISION 15. PROVIDE CORD AND PLUG SET.
- INSTALL 8" ABOVE COUNTERTOP.
- 3/4"-3 #12, 1 #10 N, 1 #12 GRND & 1 #12 ISO GRND.
- INTERLOCK WITH OUTDOOR UNIT.
- NEMA 14-50R, +24" AFF.
- ROUTE VIA TIME SWITCH IN MECHANICAL CLOSET F111.

588271

RECEIVED


APR 29 2003

CITY OF LAS VEGAS
PERMITS

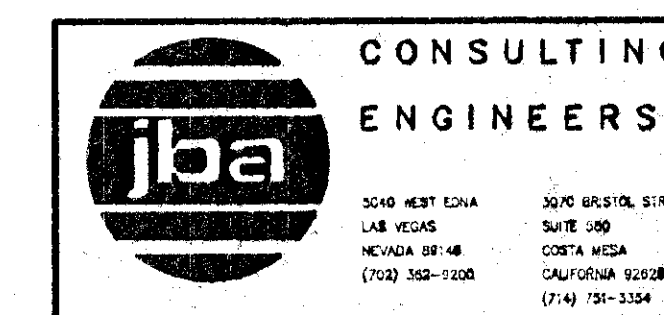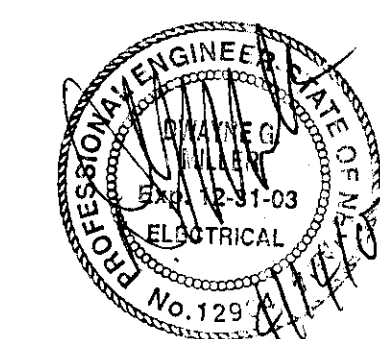

MAR. 14, 2003
OWNER REVISION

APR. 14, 2003
OWNER REVISION

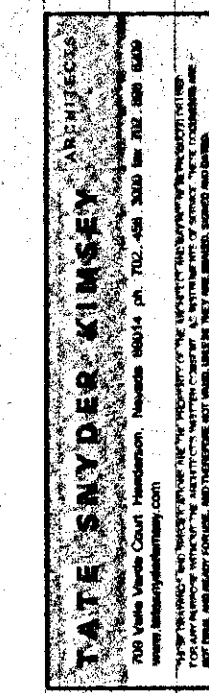

CITY OF LAS VEGAS WEST SERVICE YARD
BUFFALO DRIVE AND PEAK ROAD
LAS VEGAS, NEVADA
FLOOR PLAN - POWER
FIELD OPERATIONS BUILDING

OWNER: CITY OF LAS VEGAS
DEPARTMENT OF PUBLIC WORKS
ARCHITECTURAL SERVICES

400 EAST STEWART AVENUE
LAS VEGAS, NEVADA 89101
PHONE: (702) 229-8533
FAX: (702) 382-2232
TDD: (702) 386-9108

DATE	YES
FILE	6431211.DWG
DATE	10.16.02
SCALE	1/8" = 1'-0"
SUB NO	02-15341.09
CLY DWG NO	107-V3548

E2.11