


NOTICE

1. MINIMUM RACEWAY SIZE SHALL BE 3/4" C.

NOTES

- 1 EQUIPMENT LOCATED ON ROOF.
- 2 PROVIDE CONNECTION TO MODULAR FURNITURE WITH 1/4" LIQUID-TITE FLEXIBLE METAL CONDUIT.
- 3 1" FIRE RETARDANT PLYWOOD FROM FINISHED FLOOR TO 8'-0" A.F.F., LENGTH AS SHOWN.
- 4 INSTALL 8" ABOVE COUNTERTOP.
- 5 4" CONDUITS, SEE SITE PLAN FOR QUANTITY.
- 6 4" SQUARE REDUCE TO ONE GANG +48" FOR FUTURE SECURITY KEY PAD.
- 7 ROUGH-IN FOR SECURITY CARD READER, COORDINATE ROUGH-IN LOCATION AND HEIGHT WITH OWNER.
- 8 INSTALL IN S/A DUCT, CONNECT UNIT FOR FAN SHUT DOWN UPON ALARM OF ANY DUCT DETECTOR WITHIN THE BUILDING.
- 9 6"x6"x4"
- 10 COORDINATE ROUGH-IN LOCATION AND HEIGHT WITH EQUIPMENT FURNISHED.
- 11 LOCATE PER CITY OF LAS VEGAS FIRE DEPARTMENT.
- 12 PROVIDE DEVICE INDICATED INCLUDING ALL WIRING, DEVICE SHALL BE INSTALLED IN MODULAR FURNITURE.
- 13 ROUGH-IN FOR SECURITY DOOR SWITCHES, COORDINATE WITH OWNER'S SECURITY VENDOR.

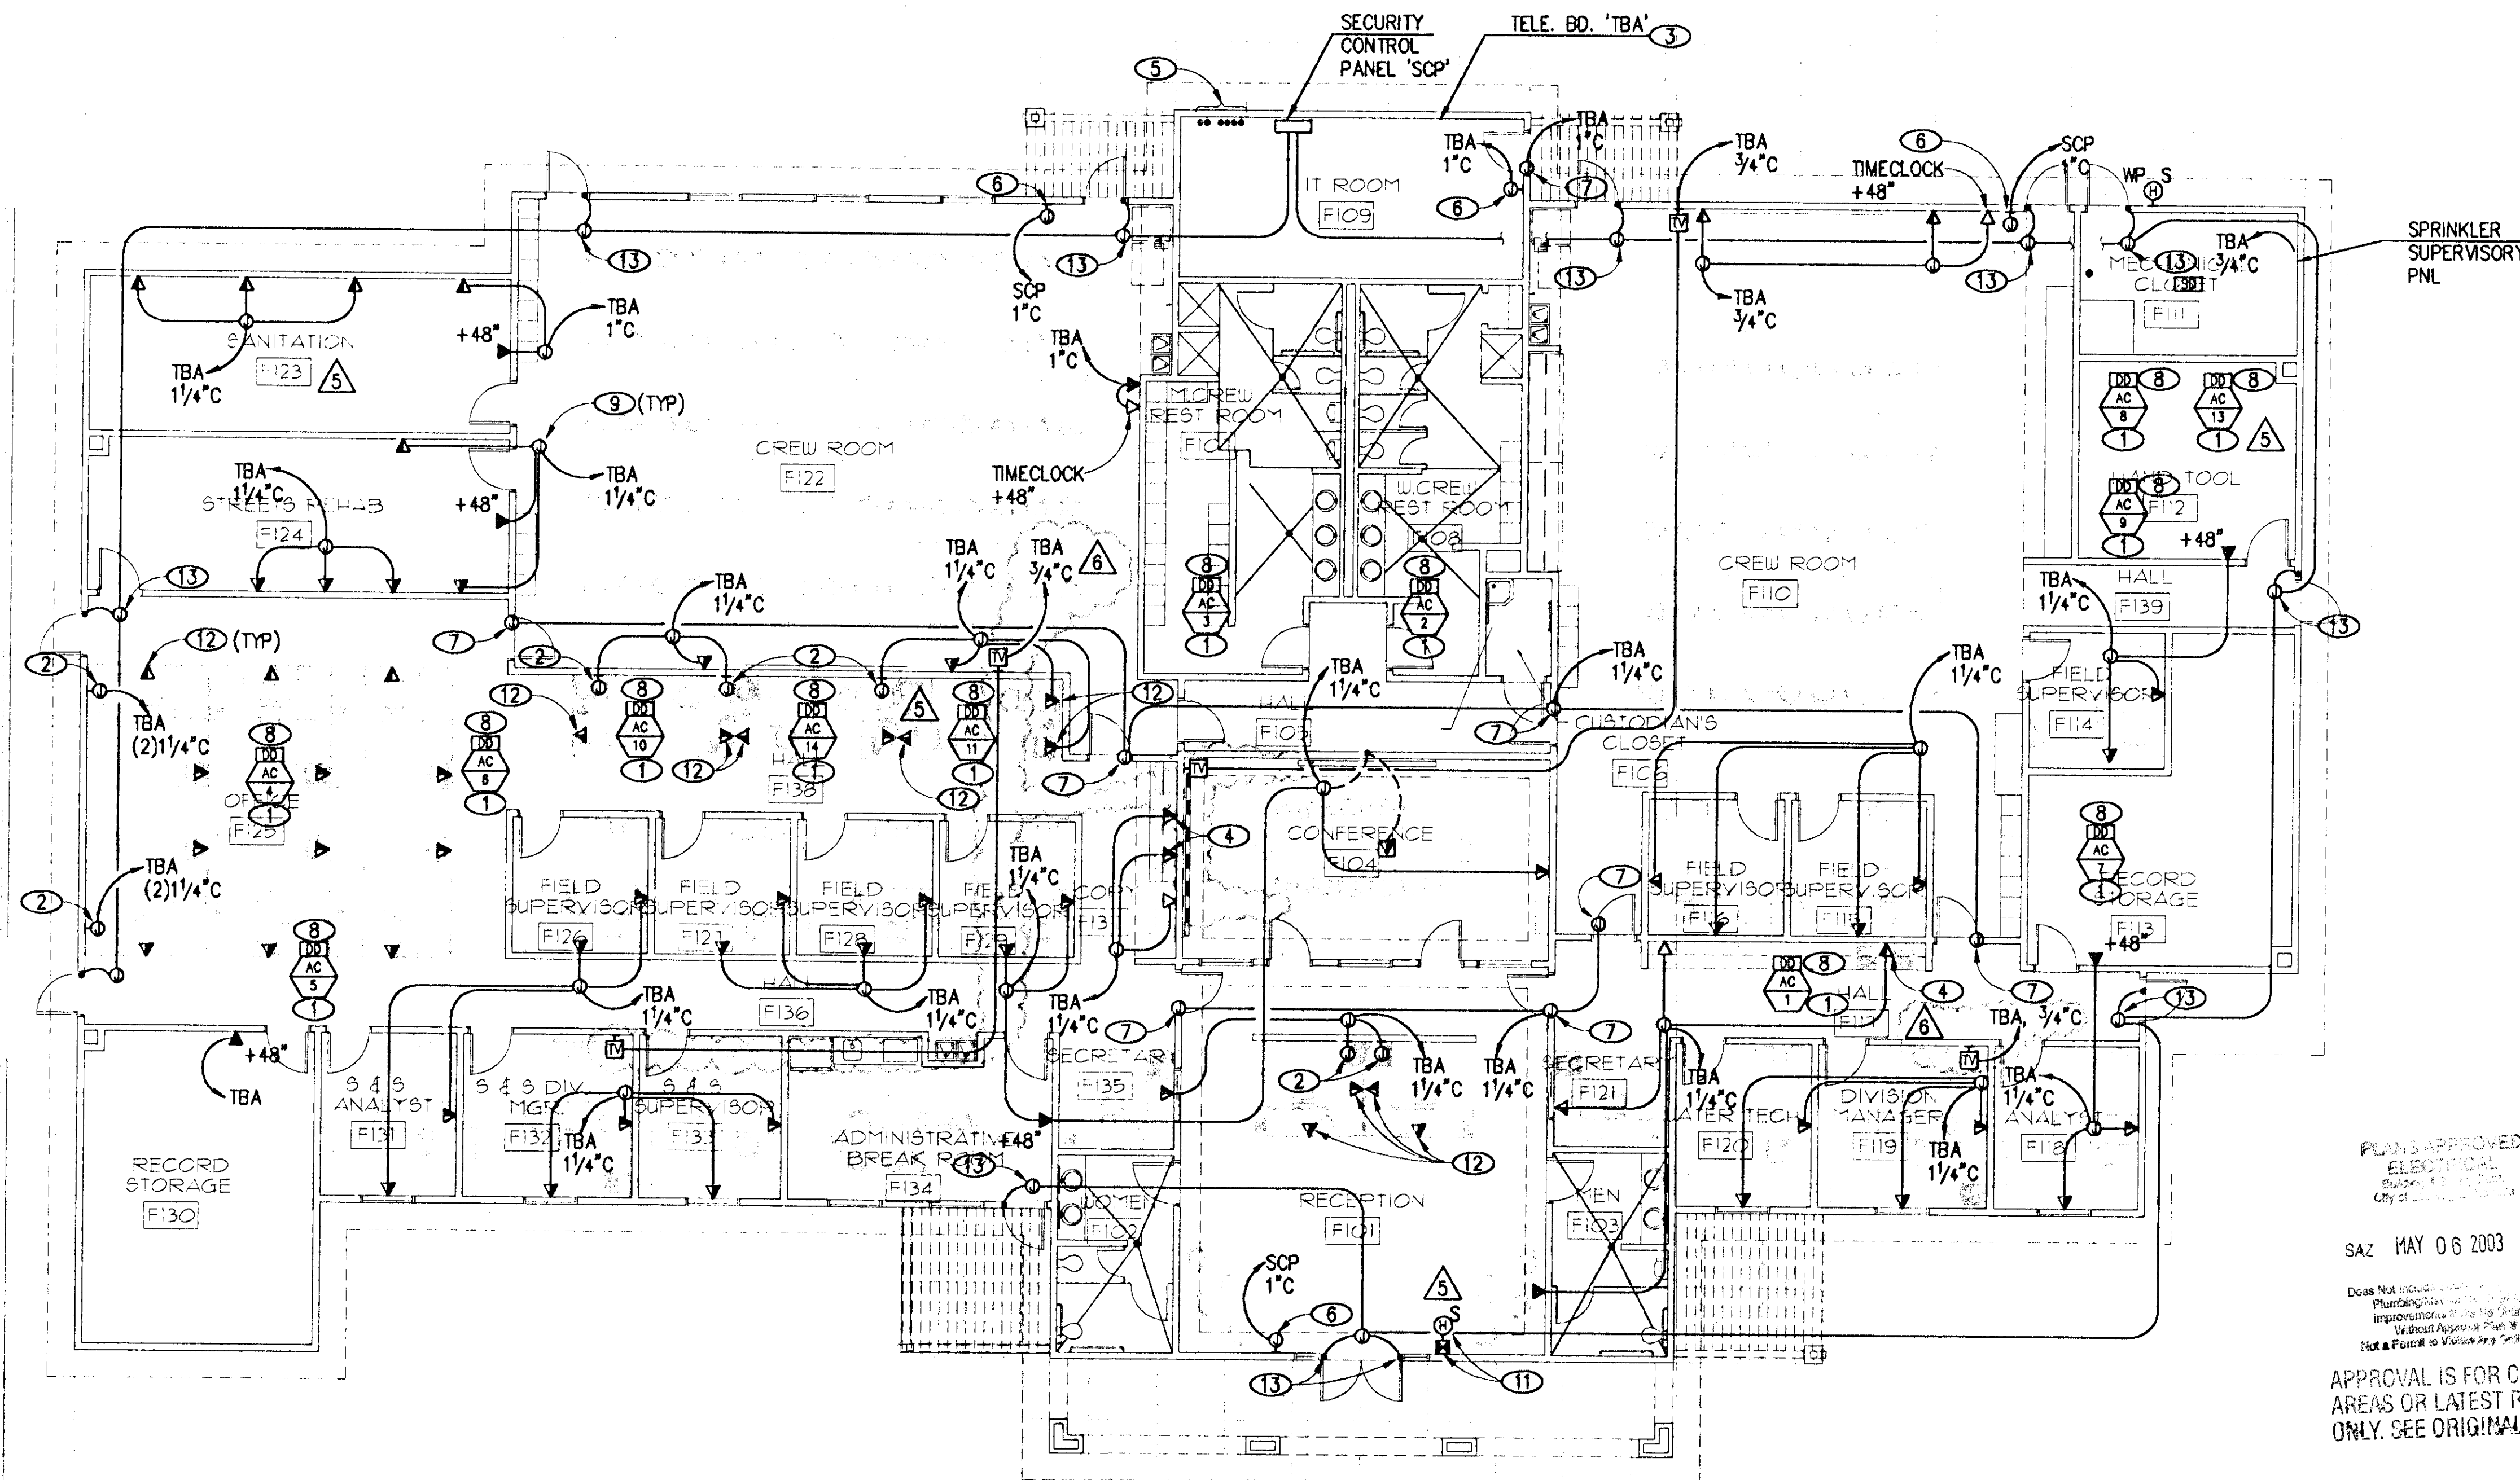

PLANS APPROVED
ELECTRICAL
City of Las Vegas

SAZ MAY 06 2003

Does Not Include a Certificate of Compliance
Plumbing, Mechanical, Electrical, Fire, and
Hazardous Waste Engineering Services
Without Approval of the City of Las Vegas
Department of Public Works


APPROVAL IS FOR CLOUDED
AREAS OR LATEST REVISIONS
ONLY. SEE ORIGINALS

588271

RECEIVED

APR 29 2003



CITY OF LAS VEGAS
PERMITS

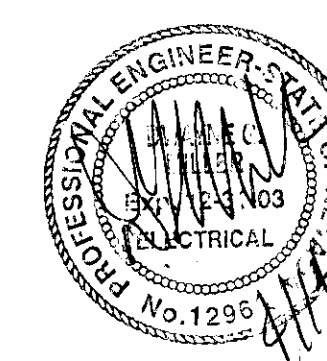

FLOOR PLAN - AUXILIARY

SCALE: 1/8" = 1'-0"

1

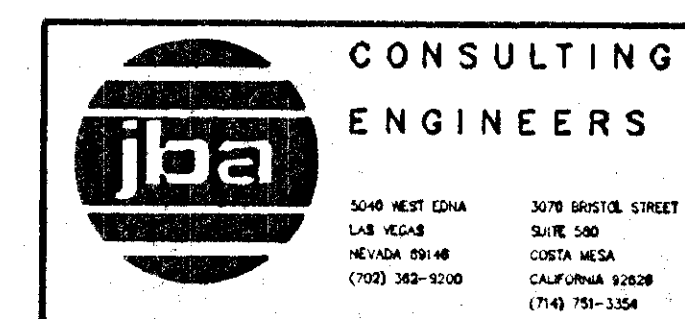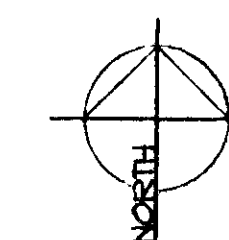

CITY OF LAS VEGAS WEST SERVICE YARD
BUFFALO DRIVE AND PEAK ROAD
LAS VEGAS, NEVADA
FLOOR PLAN - AUXILIARY
FIELD OPERATIONS BUILDING

OWNER: CITY OF LAS VEGAS
DEPARTMENT OF PUBLIC WORKS
ARCHITECTURAL SERVICES

400 EAST STEWART AVENUE
LAS VEGAS, NEVADA 89101
PHONE: (702) 228-6535
FAX: (702) 382-3232
TDD: (702) 386-9108

DATE	10.16.02
SCALE	1/8" = 1'-0"
SHEET NO.	02.15341.09
REVISED	107-V3548

E3.11