



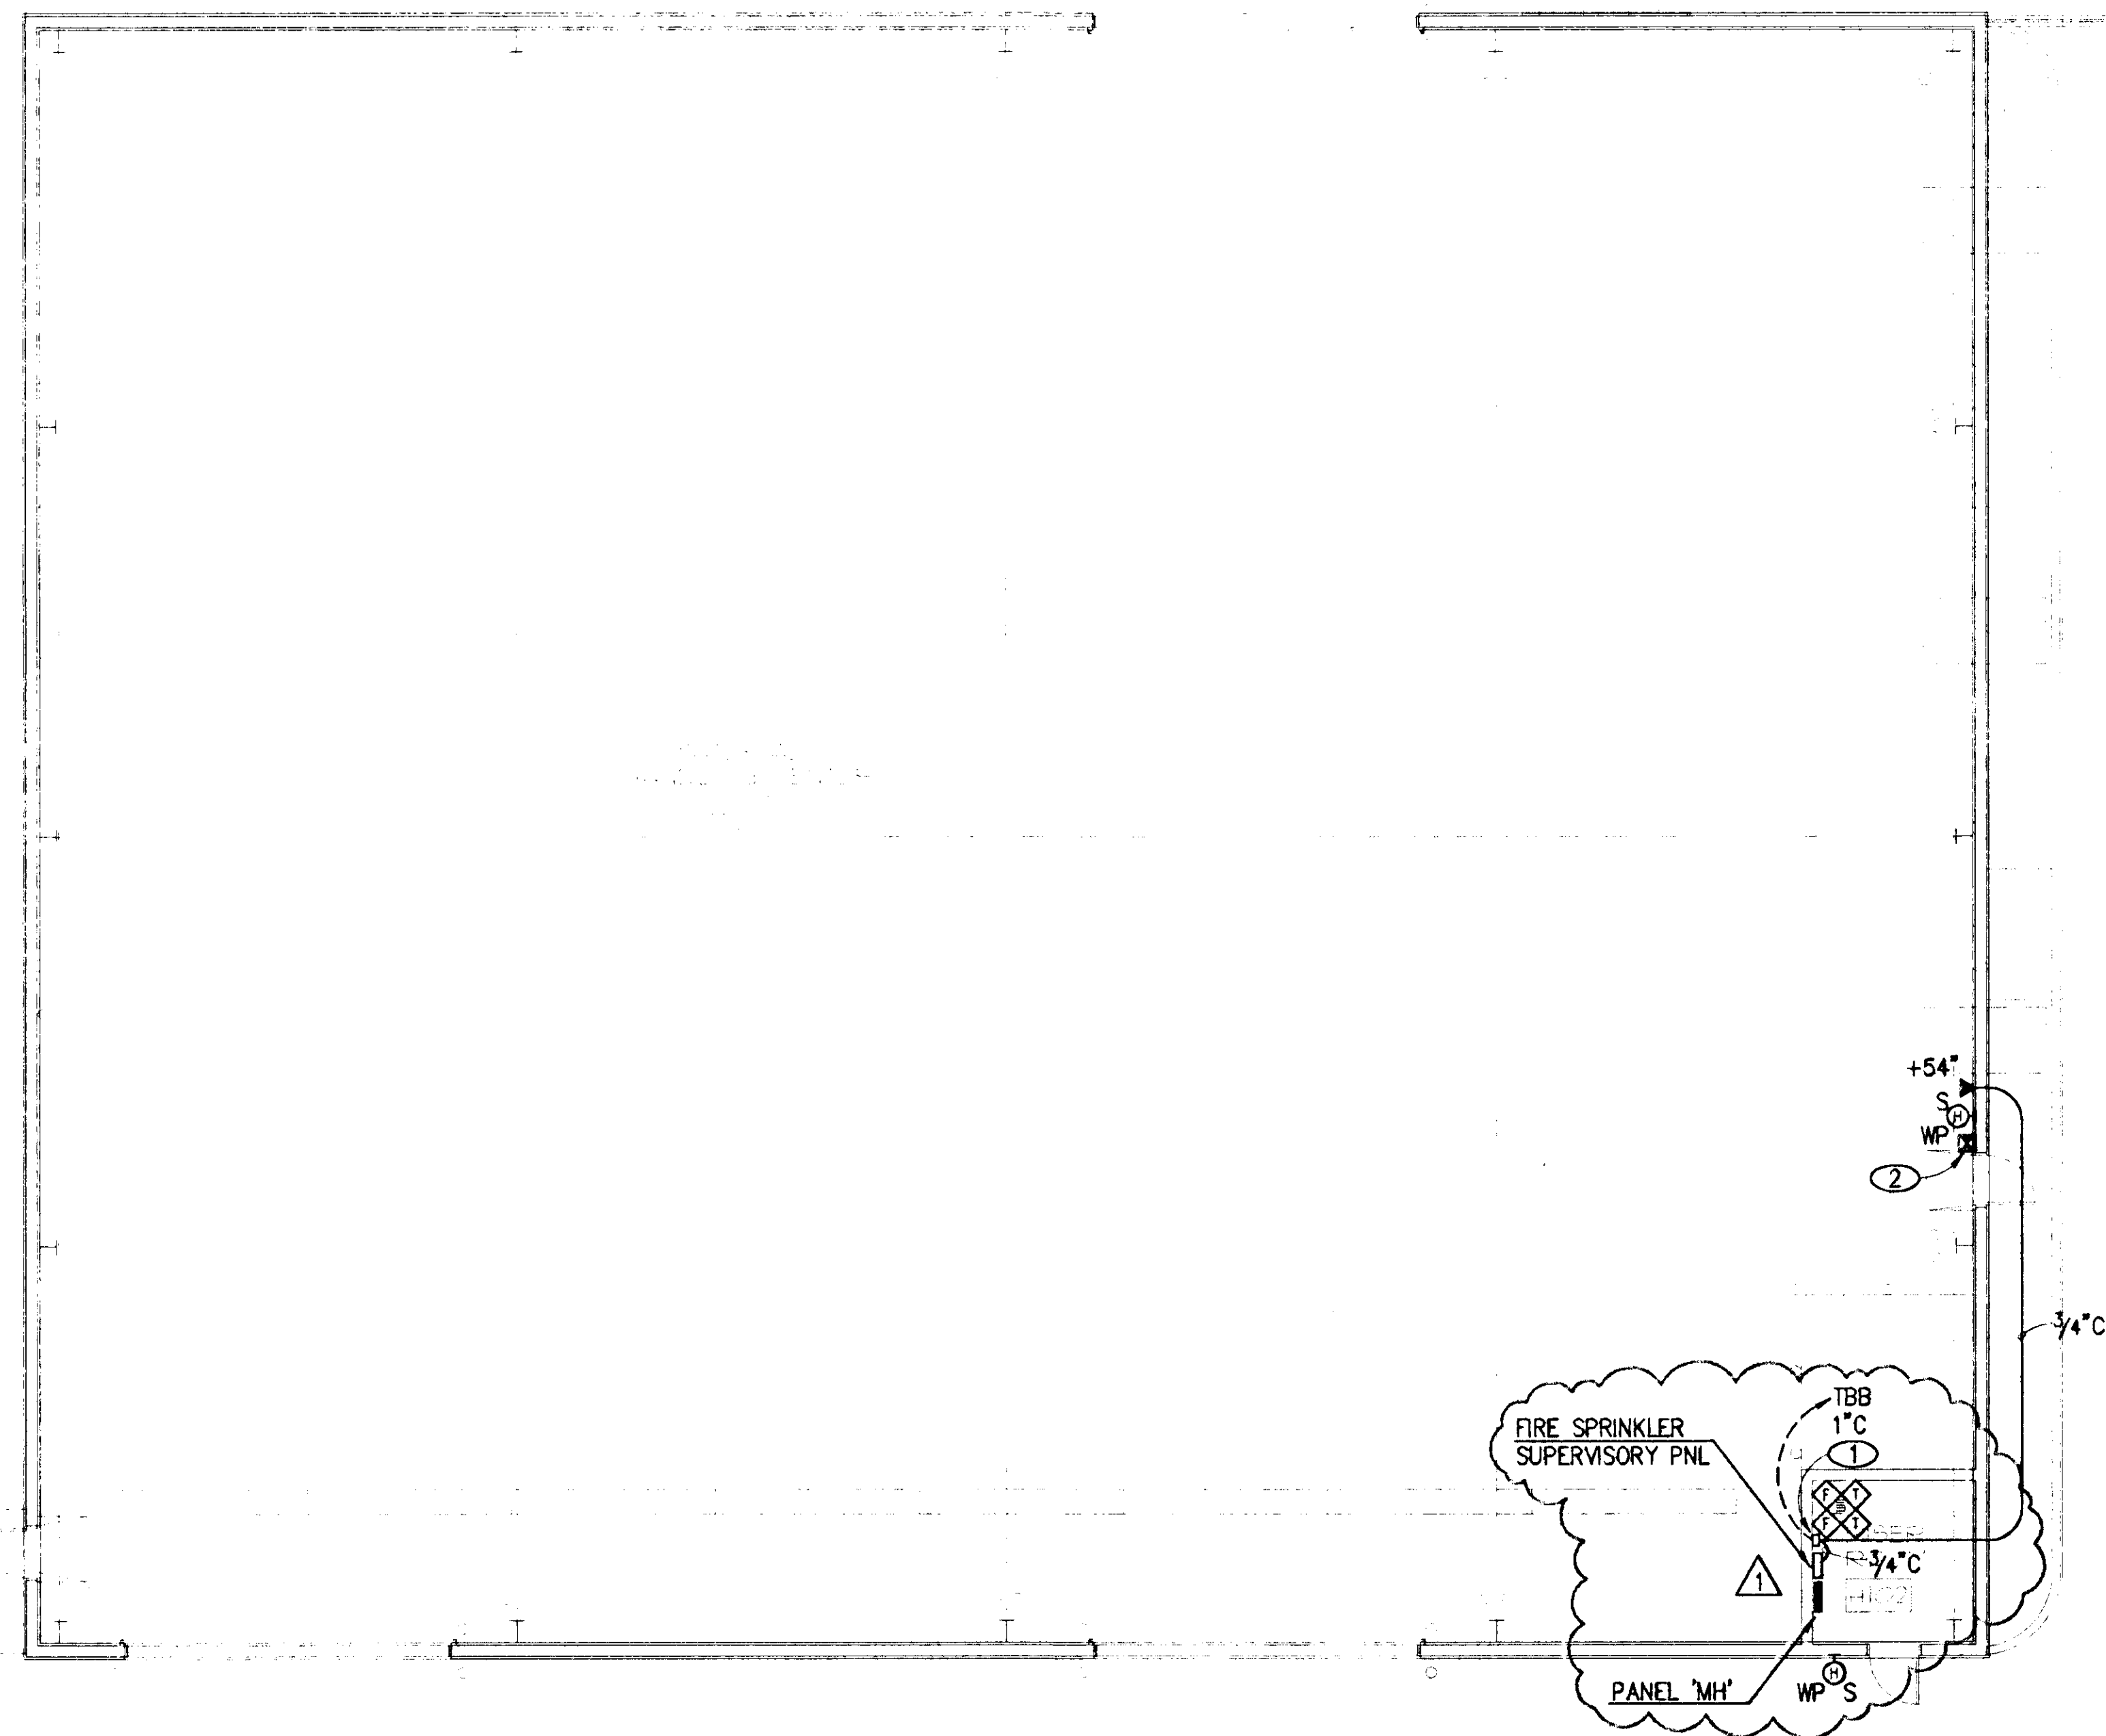

PLANS FOR FIRE HYDRANTS, FIRE EXTINGUISHING SYSTEMS, FIRE ALARM SYSTEMS, MEDICAL GAS SYSTEMS, ON-SITE FIRE WATER, AND FUEL TANKS MUST BE APPROVED BY FIRE DEPARTMENT BEFORE INSTALLATION.

Separate permit required

FLOOR PLAN - AUXILIARY
 SCALE: 1/8" = 1'-0" 1

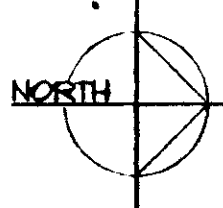

NOTES


- ① 8"x8"x4"
- ② LOCATE AS DIRECTED BY CITY OF LAS VEGAS FIRE DEPARTMENT.



AUG. 30, 2002



CITY OF LAS VEGAS WEST SERVICE YARD
 BUFFALO DRIVE AND PEAK ROAD
 LAS VEGAS, NEVADA
 FLOOR PLAN - AUXILIARY
 MATERIALS HANDLING BUILDING

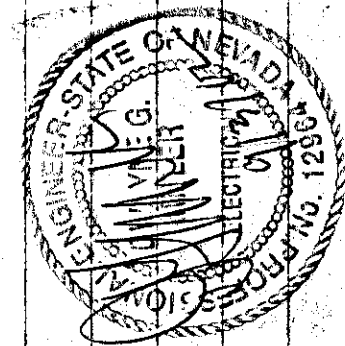


OWNER: CITY OF LAS VEGAS
 DEPARTMENT OF PUBLIC WORKS
 ARCHITECTURAL SERVICES

400 EAST STEWART AVENUE
 LAS VEGAS, NEVADA 89101
 PHONE: (702) 228-8538
 FAX: (702) 382-2232
 TDD: (702) 386-9108

LOW VOLTAGE WIRING
 SHALL BE IN CONDUIT

PLANS APPROVED
 ELECTRICAL
 SEP 13 2002

Do Not Include Structural, Architectural, Plumbing, Mechanical or Civil Work
 Not to Scale

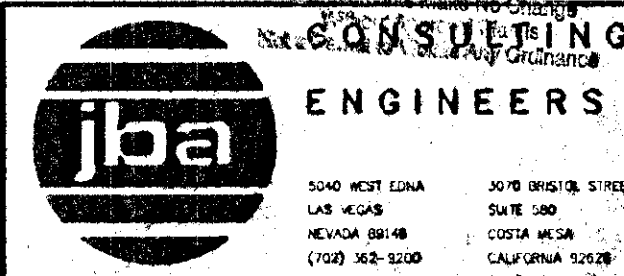

DRAWN	YES
FILE	64316312.DWG
DATE	03.15.02
SCALE	1/8" = 1'-0"
REV NO	02.15.04.1.09
REV NO	107-V3548
REV NO	E3.12