


NOTES



- 4"x4"x3/4" FIRE RETARDANT PLYWOOD. PROVIDE 1/2"-1 #6 TO NEAREST GROUNDING ELECTRODE.
- 4" SQUARE REDUCED TO ONE GANG +48" A.F.F. FOR SECURITY KEY PAD.
- LOCATE AS DIRECTED BY CITY OF LAS VEGAS FIRE DEPARTMENT,
- TO SECURITY PANEL.
- ROUGH-IN FOR SECURITY DOOR SWITCHES, COORDINATE WITH OWNER'S SECURITY VENDOR.
- WIRING METHODS IN THIS ROOM SHALL COMPLY WITH NEC 502 FOR CLASS 2, DIVISION 2 LOCATIONS. PROVIDE RACEWAYS, BOXES, DEVICES, ETC. AS REQUIRED FOR COMPLIANCE.

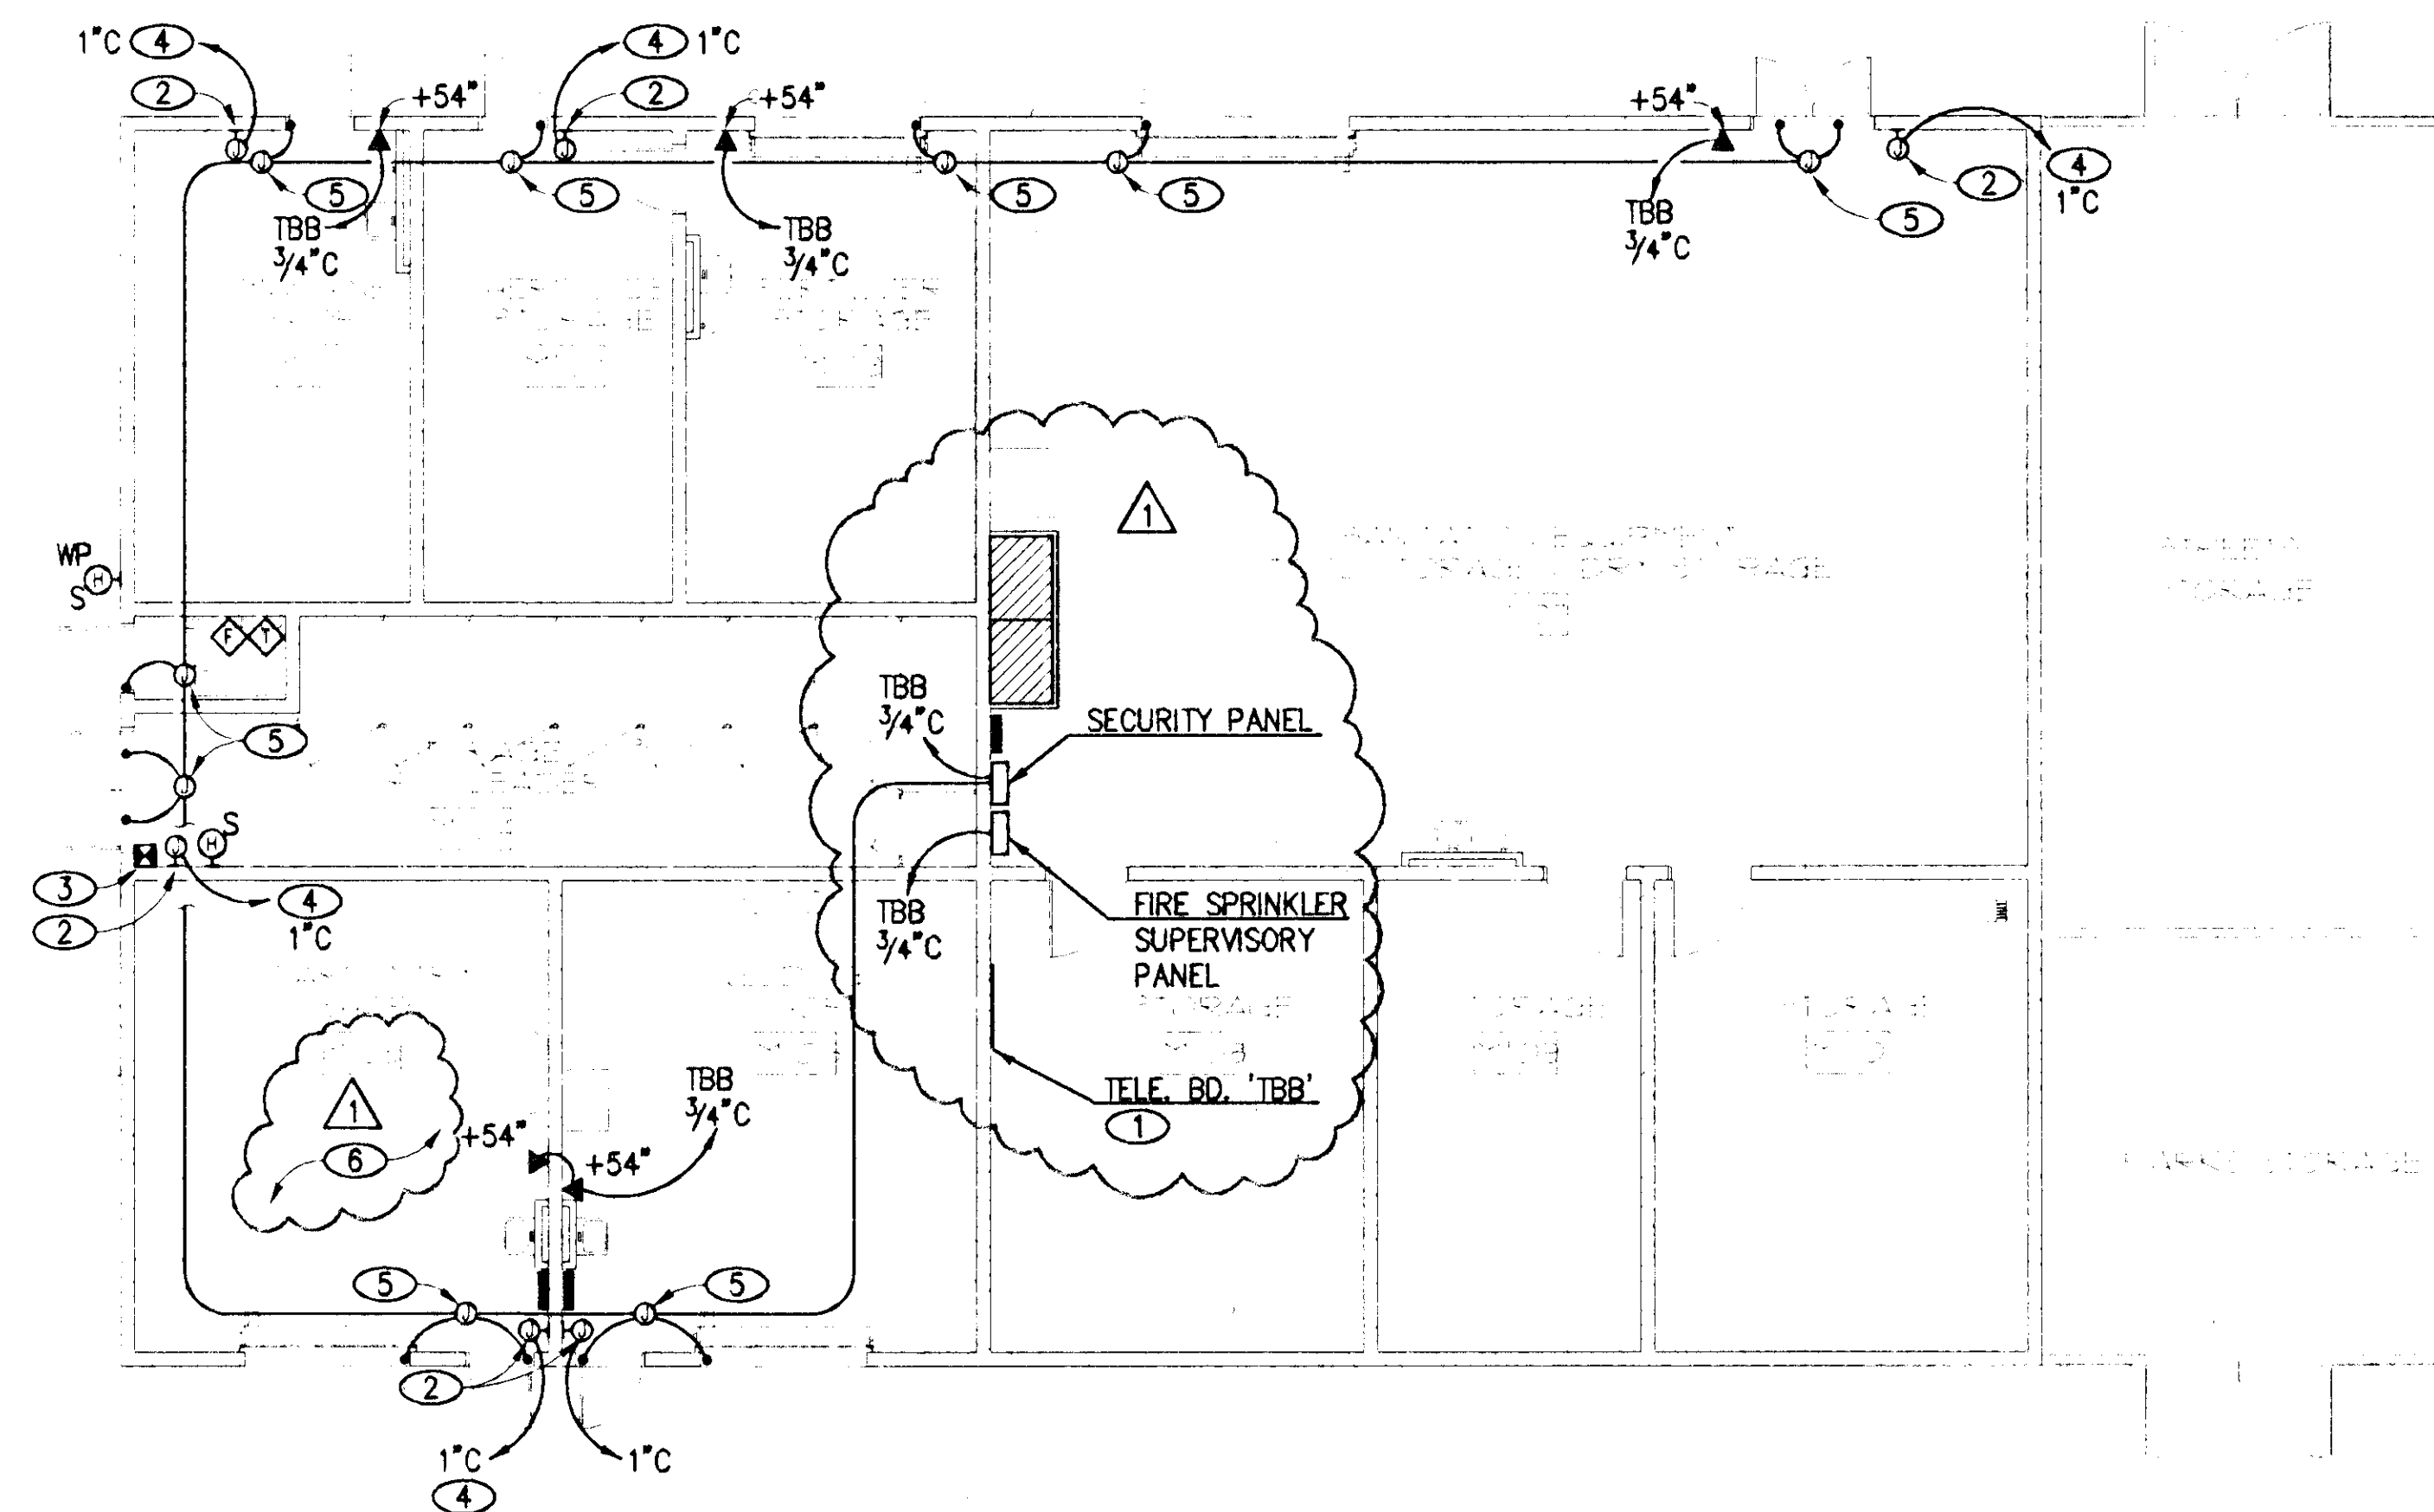

PLANS FOR FIRE HYDRANTS, FIRE EXTINGUISHING SYSTEMS, FIRE ALARM SYSTEMS, MEDICAL GAS SYSTEMS, ON-SITE FIRE, WATER, AND FUEL TANKS MUST BE APPROVED BY FIRE DEPARTMENT BEFORE INSTALLATION.

Separate permit required

FLOOR PLAN - AUXILIARY SCALE 1/8" = 1'-0"

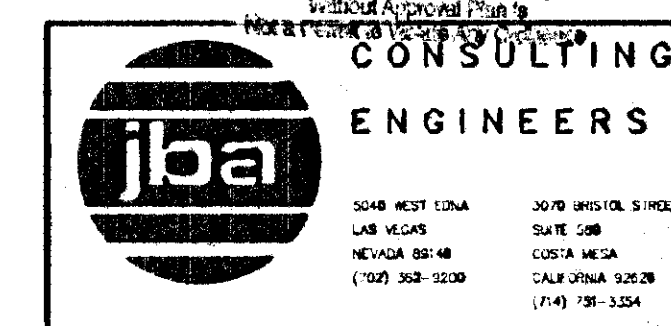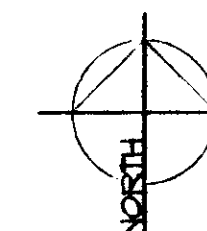


LOW VOLTAGE WIRING
SMALL IN CONDUIT

PLANS APPROVED
ELECTRICAL
RESERVED
SEP 06 2002
SEP 13 2002

CITY OF LAS VEGAS
DEPARTMENT OF PUBLIC WORKS
ARCHITECTURAL SERVICES

OWNER: CITY OF LAS VEGAS
DEPARTMENT OF PUBLIC WORKS
ARCHITECTURAL SERVICES
400 EAST STEWART AVENUE
LAS VEGAS, NEVADA 89101
PHONE: (702) 229-6535
FAX: (702) 382-8232
TDD: (702) 386-9108

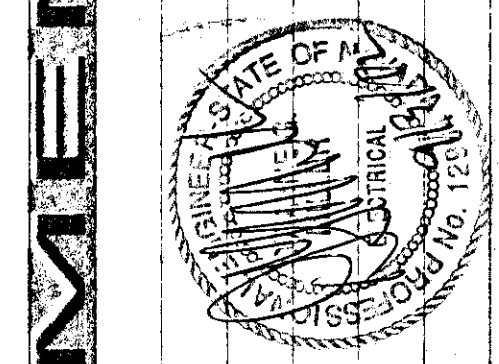

OWNER: CITY OF LAS VEGAS
DEPARTMENT OF PUBLIC WORKS
ARCHITECTURAL SERVICES

DRAWN	ELS
FILE	6431E13.DWG
DATE	03.15.02
SCALE	1/8" = 1'-0"
SHEET NO	02.15341.09
TOTAL SHEETS	107-V3548
SHEET NO	E3.13

CITY OF LAS VEGAS WEST SERVICE YARD
BUFFALO DRIVE AND PEAK ROAD
LAS VEGAS, NEVADA
FLOOR PLAN - AUXILIARY
FIELD MAINTENANCE BUILDING

AUG. 30, 2002

