



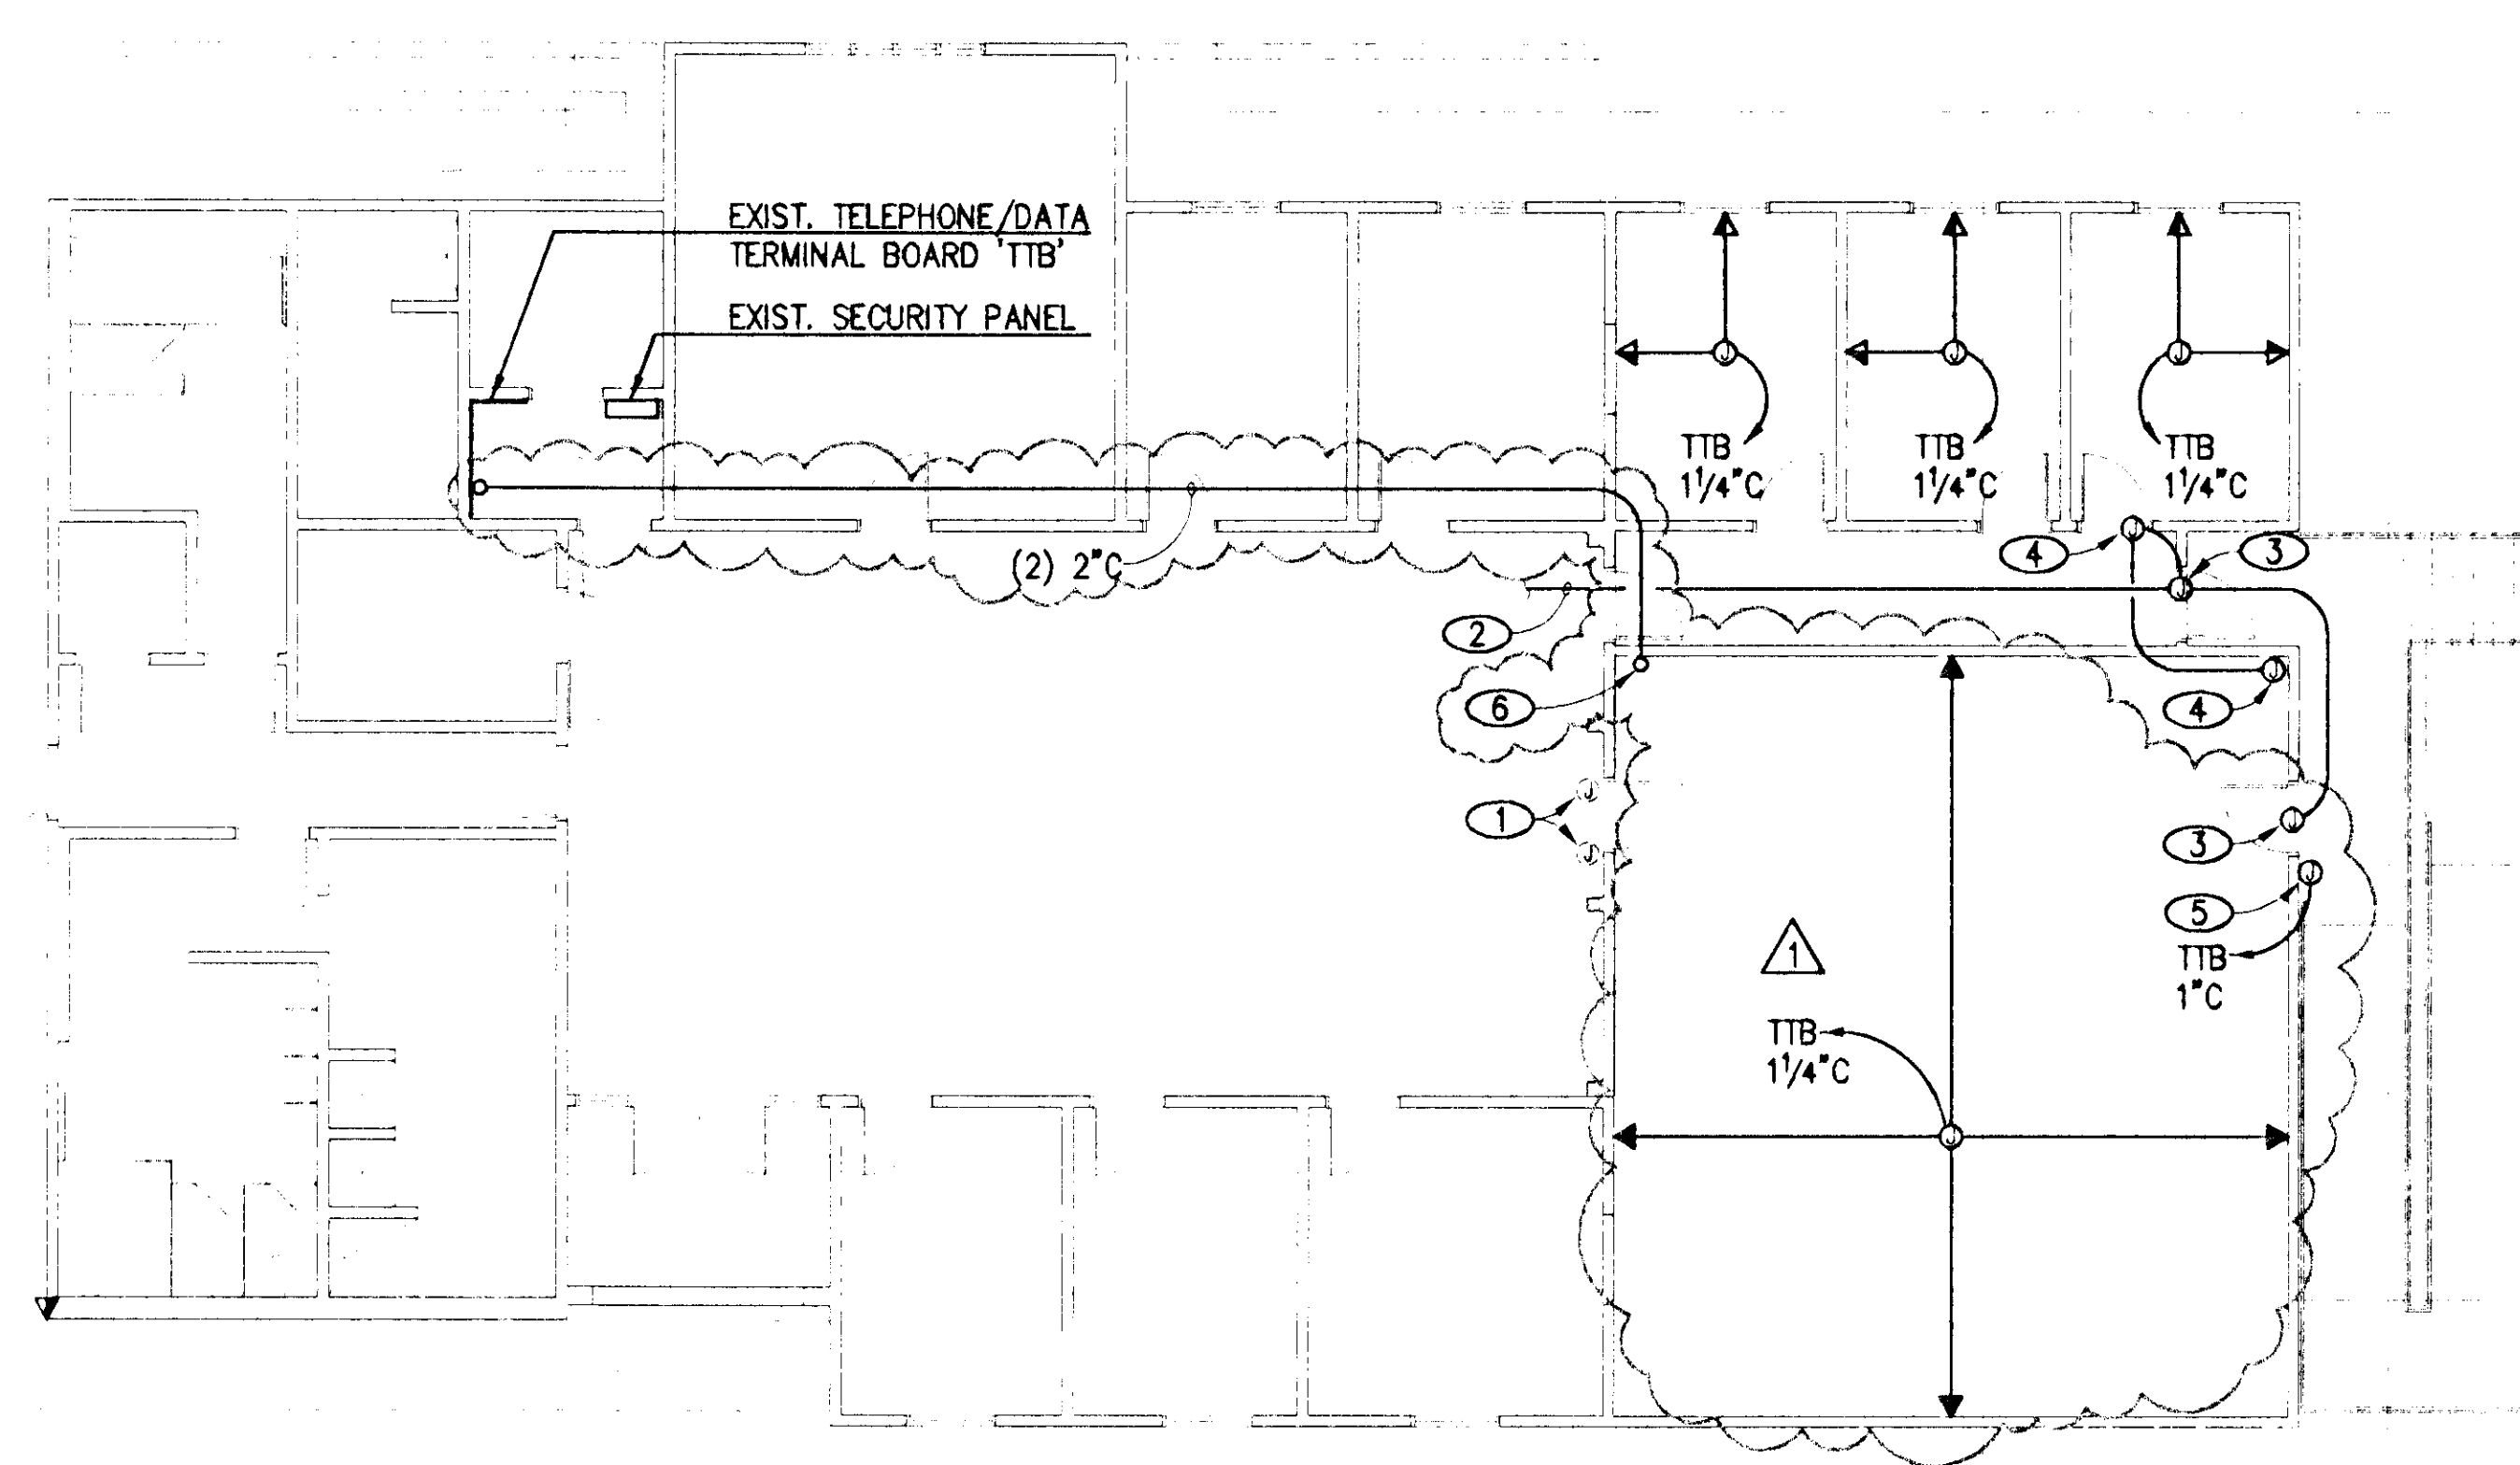

FLOOR PLAN - AUXILIARY

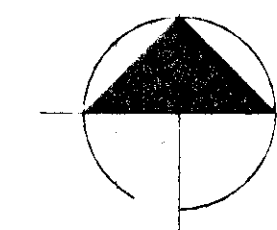

NOTICE

- EXISTING SHOWN LIGHT, NEW SHOWN BOLD, EXISTING TO BE REMOVED SHOWN LIGHT AND DASHED.
- MINIMUM RACEWAY SIZE SHALL BE 3/4" THIS SHEET.

NOTES

- DISCONNECT AND REMOVE EXISTING SECURITY DOOR CONTACTS. PROVIDE ALL RACEWAYS, WIRING, BOXES, ETC. TO MAINTAIN CIRCUITS.
- CONNECT TO EXISTING SECURITY PANEL.
- ROUGH-IN FOR SECURITY DOOR CONTACT, COORDINATE ROUGH-IN REQUIREMENTS WITH SECURITY ALARM VENDOR.
- ROUGH-IN FOR SECURITY ALARM MOTION SENSORS, COORDINATE REQUIREMENTS WITH OWNER'S SECURITY VENDOR.
- ROUGH-IN FOR SECURITY CARD READER, COORDINATE ROUGH-IN LOCATION AND HEIGHT WITH OWNER.
- STUB THRU CEILING AND PROVIDE BUSHING.

LOW VOLTAGE WIRING SHALL BE IN CONDUIT

PLANS APPROVED
ELECTRICAL
Building & Survey Dept.
City of Las Vegas, Nevada

RECEIVED 13 2002

DESIGNED BY: [Signature]
CHECKED BY: [Signature]
CITY OF LAS VEGAS
BUILDING & SURVEY DEPT.

iba CONSULTING ENGINEERS
3040 WEST TOWN
LAS VEGAS, NEVADA 89102
(702) 362-9200

3070 BRISTOL STREET
SUITE 200
COVINGTON, MISSISSIPPI 38401
(601) 798-3554

REVISION
AUG. 30, 2002

CONSULTANT
TATE SNYDER KIMSEY

CITY OF LAS VEGAS
DEPARTMENT OF PUBLIC WORKS
ARCHITECTURAL SERVICES

OWNER: CITY OF LAS VEGAS
DEPARTMENT OF PUBLIC WORKS
ARCHITECTURAL SERVICES

400 EAST STEWART AVENUE
LAS VEGAS, NEVADA 89101
PHONE: (702) 229-5533
FAX: (702) 229-5533
TDD: (702) 366-9100

OWNER	4	YES
FILE	64316314.DWG	
DATE	03.15.02	
SCALE	1/8" = 1'-0"	
DWG NO	02.15341.09	
REV DWG NO	107-V3548	
SHEET NO	E3.14	