


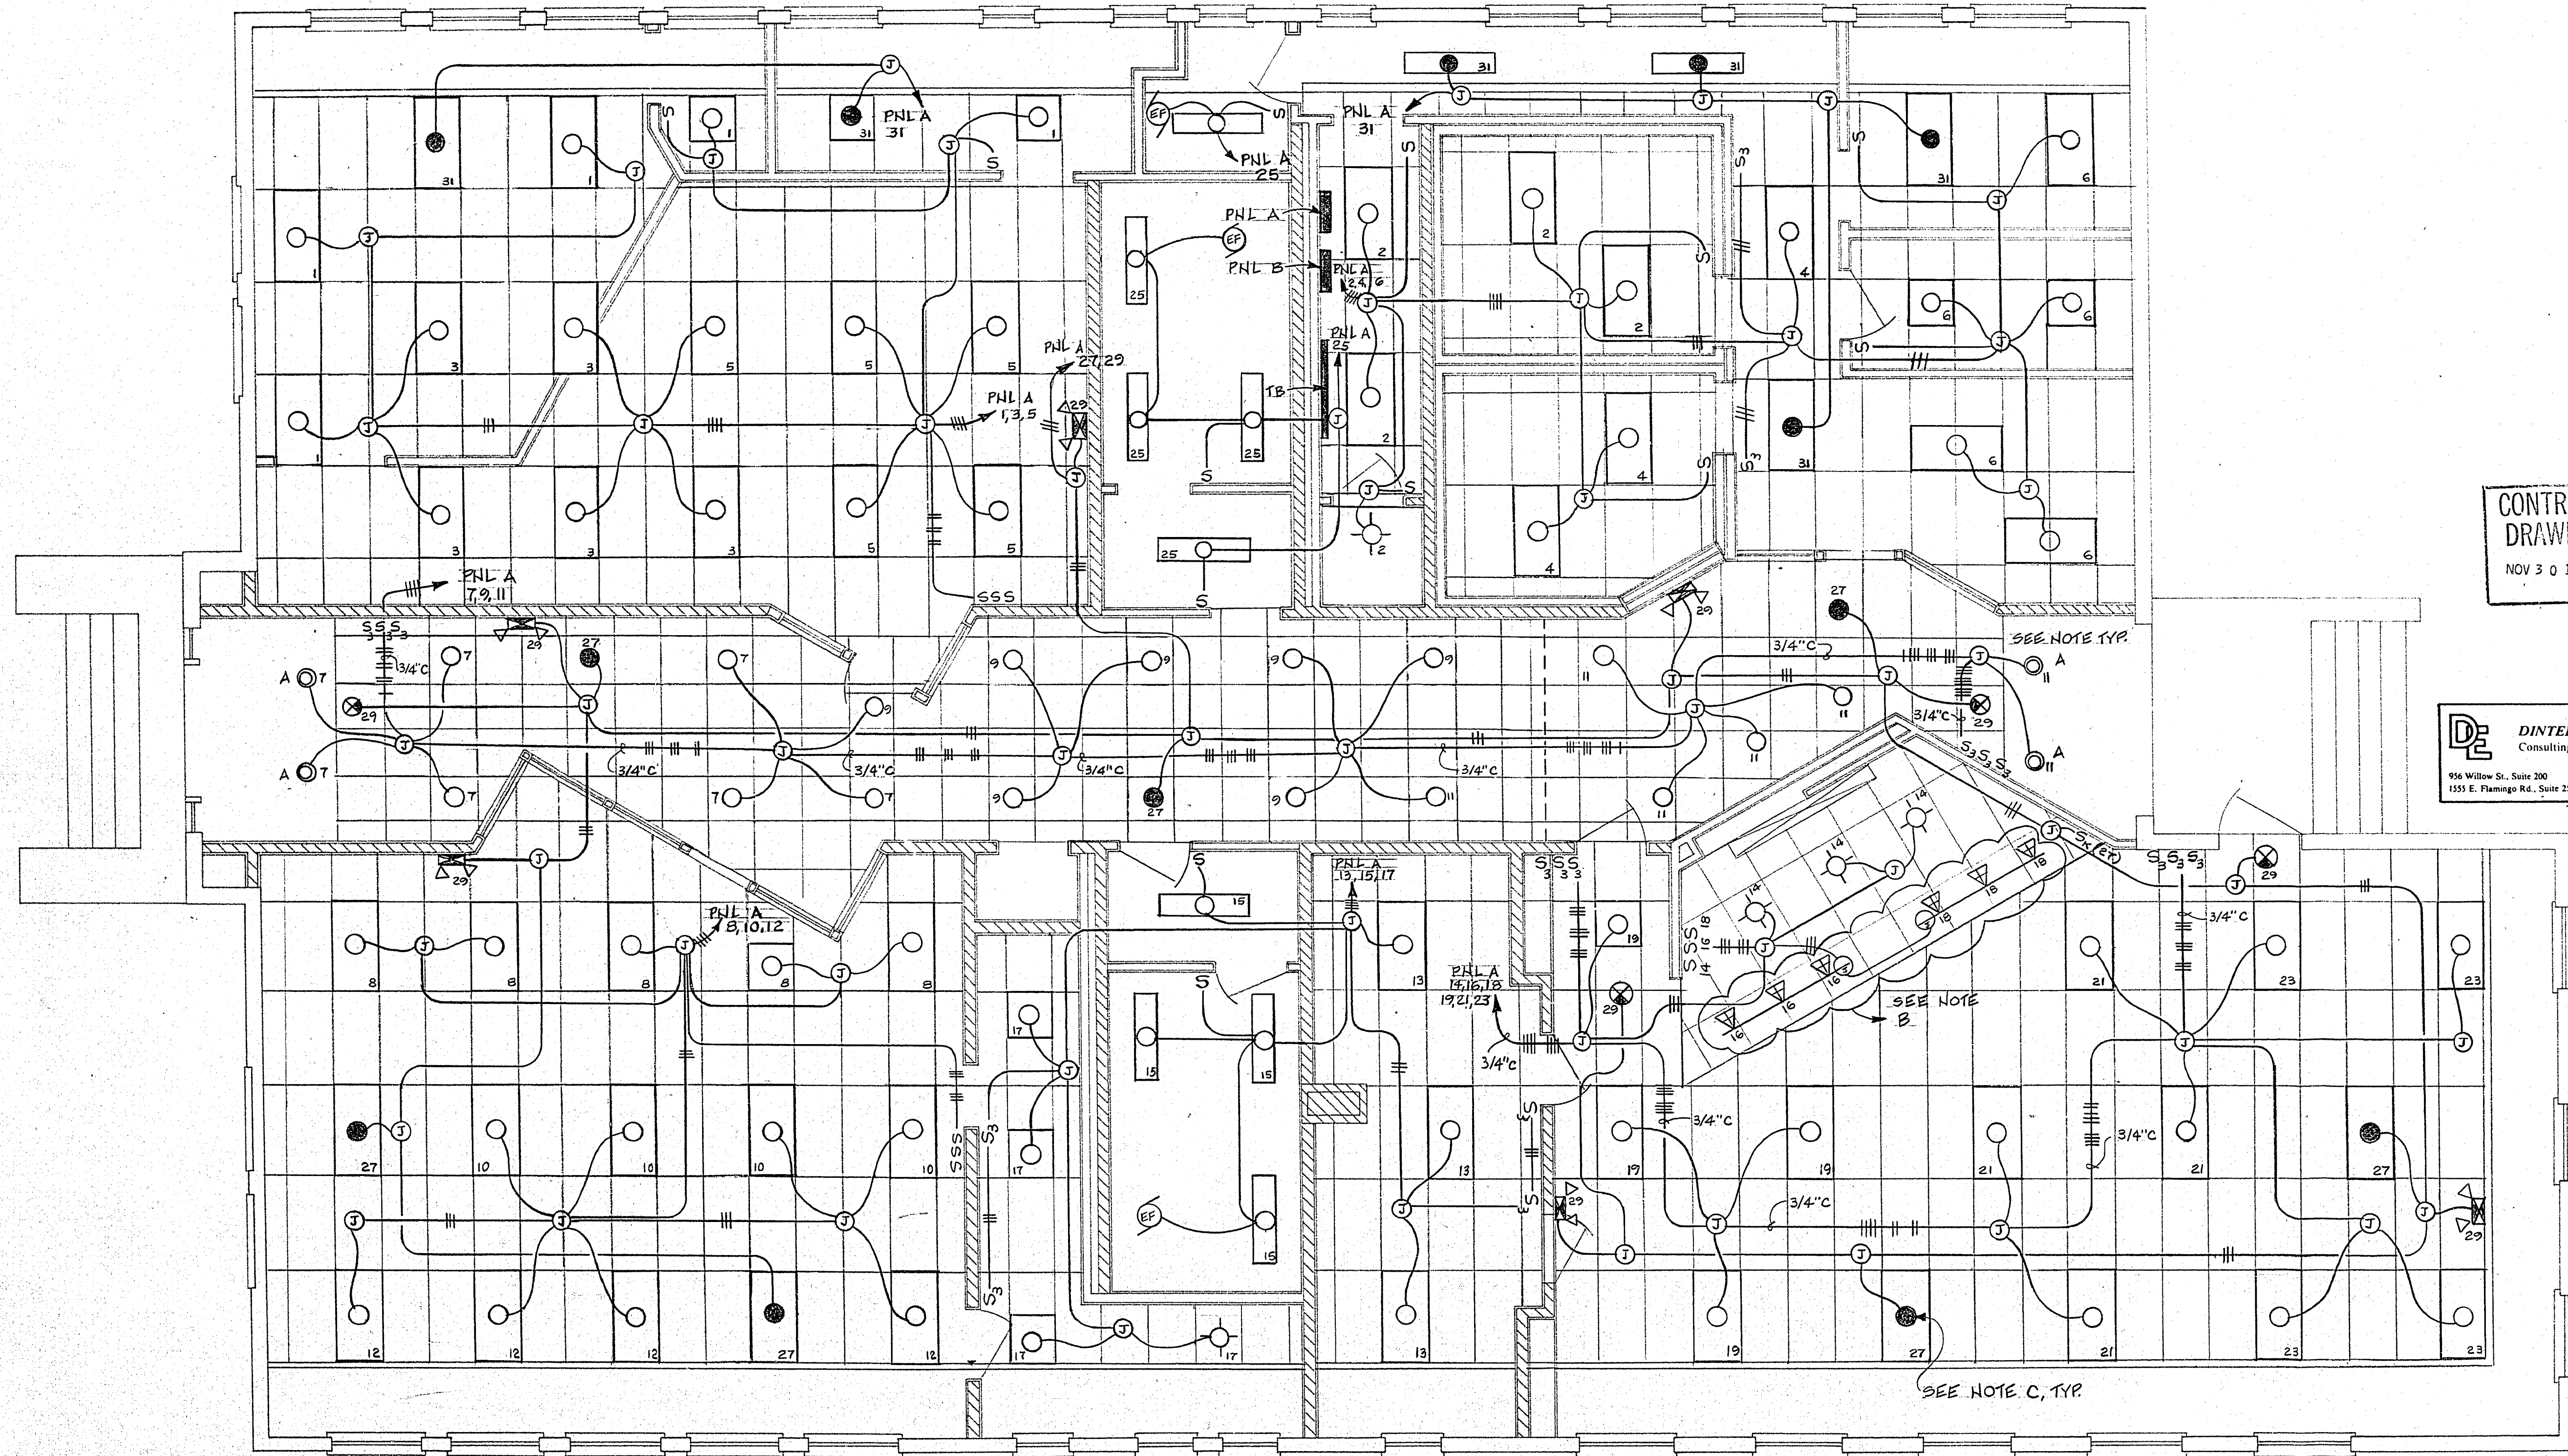

CONTRACT
DRAWING
NOV 3 0 1982

 
DINTER ENGINEERING CO., Ltd.
Consulting Electrical & Mechanical Engineers
956 Willow St., Suite 200 Reno Nevada 89502 (702) 329-0206
1551 E. Flamingo Rd., Suite 254 Las Vegas, Nevada 89109 (702) 369-3139

BONGBER-WHITNEY, INC.
1816 INDUSTRIAL RD.
LAS VEGAS-NEVADA
382-1371

NOTES

AS BUILT

- FIXTURES SHALL BE SUPPLIED WITH A 30°± SLOPE TO MATCH CEILING. VERIFY PRIOR TO ORDER.
- TRACK LIGHTING INSTALLED ON VERTICAL FACE OF CEILING TRANSITION. MOUNT AS HIGH AS POSSIBLE TO ALLOW FULL MOVEMENT OF LIGHTS. VERIFY PRIOR TO INSTALLATION.
- FIXTURES SO DESIGNATED SHALL SERVE AS "NIGHT LIGHTS" AND SHALL NOT BE SWITCHED.

 Drawing no. 513-53	Department of Public Services	Engineering Design Division	LIGHTING PLAN	WEST SIDE SCHOOL RENOVATION					
					Scale (h) 1/4" = 1'-0"	Scale (v)	W.U. 2162		
					Fid. bk. no.	Date AUG. 1982			
					Design by M. GOODMAN	Drawn by NORMA GOMEZ			
</									