


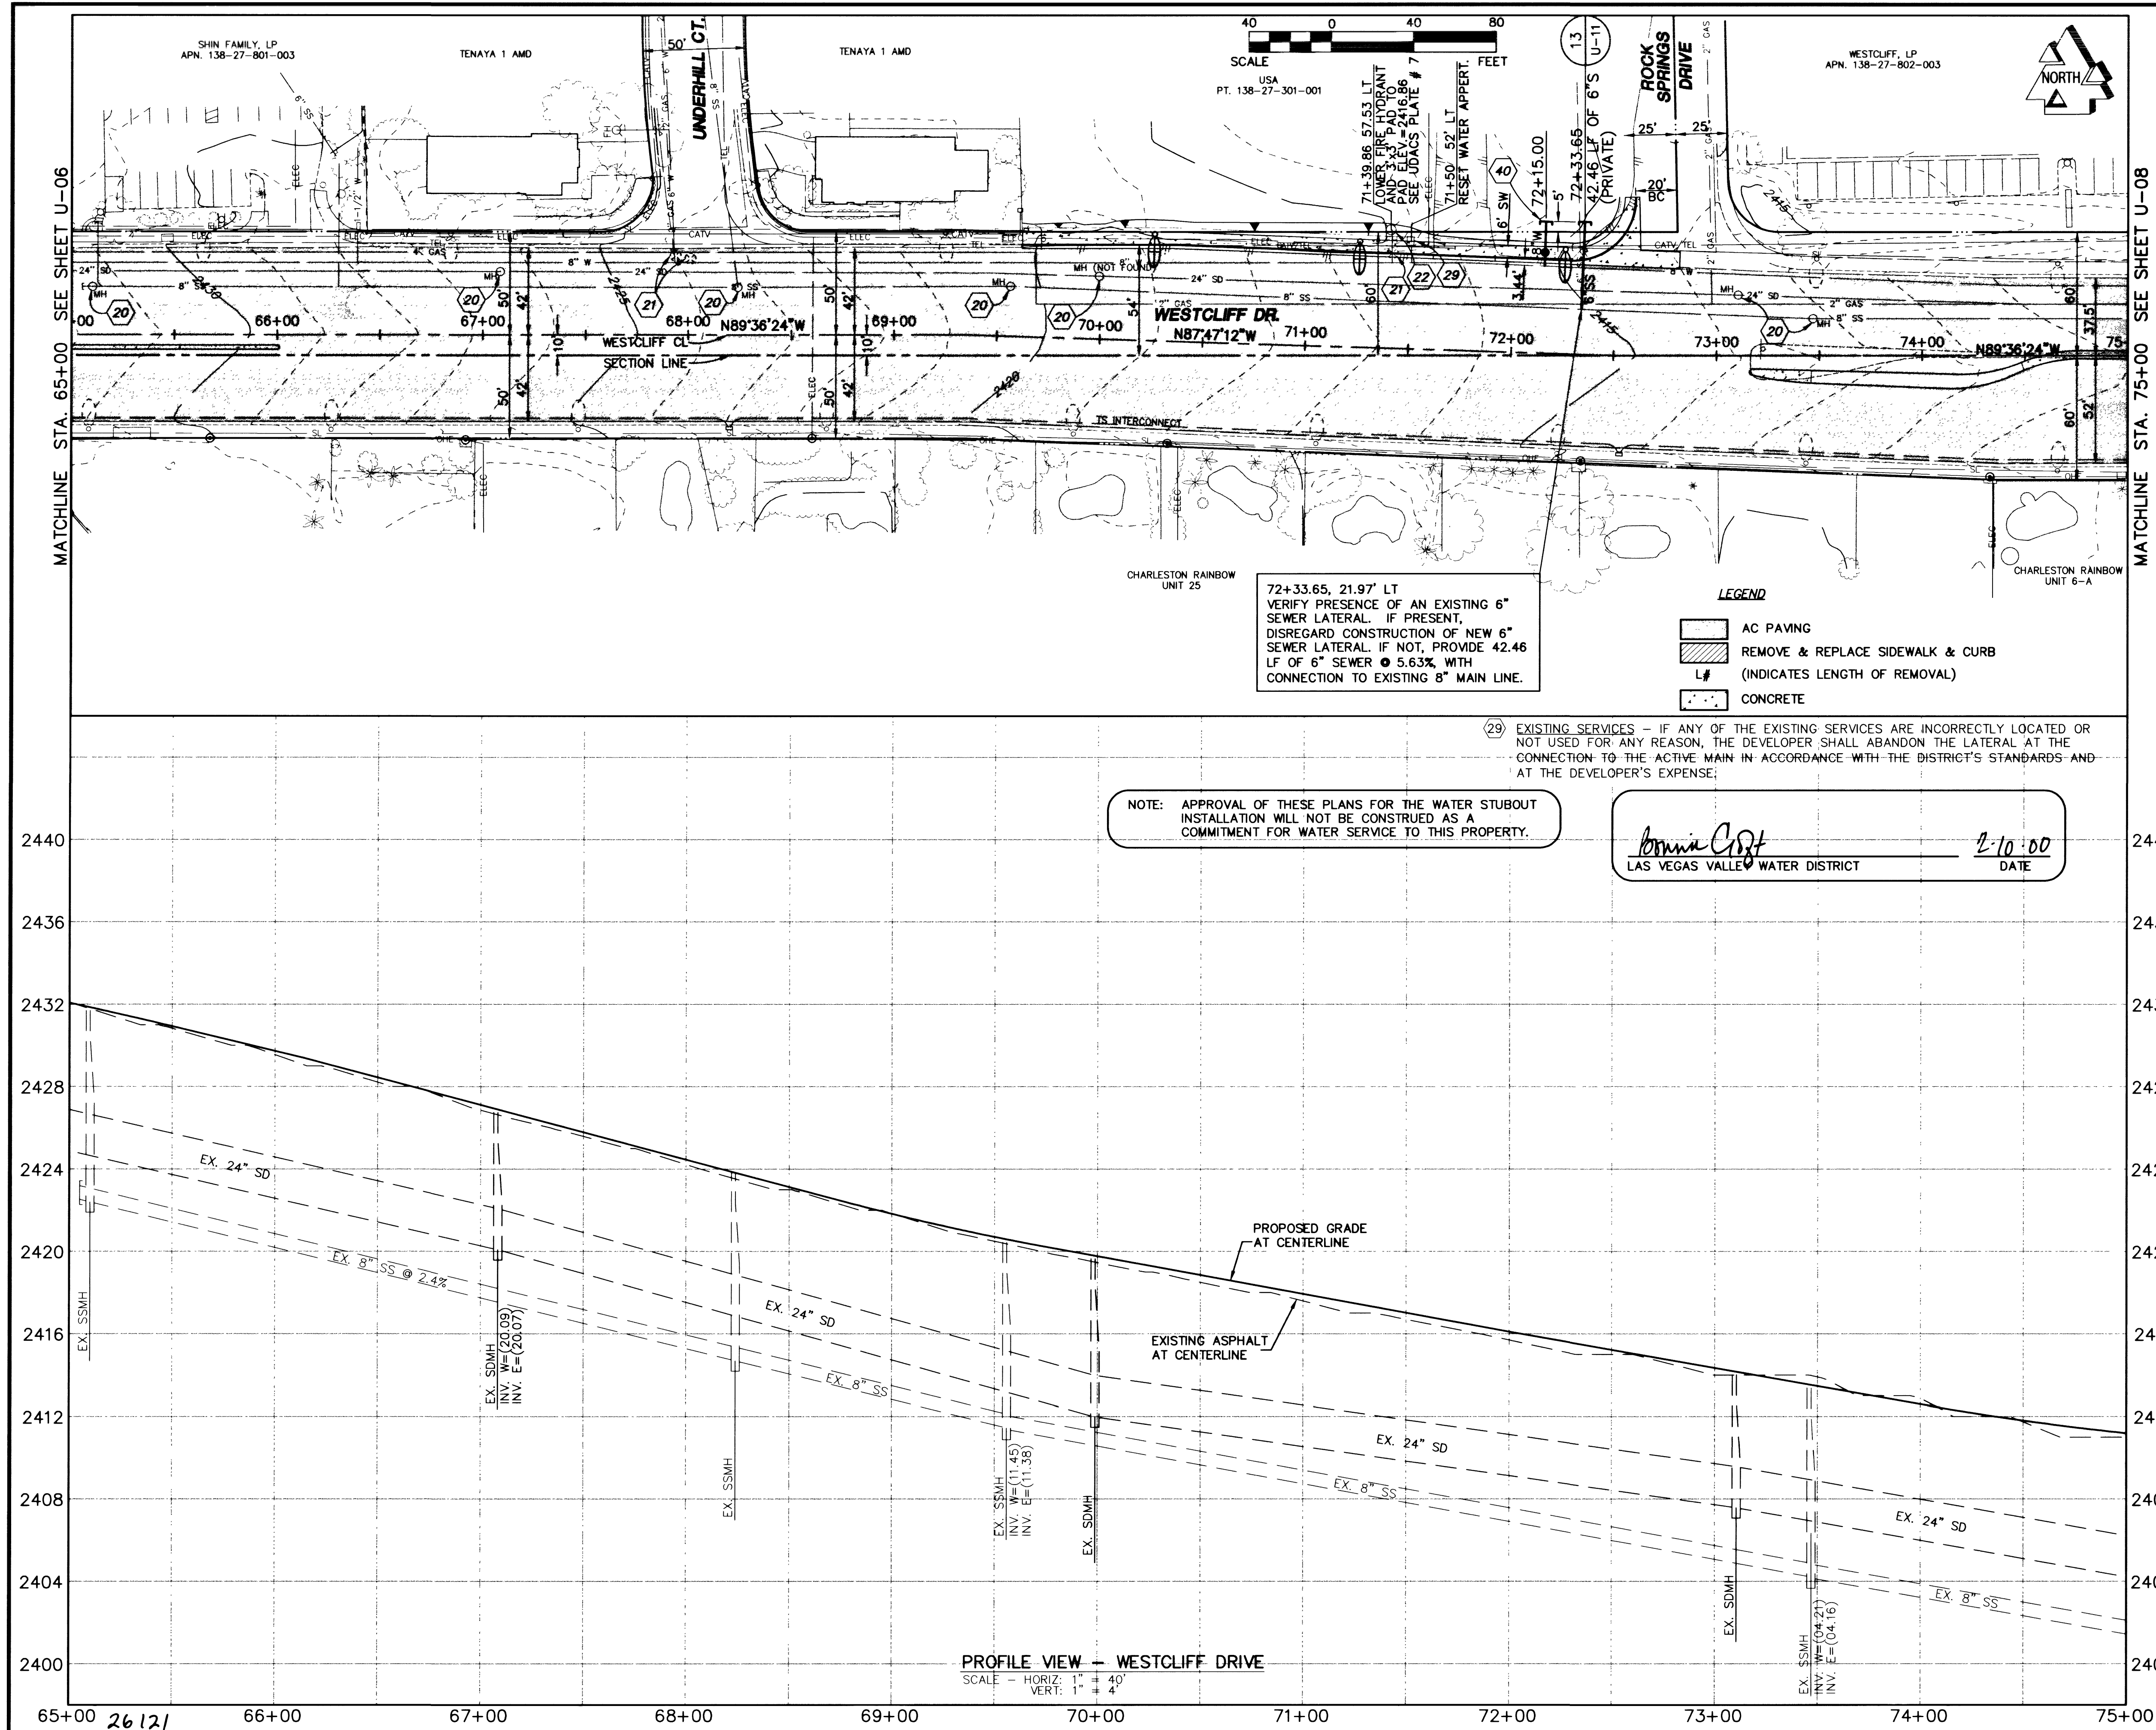

CONSTRUCTION NOTES	
USD STANDARD DRAWING REFERENCE SHOWN ON SHEET C-04	
2	CONSTRUCT CONCRETE SIDEWALK
4	CONSTRUCT "L" TYPE CURB & GUTTER
9	CONSTRUCT GUTTER TRANSITION
REMOVALS	
12	SAWCUT
15	REMOVE CURB AND GUTTER
16	REMOVE SIDEWALK
RELOCATIONS	
20	ADJUST MANHOLE TO GRADE AND CONSTRUCT CONCRETE COLLAR
21	ADJUST VALVE BOX TO GRADE
22	ADJUST FIRE HYDRANT
23	RELOCATE WATER LINE
24	RELOCATE CONFLICTING ELECTRICAL CONDUIT
25	RELOCATE CONFLICTING TELEPHONE CONDUIT
26	RELOCATE CONFLICTING ST. LIGHT CONDUIT
27	RELOCATE CONFLICTING CABLE TV CONDUIT
28	RELOCATE GAS LINE
STORM DRAIN/SEWER IMPROVEMENTS	
32	CONSTRUCT 6' TYPE "F" DROP INLET
33	CONSTRUCT 18' TYPE "F" DROP INLET
34	CONSTRUCT TYPE I MANHOLE, 60"
35	MODIFY MANHOLE
36	MODIFY DROP INLET
WATER IMPROVEMENTS	
40	INSTALL 21.61 LF 8" WATER PVC - INSTALL 8"x8" M.J. TAPPING SLEEVE - INSTALL 8" GATE VALVE IN SIDEWALK STATION 72+15. 48.9' LT WITH CONCRETE COLLAR PER UDACS PLATE # 8. OTHERWISE INSTALL IN STREET IF DISTANCE TO CURB FROM TAPPING SLEEVE ALLOWS. - TEMP. STUB & PLUG W/ 2" MAN. BLOW OFF ASSEMBLY.

PROJ NO: 99202	DESIGN: K.H./RAS	DATE: 02/10/00	SCALE: AS SHOWN	CADFILE: WC_U07
STAMP DATE: 02-10-00				
ACED				
3320 NORTH BUFFALO DRIVE, SUITE 106 TEL: (702) 398-3438, FAX: (702) 398-3758 EMAIL: admin@acep-ly.com				
WESTCLIFF DRIVE IMPROVEMENTS CIMARRON ROAD TO RAINBOW BLVD UTILITY PLAN & PROFILE 65+00 TO 75+00				
SHEET U-07 30 OF 47 SHEETS DRAWING NO. 107-V3099				