


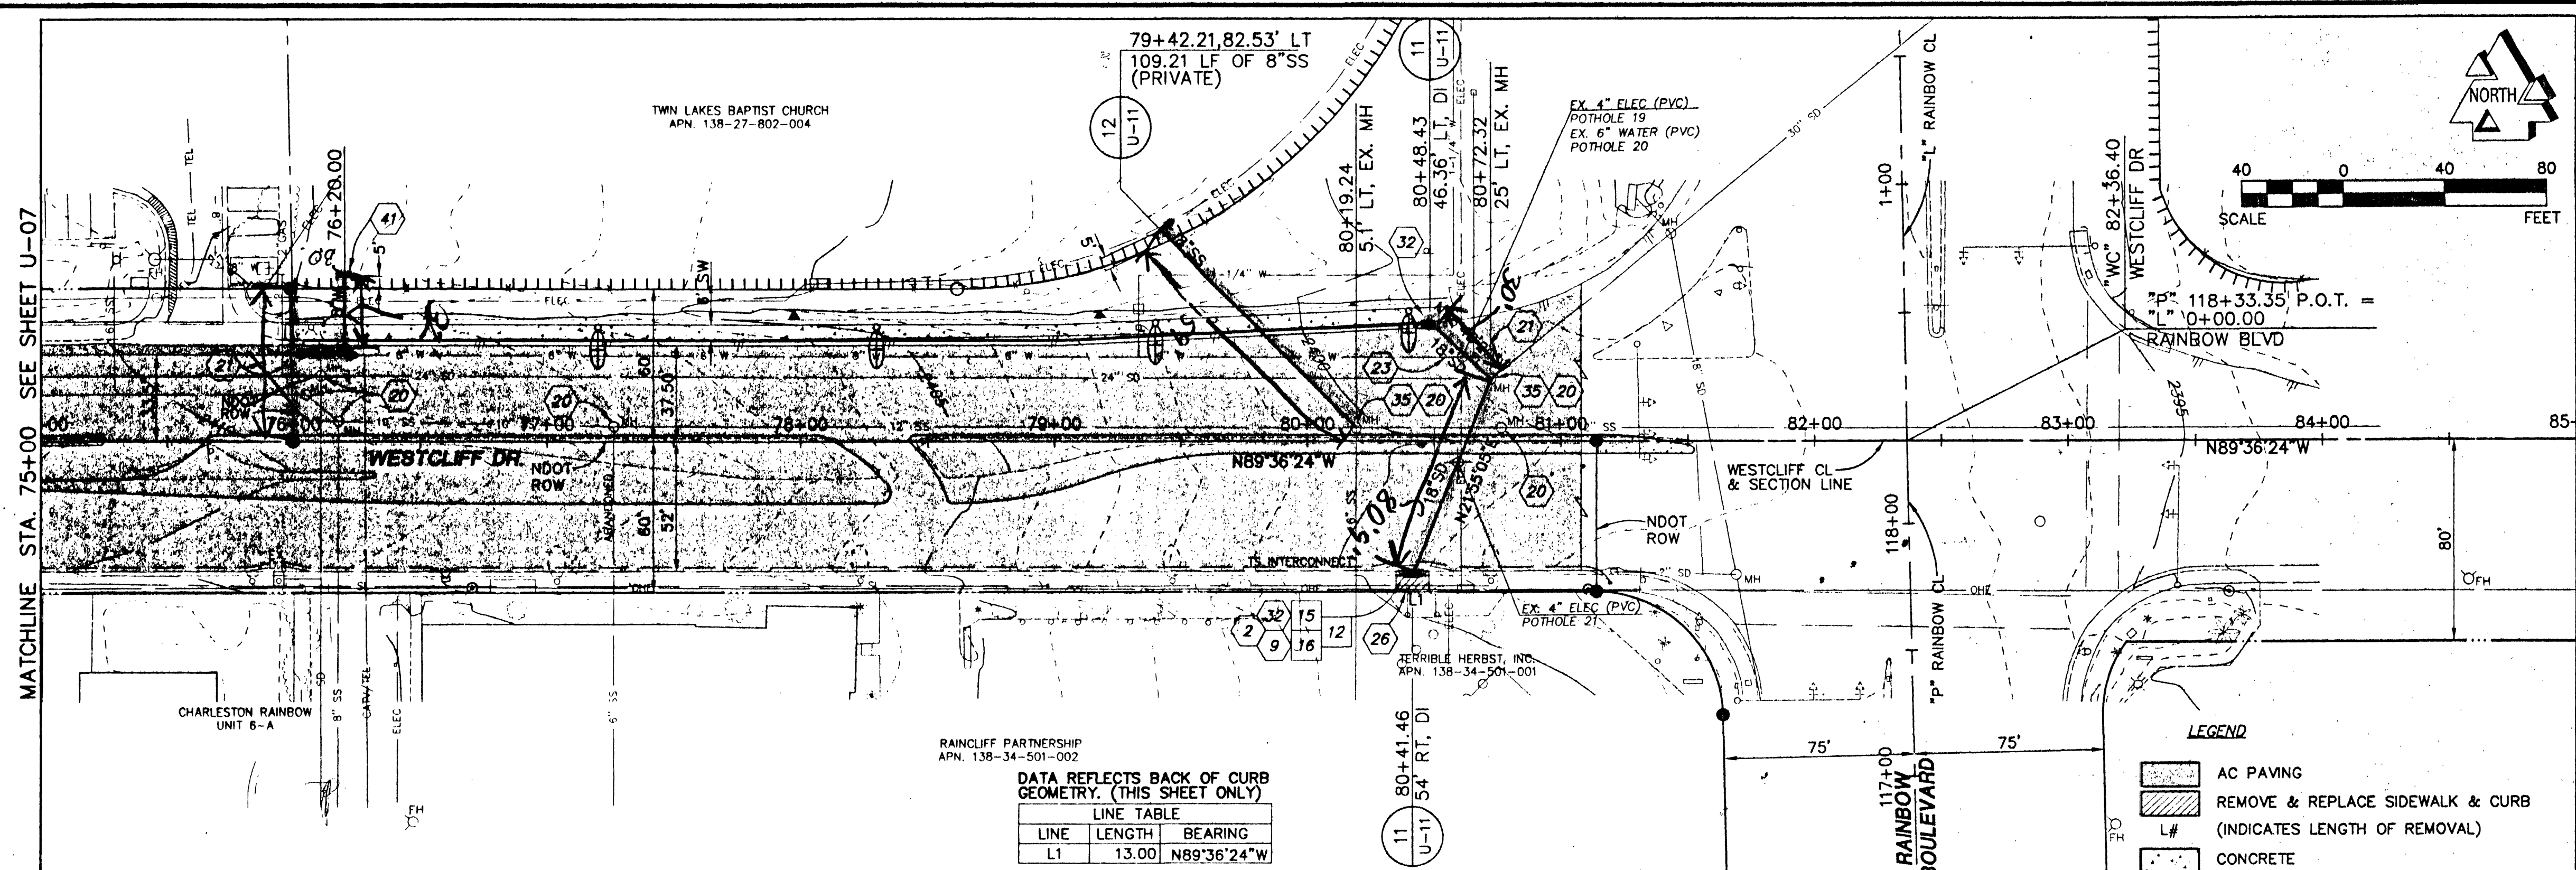


DATA REFLECTS BACK OF CURB GEOMETRY. (THIS SHEET ONLY)

| LINE | LENGTH | BEARING     |
|------|--------|-------------|
| L1   | 13.00  | N89°36'24"W |

- LEGEND**
- AC PAVING
  - REMOVE & REPLACE SIDEWALK & CURB (INDICATES LENGTH OF REMOVAL)
  - CONCRETE


NOTE: APPROVAL OF THESE PLANS FOR THE WATER STUBOUT INSTALLATION WILL NOT BE CONSTRUED AS A COMMITMENT FOR WATER SERVICE TO THIS PROPERTY.

*Bonnie C. Q. T.*  
LAS VEGAS VALLEY WATER DISTRICT  
2-10-00  
DATE

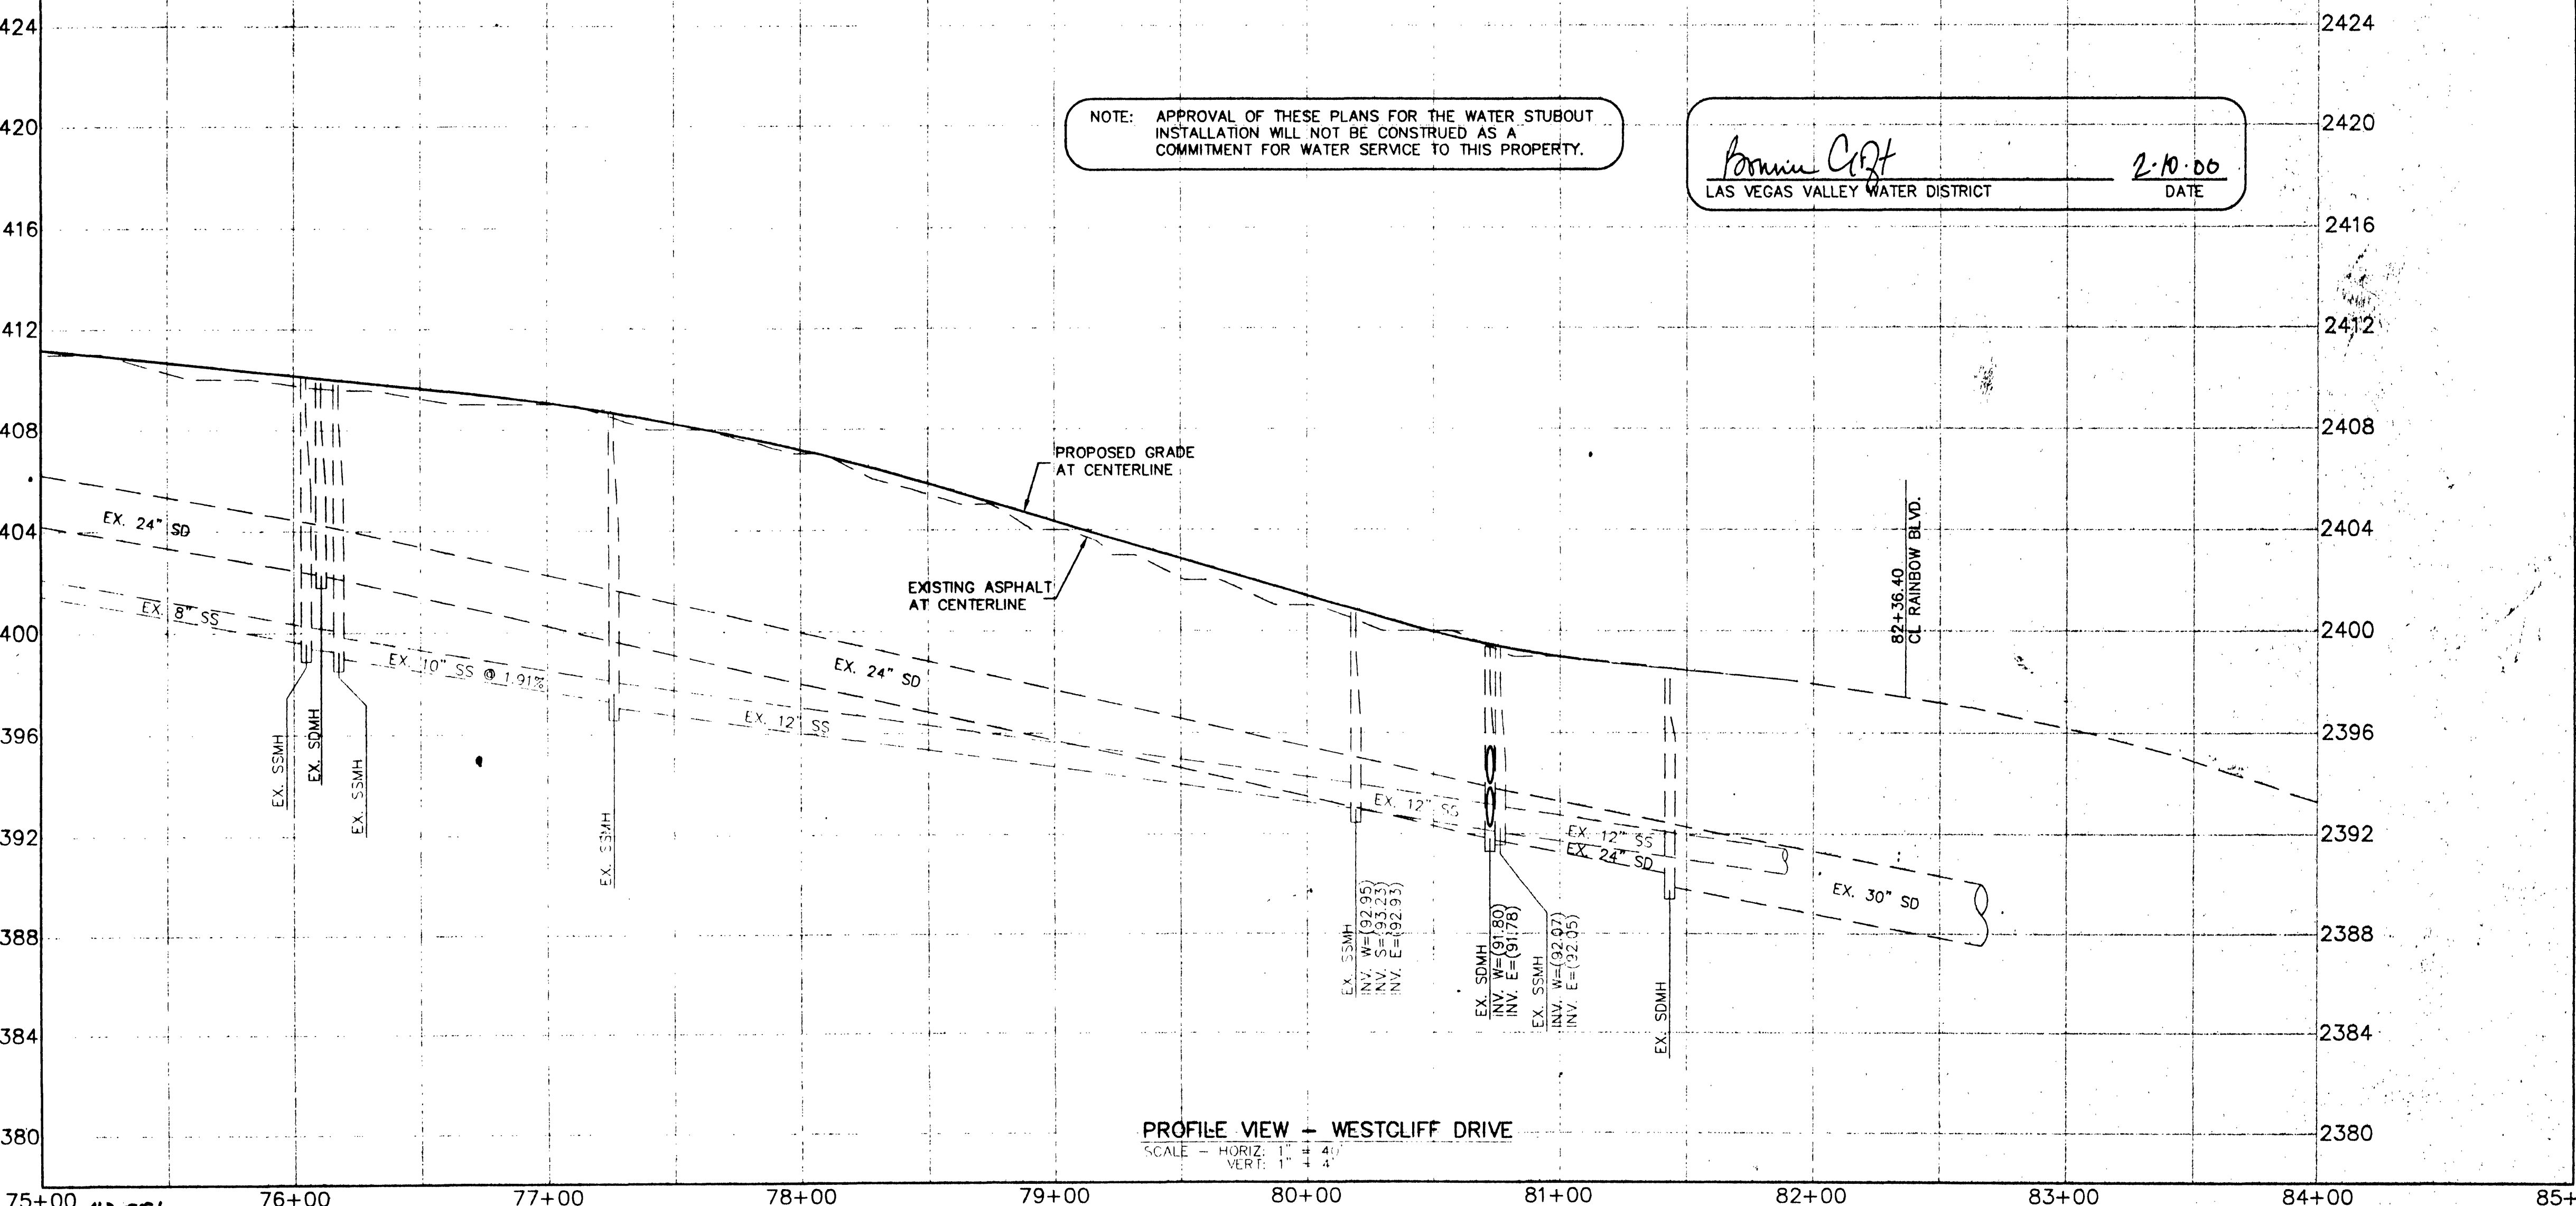

PROFILE VIEW - WESTCLIFF DRIVE  
SCALE - HORIZ. 1" = 4' VERT. 1" = 4'

- CONSTRUCTION NOTES**
- USD STANDARD DRAWING REFERENCE SHOWN ON SHEET C-04
- 2) CONSTRUCT CONCRETE SIDEWALK
  - 4) CONSTRUCT "L" TYPE CURB & GUTTER
  - 9) CONSTRUCT GUTTER TRANSITION
- REMOVALS**
- 12) SAWCUT
  - 15) REMOVE CURB AND GUTTER
  - 16) REMOVE SIDEWALK
- RELOCATIONS**
- 20) ADJUST MANHOLE TO GRADE AND CONSTRUCT CONCRETE COLLAR
  - 21) ADJUST VALVE BOX TO GRADE
  - 22) ADJUST FIRE HYDRANT
  - 23) RELOCATE WATER LINE
  - 24) RELOCATE CONFLICTING ELECTRICAL CONDUIT
  - 25) RELOCATE CONFLICTING TELEPHONE CONDUIT
  - 26) RELOCATE CONFLICTING ST. LIGHT CONDUIT
  - 27) RELOCATE CONFLICTING CABLE TV CONDUIT
  - 28) RELOCATE GAS LINE
- STORM DRAIN/SEWER IMPROVEMENTS**
- 32) CONSTRUCT 6" TYPE "F" DROP INLET
  - 33) CONSTRUCT 18" TYPE "F" DROP INLET
  - 34) CONSTRUCT TYPE I MANHOLE, 60"
  - 35) MODIFY MANHOLE
  - 36) MODIFY DROP INLET
- WATER IMPROVEMENTS**
- 41) INSTALL APPROX. 31 LF 8" WATER PVC LATERAL
  - REMOVE EX. 8"x8" REDUCER
  - REMOVE APPROX. 20 LF OF 6" WATER LINE
  - REPLACE W/ APPROX. 20 LF OF 8" PVC WATER TO LATERAL LOCATION. PROVIDE 8"x8"x8" TEE AND 8"x8" REDUCER TO RECONNECT TO EXISTING 6" WATER LINE
  - INSTALL 8" GATE VALVE FOR LATERAL (WITH CONCRETE COLLAR PER UDACS PLATE NO. 8, IF INSTALLED IN SIDEWALK)
  - TEMP. STUB & PLUG 8" LATERAL W/ 2" MAN. BLOW OFF ASSEMBLY.

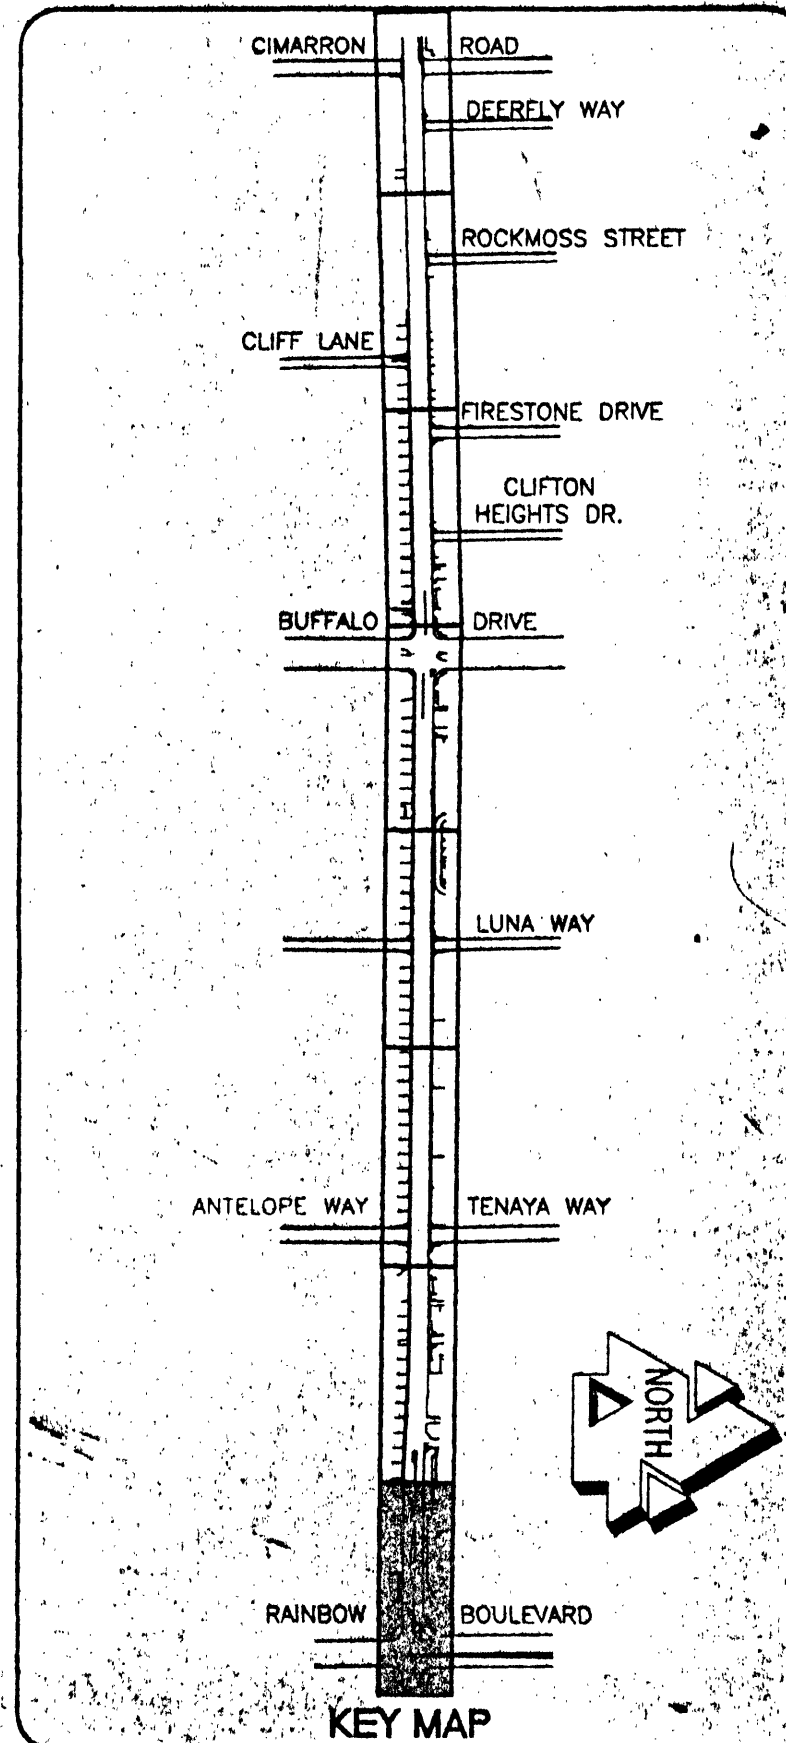

**Call before you Dig**  
1-800-227-2600  
UNDERGROUND SERVICE (USA)

**CALL BEFORE YOU DO OVERHEAD**  
1-702-593-6111

**ACEP**  
3320 WEST BUFFALO DRIVE, SUITE 106  
LAS VEGAS, NV 89102  
TEL: (702) 368-3476 FAX: (702) 396-3758  
EMAIL: admin@acep-nv.com

**WESTCLIFF DRIVE IMPROVEMENTS**  
CIMARRON ROAD TO RAINBOW BLVD  
UTILITY PLAN & PROFILE  
75+00 TO 85+00

SHEET  
**U-08**  
31 OF 47 SHEETS  
DRAWING NO.  
**107-V3099**

SOUTHERN NEVADA PAVING, INC.  
**AS BUILT**  
DATE: 10/10/00