



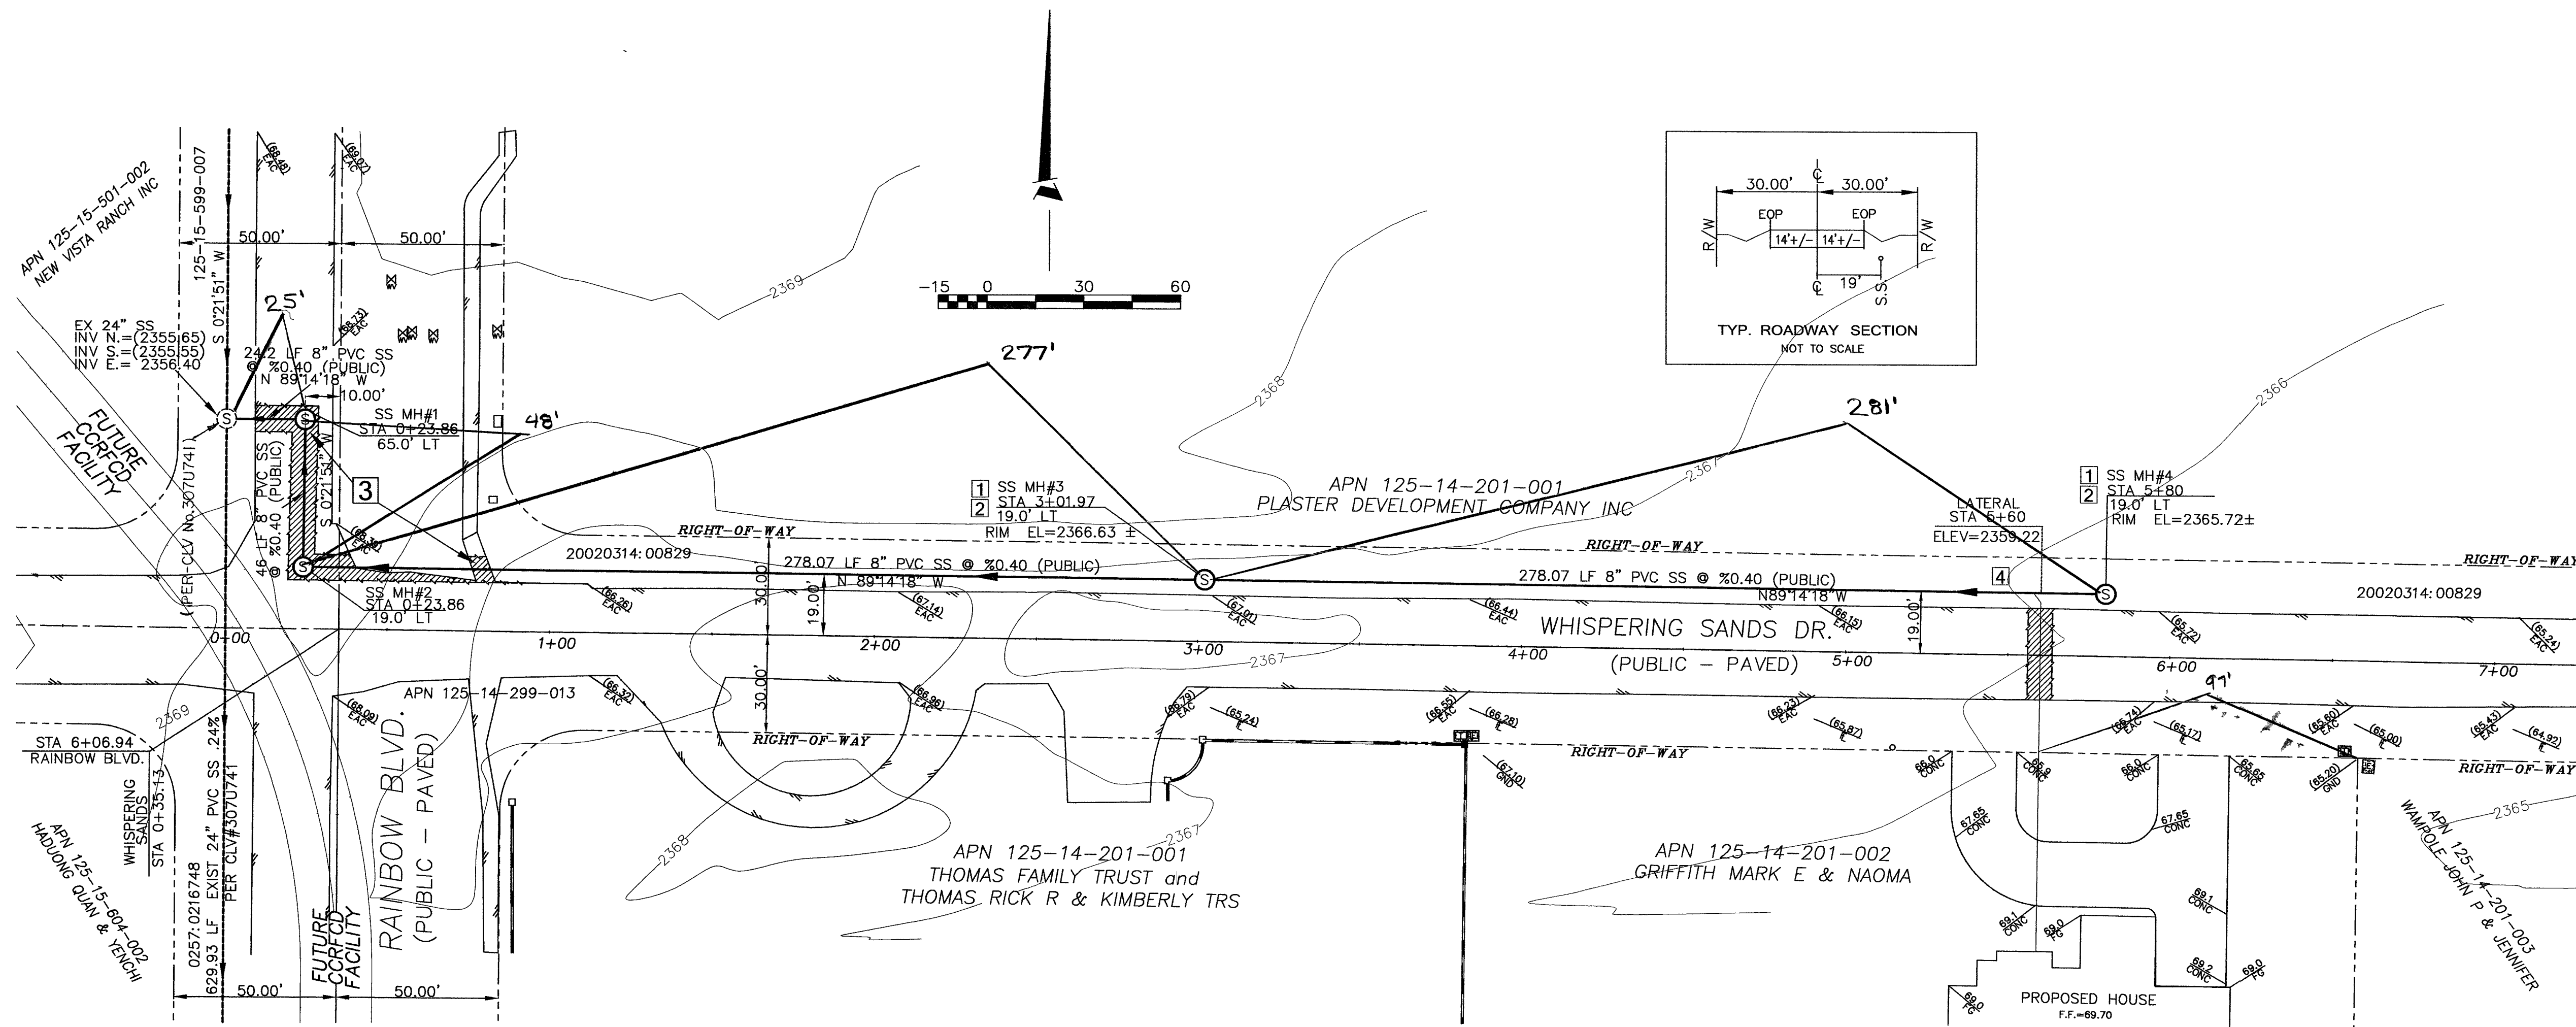

SEWER CONNECTION NOTE

A SEGMENT OF THE DOWNSTREAM SEWER SYSTEM THAT WILL SERVE THIS PROJECT HAS NOT BEEN COMPLETED AND/OR ACCEPTED FOR MAINTENANCE BY THE CITY OF LAS VEGAS. ANY WORK DONE ON THIS PROJECT PRIOR TO THE COMPLETION AND/OR ACCEPTANCE OF THE DOWNSTREAM SEWER SYSTEM(S) SHALL BE DONE AT THE DEVELOPER'S OWN RISK. THE CITY OF LAS VEGAS RESERVES THE RIGHT TO PREVENT THE PHYSICAL CONNECTION OF THIS PROJECT INTO THE DOWNSTREAM SEWER SYSTEM UNTIL ALL SEGMENTS HAVE BEEN COMPLETED AND ACCEPTED FOR MAINTENANCE, OR UNTIL SUCH TIME AS THEY HAVE BEEN DEEMED AVAILABLE FOR SERVICE.

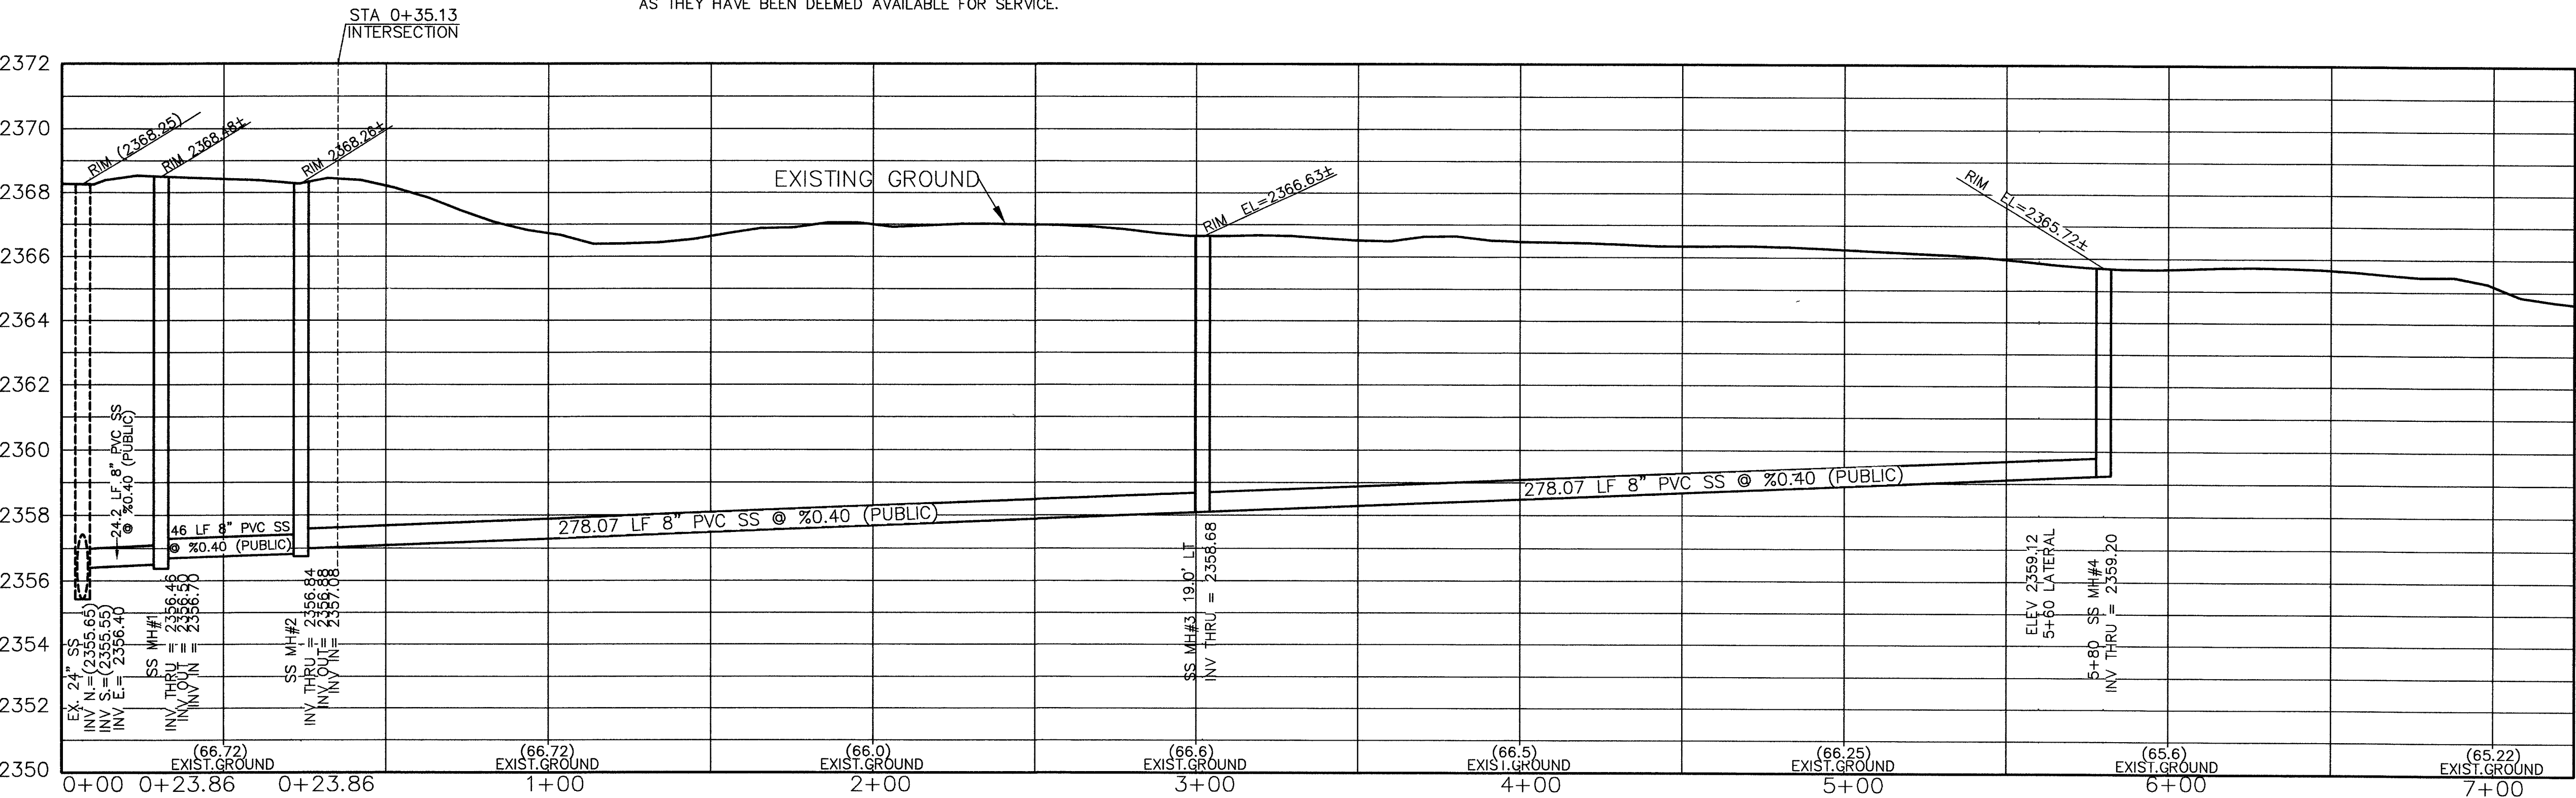

CALL before you DIG

1-800-227-2600

UNDERGROUND SERVICE (USA)
AVOID CUTTING UNDERGROUND UTILITY LINES. IT'S COSTLY.

CALL before you Overhead

1-702-593-6111

UNDERGROUND SERVICE (USA)
AVOID OVERHEAD POWER LINE CONTACT. IT'S COSTLY.

SANITARY SEWER NOTES

- 1 CONSTRUCT TYPE I MANHOLE PER C.C.A.U.S.D. DWG #403
- 2 TRENCH AND BACKFILL PER C.C.A.U.S.D. DWG #502
- 3 TRENCH AND BACKFILL PER C.C.A.U.S.D. DWG #504
- 4 TRENCH AND BACKFILL PER C.C.A.U.S.D. DWG #503

SEE SHEET 3 OF 3 FOR STD. DRAWING DETAILS

99024

ESLYN BRENNER - PLS 5088

BRENNER & ASSOCIATES INC.

3014 WEST CHARLESTON BLVD. SUITE 100
LAS VEGAS, NEVADA 89102

TEL: (702)877-0317 FAX: (702)877-0358

ebrenner@earthlink.net

PLAN AND PROFILE SHEET		SANITARY SEWER	
GRIFFITH, MARK E & NAOMA		GRIFFITH RESIDENTS	
APN 125-14-201-002		APN 125-14-201-003	
DRAWN BY: JB		DESIGNED BY: EB	
CHECKED BY: EB		PROJECT NO: 04-468	
FILE NAME: 04-468.DWG		EXPIRES: 6-30-06	
SCALE		SHEET	
HORIZONTAL: 1" = 30'		VERTICAL: 1" = 3'	
2 OF 3 SHEETS		307V 903	

BRENNER & ASSOCIATES, INC.

LAND SURVEYORS

3014 W. CHARLESTON BLVD. SUITE 100 LAS VEGAS, NEVADA 89102

PHONE (702) 877-0317 FAX (702) 877-0358

EMAIL: EBRENNER@EARTHLINK.NET