

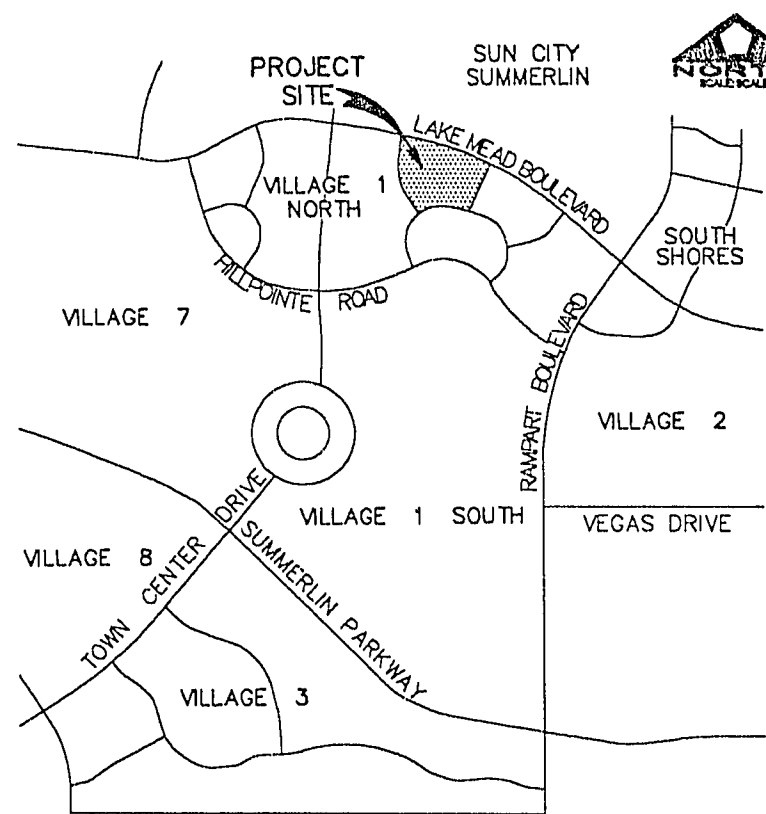


SUMMERLIN PARCEL H
Manhole Coordinate Listing

Manhole	Northing	Easting	Manhole	Northing	Easting
1	9705.092	7187.263	13	10390.418	6015.024
2	9781.132	7212.119	14	10076.295	6076.074
3	10040.941	7297.045	15	9799.429	6263.665
4	10278.729	7415.170	16	9880.726	6510.628
5	10398.485	7134.100	17	9878.191	6772.711
6	10241.757	7056.243	18	10324.277	6278.916
7	10485.829	6898.342	19	10120.496	6358.186
8	10299.104	6805.583	20	10151.761	6606.223
9	10563.286	6657.672	21	10107.217	6953.377
10	10392.245	6572.705	22	10307.585	7558.975
11	10651.735	6325.109	LM-18	10387.063	7597.294
12	10703.636	6080.555			

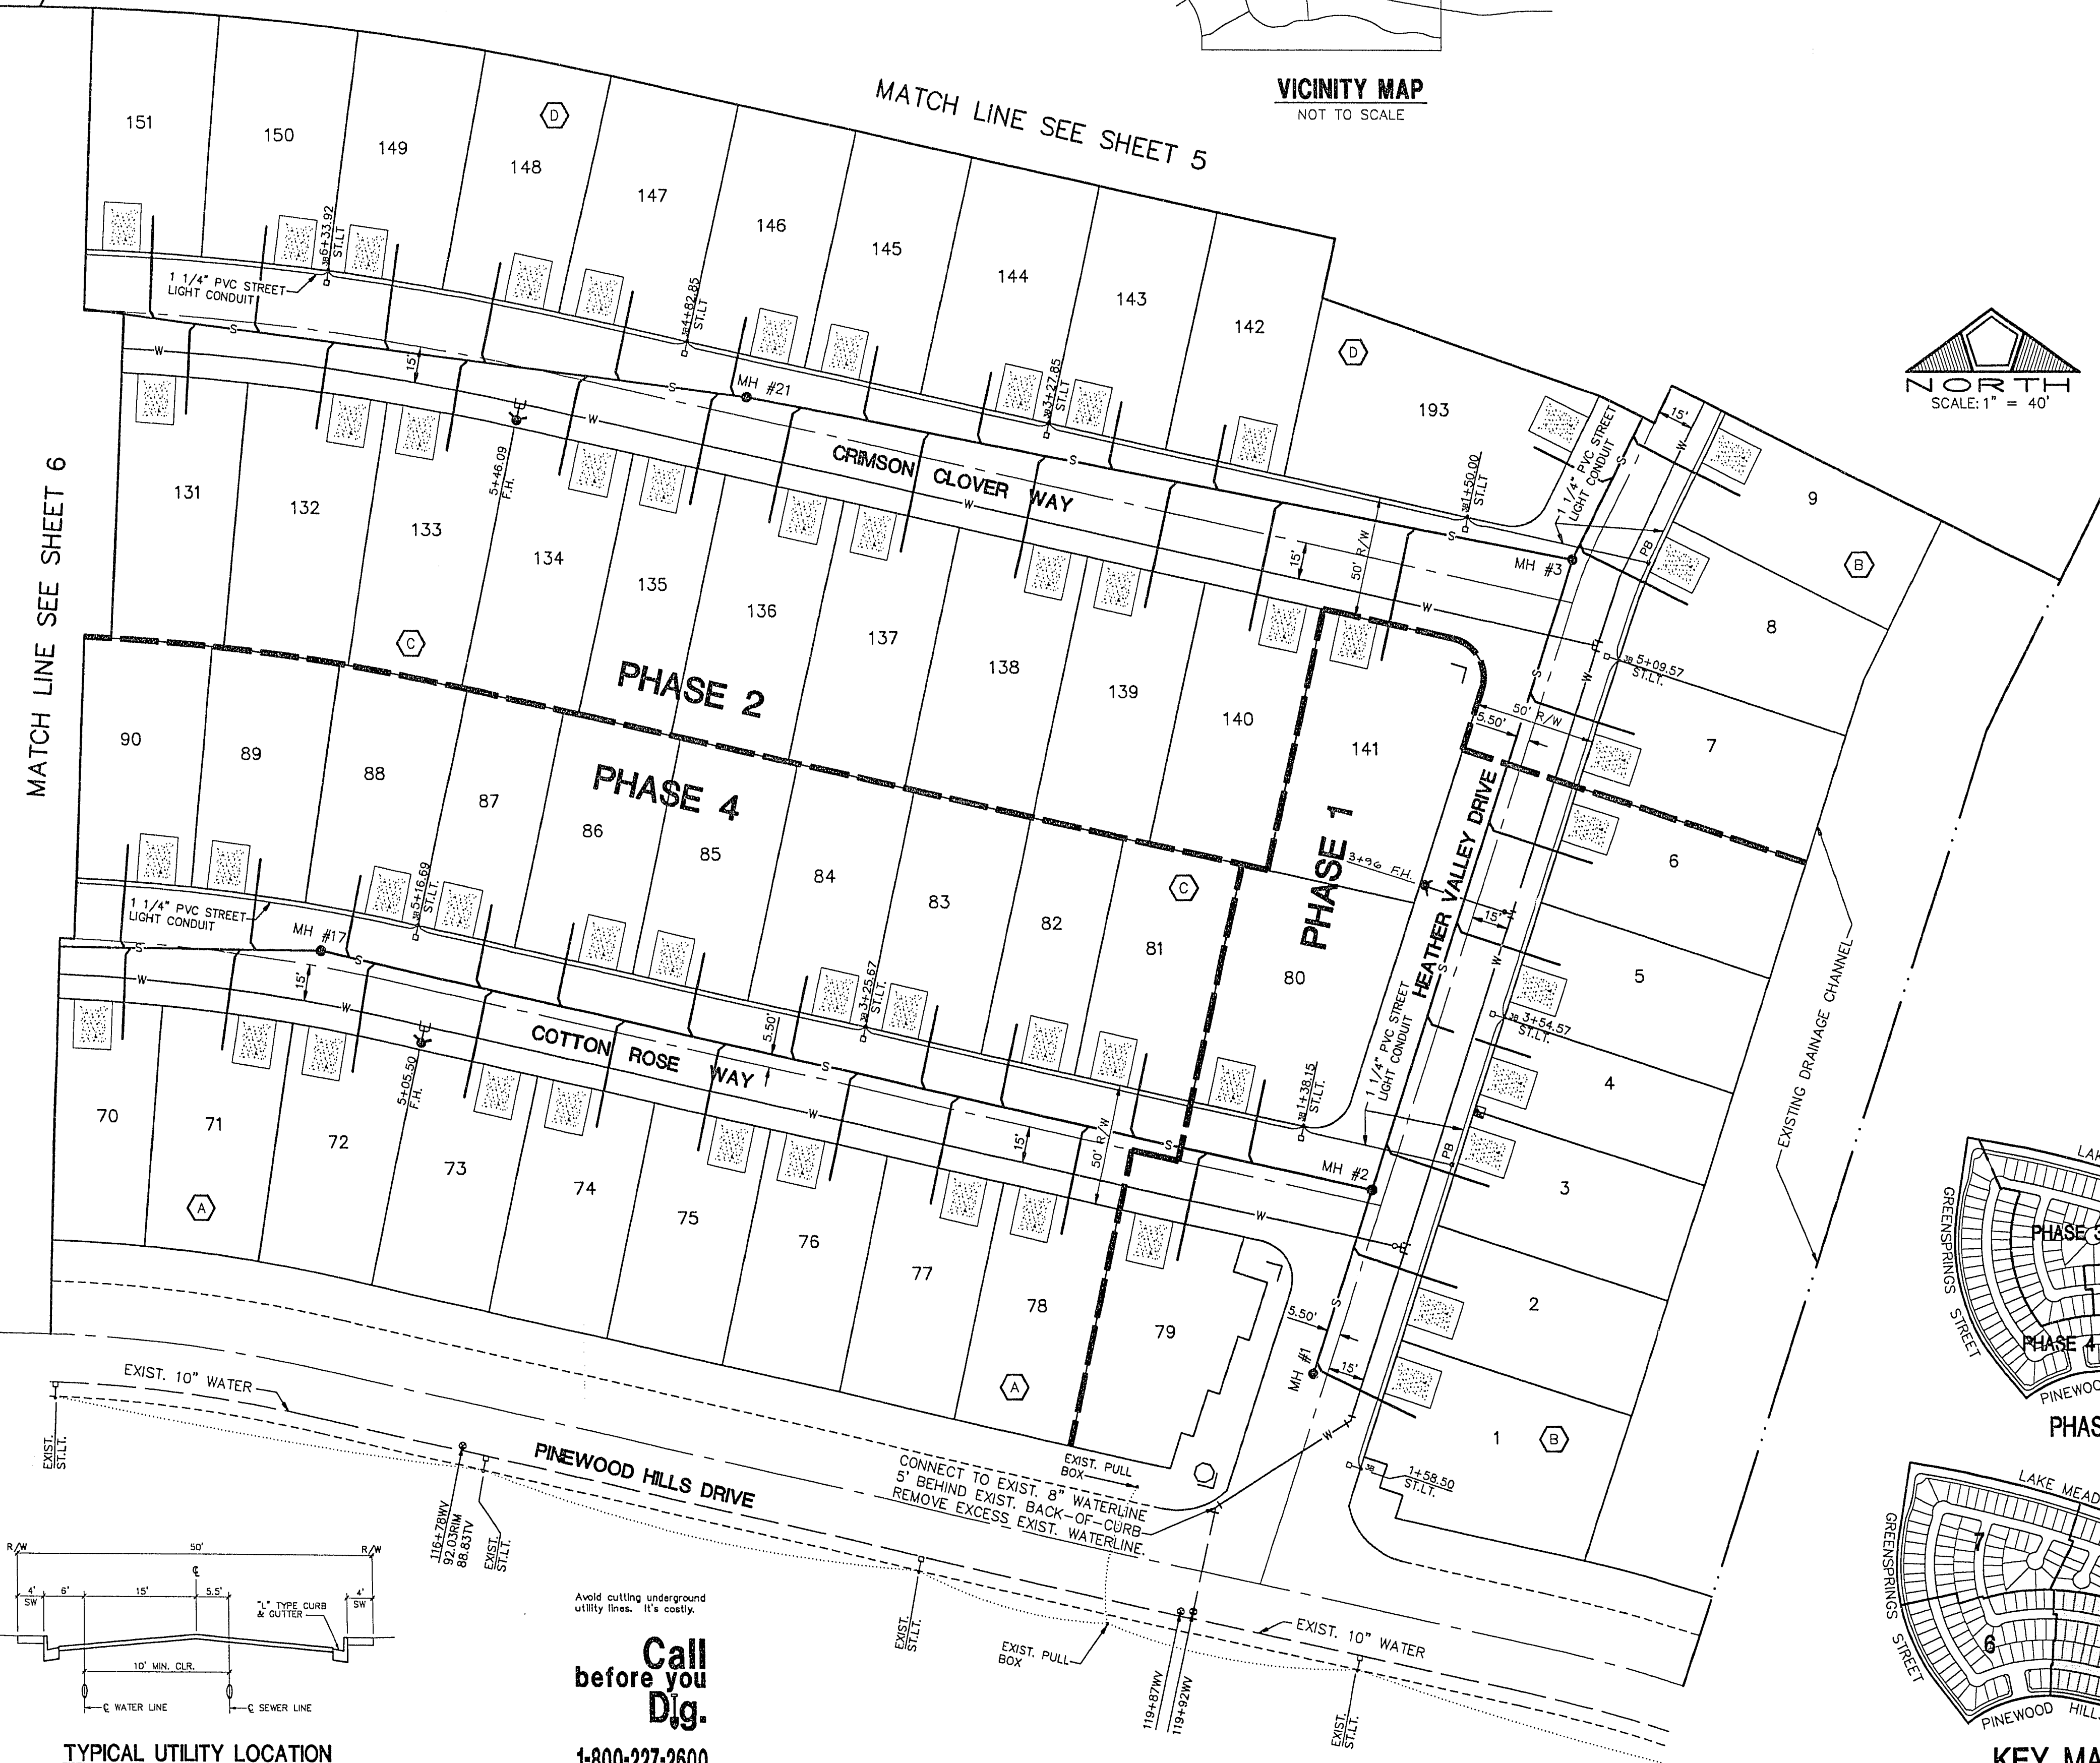

VICINITY MAP
NOT TO SCALE

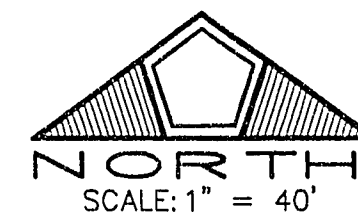

UTILITY LEGEND

L	6" D-3 STREET NAME SIGN
O	30" STOP SIGN
HEIGHT WATTAGE	STREET LIGHT
□	ELECTRICAL SERVICE & RCOC
■	#3 1/2 PULL BOX
⊕	FIRE HYDRANT
—S—	SEWER LINE W/ MANHOLE
—W—	WATER LINE W/ GATE VALVE
▨	CONCRETE DRIVEWAY

STREET LIGHT NOTE


ALL HAND HOLE COVERS MUST BE INSTALLED, POLE CAPS POURED, AND PULL BOX LIDS BOLTED DOWN PRIOR TO ENERGIZING CIRCUIT. ALL WIRE MUST HAVE THW INSULATION.

APPROVALS


FOR WATER
SEE SHEETS 21-29

LAS VEGAS VALLEY FIRE DEPARTMENT DATE _____
CITY OF LAS VEGAS FIRE DEPARTMENT DATE _____


NEVADA POWER COMPANY DATE _____
NOTE: THIS APPROVAL IS FOR THE PLACEMENT AND CLEARANCE OF STREET LIGHT AND SIGNAL LIGHT INSTALLATIONS ONLY.

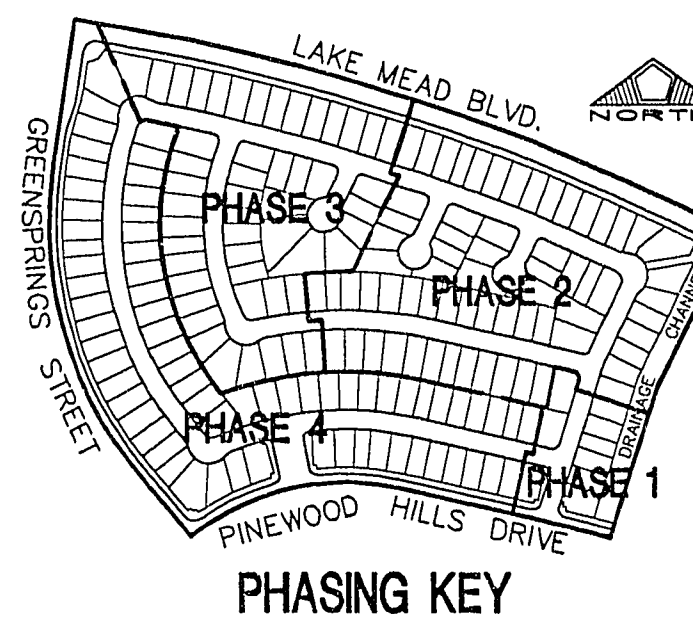

PHASING KEY

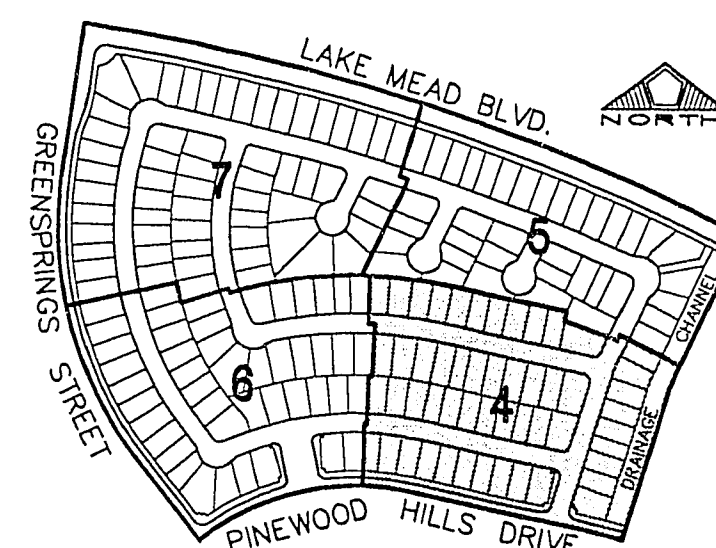

KEY MAP

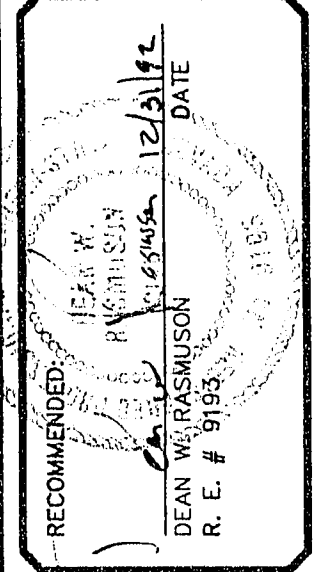

DATE:	12/22/09
DRAWN BY:	CWC
DESIGNED BY:	MR
CHECKED BY:	DWR
JOB NO.:	00301020
SCALE:	1" = 40'

PENTACORE
Engineering, Inc.
6753 West Charleston Boulevard
Las Vegas, Nevada 89102
(702) 258-0115

LEWIS HOMES OF NEVADA
WILLOW TREE
UTILITY PLAN 1

10-26-73 3071-4242