

MATCH LINE SEE SHEET 7

MATCH LINE SEE SHEET 4

EXIST. 13 LF OF 10" WATER LINE WITH 10" GATE VALVE TO BE ABANDONED PER L.V.V.W.D. STANDARDS

EXIST. 30" WATER LINE

EXIST. CURB & GUTTER
EXIST. PAVEMENT

EXIST. 10" WATER STUB TO WEST


SEWER & GAS LINES NOT SHOWN
LANDSCAPING, VILLAGE WALL & SIDEWALK BY OTHERS

EXIST. IRRIGATION SLEEVES

EXIST. IRRIGATION SLEEVES

Avoid cutting underground utility lines. It's costly.


Call before you Dig.
1-800-227-2600
UNDERGROUND SERVICE ALERT (USA)

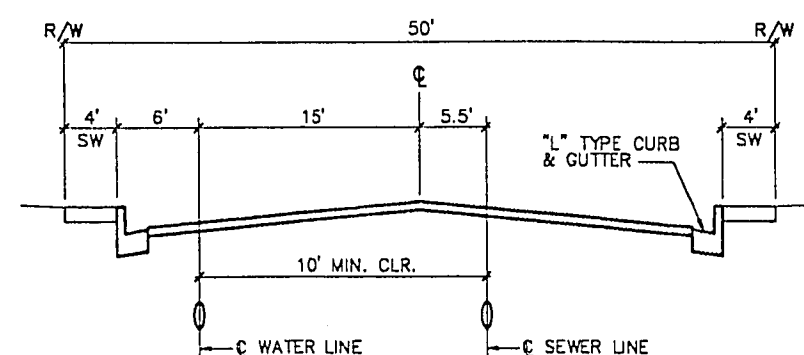


TYPICAL UTILITY LOCATION
(NOT TO SCALE)

UTILITY LEGEND

- 6" D-3 STREET NAME SIGN
- 30" STOP SIGN
- STREET LIGHT
- ELECTRICAL SERVICE & ROOC
- #3 1/2 PULL BOX
- FIRE HYDRANT
- SEWER LINE W/ MANHOLE
- WATER LINE W/ GATE VALVE
- CONCRETE DRIVEWAY

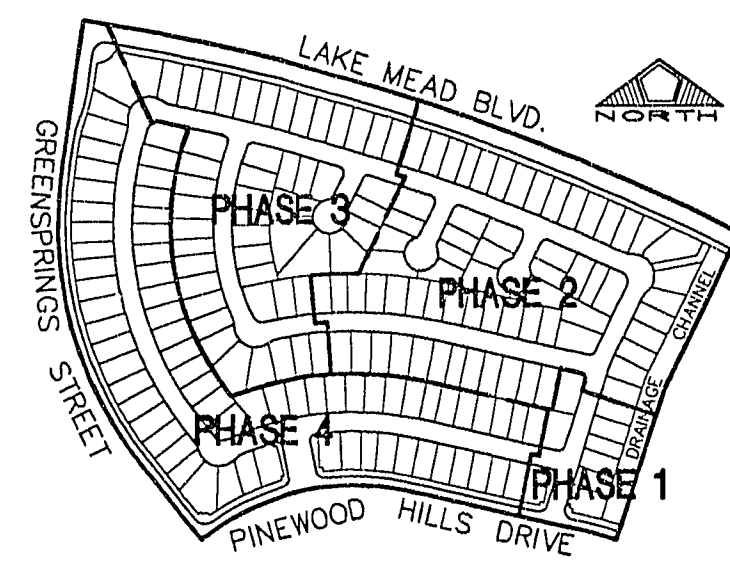

PHASING KEY

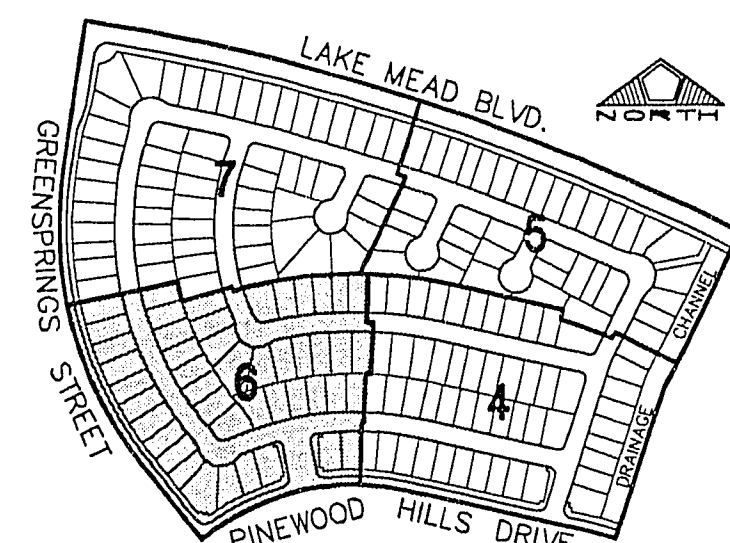

KEY MAP

APPROVALS

FOR WATER
SEE SHEETS 21-29

LAS VEGAS VALLEY WATER DISTRICT DATE _____

CITY OF LAS VEGAS FIRE DEPARTMENT DATE _____

NEVADA POWER COMPANY DATE _____

NOTE: THIS APPROVAL IS FOR THE PLACEMENT AND CLEARANCE OF STREET LIGHT AND SIGNAL LIGHT INSTALLATIONS ONLY.

SUMMERLIN PARCEL H Manhole Coordinate Listing					
Manhole	Northing	Easting	Manhole	Northing	Easting
1	9705.092	7187.263	13	10390.418	6015.024
2	9781.132	7212.119	14	10076.295	6076.074
3	10040.941	7287.045	15	9799.429	6263.665
4	10278.729	7415.170	16	9880.726	6510.828
5	10398.485	7134.100	17	9878.191	6772.711
6	10241.757	7056.243	18	10324.277	6278.916
7	10485.829	6898.342	19	10120.498	6358.186
8	10299.104	6805.583	20	10151.761	6606.223
9	10563.286	6657.672	21	10107.217	6953.377
10	10392.245	6572.705	22	10307.585	7558.975
11	10651.735	6325.109			7597.294
12	10703.636	6080.555	LM-18	10387.063	

RECOMMENDED
DATE: 12/21/92
DRAWN BY: CWC
DESIGNED BY: MR
CHECKED BY: DW
JOB NO.: 00301020
SCALE: 1" = 40'

PENTACORE
Engineering, Inc.
6763 West Charleston Boulevard
Las Vegas, Nevada 89102
(702) 258-0115

LEWIS HOMES OF NEVADA
WILLOW TREE
UTILITY PLAN III

SHEET
6
OF 29