
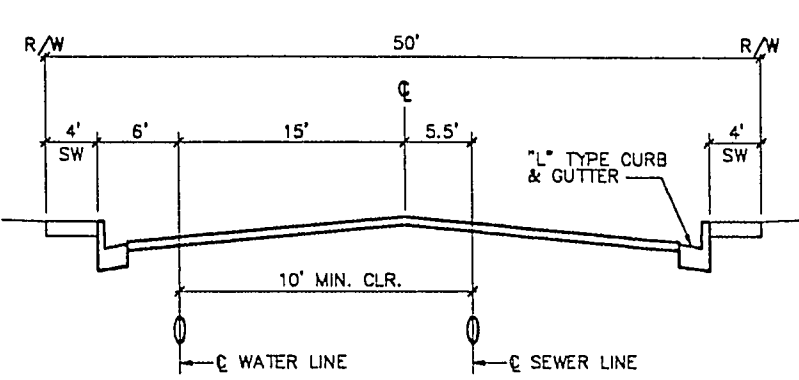
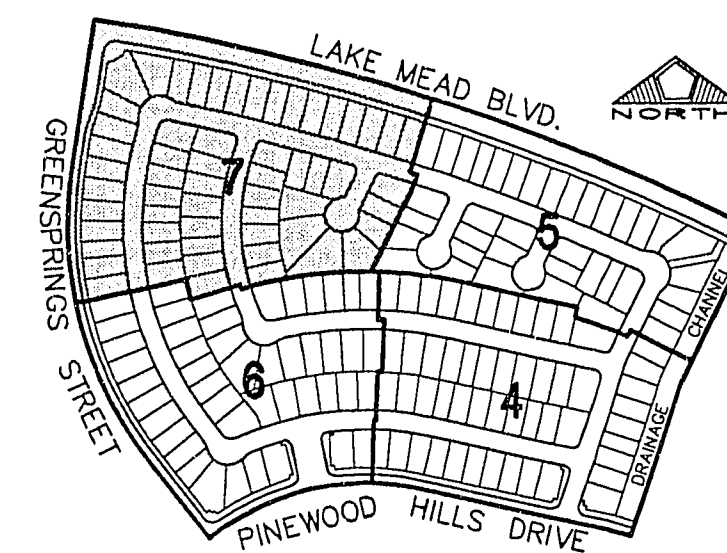
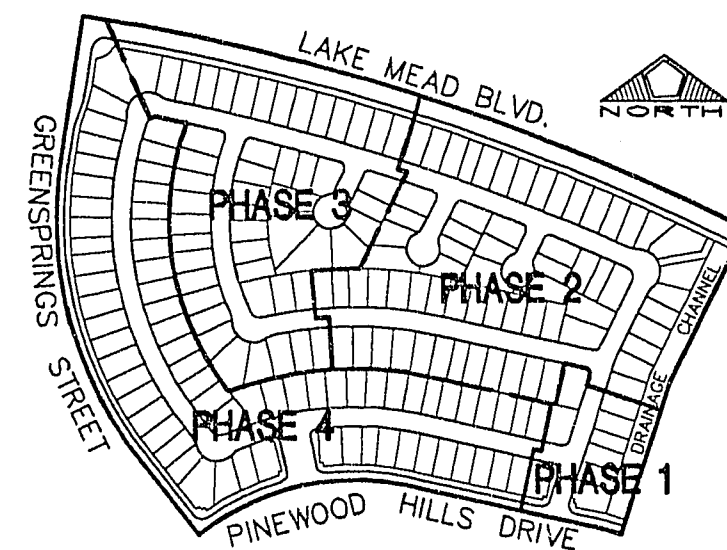


SUMMERLIN PARCEL H
Manhole Coordinate Listing

Manhole	Northing	Easting	Manhole	Northing	Easting
1	9705.092	7187.263	9	10563.286	6657.672
2	9781.132	7212.119	10	10392.245	6572.705
3	10040.941	7297.045	11	10651.735	6325.109
4	10278.729	7415.170	12	10703.636	6080.555
5	10398.485	7134.100	13	10390.418	6015.024
6	10241.757	7056.243	14	10076.295	6076.074
7	10485.829	6898.342	15	9799.429	6263.665
8	10299.104	6805.583	16	9880.726	6510.628
			17	9878.191	6772.711
			18	10324.277	6278.916
			19	10120.496	6358.186
			20	10151.761	6606.223
			21	10107.217	6953.377
			22	10307.585	7558.975
			LM-18	10387.063	7597.294

UTILITY LEGEND

	6" D-3 STREET NAME SIGN
	30" STOP SIGN
	STREET LIGHT
	ELECTRICAL SERVICE & RCOO
	#3 1/2 PULL BOX
	FIRE HYDRANT
	SEWER LINE W/ MANHOLE
	WATER LINE W/ GATE VALVE
	CONCRETE DRIVEWAY

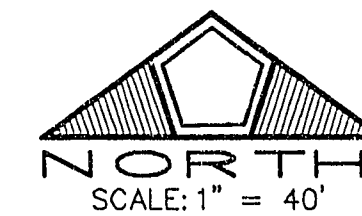

TYPICAL UTILITY LOCATION
(NOT TO SCALE)

Avoid cutting underground utility lines. It's costly.

Call before you Dig.
1-800-227-2600
UNDERGROUND SERVICE ALERT (USA)

APPROVALS

LAS VEGAS VALLEY FIRE DISTRICT
CITY OF LAS VEGAS FIRE DEPARTMENT
DATE

NEVADA POWER COMPANY
NOTE: THIS APPROVAL IS FOR THE PLACEMENT AND CLEARANCE OF STREET LIGHT AND SIGNAL LIGHT INSTALLATIONS ONLY.
DATE

NO.	DESCRIPTION	DATE	APP'D.

RECOMMENDED
DATE
DESIGNED BY: [Signature]
CHECKED BY: [Signature]
JOB NO.: 0301020
SCALE: 1" = 40'

DATE: 12/21/92
DRAWN BY: CMC
DESIGNED BY: MK
CHECKED BY: DWR
JOB NO.: 0301020
SCALE: 1" = 40'

PENTACORE Engineering, Inc.
6763 West Charleston Boulevard
Las Vegas, Nevada 89102
(702) 258-0115

LEWIS HOMES OF NEVADA
WILLOW TREE
UTILITY PLAN IV

SHEET
7
OF 29

10-26-76 307Y-4242