
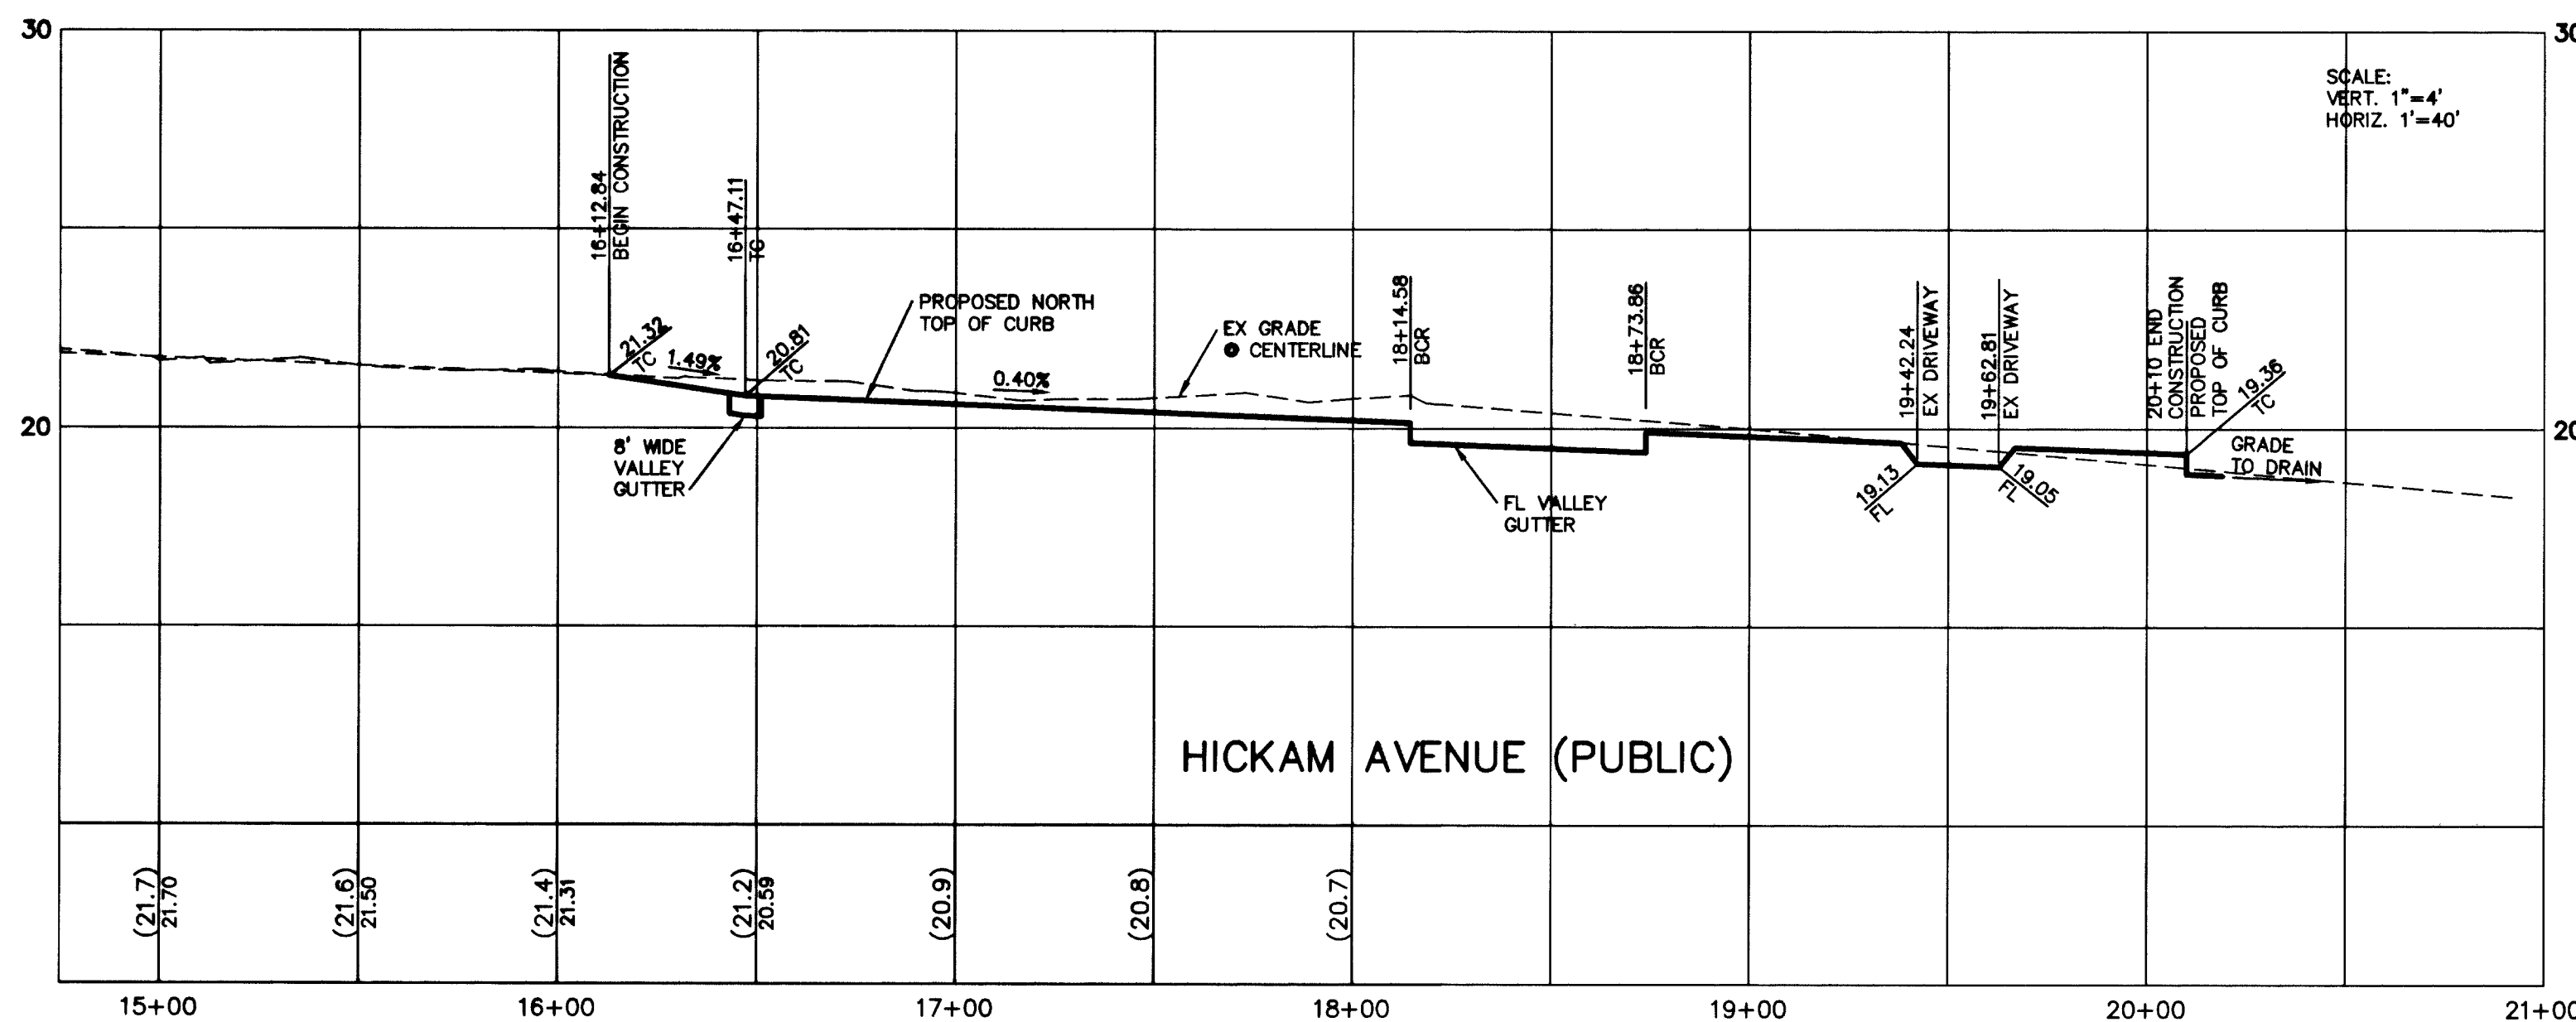


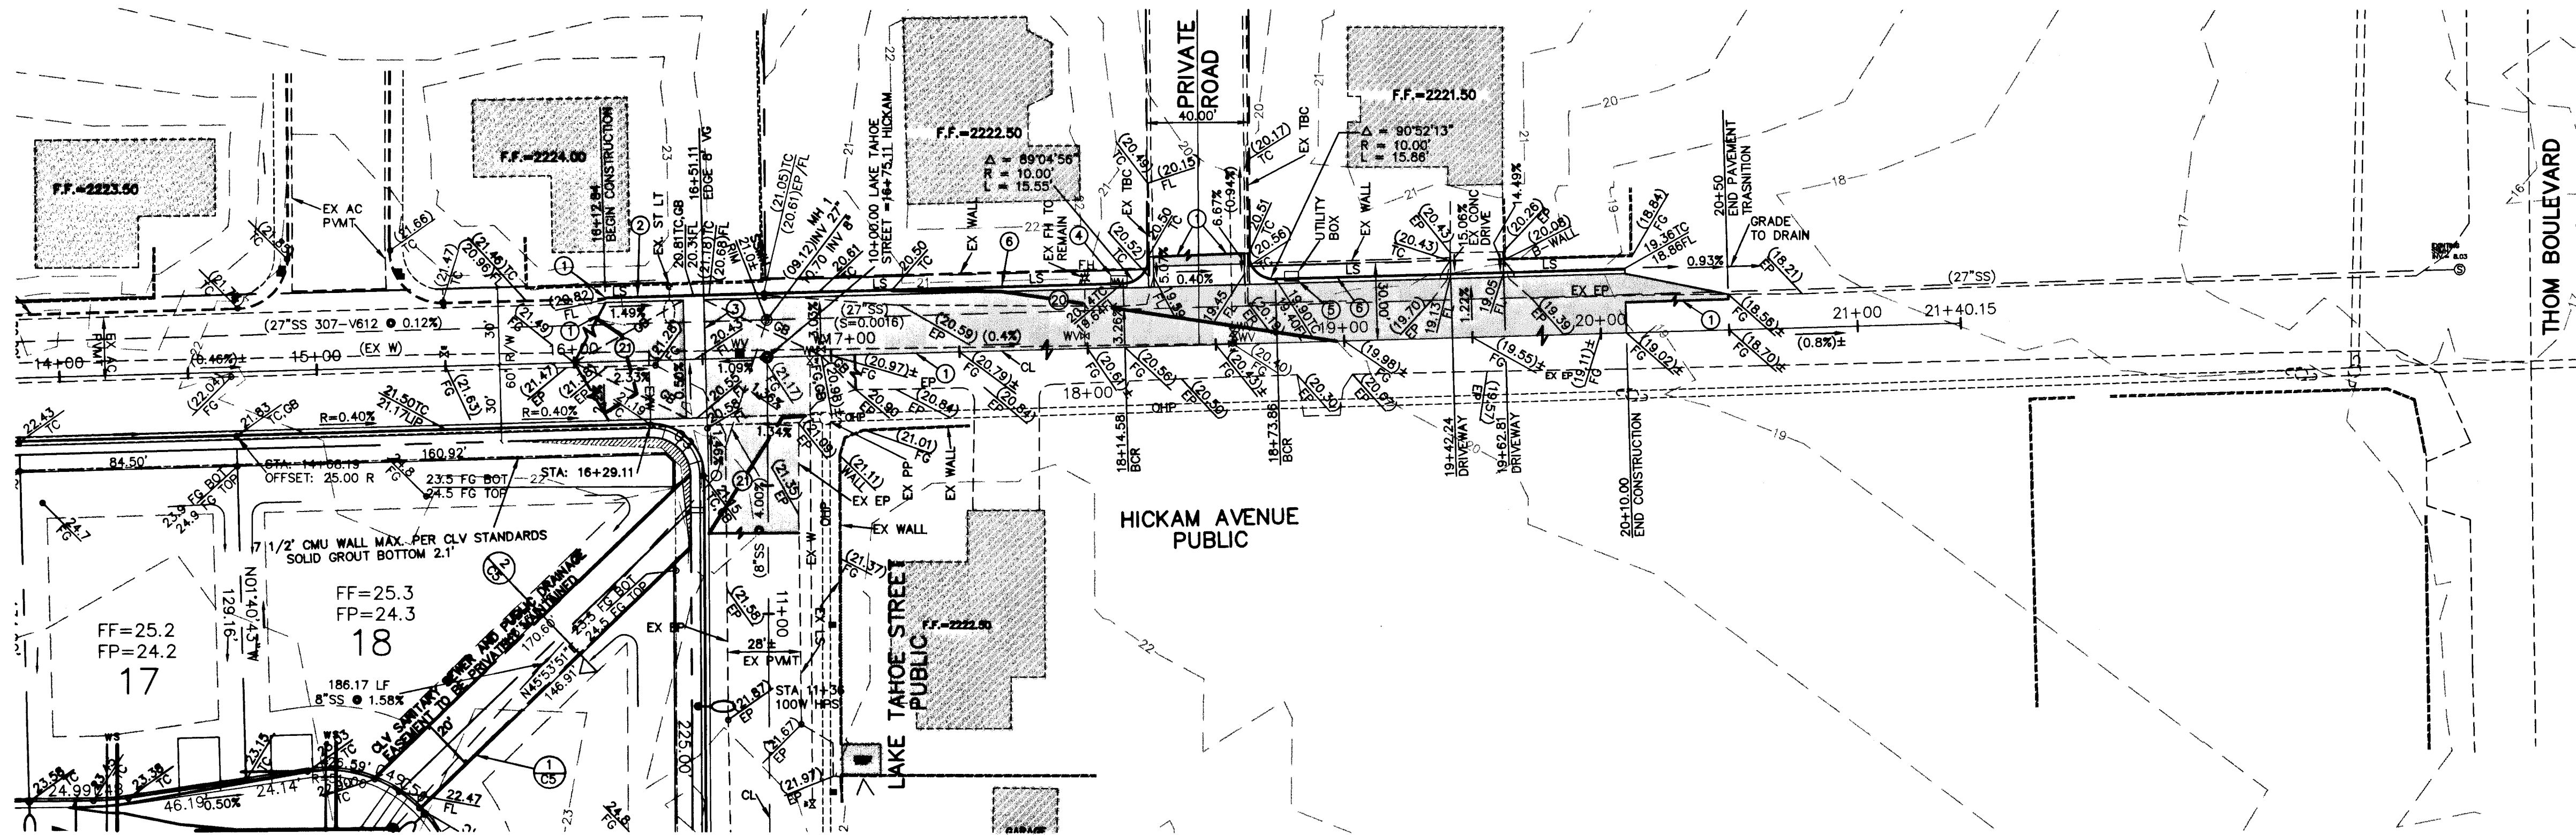


AVOID CUTTING UNDERGROUND UTILITY LINES. IT'S COSTLY.
Call before you Dig—
1-800-227-2600
UNDERGROUND SERVICE ALERT (USA)

AVOID OVERHEAD POWER LINE CONTACT
Call before you OVERHEAD
1-702-227-2929
NEVADA POWER ENVIRONMENT AND SAFETY SERVICES DEPARTMENT

BENCHMARK
CITY OF LAS VEGAS # 46, 1LV00 12N4, BEING A RIVET AND PLATE IN WATER METER PAD, 5401 W. ALEXANDER ROAD AT BRADLEY ROAD.
N.A.V.D. 88 DATUM ELEVATION 681.6670 METERS (2236.4358 FEET).

BASIS OF BEARINGS
NORTH 00°10'18" WEST BEING THE BEARING OF THE WEST LINE OF THE NORTHWEST QUARTER OF SECTION 1, TOWNSHIP 20S, RANGE 60E, M.D.M., WEST LINE ALSO BEING THE CENTERLINE OF BRADLEY ROAD AS SHOWN ON BOOK 79 PAGE 9 OF PLATS OFFICIAL RECORDS, CLARK COUNTY, NEVADA.

- NOTES**
- 1 SAWCUT AND MATCH EXISTING GRADE
 - 2 REMOVE AND REPLACE 'L' CURB AT NEW GRADE
 - 3 CONSTRUCT 8' WIDE VALLEY GUTTER PER STANDARD DRAWING NO. 228
 - 4 RELOCATE EXISTING WATER METER IF NECESSARY
 - 5 RELOCATE EXISTING UTILITY BOX IF NECESSARY
 - 6 CONSTRUCT 'L' CURB PER STANDARD DRAWING NO. 216

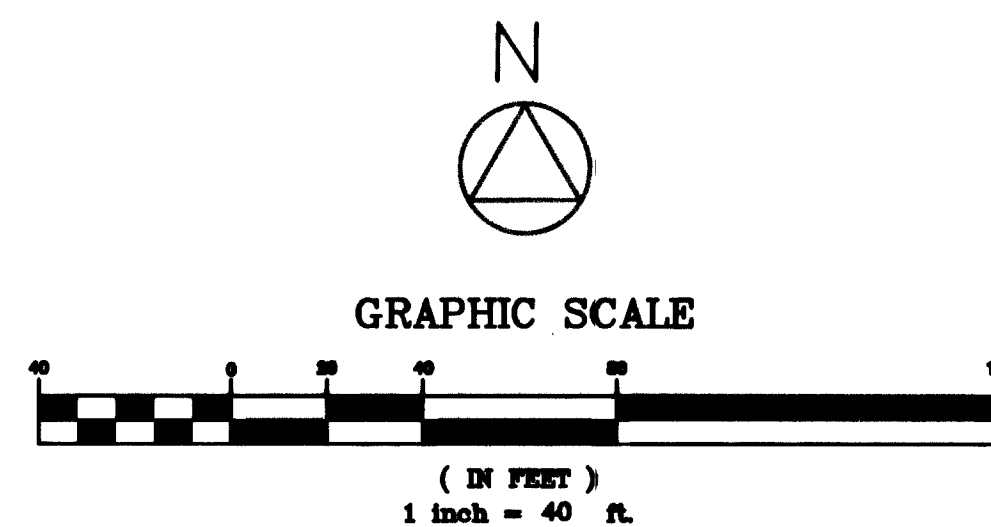

DELTA ENGINEERING ASSUMES NO RESPONSIBILITY FOR EXISTING UTILITY LOCATIONS AND ELEVATIONS. THE UTILITIES SHOWN ON THIS DRAWING HAVE BEEN PLOTTED FROM THE BEST AVAILABLE INFORMATION. IT IS, HOWEVER, THE CONTRACTOR'S RESPONSIBILITY TO FIELD VERIFY THE LOCATION AND ELEVATION OF ALL UTILITIES PRIOR TO THE COMMENCEMENT OF ANY CONSTRUCTION. CONTRACTOR TO FIELD VERIFY ALL EXISTING SITE CONDITIONS PRIOR TO CONSTRUCTION. IF A CONFLICT EXISTS BETWEEN WHAT IS SHOWN ON THESE DRAWINGS AND WHAT EXISTS IN THE FIELD, THE CONTRACTOR IS TO NOTIFY THE ARCHITECT, OWNER'S REPRESENTATIVE OR ENGINEER IMMEDIATELY.

LEGEND	
EXISTING	PROPOSED
--- RIGHT-OF-WAY	--- RIGHT-OF-WAY
--- PROPERTY LINE	--- PROPERTY LINE
--- CENTERLINE	--- CENTERLINE
--- WATER LINE	--- WATER LINE
--- GAS LINE	--- GAS LINE
--- STORM DRAIN	--- STORM DRAIN
--- POWER LINE/POWER POLE	--- POWER LINE/POWER POLE
--- TELEPHONE LINE	--- TELEPHONE LINE
--- FIRE HYDRANT	--- FIRE HYDRANT
--- WATER VALVE	--- WATER VALVE
--- METER/PULL BOXES	--- METER/PULL BOXES
--- REDUCER	--- REDUCER
--- MANHOLE	--- MANHOLE
--- CLEANOUT	--- CLEANOUT
--- CONTOUR	--- CONTOUR
--- A.C. PAVING	--- A.C. PAVING
--- TYPE 'L' CURB & GUTTER	--- TYPE 'L' CURB & GUTTER
--- TYPE 'A' CURB	--- TYPE 'A' CURB
--- CONCRETE	--- CONCRETE
--- RETAINING WALL	--- RETAINING WALL
--- CHAIN LINK FENCE	--- CHAIN LINK FENCE
--- GRADE BREAK	--- GRADE BREAK
--- WIRE FENCE	--- WIRE FENCE
--- FINISH FLOOR	--- FINISH FLOOR
--- C.O. INV.	--- C.O. INV.
--- FLOW LINE	--- FLOW LINE
--- FINISH GRADE	--- FINISH GRADE
--- TOP OF CURB	--- TOP OF CURB
--- TOP OF WALL	--- TOP OF WALL
--- GATE	--- GATE
--- SIGN	--- SIGN
--- STREET LIGHTS	--- STREET LIGHTS
100 W.H.P.S.	100 W.H.P.S.
150 W.H.P.S.	150 W.H.P.S.
200 W.H.P.S.	200 W.H.P.S.
250 W.H.P.S.	250 W.H.P.S.

DRAWN BY: ACADD	DESIGNED BY: WSC	CHECKED BY: PFB	PROJECT NO: 98062	SCALE: 1"=40'
SHEET C11-A				11 OF 14 SHEETS
DRAWING NO. 1074-4670				
EMERALD DEVELOPMENT 1304 ALPINE DRIVE BOULDER CITY, NEVADA 89005 (702) 293-1819				DELTA ENGINEERING 3137 MEADE AVENUE, SUITE D LAS VEGAS, NV 89102 (702) 364-9777 FAX (702) 364-9333
HICKAM AVENUE PLAN AND PROFILE				WILLOWDALE PARK UNIT I AND II
SHEET				TITLE
E-MAIL: ENGRDELTA@AOL.COM				REVISION