

Call before you Dig
1-702-455-7511
CLARK COUNTY TRAFFIC OPERATIONS
AND
1-702-229-8611
LAS VEGAS AREA COMPUTERIZED TRAFFIC SYSTEM

Call before you Overhead
1-702-227-2829



Call before you Dig
1-800-227-2800

NOTES
1. ALL PRIVATE STREETS AND PRIVATE DRIVES ARE P.U.E., PUBLIC SEWER EASEMENTS, AND PUBLIC DRAINAGE EASEMENTS TO BE PRIVATELY MAINTAINED BY HOMEOWNERS ASSOCIATION.
2. SEE SHEET UT7 FOR S.S. MANHOLE SCHEDULE, LEGENDS, DETAILS, NOTES, AND QUANTITY ESTIMATE.

CONTRACTOR NOTE
CONTRACTOR SHALL VERIFY HORIZONTAL AND VERTICAL LOCATION OF EXISTING IMPROVEMENTS UTILITIES AND NOTIFY THE DESIGN ENGINEER IMMEDIATELY OF ANY DISCREPANCIES PRIOR TO CONSTRUCTION.

BASIS OF BEARINGS
THE BASIS OF BEARINGS FOR THIS PROJECT IS NORTH 00°01'18" EAST BEING THE EAST LINE OF THE NORTHWEST QUARTER (ONE 1/4) OF THE SECTION 24, TOWNSHIP 18 SOUTH, RANGE 59 EAST, W.D.M., CLARK COUNTY, NEVADA, AS SHOWN ON A RECORD OF SURVEY ON FILE IN THE CLARK COUNTY, NEVADA, RECORDER'S OFFICE IN FILE 123 AT PAGE 32.

PROJECT BENCHMARK
DATUM: NORTH AMERICAN VERTICAL DATUM OF 1988 (NAV88)
CITY OF LAS VEGAS BENCHMARK: BLV99-1335S
NAVD88 ELEVATION: 868.606 METERS (2853.03 FEET)
RIVET AND PLATE IN CONCRETE CYLINDER NW CORNER OF HUALAPAI AND ELKHORN
NOTE: WHEN THE SURVEYING FOR THIS PROJECT BEGAN, THE ABOVE REFERENCED BENCHMARK BLV99-1335S WAS NOT PUBLISHED. THE BASIS FOR THE DATUM FOR THIS PROJECT IS SHOWN ON RECORD OF SURVEY FILE 124 IN THE CLARK COUNTY BENCHMARK 1000-8N6, WHICH AT THE TIME OF THE ORIGINAL SURVEY (PRIOR TO THE CURRENT 2003 COUNTY BENCHMARK PUBLISHING) HAD AN ELEVATION OF 2584.61 FEET TO CONVERT THE CURRENT CITY OF LAS VEGAS BENCHMARK BLV99-1335S TO MATCH THE ORIGINAL PROJECT DATUM, 0.34' NEEDS TO BE ADDED TO THE ELEVATION OF 2853.03 FEET.

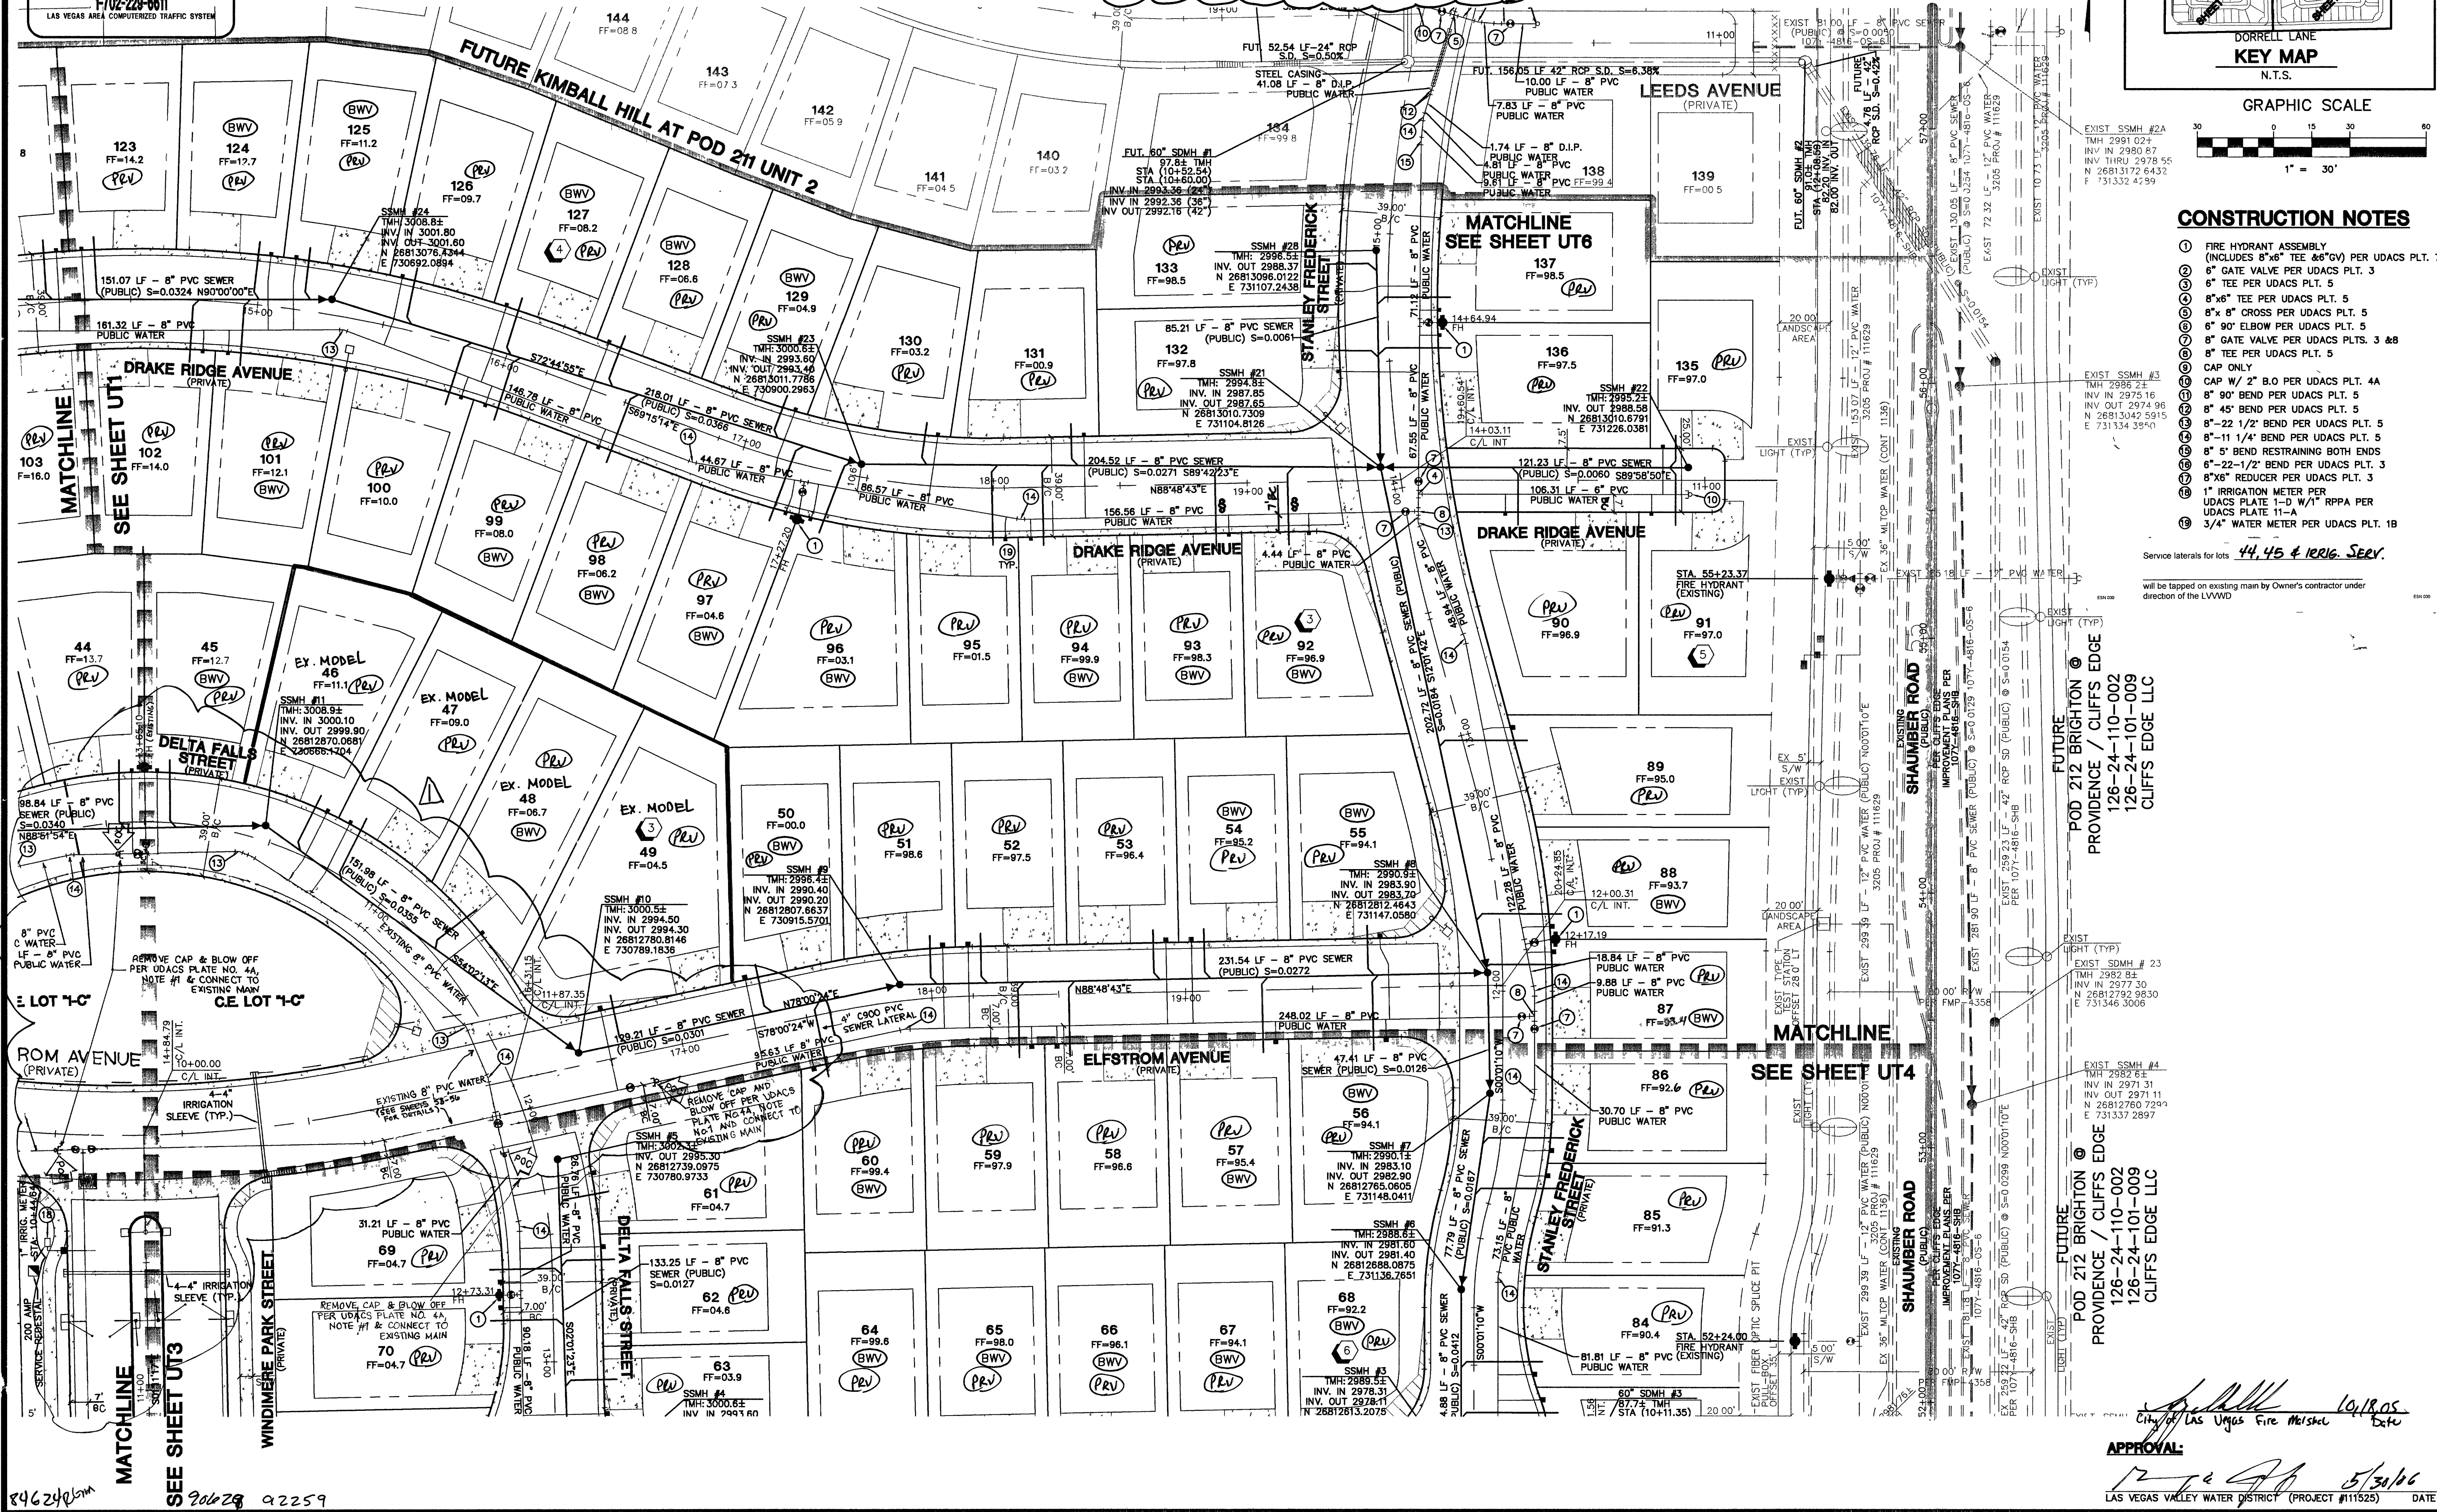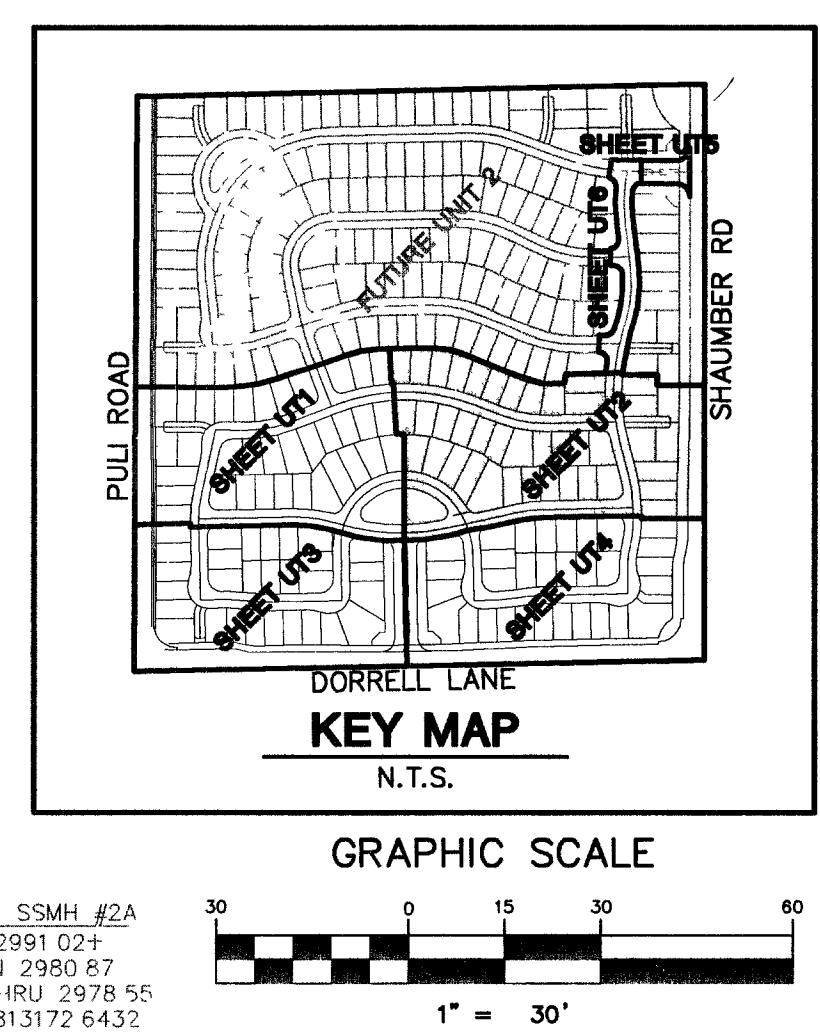

- CONSTRUCTION NOTES**
1. FIRE HYDRANT ASSEMBLY (INCLUDES 8"x8" TEE 45°/90°) PER UDACS PLT. 7
 2. 6" GATE VALVE PER UDACS PLT. 3
 3. 6" TEE PER UDACS PLT. 5
 4. 6"x6" TEE PER UDACS PLT. 5
 5. 6"x8" CROSS PER UDACS PLT. 5
 6. 6" 90° ELBOW PER UDACS PLT. 5
 7. 6" GATE VALVE PER UDACS PLTS. 3 & 8
 8. 6" TEE PER UDACS PLT. 5
 9. CAP ONLY
 10. CAP W/ 2" B.O. PER UDACS PLT. 4A
 11. 6" 90° BEND PER UDACS PLT. 5
 12. 6" 90° BEND PER UDACS PLT. 5
 13. 6"-22 1/2" BEND PER UDACS PLT. 5
 14. 6"-11 1/4" BEND PER UDACS PLT. 5
 15. 6" 5' BEND RESTRAINING BOTH ENDS
 16. 6"-22 1/2" BEND PER UDACS PLT. 3
 17. 6"x6" REDUCER PER UDACS PLT. 3
 18. 1" IRRIGATION METER PER UDACS PLATE 1-D W/1" RPPA PER UDACS PLATE 11-A
 19. 3/4" WATER METER PER UDACS PLT. 18
- Service laterals for lots 44, 45 & 100-102. SERV.
- will be tapped on existing main by Owner's contractor under direction of the LVVWD

CITY OF LAS VEGAS	
2727 SOUTH RAINBOW BOULEVARD LAS VEGAS, NEVADA 89146-5148 PH (702) 873-7550 FAX (702) 362-2597	
KIMBALL HILL 8 SUNSET WAY, SUITE 101 HENDERSON, NEVADA 89014 (702) 436-4582	
UTILITY PLAN 2	
WINDMERE / CLIFFS EDGE PROVIDENCE / CLIFFS EDGE POD 211 - UNIT 1	
DRAWN BY: TP	10/05
DESIGNED BY: TP	10/05
CHECKED BY: CRG	10/05
PROJECT NO: 9400-1	SCALE: 1"=30' HORIZ. N/A
APPROVAL: City of Las Vegas Fire Marshal LAS VEGAS VALLEY WATER DISTRICT (PROJECT #11525) DATE 5/31/06	
EXPIRES 06-30-07 SHEET 5 OF 52 SHEETS DRAWING NO. 10744888-1	