


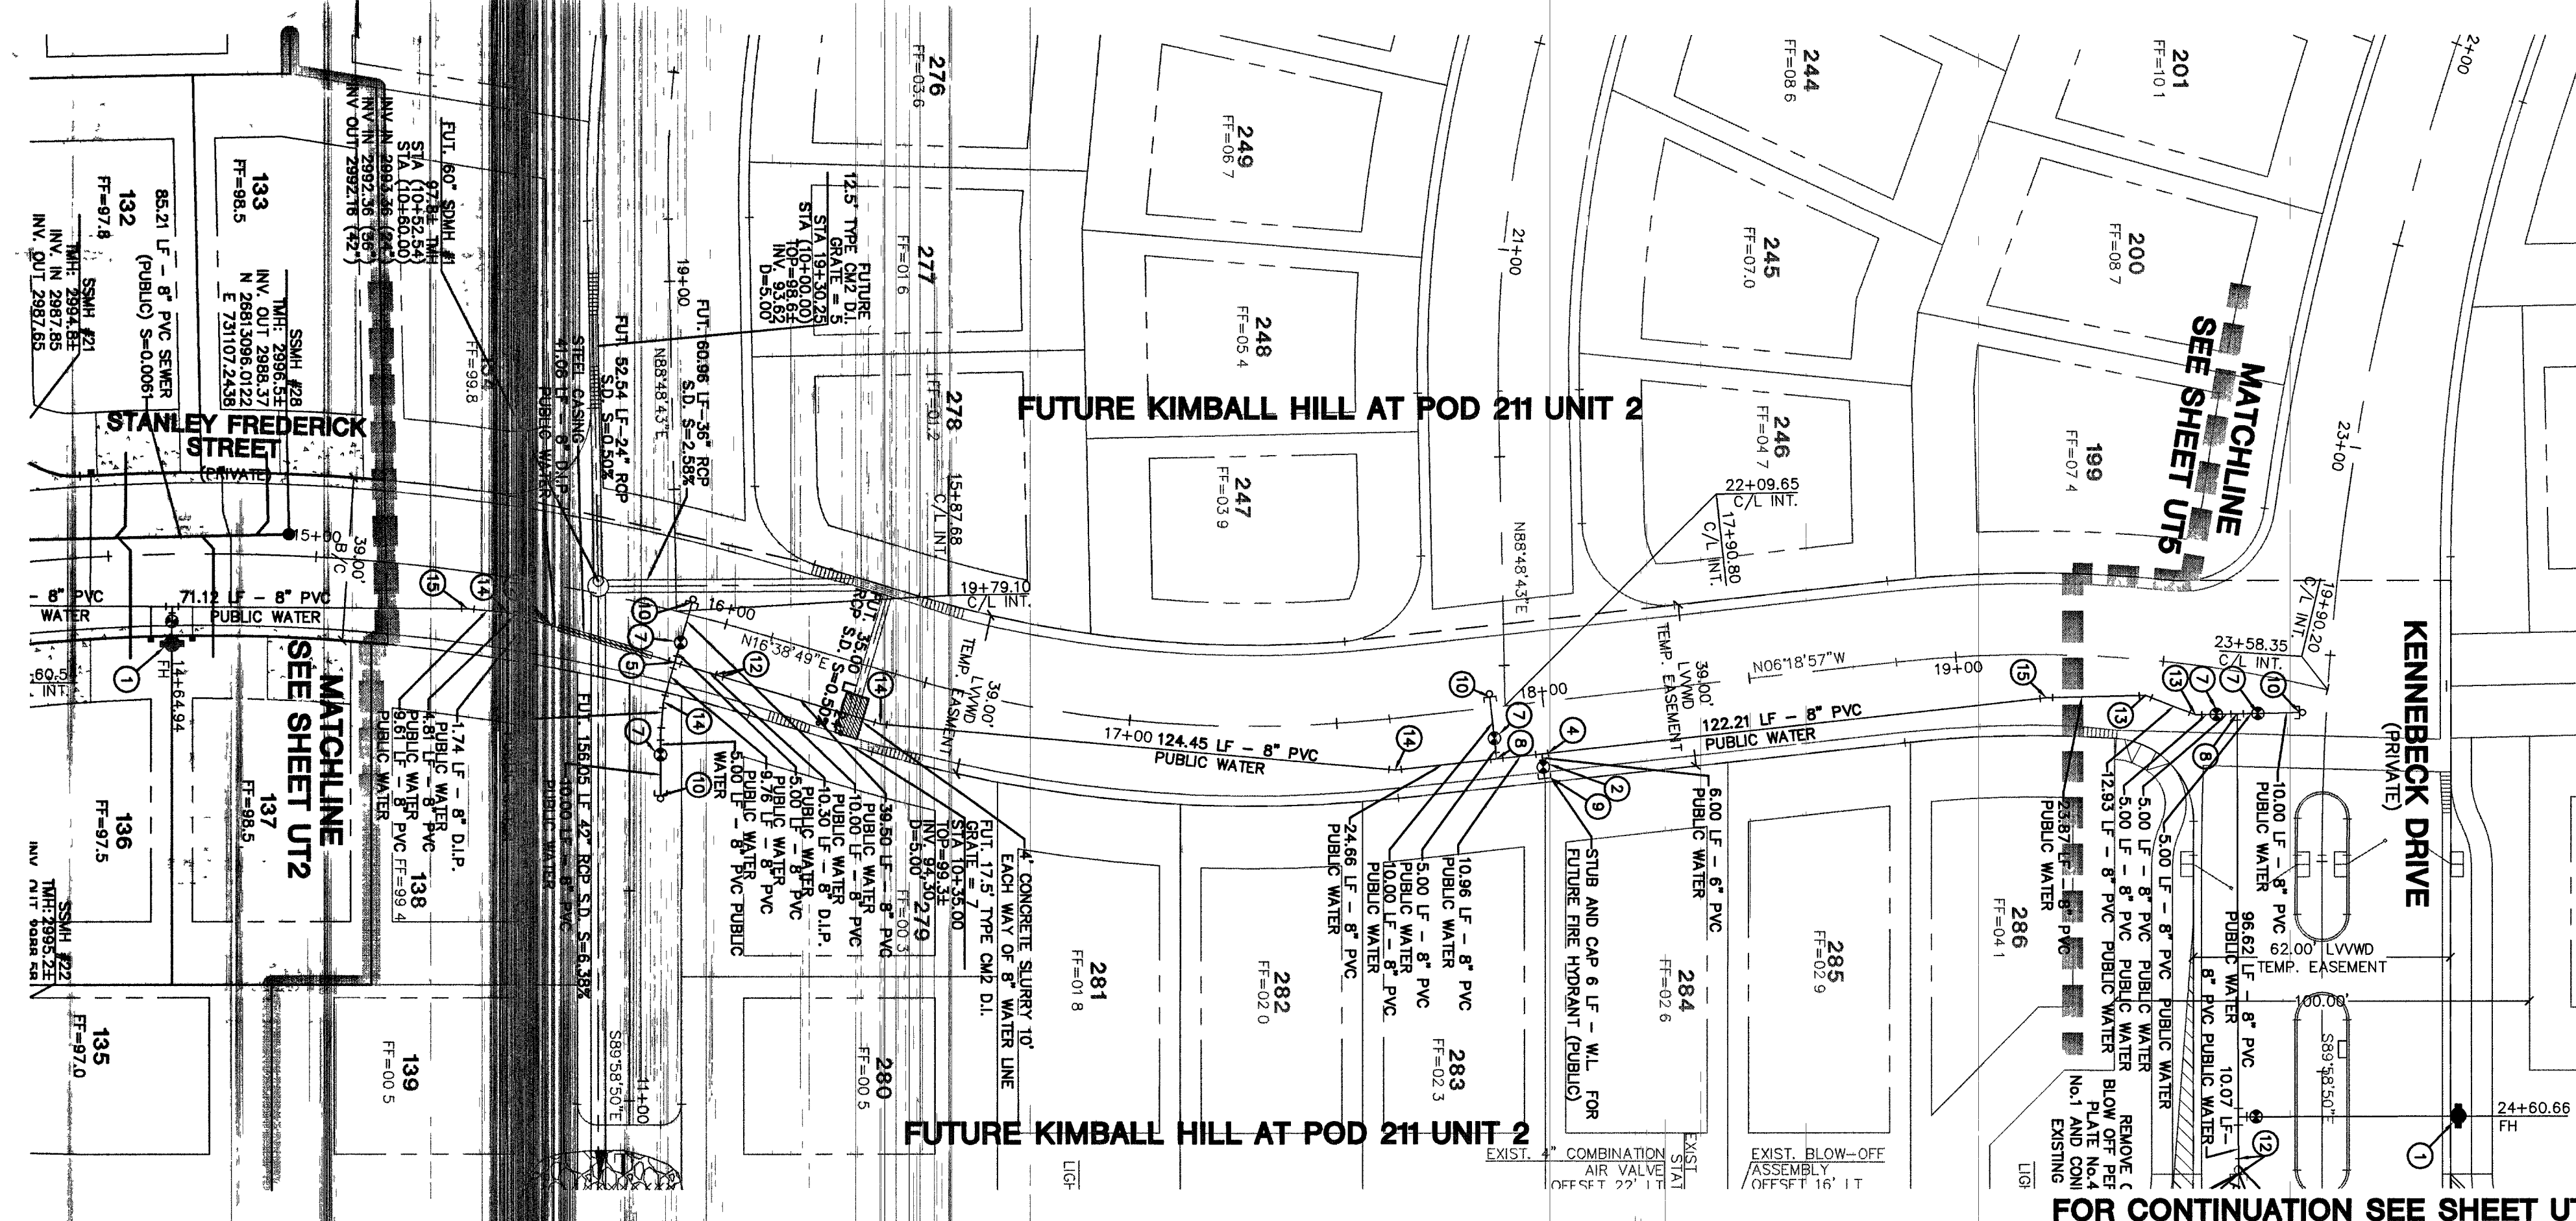

PROJECT BENCHMARK
 DATUM: NORTH AMERICAN VERTICAL DATUM OF 1988 (NAVD88)
 CITY OF LAS VEGAS BENCHMARK: BLV98:13SES
 NAVD88 ELEVATION: 869.608 METERS (2853.03 FEET)
 RIVET AND PLATE IN CONCRETE CYLINDER NW CORNER OF HUALAPAI AND ELKHORN

NOTE: WHEN THE SURVEYING FOR THIS PROJECT BEGAN, THE ABOVE REFERENCED BENCHMARK BLV98:13SES WAS NOT PUBLISHED. THE BASIS FOR THE DATUM FOR THIS PROJECT IS SHOWN ON RECORD OF SURVEY FILE 124, PAGE 94, CLARK COUNTY BENCHMARK 1000-586, WHICH AT THE TIME OF THE ORIGINAL SURVEY (PRIOR TO THE CURRENT 2003 COUNTY BENCHMARK PUBLISHING) HAD AN ELEVATION OF 2584.61 FEET. TO CONVERT THE CURRENT CITY OF LAS VEGAS BENCHMARK BLV98:13SES TO MATCH THE ORIGINAL PROJECT DATUM, 0.34' NEEDS TO BE ADDED TO THE ELEVATION OF 2853.03 FEET.


BASIS OF BEARINGS
 THE BASIS OF BEARINGS FOR THIS PROJECT IS NORTH 00°08'18" EAST BEING THE EAST LINE OF THE NORTHWEST QUARTER (NE 1/4) OF THE SECTION 24, TOWNSHIP 19 SOUTH, RANGE 58 EAST, M.D.M., CLARK COUNTY, NEVADA, AS SHOWN ON A RECORD OF SURVEY ON FILE IN THE CLARK COUNTY, NEVADA, RECORDER'S OFFICE IN FILE 123 AT PAGE 32.

CONTRACTOR NOTE
 CONTRACTOR SHALL VERIFY HORIZONTAL AND VERTICAL LOCATION OF EXISTING IMPROVEMENTS UTILITIES AND NOTIFY THE DESIGN ENGINEER IMMEDIATELY OF ANY DISCREPANCIES PRIOR TO CONSTRUCTION

Call before you Dig
 1-800-227-2800

Call before you Overhead
 1-702-227-2828

Call before you Underground
 1-702-455-7511
 CLARK COUNTY TRAFFIC OPERATIONS AND
 1-702-229-6811
 LAS VEGAS AREA COMPUTERIZED TRAFFIC SYSTEM

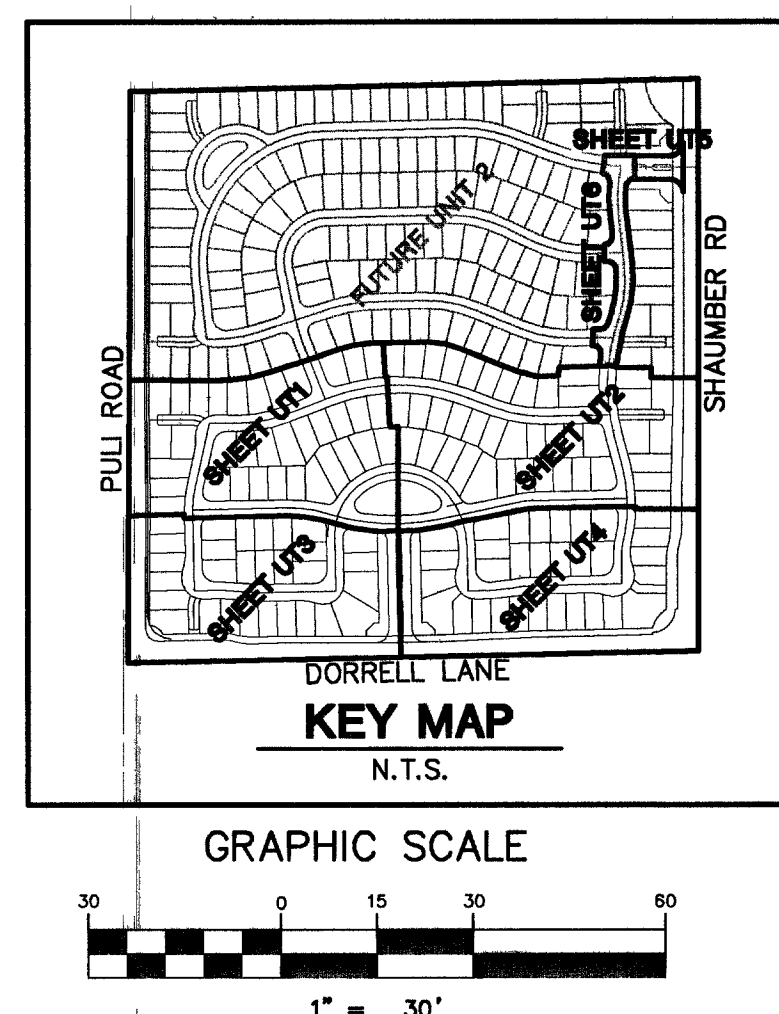


- CONSTRUCTION NOTES**
- ① FIRE HYDRANT ASSEMBLY (INCLUDES 8"x6" TEE & 6"GV) PER UDACS PLT. 7
 - ② 6" GATE VALVE PER UDACS PLT. 3
 - ③ 6" TEE PER UDACS PLT. 5
 - ④ 8"x6" TEE PER UDACS PLT. 5
 - ⑤ 8"x6" CROSS PER UDACS PLT. 5
 - ⑥ 6" 90° ELBOW PER UDACS PLT. 5
 - ⑦ 6" GATE VALVE PER UDACS PLTS. 3 & 8
 - ⑧ 6" TEE PER UDACS PLT. 5
 - ⑨ CAP ONLY
 - ⑩ CAP W/ 2" B.O PER UDACS PLT. 4A
 - ⑪ 8" 90° BEND PER UDACS PLT. 5
 - ⑫ 8" 45° BEND PER UDACS PLT. 5
 - ⑬ 8"-22 1/2" BEND PER UDACS PLT. 5
 - ⑭ 8"-11 1/4" BEND PER UDACS PLT. 5
 - ⑮ 8" 5" BEND RESTRAINING BOTH ENDS
 - ⑯ 6"-22 1/2" BEND PER UDACS PLT. 3
 - ⑰ 8"x6" REDUCER PER UDACS PLT. 3
 - ⑱ 1" IRRIGATION METER PER UDACS PLATE 11-D W/1" RPPA PER UDACS PLATE 11-A
 - ⑲ 3/4" WATER METER PER UDACS PLT. 1B

NOTES

1. ALL PRIVATE STREETS AND PRIVATE DRIVES ARE P.U.E., PUBLIC SEWER EASEMENTS, AND PUBLIC DRAINAGE EASEMENTS TO BE PRIVATELY MAINTAINED BY HOMEOWNERS ASSOCIATION.
2. SEE SHEET UT7 FOR S.S. MANHOLE SCHEDULE, LEGENDS, DETAILS, NOTES, AND QUANTITY ESTIMATE.

**STANLEY FREDERICK STREET
 (PRIVATE)
 (8" PIPE CONTINUATION THROUGH UNIT 2)**

PROFILE SCALES:
 HORIZ. = 1"=30'
 VERT. = 1"=3'

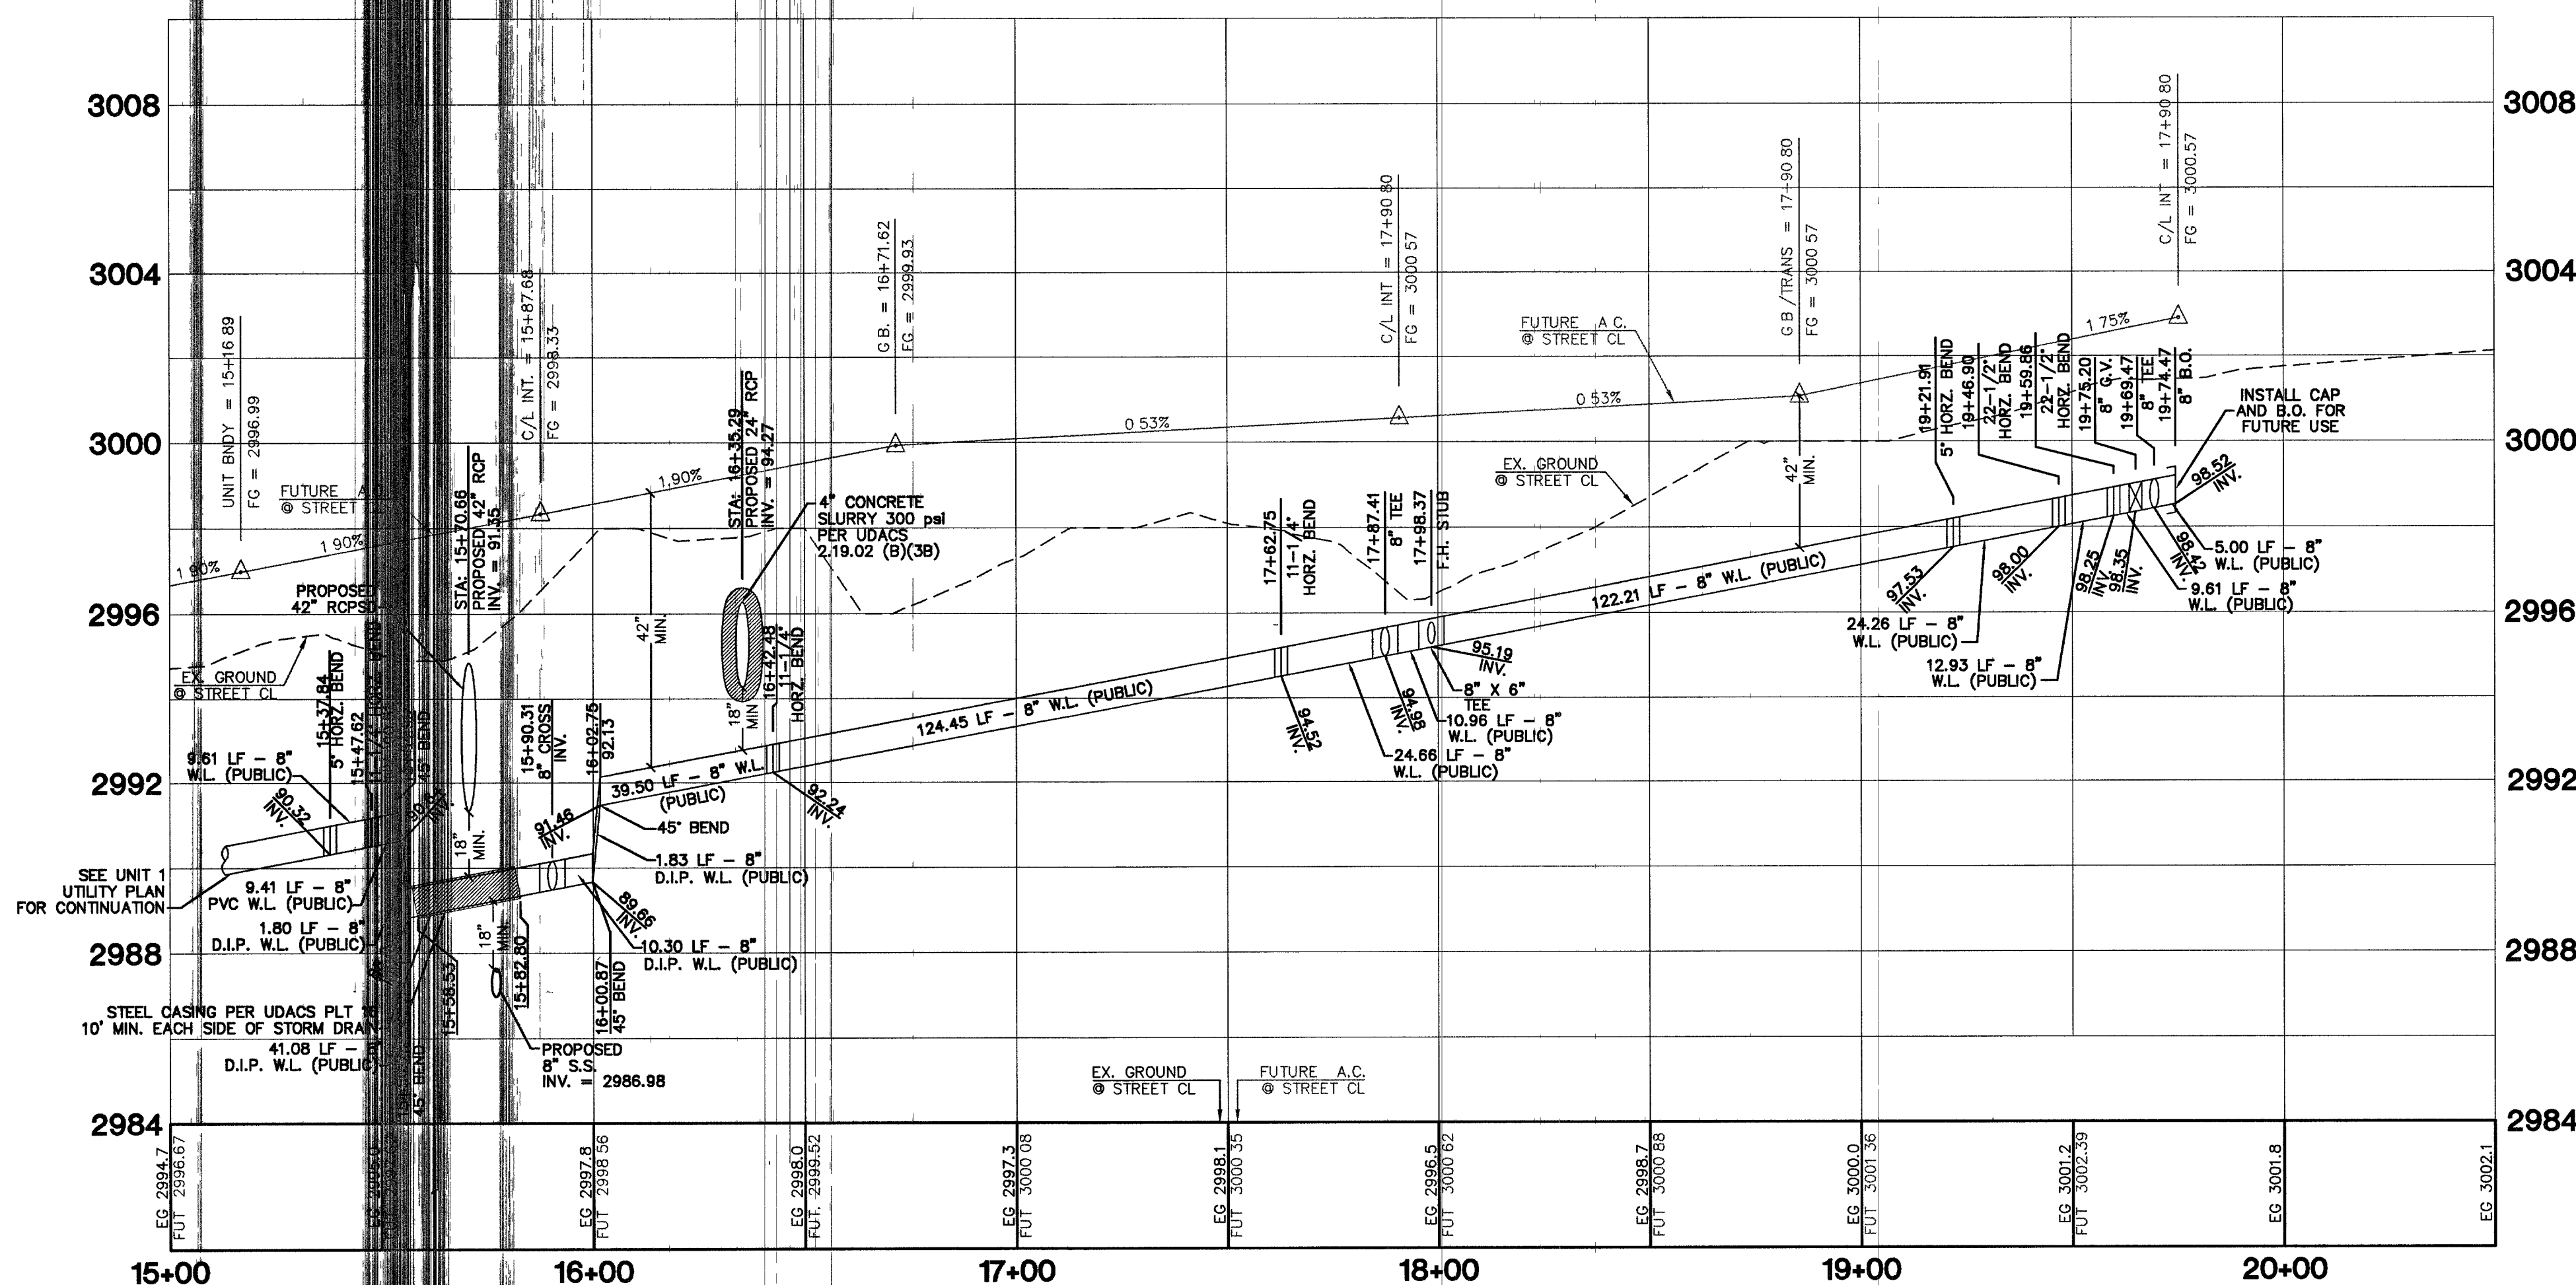

APPROVAL: *[Signature]*
 City of Las Vegas Fire Marshal
 10/5/09

PROFESSIONAL ENGINEER STATE OF NEVADA
 No. 13956
 EXPIRES 06-30-07
 10/5/09

LAS VEGAS VALLEY WATER DISTRICT (PROJECT #111525) DATE

UT6
 9 OF 52 SHEETS
 DRAWING NO. 10744888-1

KIMBALL HILL
 8 SUNSET WAY, SUITE 101
 HENDERSON, NEVADA 89014
 (702) 435-4582

UTILITY PLAN AND PROFILE
STANLEY FREDERICK STREET

WINDMERE •
PROVIDENCE / CLIFFS EDGE
POD 211 - UNIT 1

CITY OF LAS VEGAS
 2727 SOUTH RAINBOW BOULEVARD LAS VEGAS, NEVADA 89146-5148
 PH. (702) 873-7550 FAX (702) 362-2597

REVISION

REV	DATE	BY
1		
2		
3		
4		
5		
6		
7		