

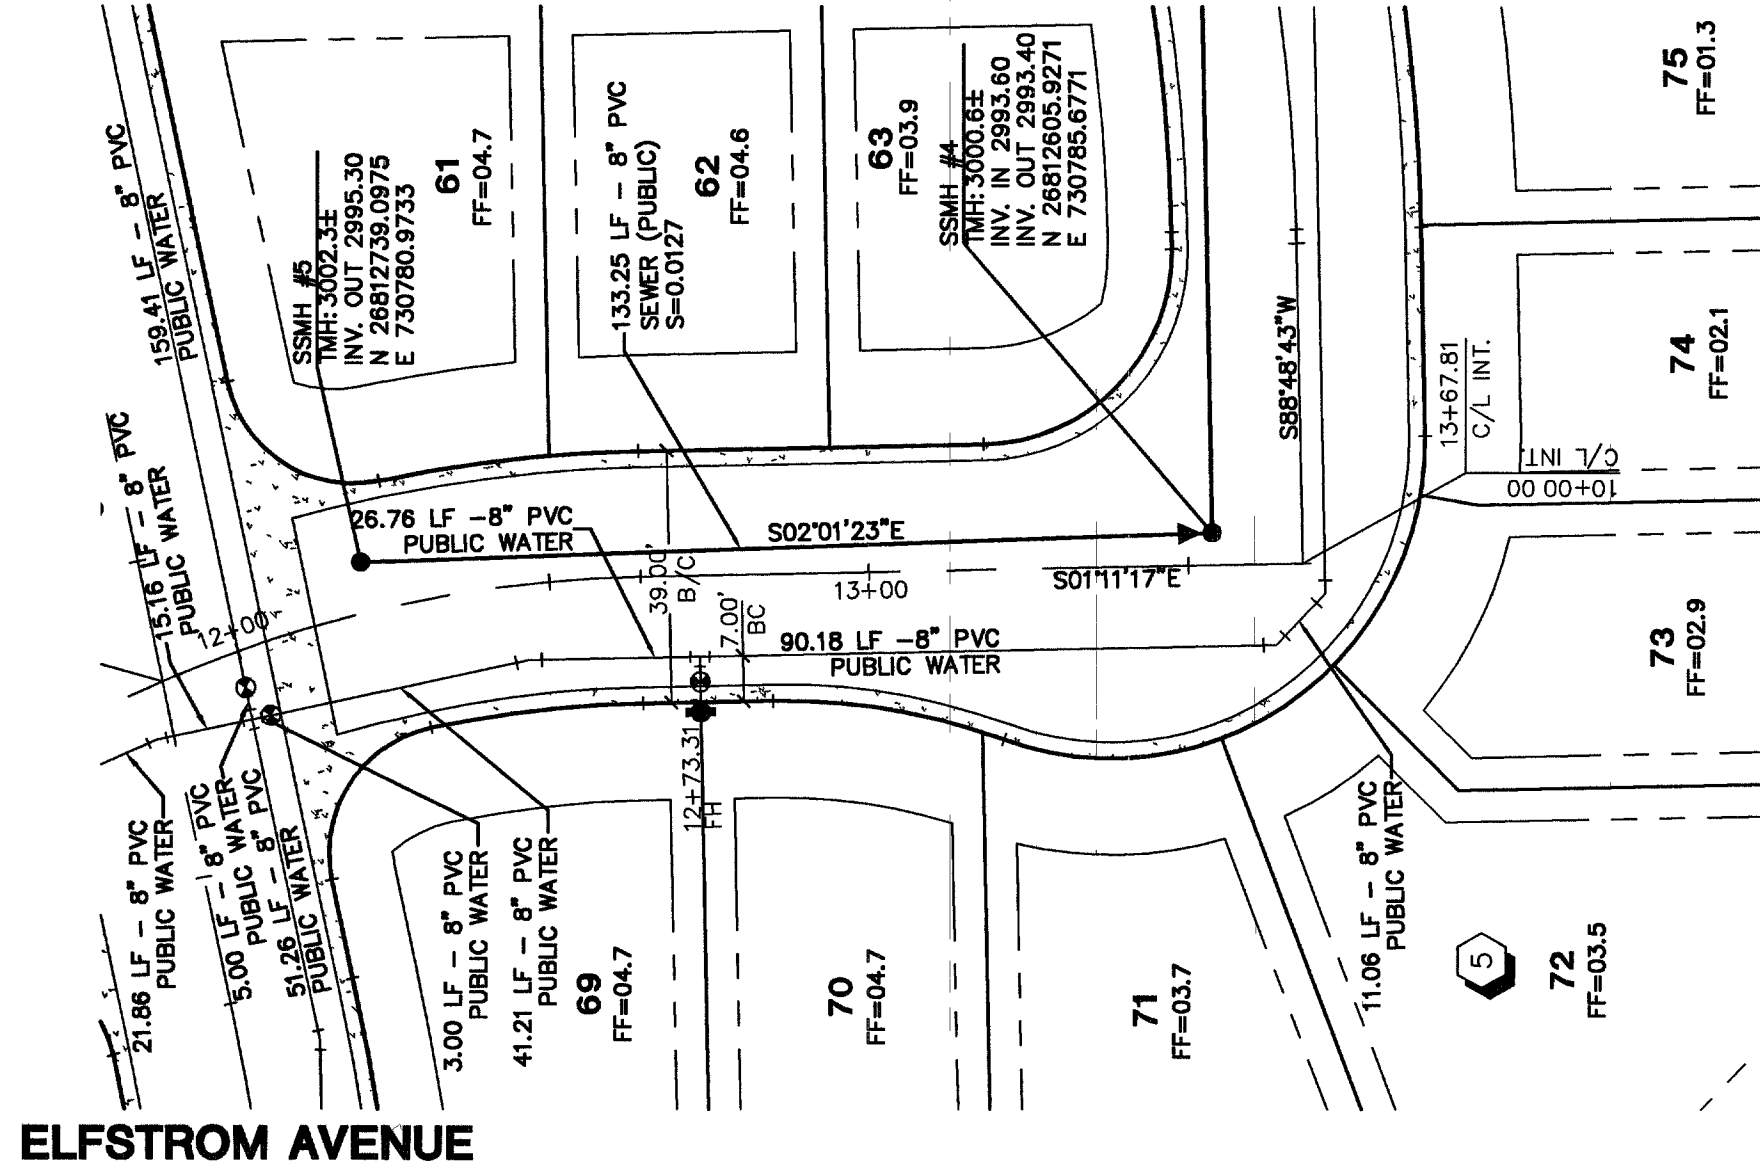
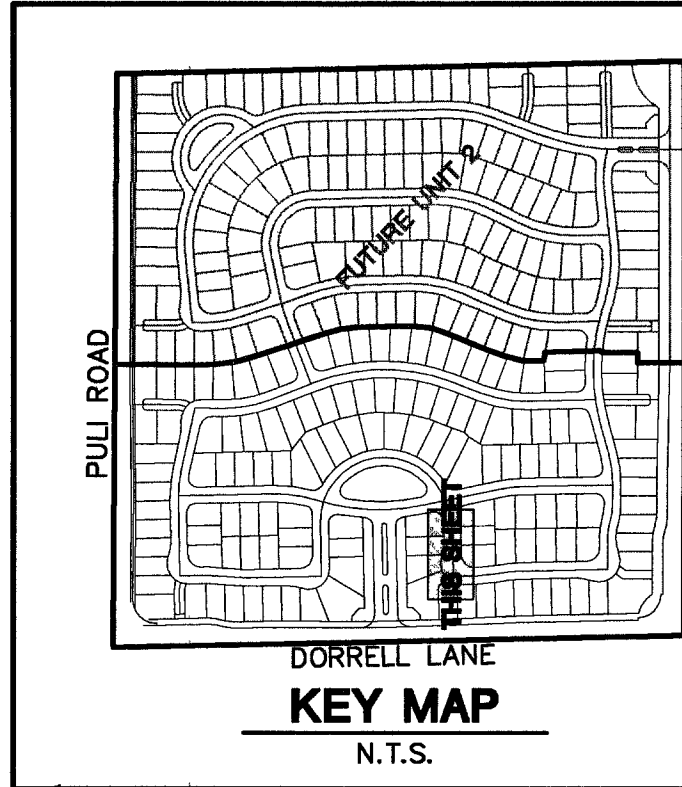


ELFSTROM AVENUE
AND CONTINUATION SEE SHEET SS4


YORK MANOR AVENUE
AND CONTINUATION SEE SHEET SS6

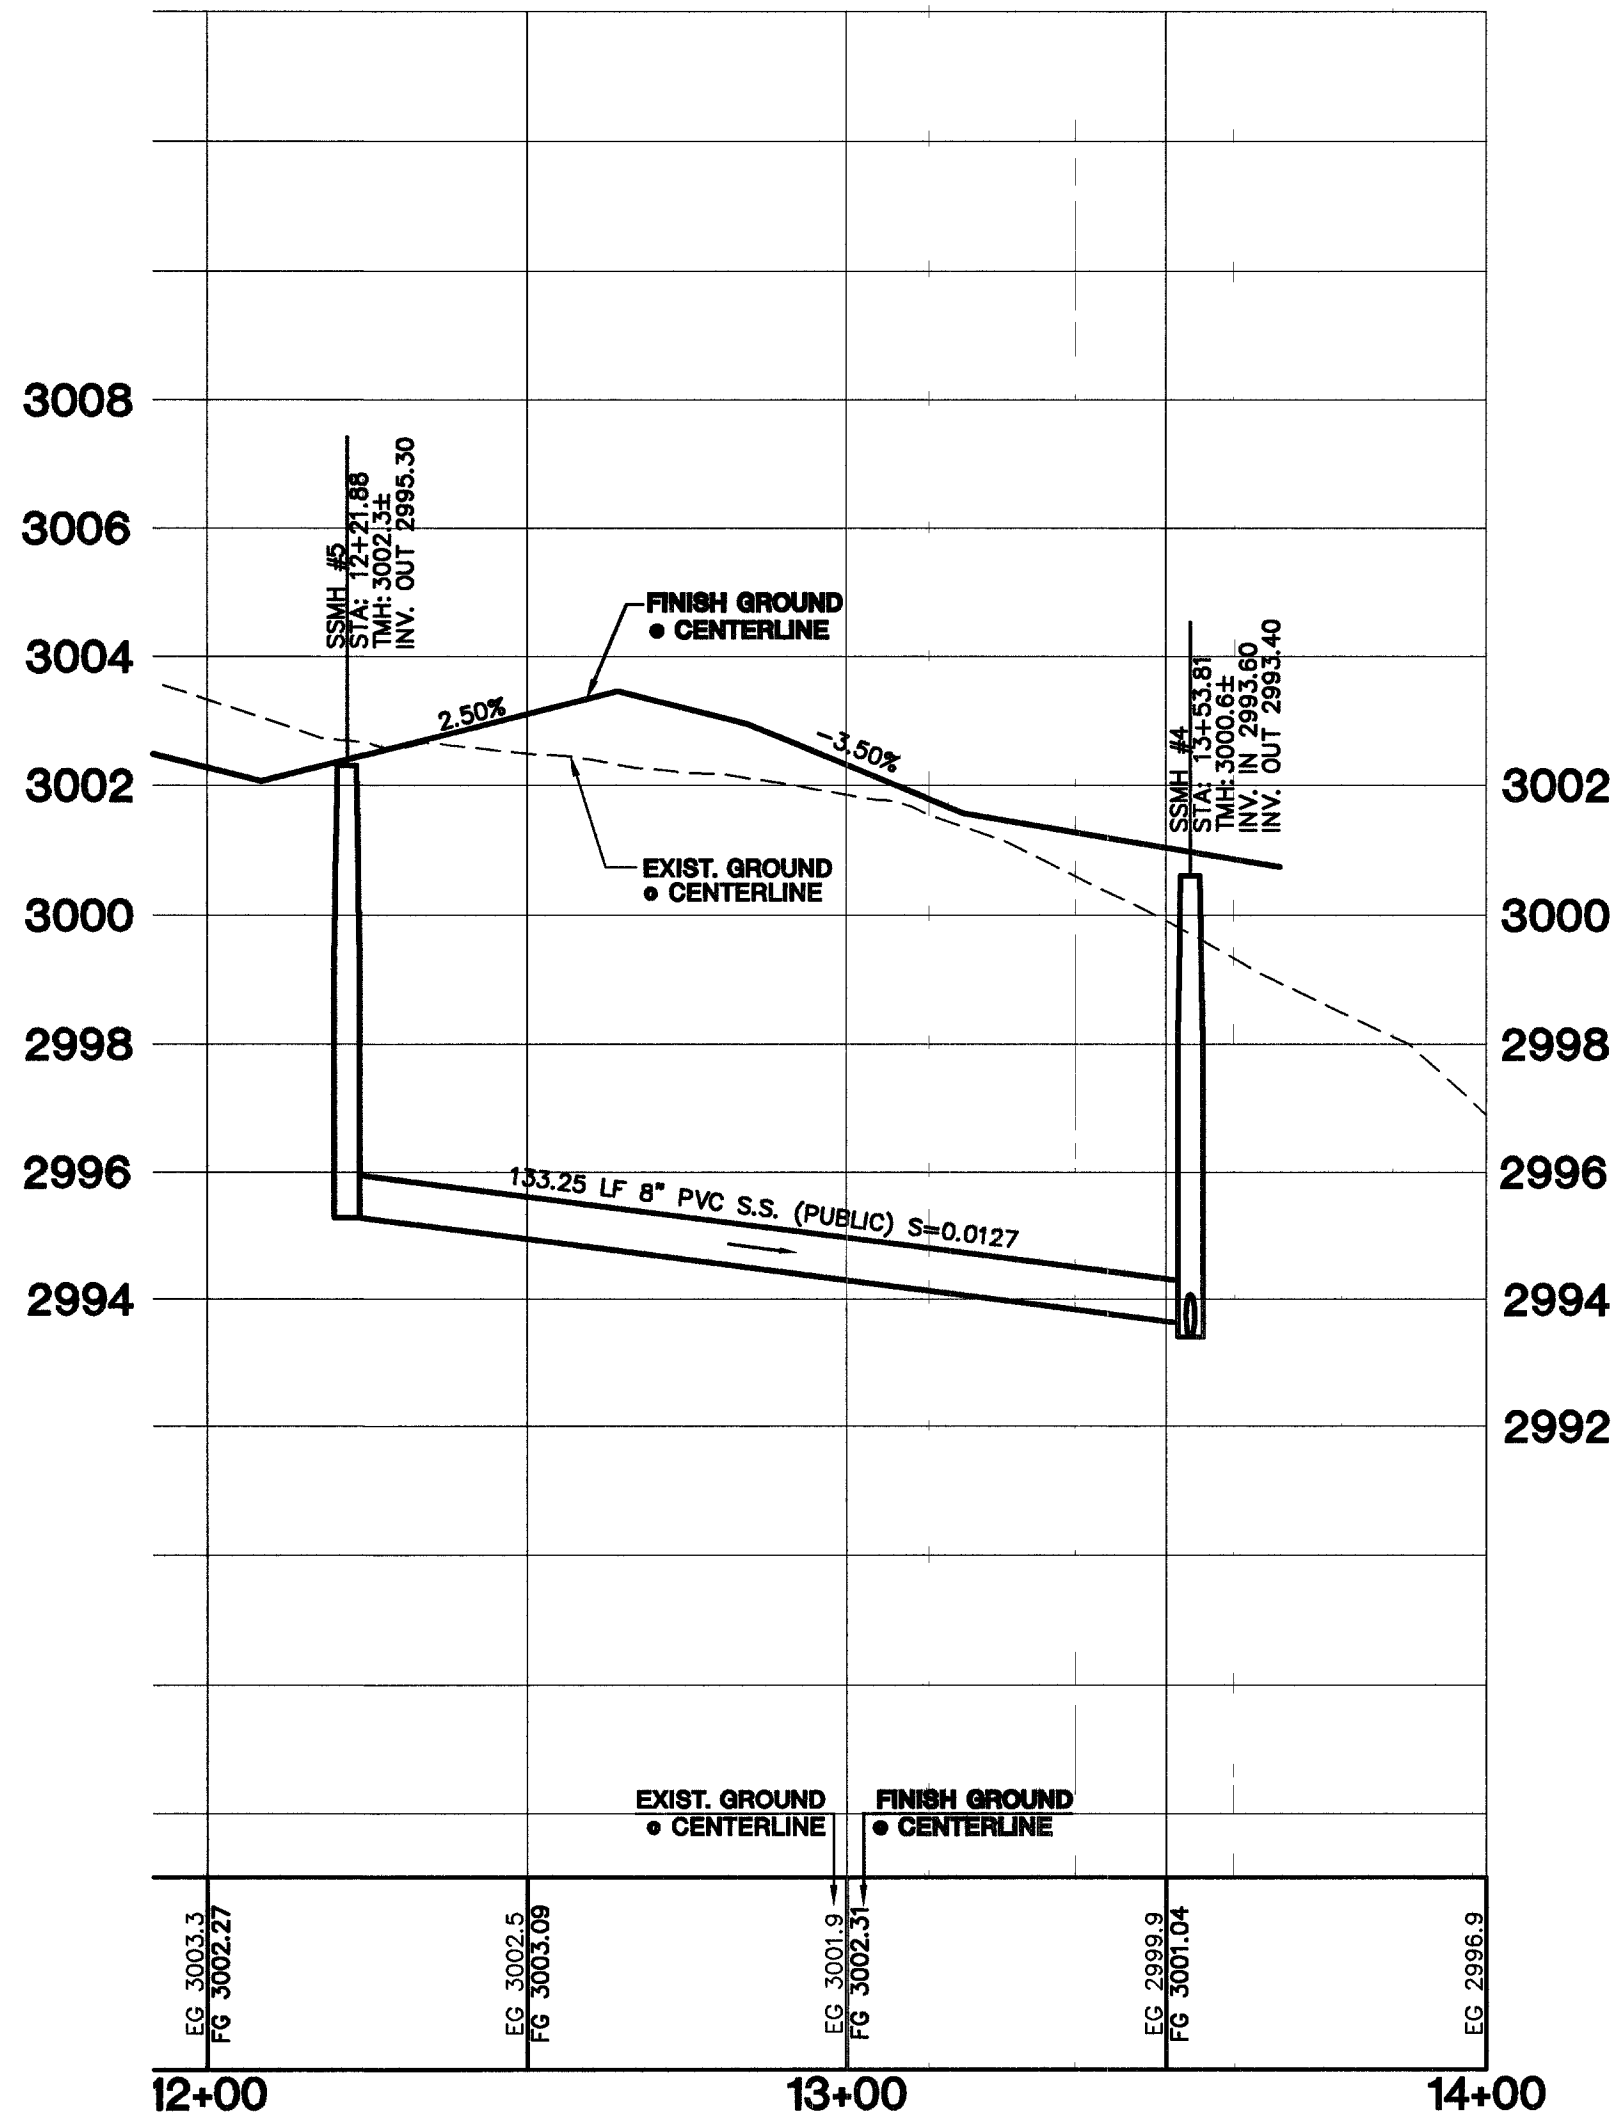

DELTA FALLS STREET
(PRIVATE)

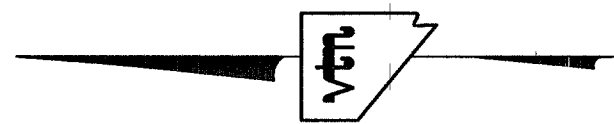

GRAPHIC SCALE

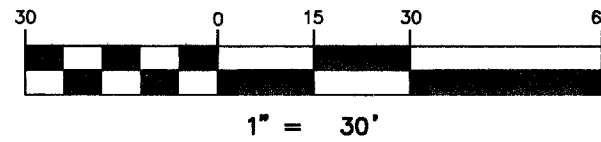

PROFILE SCALES:

HORZ. = 1"=30'

VERT. = 1"=3'

PROJECT BENCHMARK

DATUM: NORTH AMERICAN VERTICAL DATUM OF 1988 (NAVD88)

CITY OF LAS VEGAS BENCHMARK: BLV99:13SES

NAVD88 ELEVATION: 869.606 METERS (2853.03 FEET)

RIVET AND PLATE IN CONCRETE CYLINDER NW CORNER OF HUALAPAI AND ELKHORN

NOTE: WHEN THE SURVEYING FOR THIS PROJECT BEGAN, THE ABOVE REFERENCED BENCHMARK BLV99:13SES WAS NOT PUBLISHED. THE BASIS FOR THE DATUM FOR THIS PROJECT IS SHOWN ON RECORD OF SURVEY FILE 124 PAGE 94, CLARK COUNTY BENCHMARK 1C00-846, WHICH AT THE TIME OF THE ORIGINAL SURVEY (PRIOR TO THE CURRENT 2003 COUNTY BENCHMARK PUBLISHING) HAD AN ELEVATION OF 2584.81 FEET. TO CONVERT THE CURRENT CITY OF LAS VEGAS BENCHMARK BLV99:13SES TO MATCH THE ORIGINAL PROJECT DATUM, 0.34' NEEDS TO BE ADDED TO THE ELEVATION OF 2853.03 FEET.

BASIS OF BEARINGS

THE BASIS OF BEARINGS FOR THIS PROJECT IS NORTH 00°03'18" EAST BEING THE EAST LINE OF THE NORTHWEST QUARTER (NE 1/4) OF THE SECTION 24, TOWNSHIP 19 SOUTH, RANGE 59 EAST, M.D.M., CLARK COUNTY, NEVADA, AS SHOWN ON A RECORD OF SURVEY ON FILE IN THE CLARK COUNTY, NEVADA, RECORDER'S OFFICE IN FILE 123 AT PAGE 32.

NOTE

ALL DRAINAGE EASEMENTS MUST BE COMMON LOTS & PUBLIC DRAINAGE EASEMENTS TO BE PRIVATELY MAINTAINED BY H.O.A.

NOTES

1. ALL PRIVATE STREETS AND PRIVATE DRIVES ARE P.U.E., PUBLIC SEWER EASEMENT, & PUBLIC DRAINAGE EASEMENT TO BE PRIVATELY MAINTAINED BY H.O.A.
2. SEE SHEET U17 FOR S.S. MANHOLE SCHEDULE

CONTRACTOR NOTE

CONTRACTOR SHALL VERIFY HORIZONTAL AND VERTICAL LOCATION OF EXISTING UTILITIES AND NOTIFY THE DESIGN ENGINEER IMMEDIATELY OF ANY DISCREPANCIES PRIOR TO CONSTRUCTION.

Avoid overhead power line contact. It's costly.

Call before you Overhead

1-702-227-2929

Avoid cutting underground utility lines. It's costly.

Call before you Dig

1-800-227-2600

AVOID HITTING UNDERGROUND TRAFFIC SIGNAL SYSTEMS AND STREET LIGHT SYSTEM CONDUITS. IT'S COSTLY CALL BEFORE YOU DO UNDERGROUND

Call before you Underground
1-702-455-7511
CLARK COUNTY TRAFFIC OPERATIONS AND
1-702-229-6611
LAS VEGAS AREA COMPUTERIZED TRAFFIC SYSTEM

KIMBALL HILL
8 SUNSET WAY, SUITE 101
HENDERSON, NEVADA 89014
(702) 438-4582

SEWER PLAN AND PROFILE
DELTA FALLS STREET

DRAWN BY: TP 10/05
DESIGNED BY: TP 10/05
CHECKED BY: CRG 10/05
PROJECT NO: 8400-1



EXPIRES 06-30-07
SHEET SS10
45 OF 52 SHEETS
DRAWING NO. 10744888-1

CITY OF LAS VEGAS

2727 SOUTH RAINBOW BOULEVARD LAS VEGAS, NEVADA 89146-5148
PH: (702) 873-7550 FAX (702) 362-2597

CONSULTING ENGINEERS

WINDMERE
PROVIDENCE / CLIFFS EDGE
POD 211 - UNIT 1

SCALE: 1"=30' HORZ.
1"=3' VERT.



EXPIRES 06-30-07
SHEET SS10
45 OF 52 SHEETS
DRAWING NO. 10744888-1